

EL RAYO - FREE STREET
 PORTLAND, MAINE
 RENOVATION




CONSULTANTS:

REVISIONS:

ISSUED: 01/15/16
 PROJECT No: 1523
 DRAWN BY: RIP
 CHECKED BY: RIP
 SHEET TITLE:
 ENLARGED BATHROOM PLAN
 & DETAILS


A401

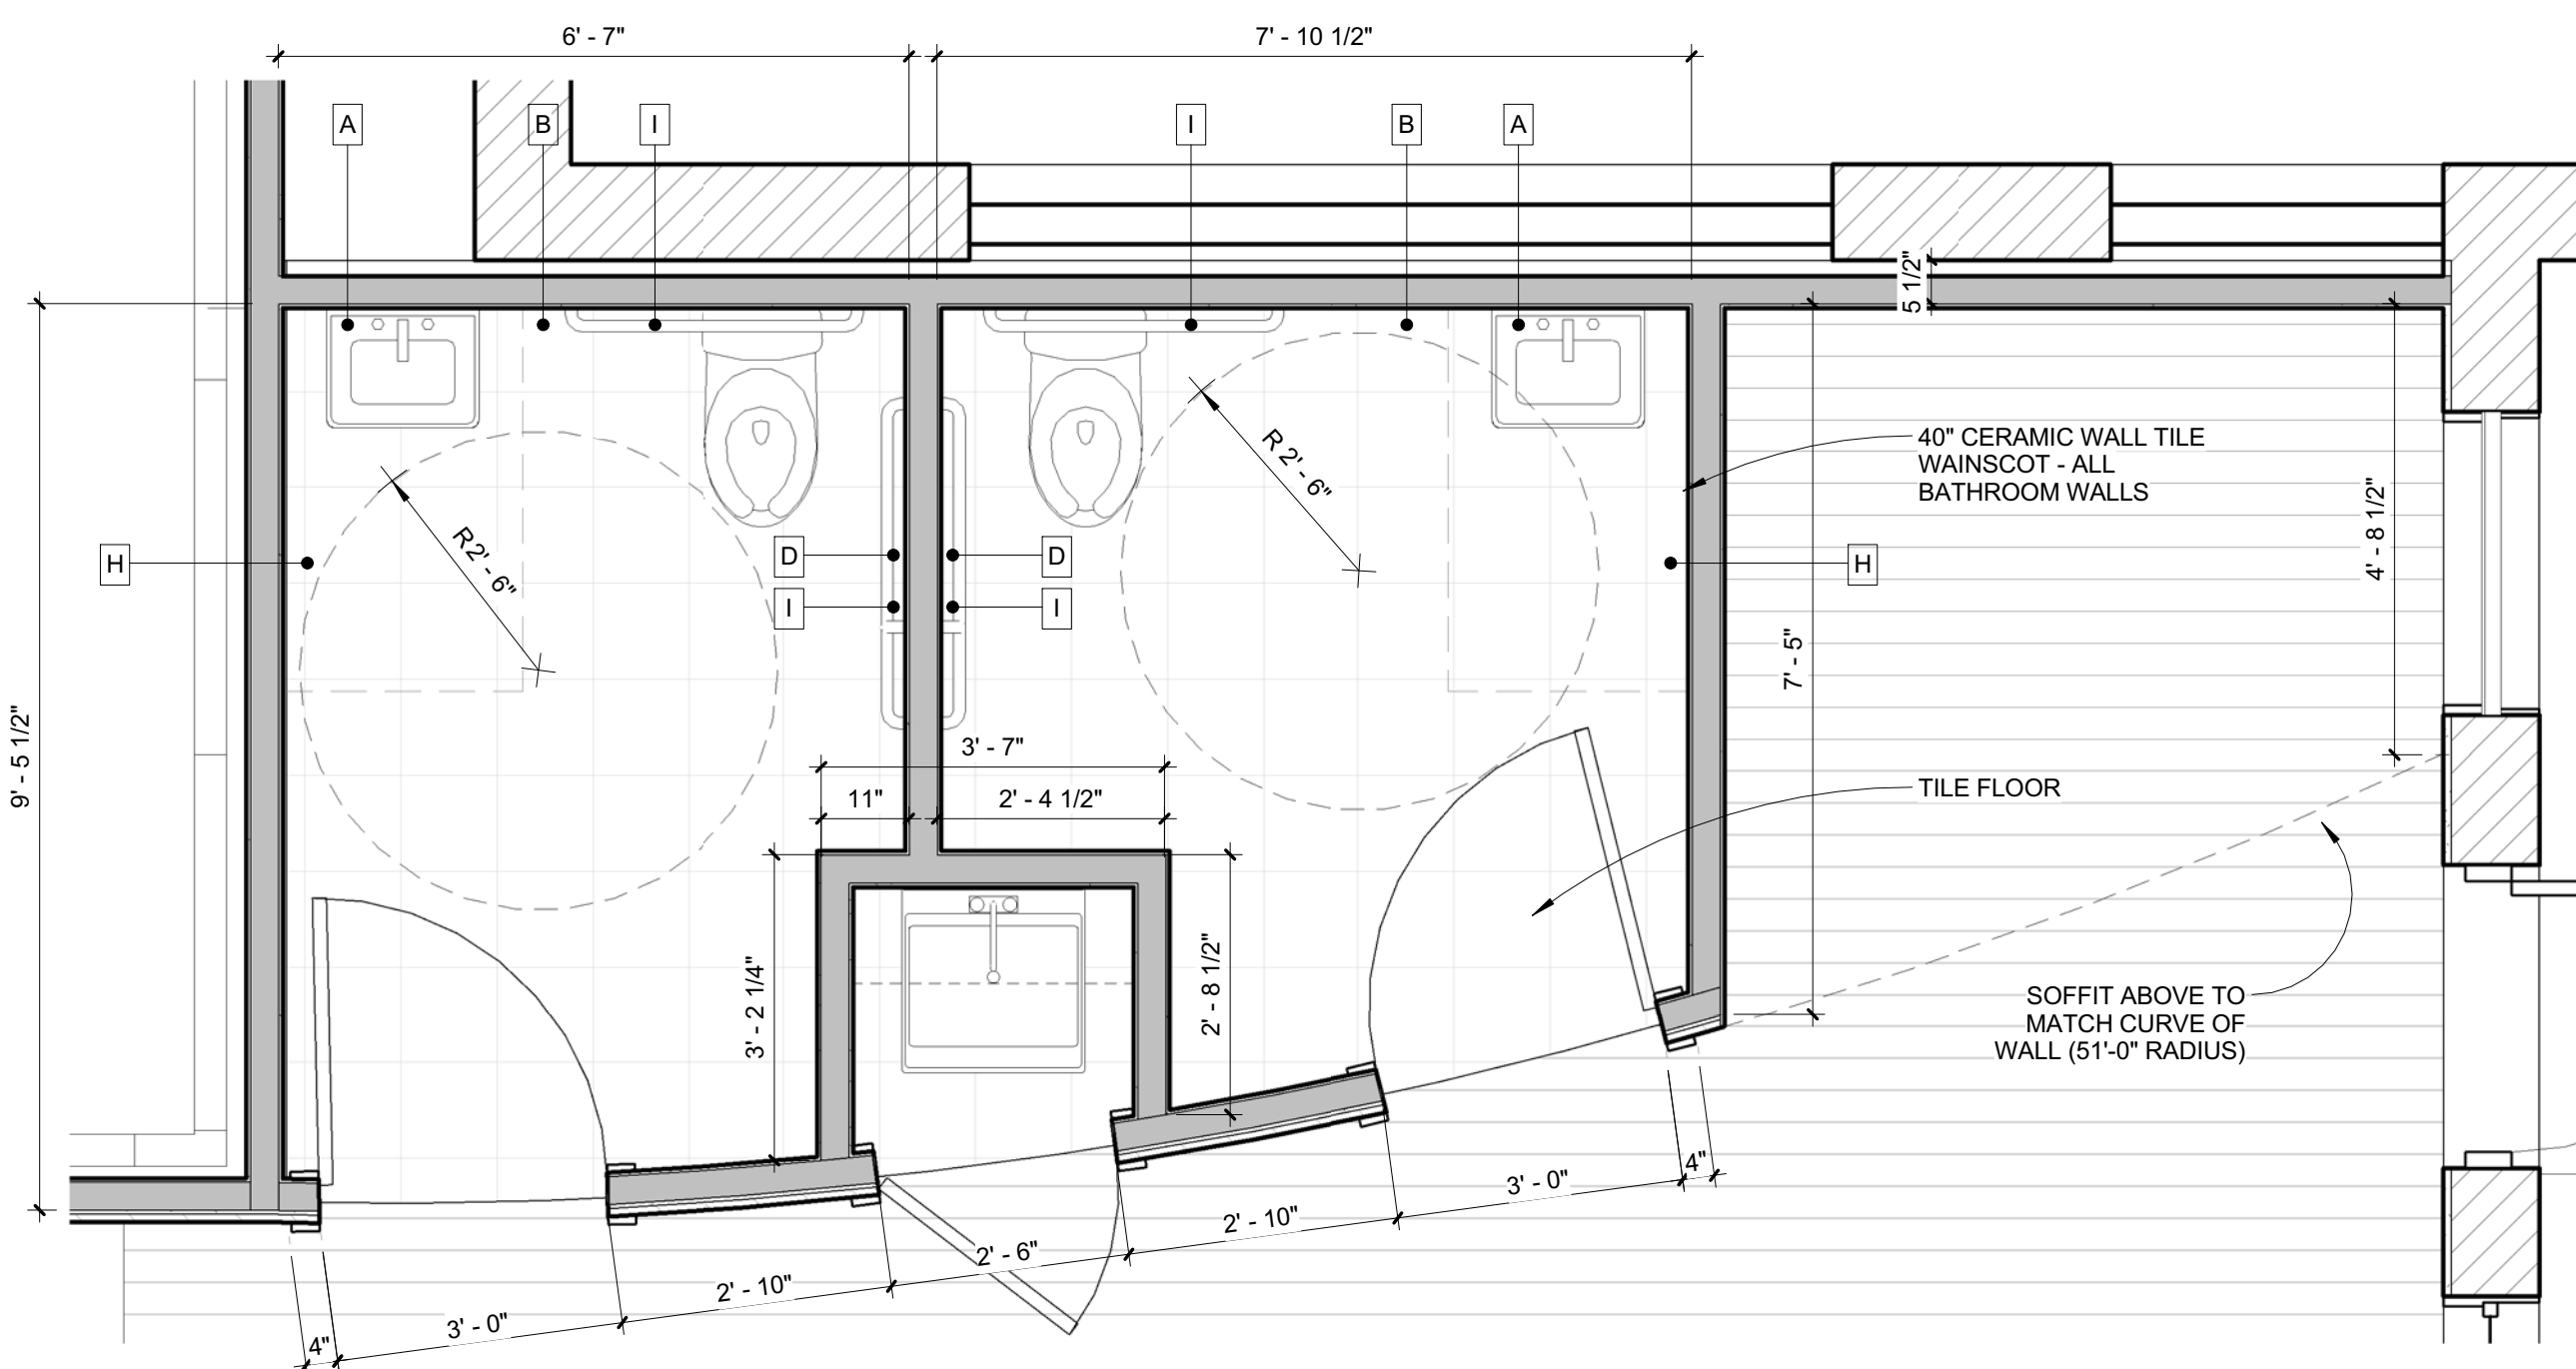


BATHROOM ACCESSORY LEGEND

- A MIRROR
- B SOAP DISPENSER
- C PAPER TOWEL DISPENSER
- D TOILET PAPER DISPENSER
- E TOILET PAPER HOLDER
- F SANITARY NAPKIN DISPOSAL
- G SANITARY NAPKIN DISPENSER
- H HAND DRYER
- I GRAB BARS

1 ENLARGED BATHROOM PLAN
 1/2" = 1'-0"

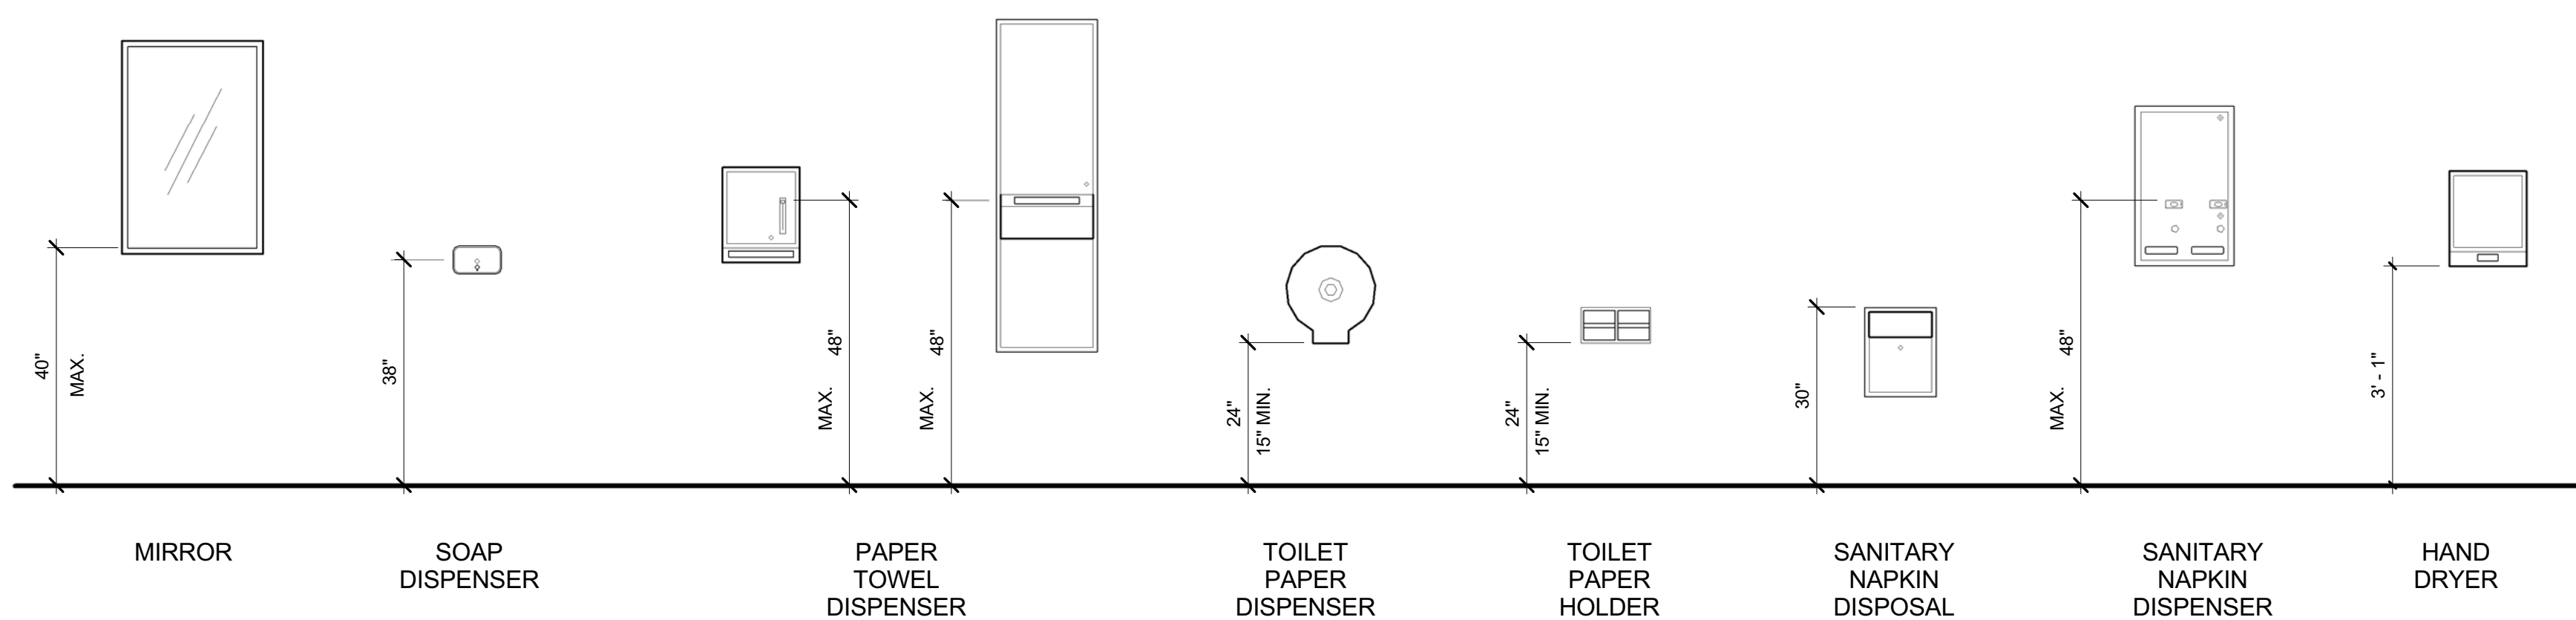

TYPICAL TOILET ACCESSORIES MOUNTING HEIGHTS

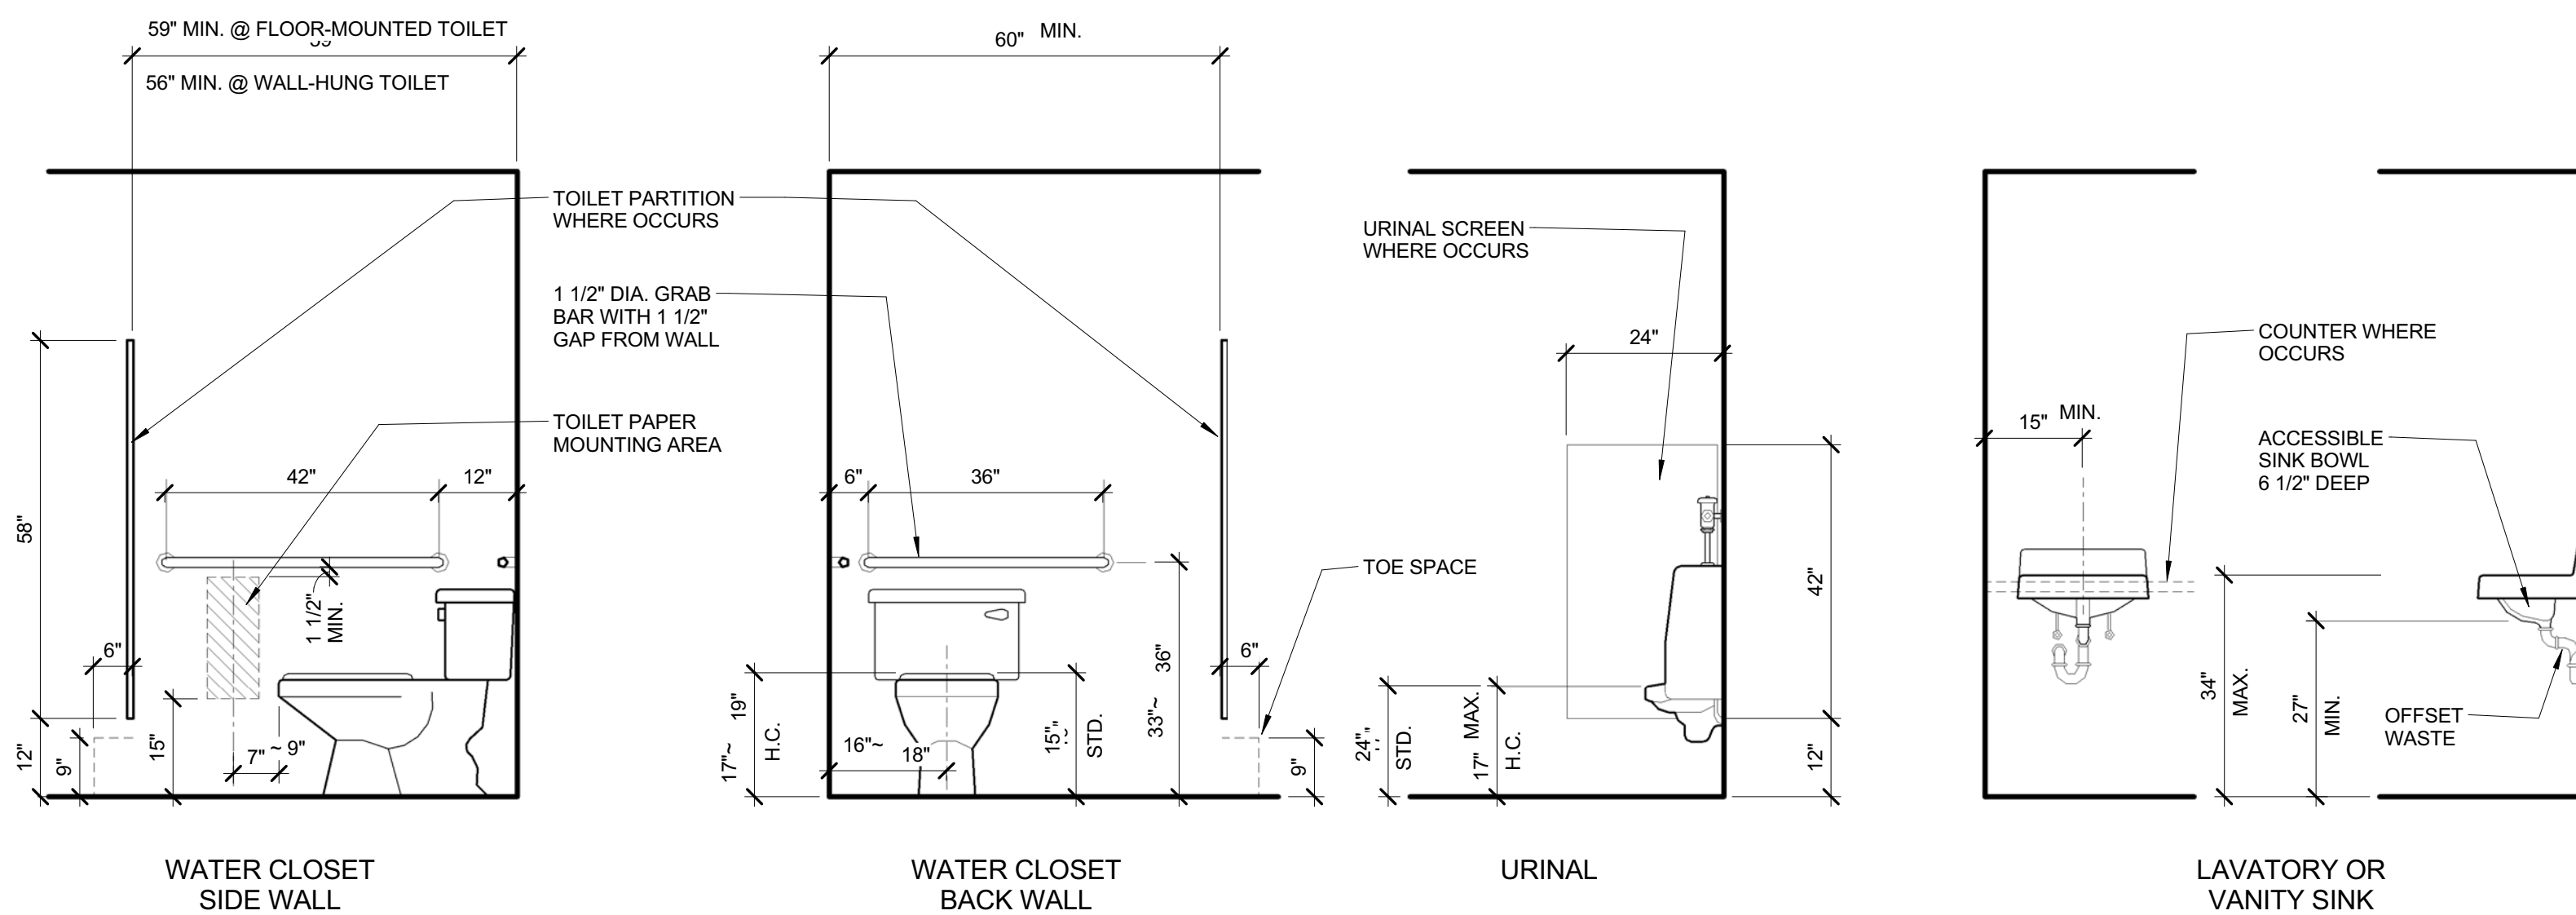

TYPICAL PLUMBING FIXTURES AND ACCESSORIES MOUNTING HEIGHTS