
















FIRE ALARM LEGEND

-  FIRE ALARM CONTROL PANEL
-  FIRE ALARM ANNUNCIATOR
-  SMOKE DETECTOR, R INDICATES ELEVATOR RECALL DEVICE
-  HEAT DETECTOR, R INDICATES ELEVATOR RECALL DEVICE
-  CARBON MONOXIDE DETECTOR
-  PULL STATION
-  HORN STROBE, NUMBER INDICATES STROBE CANDELA VALUE
-  STROBE ONLY, NUMBER INDICATES STROBE CANDELA VALUE
-  LOW FREQUENCY SOUNDER STROBE, NUMBER INDICATES STROBE CANDELA VALUE
-  LOW FREQUENCY SOUNDER
-  MINI HORN
-  STROBE ONLY, SS INDICATES SINGLE STATION
-  SMOKE DETECTOR, SS INDICATES SINGLE STATION
-  SMOKE/CO COMBINATION, SS INDICATES SINGLE STATION
-  SMOKE/STROBE COMBINATION, SS INDICATES SINGLE STATION

Drawn By: JAB
 Checked By: MP
 Installation Contractor: BH Milliken

Mixed Use Building 40 Free Street



| No. | Revision/Issue | Date |
|-----|----------------|------|
| | | |
















Firm Name and Address
 Norris Inc.
 2257 West Broadway
 South Portland Me.
 04106
 1-800-370-3473


Project Name and Address
**Mixed Use Building
 Basement
 Fire Alarm Plan
 40 Free Street
 Portland, Maine**

| | | | |
|---------|-----------|-------|-------------|
| Project | 1376 | Sheet | FP-B |
| Date | 11/6/2019 | | |
| Scale | 1/8" = 1' | | |


 Reviewed for Code Compliance
 Permitting and Inspections Department
 Approved with Conditions
 12/17/2019

FIRE ALARM LEGEND

-  FIRE ALARM CONTROL PANEL
-  FIRE ALARM ANNUNCIATOR
-  SMOKE DETECTOR, R INDICATES ELEVATOR RECALL DEVICE
-  HEAT DETECTOR, R INDICATES ELEVATOR RECALL DEVICE
-  CARBON MONOXIDE DETECTOR
-  PULL STATION
-  HORN STROBE, NUMBER INDICATES STROBE CANDELA VALUE
-  STROBE ONLY, NUMBER INDICATES STROBE CANDELA VALUE
-  LOW FREQUENCY SOUNDER STROBE, NUMBER INDICATES STROBE CANDELA VALUE
-  LOW FREQUENCY SOUNDER
-  MINI HORN
-  STROBE ONLY, SS INDICATES SINGLE STATION
-  SMOKE DETECTOR, SS INDICATES SINGLE STATION
-  SMOKE/CO COMBINATION, SS INDICATES SINGLE STATION
-  SMOKE/STROBE COMBINATION, SS INDICATES SINGLE STATION

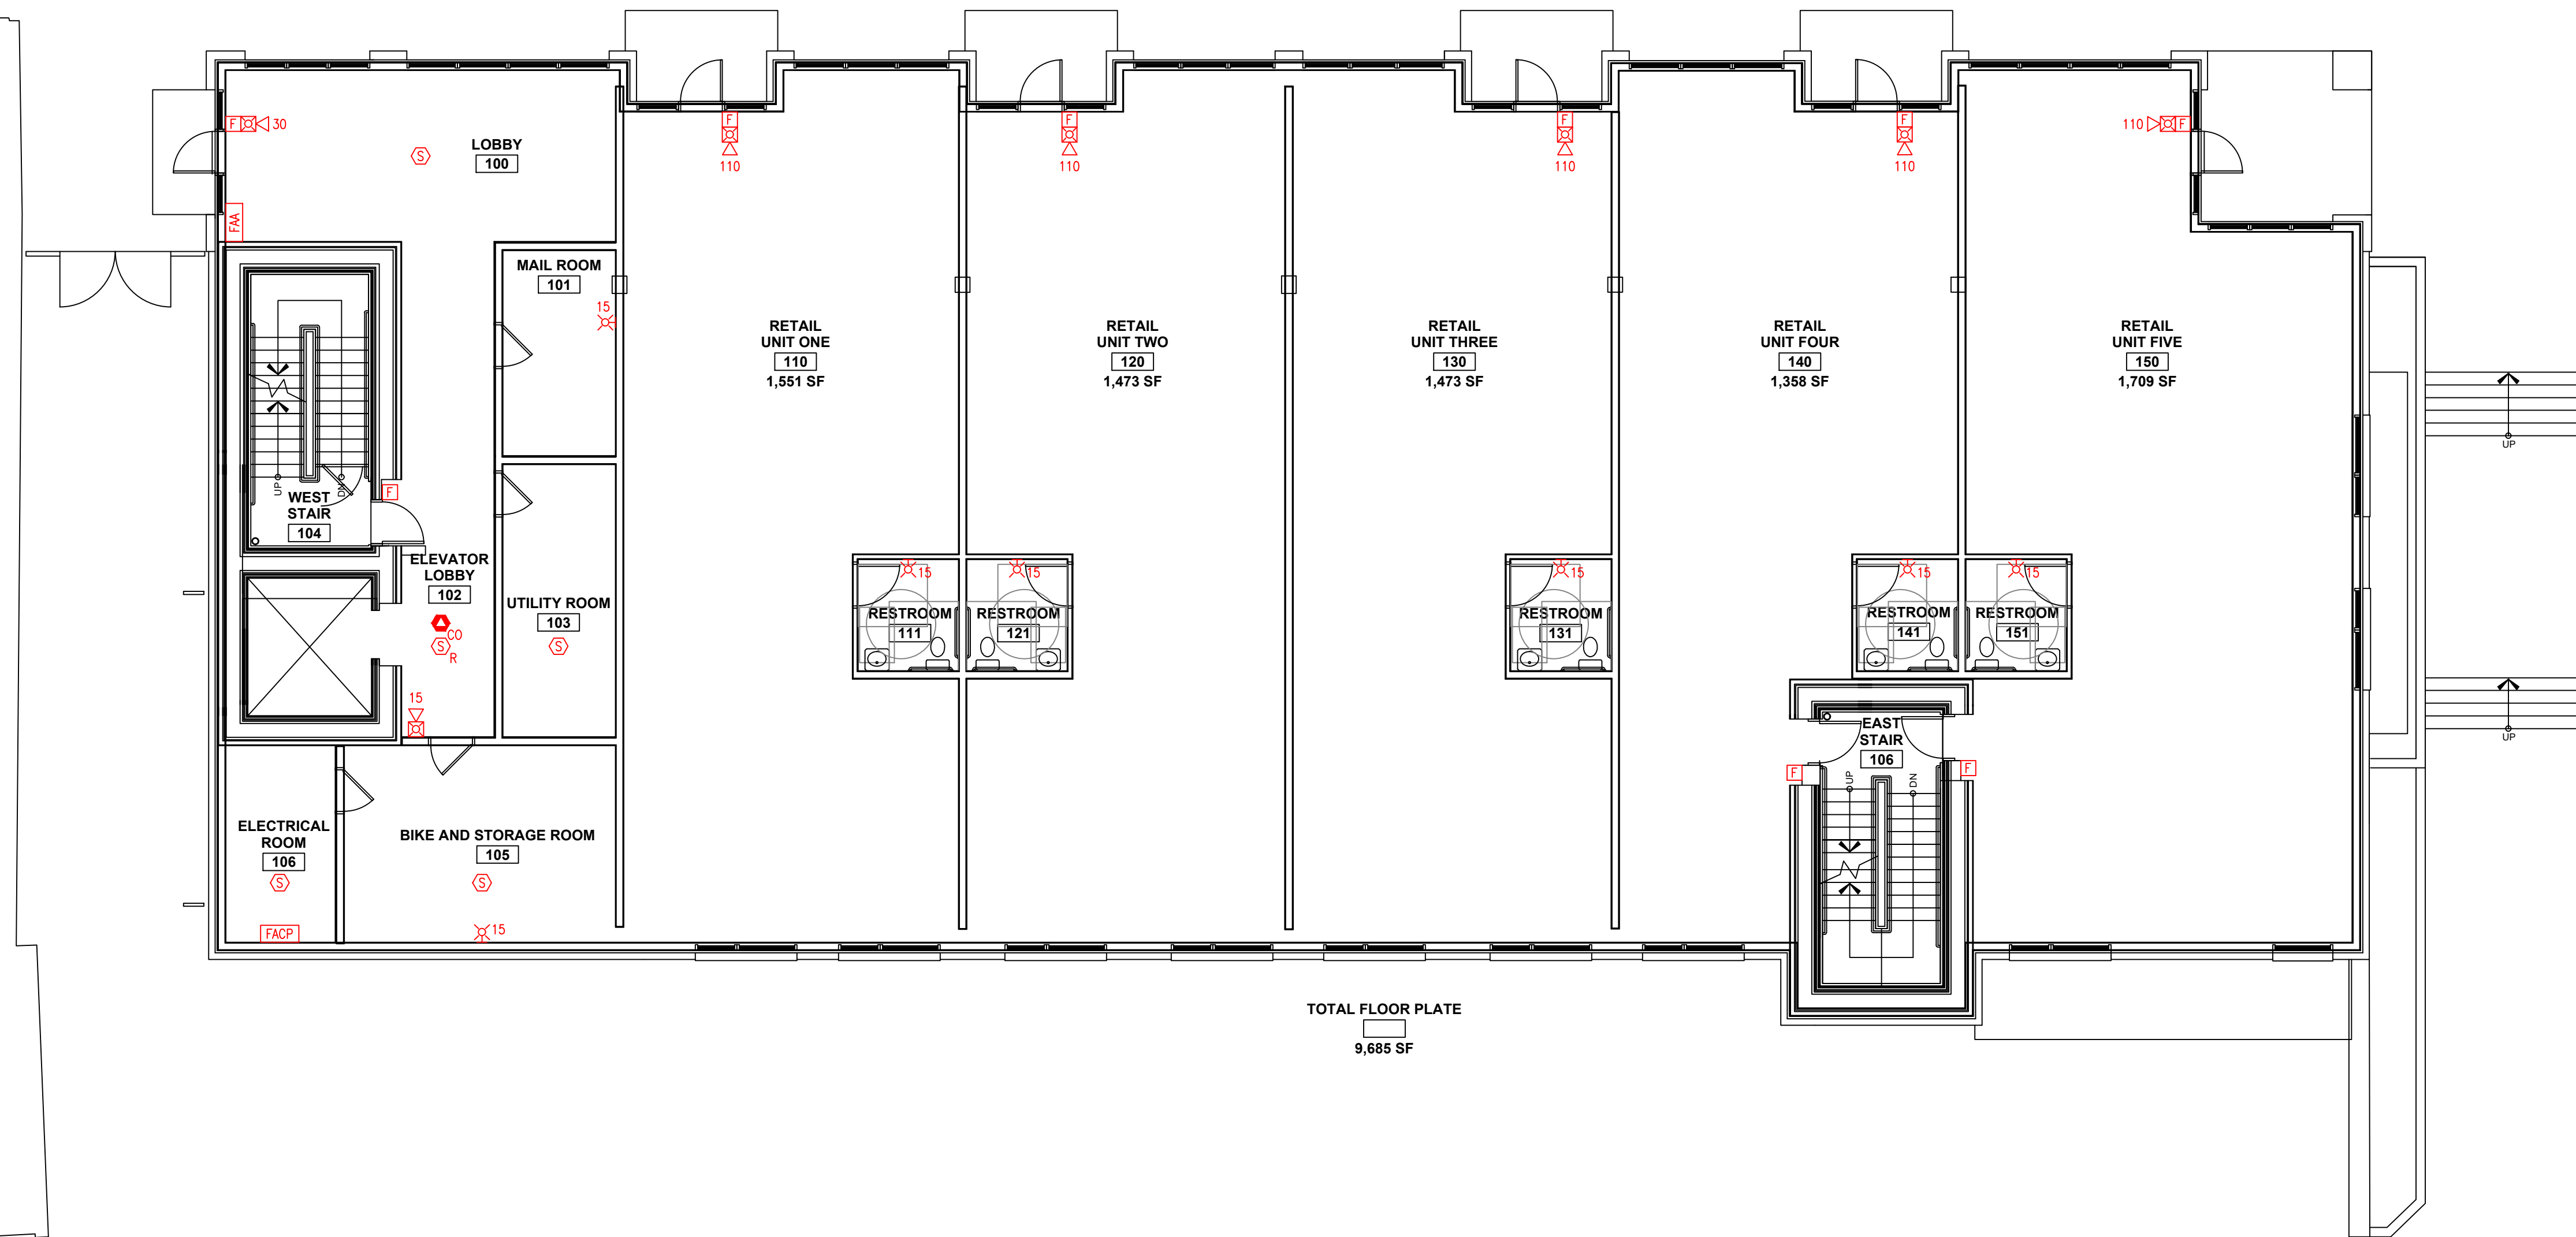

TOTAL FLOOR PLATE
9,685 SF

Drawn By: JAB
Checked By: MP
Installation Contractor: BH Milliken

Mixed Use Building 40 Free Street



| No. | Revision/Issue | Date |
|-----|----------------|------|
| | | |
















Firm Name and Address
Norris Inc.
2257 West Broadway
South Portland Me.
04106
1-800-370-3473


Project Name and Address
**Mixed Use Building
First Floor
Fire Alarm Plan
40 Free Street
Portland, Maine**

| | | | |
|---------|-----------|-------|-------------|
| Project | 1376 | Sheet | FP-1 |
| Date | 11/6/2019 | | |
| Scale | 1/8" = 1' | | |


Reviewed for Code Compliance
Permitting and Inspections Department
Approved with Conditions
12/17/2019

FIRE ALARM LEGEND

-  FIRE ALARM CONTROL PANEL
-  FIRE ALARM ANNUNCIATOR
-  SMOKE DETECTOR, R INDICATES ELEVATOR RECALL DEVICE
-  HEAT DETECTOR, R INDICATES ELEVATOR RECALL DEVICE
-  CARBON MONOXIDE DETECTOR
-  PULL STATION
-  HORN STROBE, NUMBER INDICATES STROBE CANDELA VALUE
-  STROBE ONLY, NUMBER INDICATES STROBE CANDELA VALUE
-  LOW FREQUENCY SOUNDER STROBE, NUMBER INDICATES STROBE CANDELA VALUE
-  LOW FREQUENCY SOUNDER
-  MINI HORN
-  STROBE ONLY, SS INDICATES SINGLE STATION
-  SMOKE DETECTOR, SS INDICATES SINGLE STATION
-  SMOKE/CO COMBINATION, SS INDICATES SINGLE STATION
-  SMOKE/STROBE COMBINATION, SS INDICATES SINGLE STATION

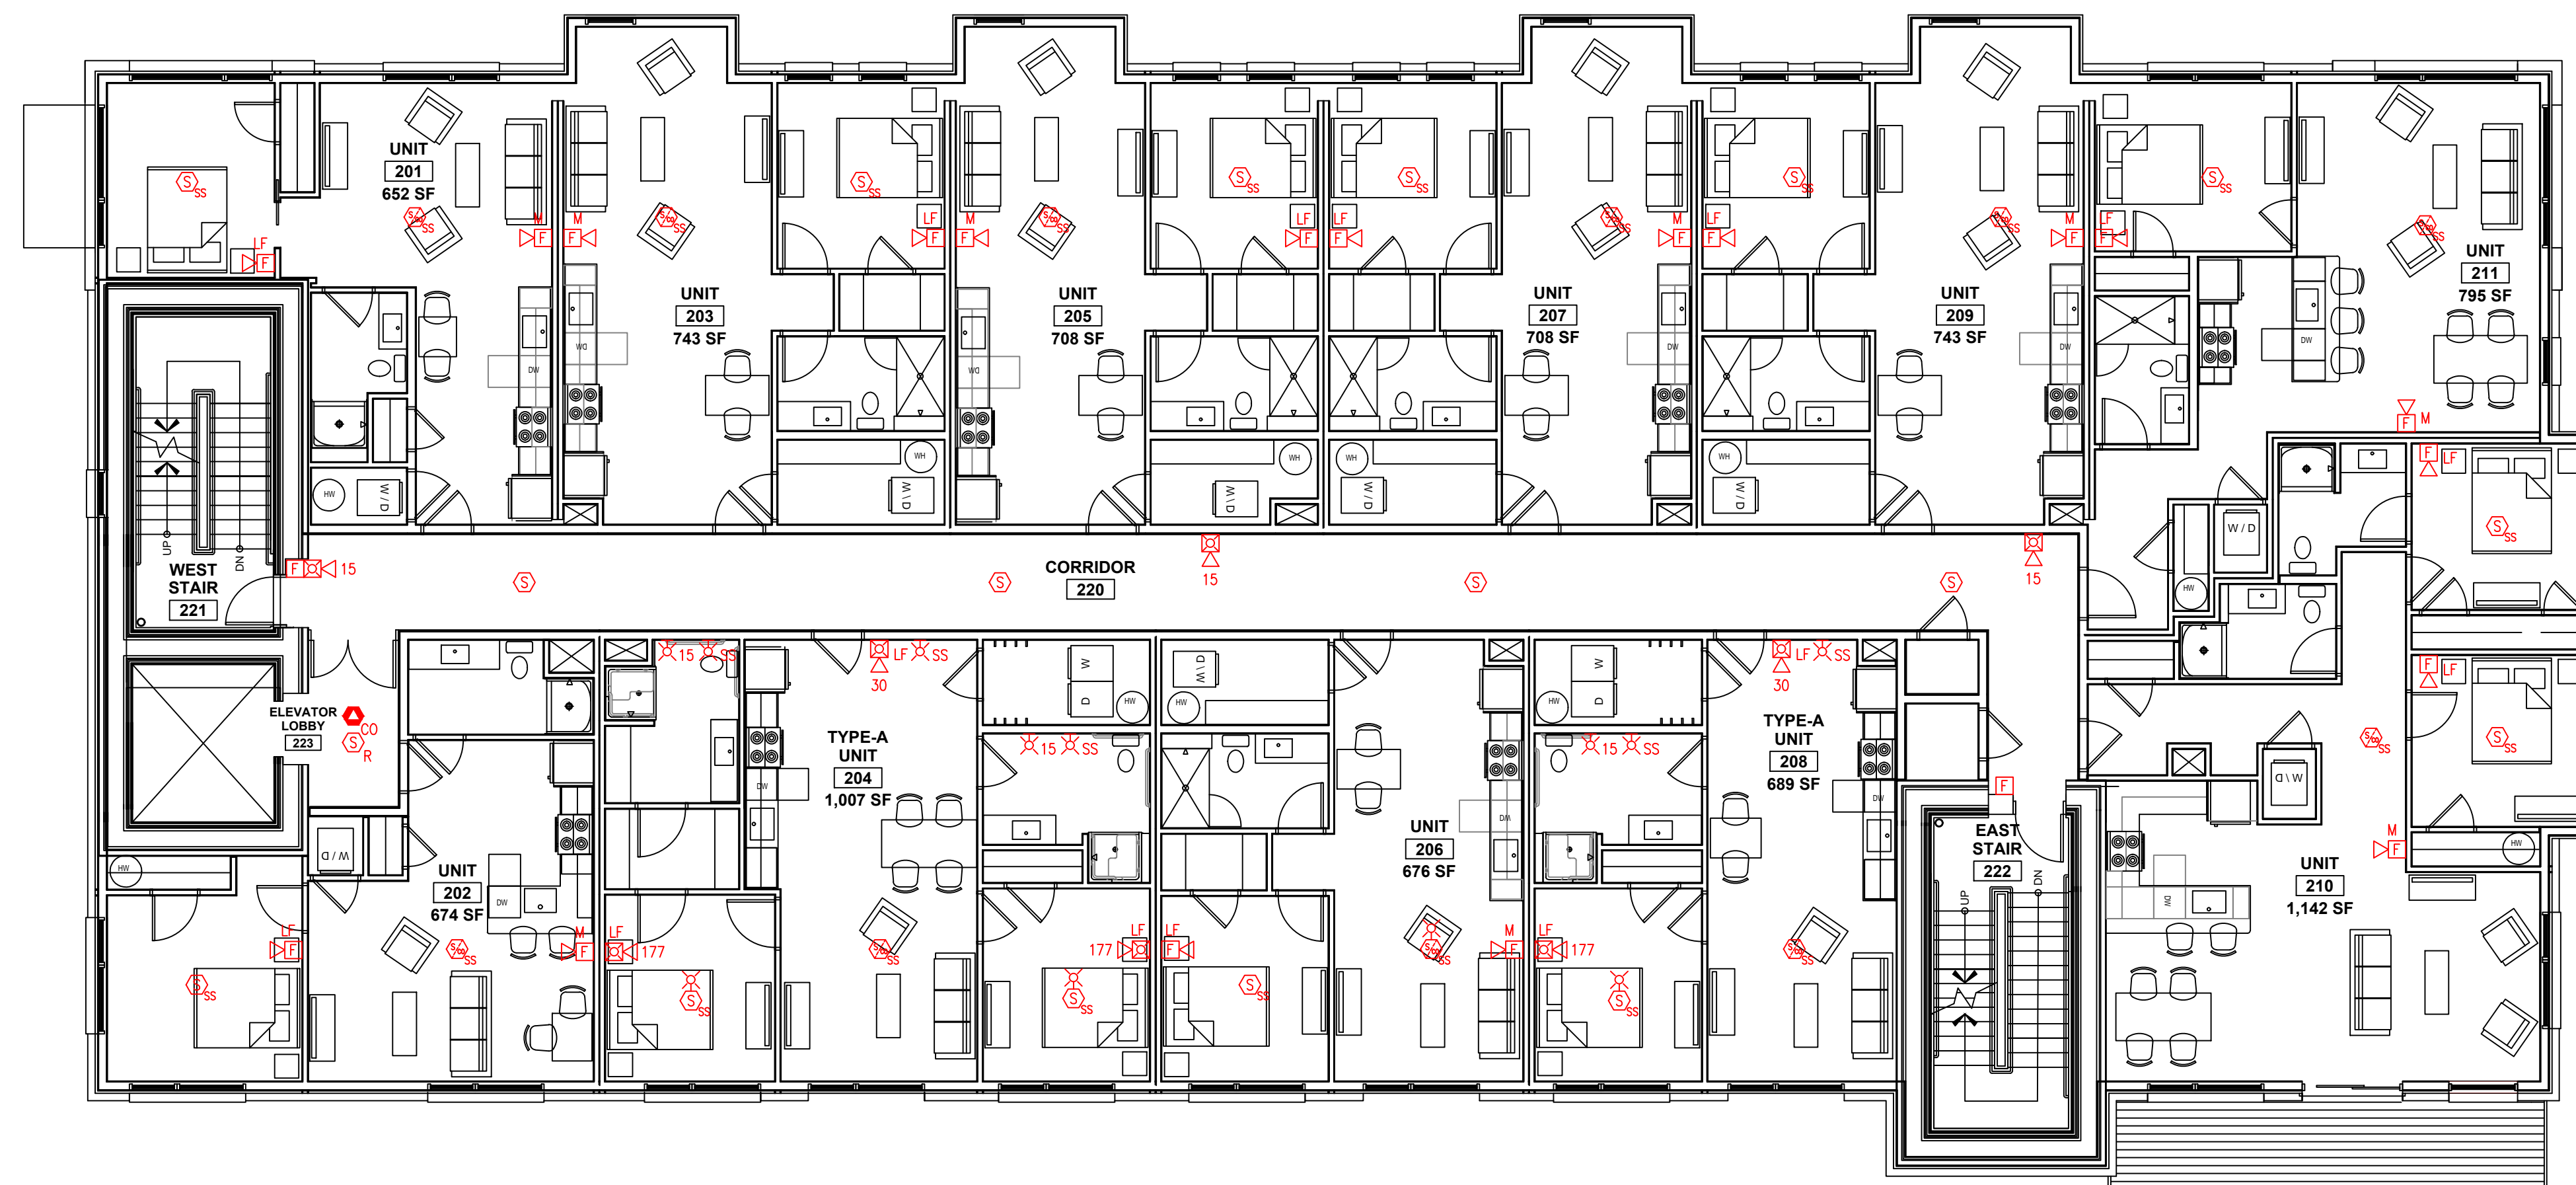

Drawn By: JAB
 Checked By: MP
 Installation Contractor: BH Milliken

Mixed Use Building 40 Free Street



| No. | Revision/Issue | Date |
|-----|----------------|------|
| | | |
















Firm Name and Address
 Norris Inc.
 2257 West Broadway
 South Portland Me.
 04106
 1-800-370-3473


Project Name and Address
**Mixed Use Building
 Second Floor
 Fire Alarm Plan
 40 Free Street
 Portland, Maine**

| | | | |
|---------|-----------|-------|-------------|
| Project | 1376 | Sheet | FP-2 |
| Date | 11/6/2019 | | |
| Scale | 1/8" = 1' | | |


 Reviewed for Code Compliance
 Permitting and Inspections Department
 Approved with Conditions
 12/17/2019

FIRE ALARM LEGEND

-  FIRE ALARM CONTROL PANEL
-  FIRE ALARM ANNUNCIATOR
-  SMOKE DETECTOR, R INDICATES ELEVATOR RECALL DEVICE
-  HEAT DETECTOR, R INDICATES ELEVATOR RECALL DEVICE
-  CARBON MONOXIDE DETECTOR
-  PULL STATION
-  HORN STROBE, NUMBER INDICATES STROBE CANDELA VALUE
-  STROBE ONLY, NUMBER INDICATES STROBE CANDELA VALUE
-  LOW FREQUENCY SOUNDER STROBE, NUMBER INDICATES STROBE CANDELA VALUE
-  LOW FREQUENCY SOUNDER
-  MINI HORN
-  STROBE ONLY, SS INDICATES SINGLE STATION
-  SMOKE DETECTOR, SS INDICATES SINGLE STATION
-  SMOKE/CO COMBINATION, SS INDICATES SINGLE STATION
-  SMOKE/STROBE COMBINATION, SS INDICATES SINGLE STATION

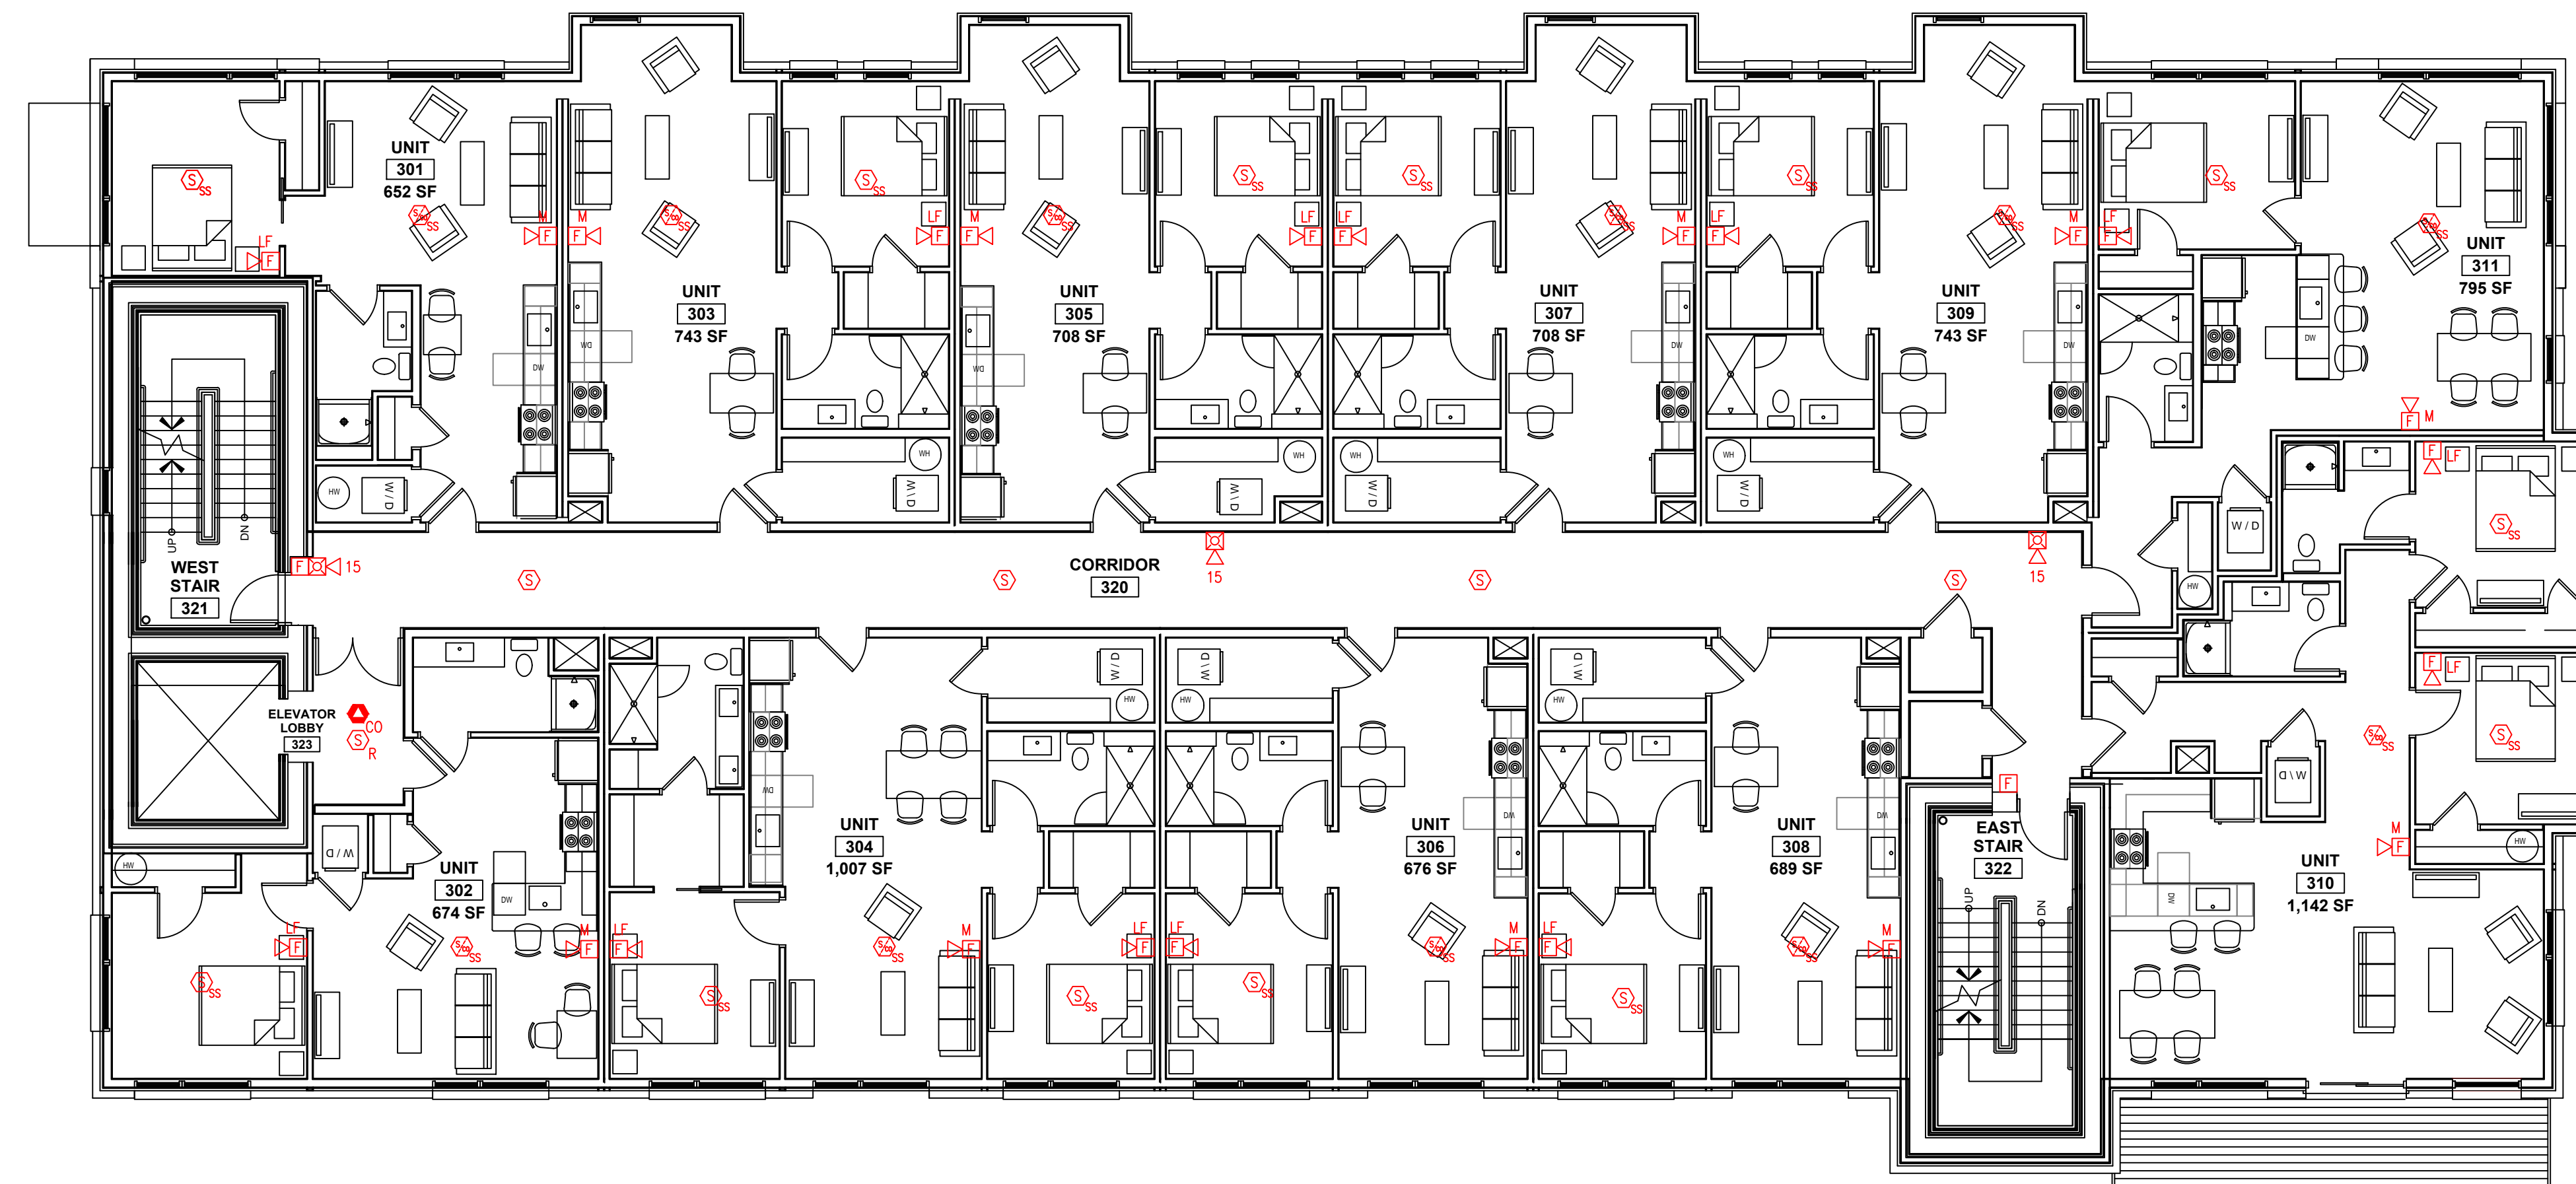

Drawn By: JAB
 Checked By: MP
 Installation Contractor: BH Milliken

Mixed Use Building 40 Free Street



| No. | Revision/Issue | Date |
|-----|----------------|------|
| | | |
















Firm Name and Address
 Norris Inc.
 2257 West Broadway
 South Portland Me.
 04106
 1-800-370-3473


Project Name and Address
**Mixed Use Building
 Third Floor
 Fire Alarm Plan
 40 Free Street
 Portland, Maine**

| | | | |
|---------|-----------|-------|-------------|
| Project | 1376 | Sheet | FP-3 |
| Date | 11/6/2019 | | |
| Scale | 1/8" = 1' | | |


 Reviewed for Code Compliance
 Permitting and Inspections Department
 Approved with Conditions
 12/17/2019

FIRE ALARM LEGEND

-  FIRE ALARM CONTROL PANEL
-  FIRE ALARM ANNUNCIATOR
-  SMOKE DETECTOR, R INDICATES ELEVATOR RECALL DEVICE
-  HEAT DETECTOR, R INDICATES ELEVATOR RECALL DEVICE
-  CARBON MONOXIDE DETECTOR
-  PULL STATION
-  HORN STROBE, NUMBER INDICATES STROBE CANDELA VALUE
-  STROBE ONLY, NUMBER INDICATES STROBE CANDELA VALUE
-  LOW FREQUENCY SOUNDER STROBE, NUMBER INDICATES STROBE CANDELA VALUE
-  LOW FREQUENCY SOUNDER
-  MINI HORN
-  STROBE ONLY, SS INDICATES SINGLE STATION
-  SMOKE DETECTOR, SS INDICATES SINGLE STATION
-  SMOKE/CO COMBINATION, SS INDICATES SINGLE STATION
-  SMOKE/STROBE COMBINATION, SS INDICATES SINGLE STATION

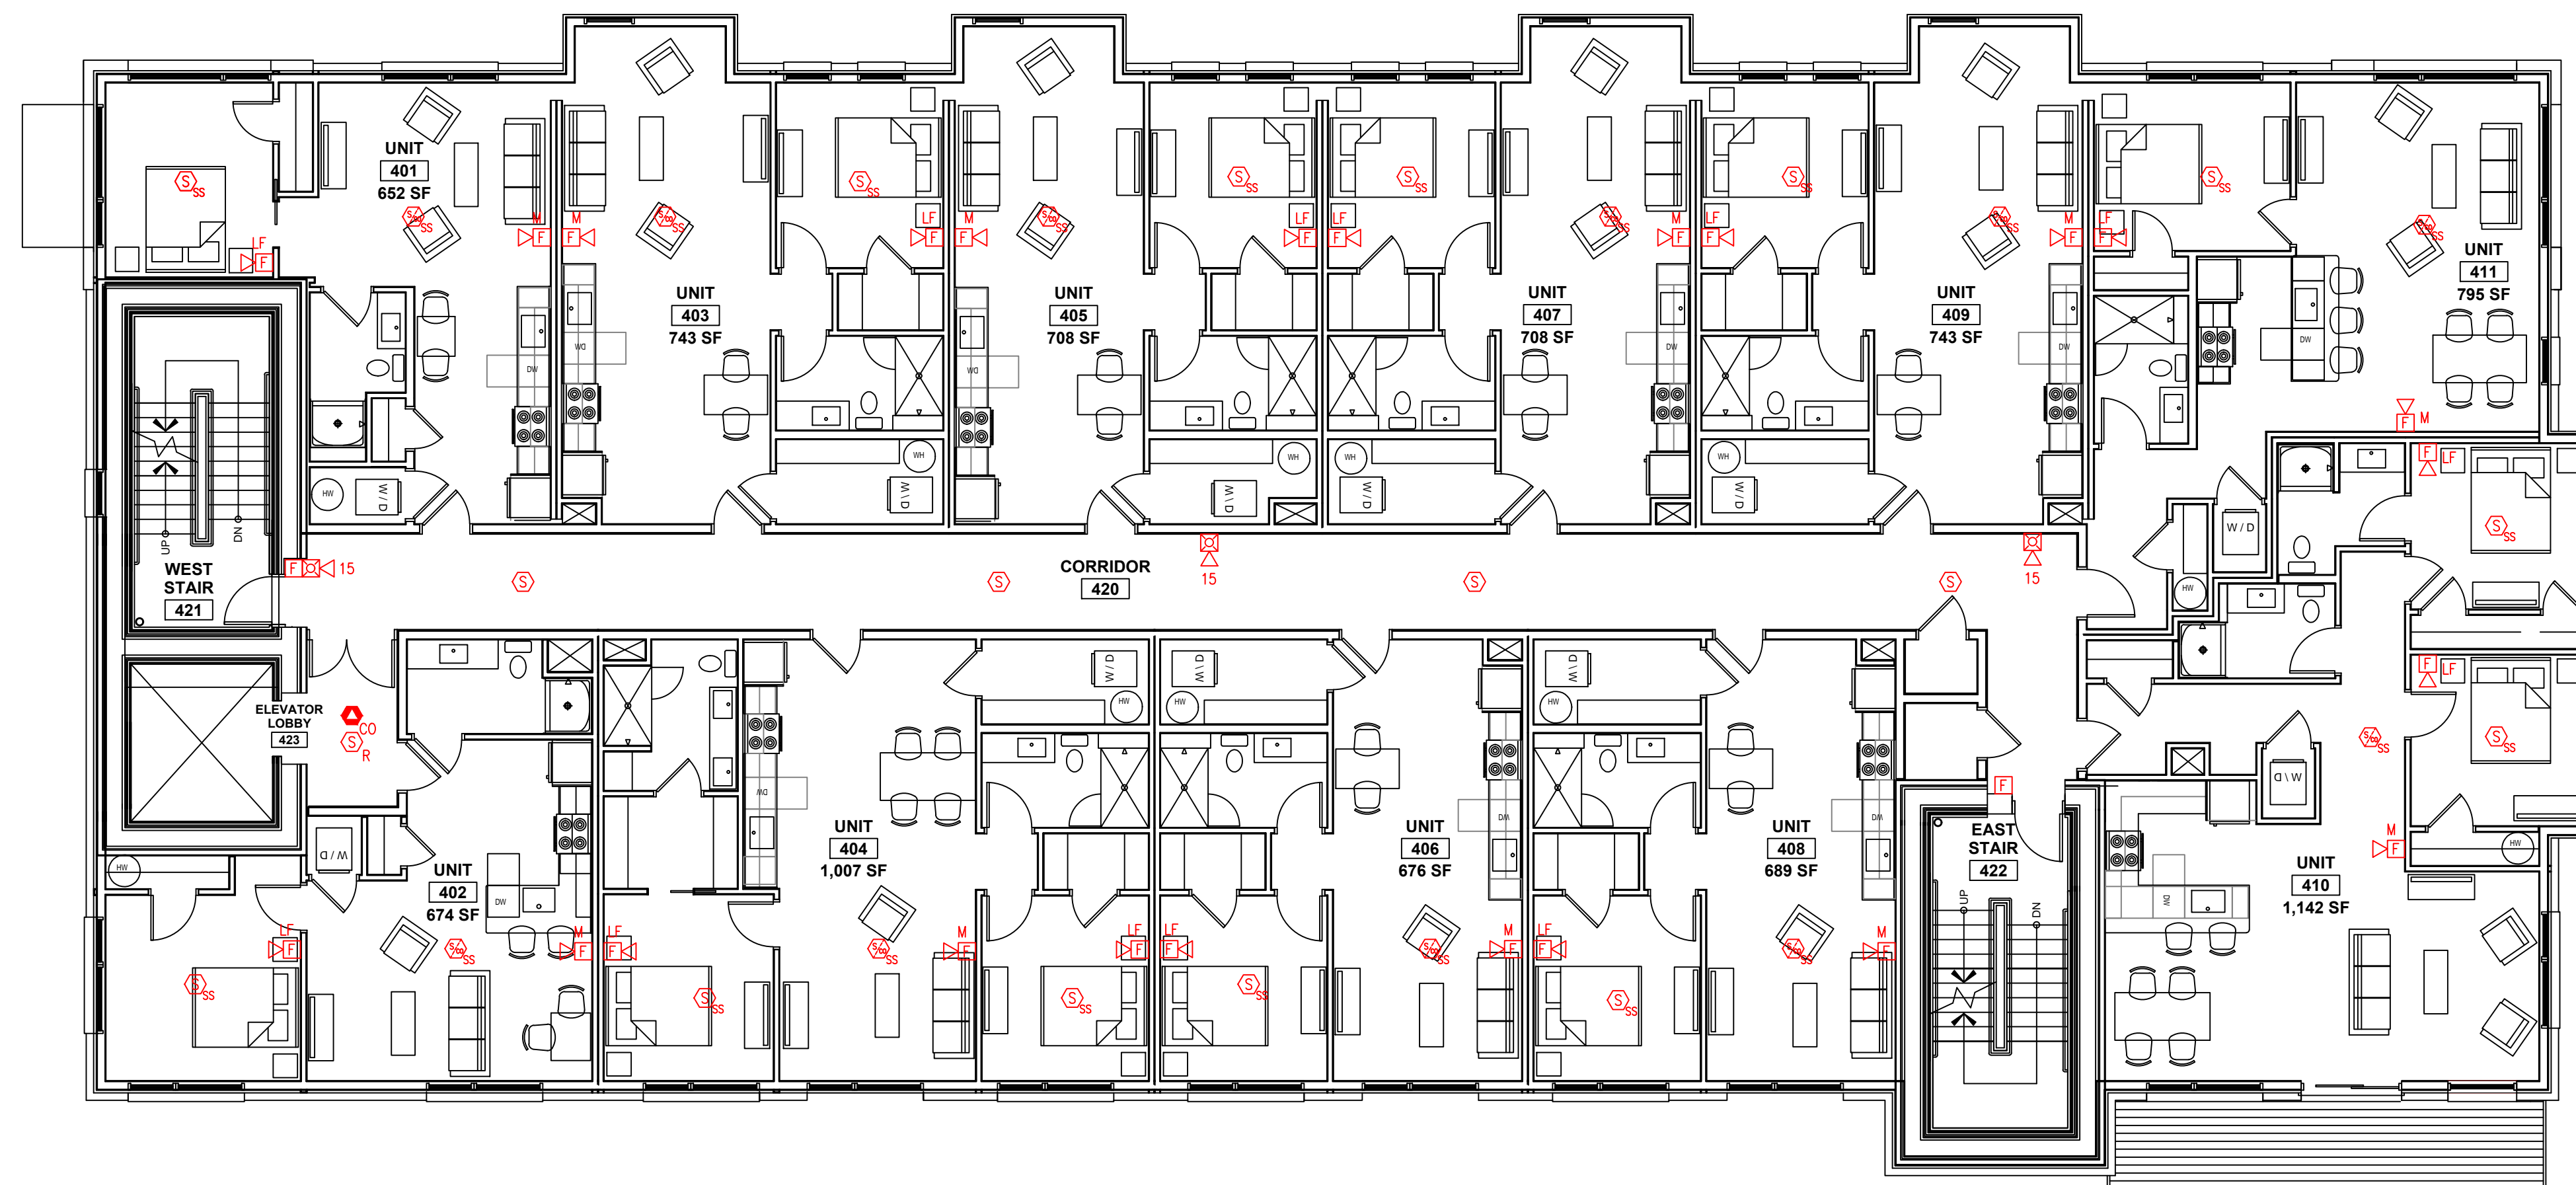

Drawn By: JAB
 Checked By: MP
 Installation Contractor: BH Milliken

Mixed Use Building 40 Free Street



| No. | Revision/Issue | Date |
|-----|----------------|------|
| | | |
















Firm Name and Address
 Norris Inc.
 2257 West Broadway
 South Portland Me.
 04106
 1-800-370-3473


Project Name and Address
Mixed Use Building
Fourth Floor
Fire Alarm Plan
40 Free Street
Portland, Maine

| | | | |
|---------|-----------|-------|-------------|
| Project | 1376 | Sheet | FP-4 |
| Date | 11/6/2019 | | |
| Scale | 1/8" = 1' | | |


 Reviewed for Code Compliance
 Permitting and Inspections Department
 Approved with Conditions
 12/17/2019

FIRE ALARM LEGEND

-  FIRE ALARM CONTROL PANEL
-  FIRE ALARM ANNUNCIATOR
-  SMOKE DETECTOR, R INDICATES ELEVATOR RECALL DEVICE
-  HEAT DETECTOR, R INDICATES ELEVATOR RECALL DEVICE
-  CARBON MONOXIDE DETECTOR
-  PULL STATION
-  HORN STROBE, NUMBER INDICATES STROBE CANDELA VALUE
-  STROBE ONLY, NUMBER INDICATES STROBE CANDELA VALUE
-  LOW FREQUENCY SOUNDER STROBE, NUMBER INDICATES STROBE CANDELA VALUE
-  LOW FREQUENCY SOUNDER
-  MINI HORN
-  STROBE ONLY, SS INDICATES SINGLE STATION
-  SMOKE DETECTOR, SS INDICATES SINGLE STATION
-  SMOKE/CO COMBINATION, SS INDICATES SINGLE STATION
-  SMOKE/STROBE COMBINATION, SS INDICATES SINGLE STATION

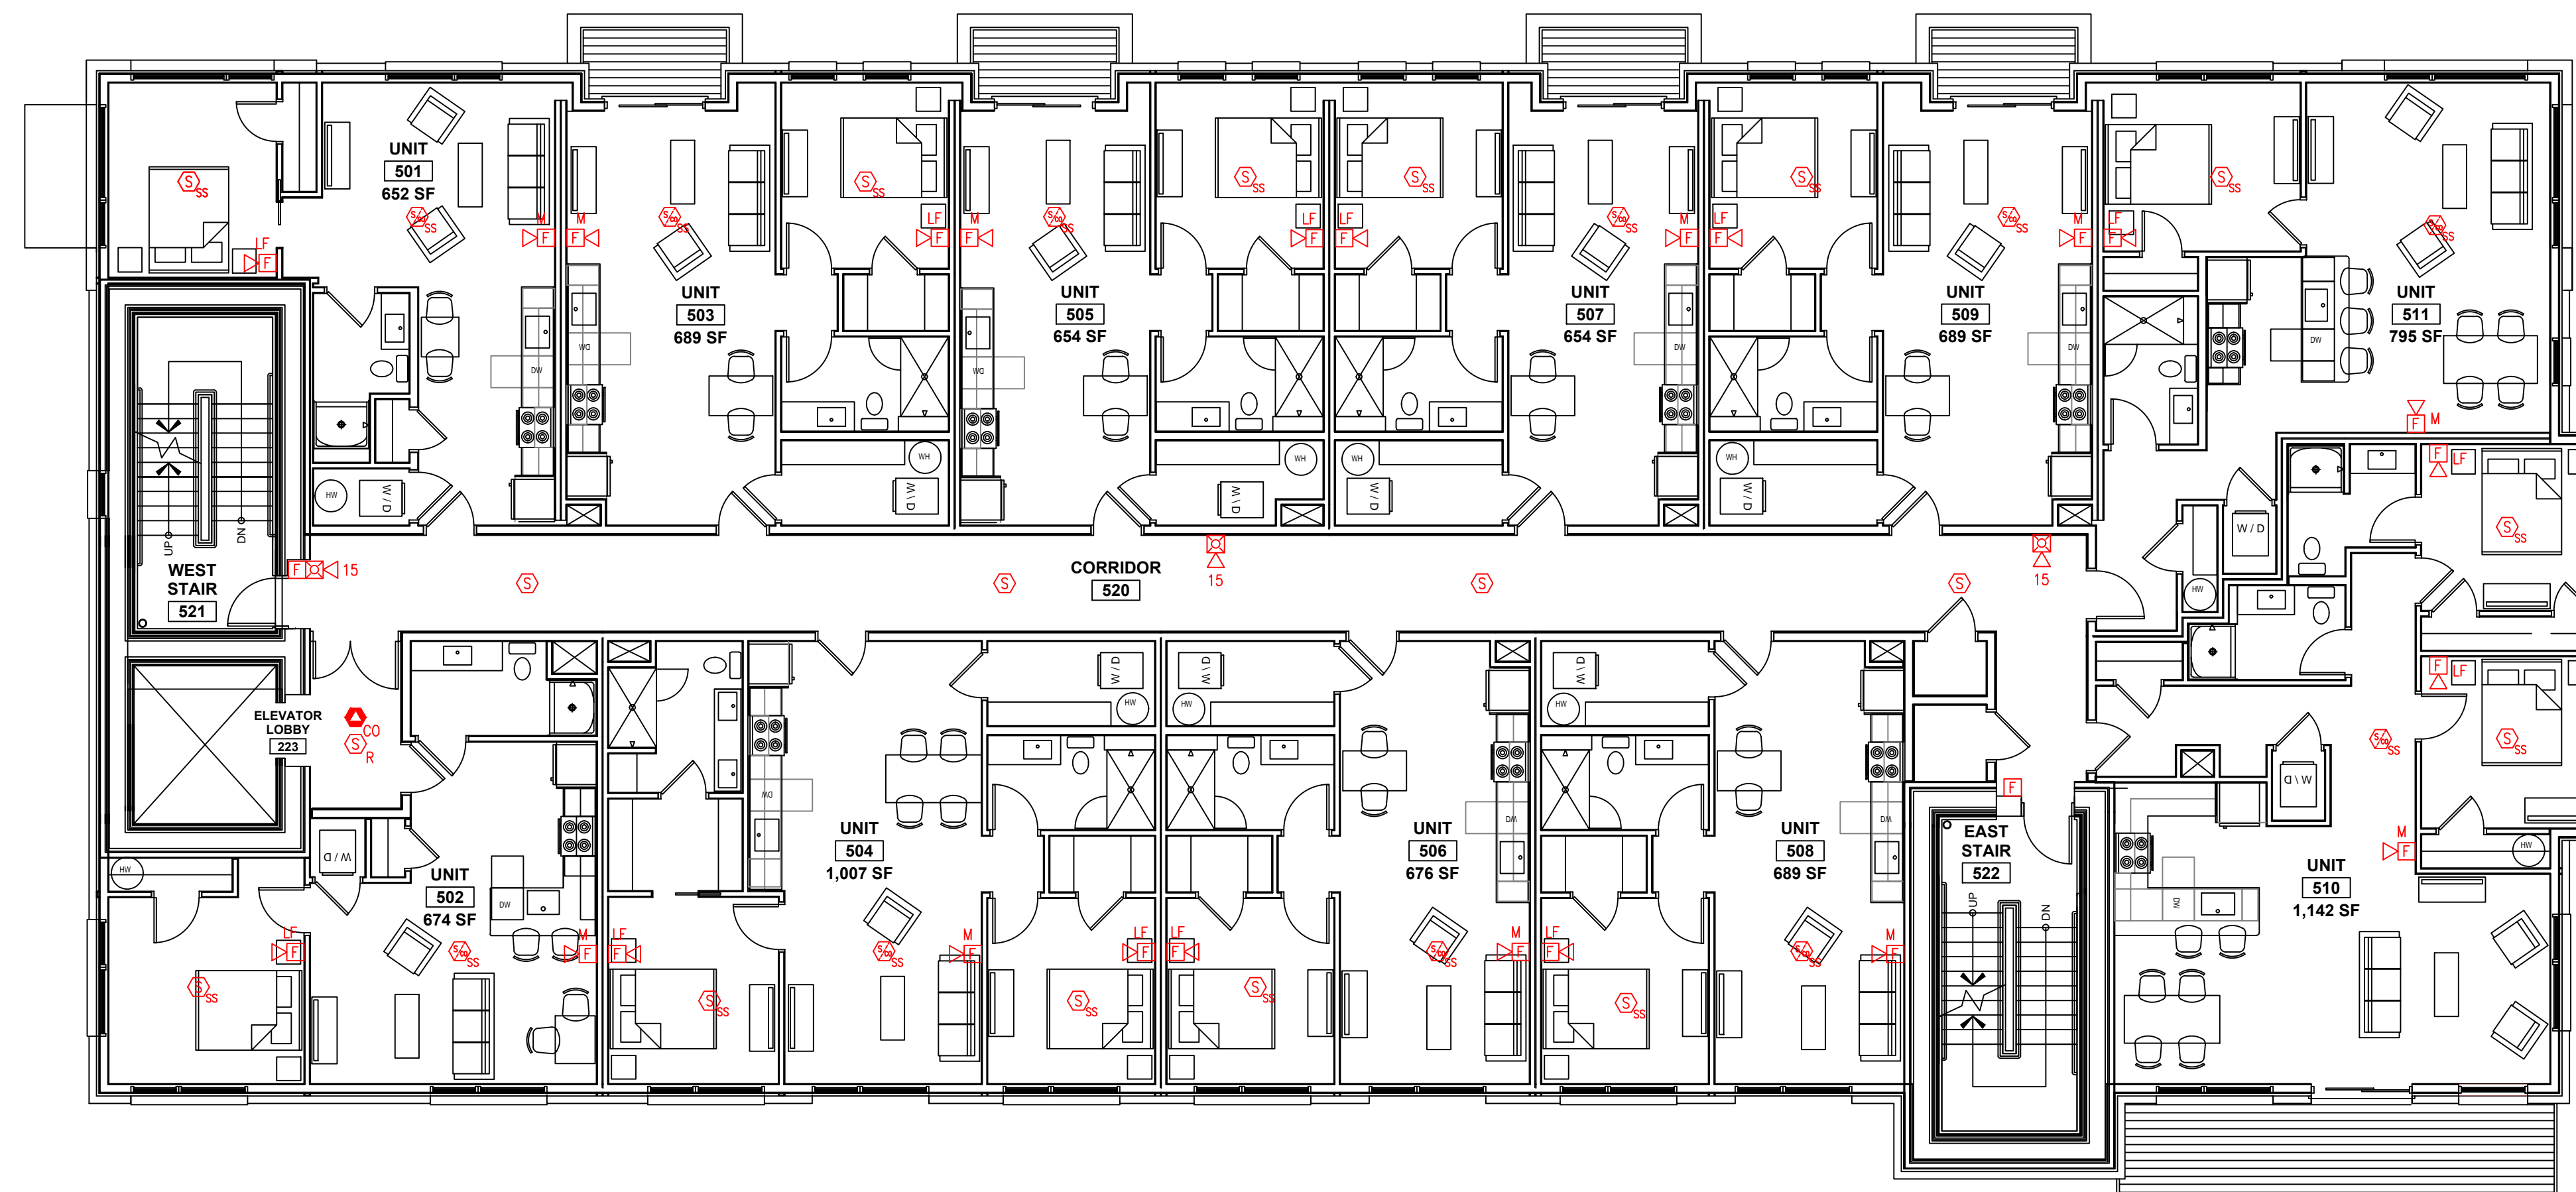

Drawn By: JAB
 Checked By: MP
 Installation Contractor: BH Milliken

Mixed Use Building 40 Free Street



| No. | Revision/Issue | Date |
|-----|----------------|------|
| | | |
















Firm Name and Address
 Norris Inc.
 2257 West Broadway
 South Portland Me.
 04106
 1-800-370-3473


Project Name and Address
Mixed Use Building
Fifth Floor
Fire Alarm Plan
40 Free Street
Portland, Maine

| | | | |
|---------|-----------|-------|-------------|
| Project | 1376 | Sheet | FP-5 |
| Date | 11/6/2019 | | |
| Scale | 1/8" = 1' | | |



FIRE ALARM LEGEND

-  FIRE ALARM CONTROL PANEL
-  FIRE ALARM ANNUNCIATOR
-  SMOKE DETECTOR, R INDICATES ELEVATOR RECALL DEVICE
-  HEAT DETECTOR, R INDICATES ELEVATOR RECALL DEVICE
-  CARBON MONOXIDE DETECTOR
-  PULL STATION
-  HORN STROBE, NUMBER INDICATES STROBE CANDELA VALUE
-  STROBE ONLY, NUMBER INDICATES STROBE CANDELA VALUE
-  LOW FREQUENCY SOUNDER STROBE, NUMBER INDICATES STROBE CANDELA VALUE
-  LOW FREQUENCY SOUNDER
-  MINI HORN
-  STROBE ONLY, SS INDICATES SINGLE STATION
-  SMOKE DETECTOR, SS INDICATES SINGLE STATION
-  SMOKE/CO COMBINATION, SS INDICATES SINGLE STATION
-  SMOKE/STROBE COMBINATION, SS INDICATES SINGLE STATION

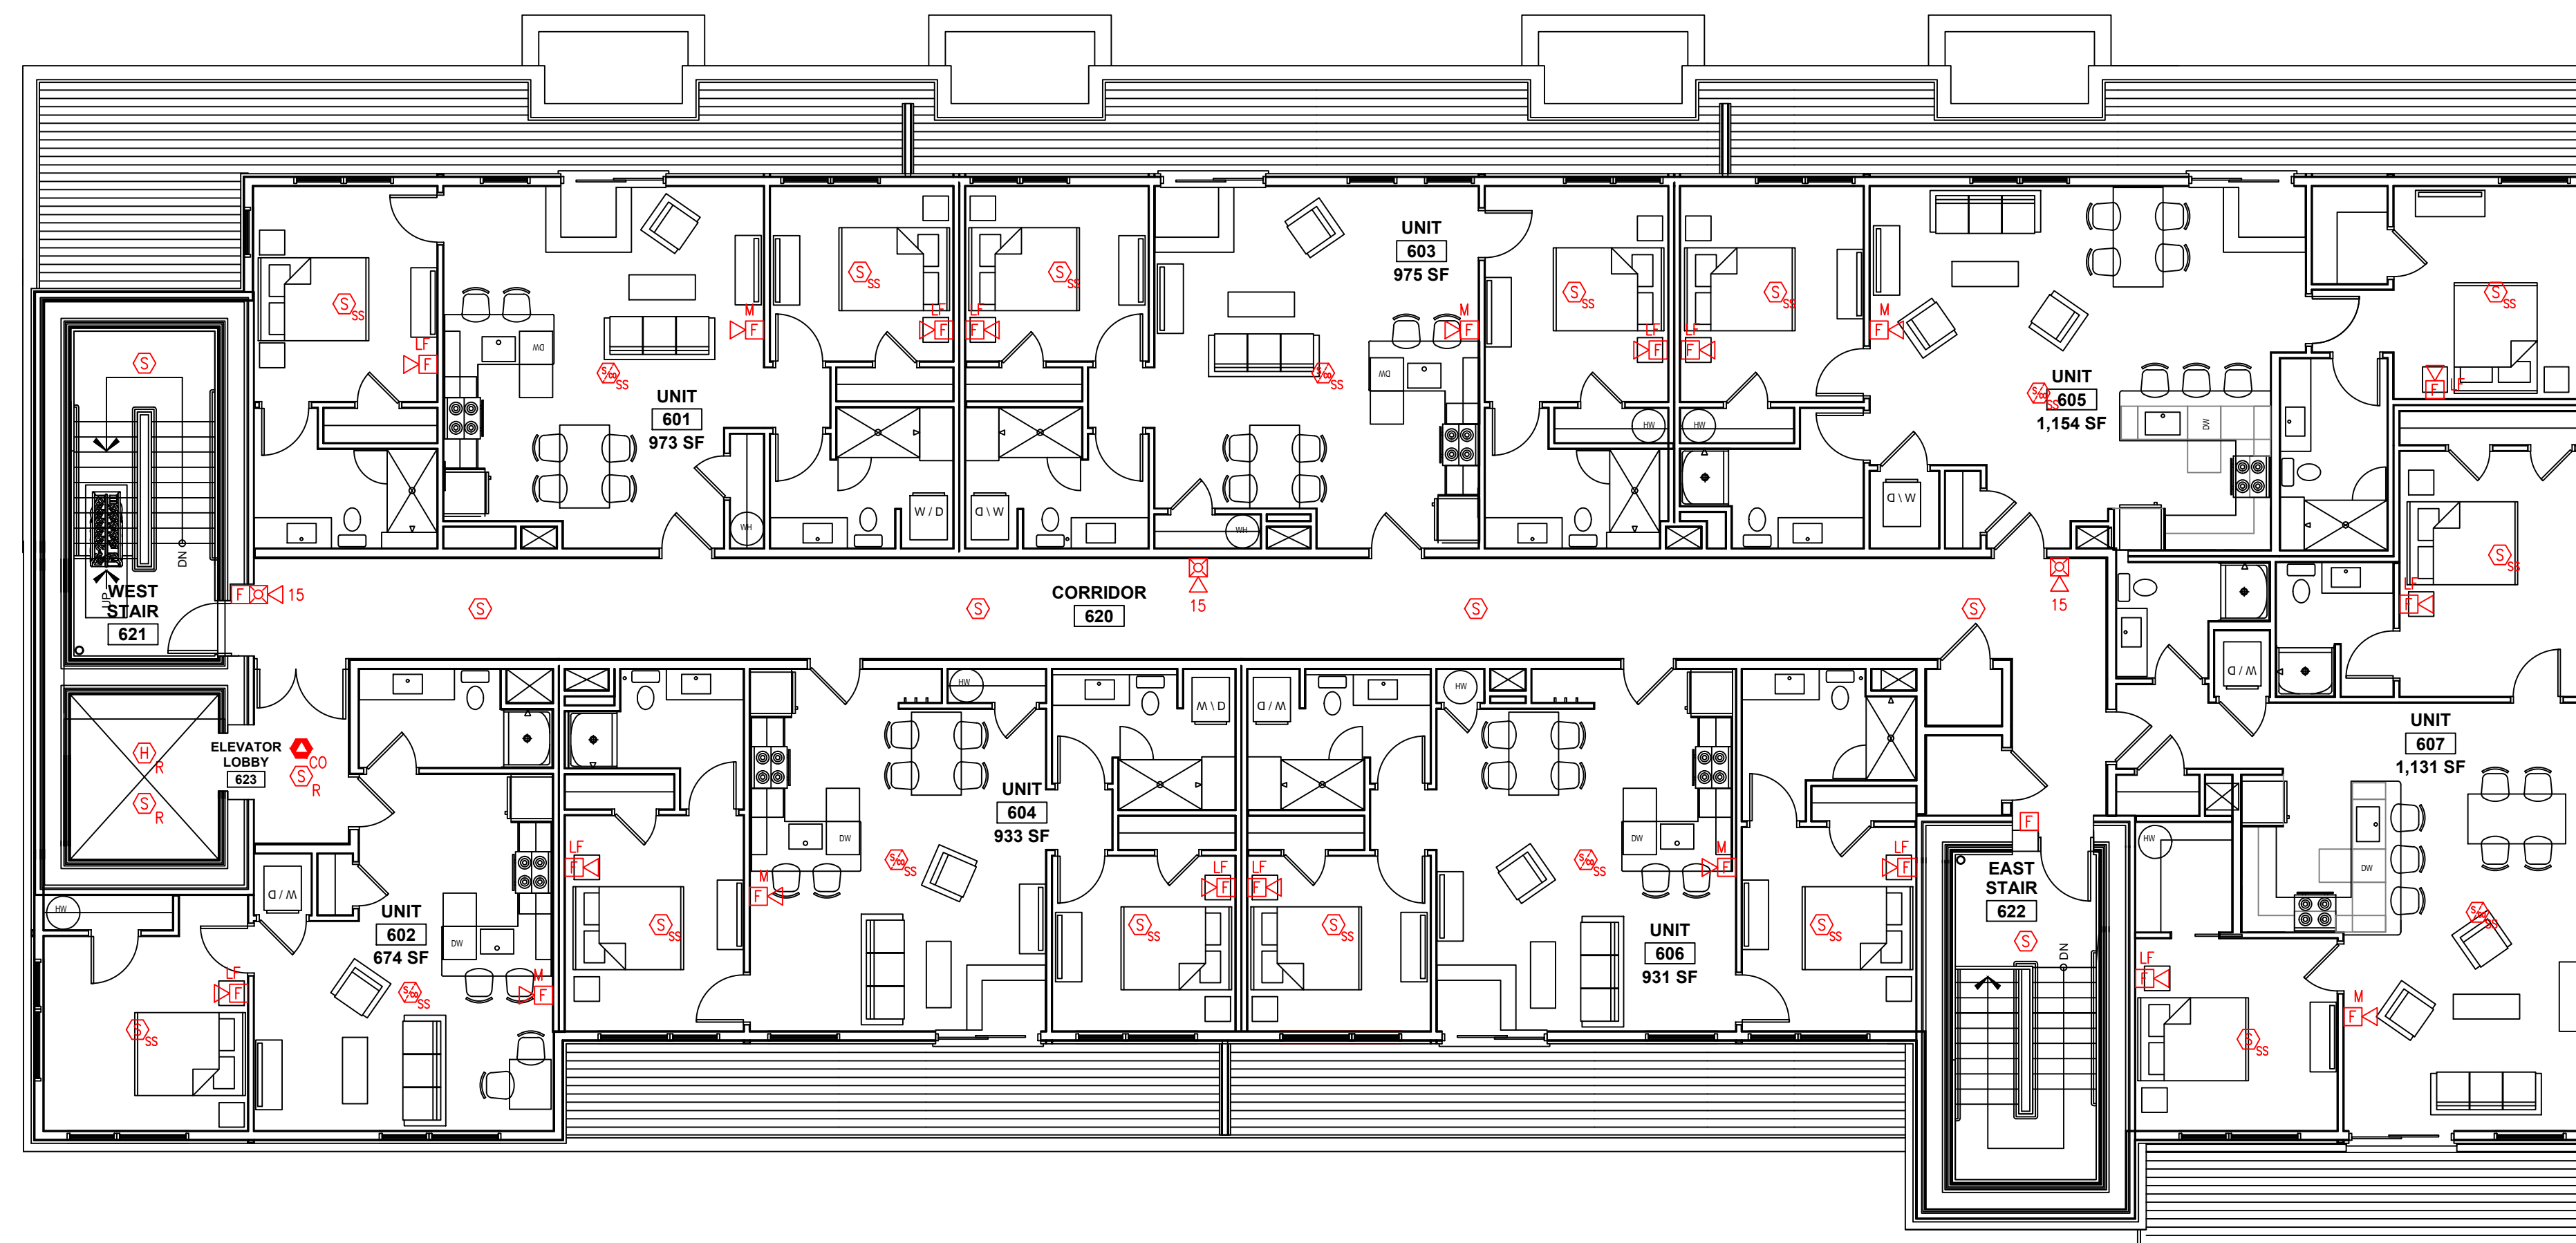

Drawn By: JAB
 Checked By: MP
 Installation Contractor: BH Milliken

Mixed Use Building 40 Free Street



| No. | Revision/Issue | Date |
|-----|----------------|------|
| | | |

Firm Name and Address
 Norris Inc.
 2257 West Broadway
 South Portland Me.
 04106
 1-800-370-3473

Project Name and Address
**Mixed Use Building
 Sixth Floor
 Fire Alarm Plan
 40 Free Street
 Portland, Maine**

| | | | |
|---------|----------------------|-------|-------------|
| Project | 1376 | Sheet | FP-6 |
| Date | 11/6/2019 | | |
| Scale | $\frac{1}{8}'' = 1'$ | | |

