

Mark	Date	Description

ISSUED FOR
CONSTRUCTION


SEPTEMBER 21, 2016

Drawing Title
FLOORS 7 & 8
EXISTING
CONDITIONS
REMOVAL PLAN
PLUMBING

Scale: 1/8" = 1'-0"

Drawing Number


P05.1

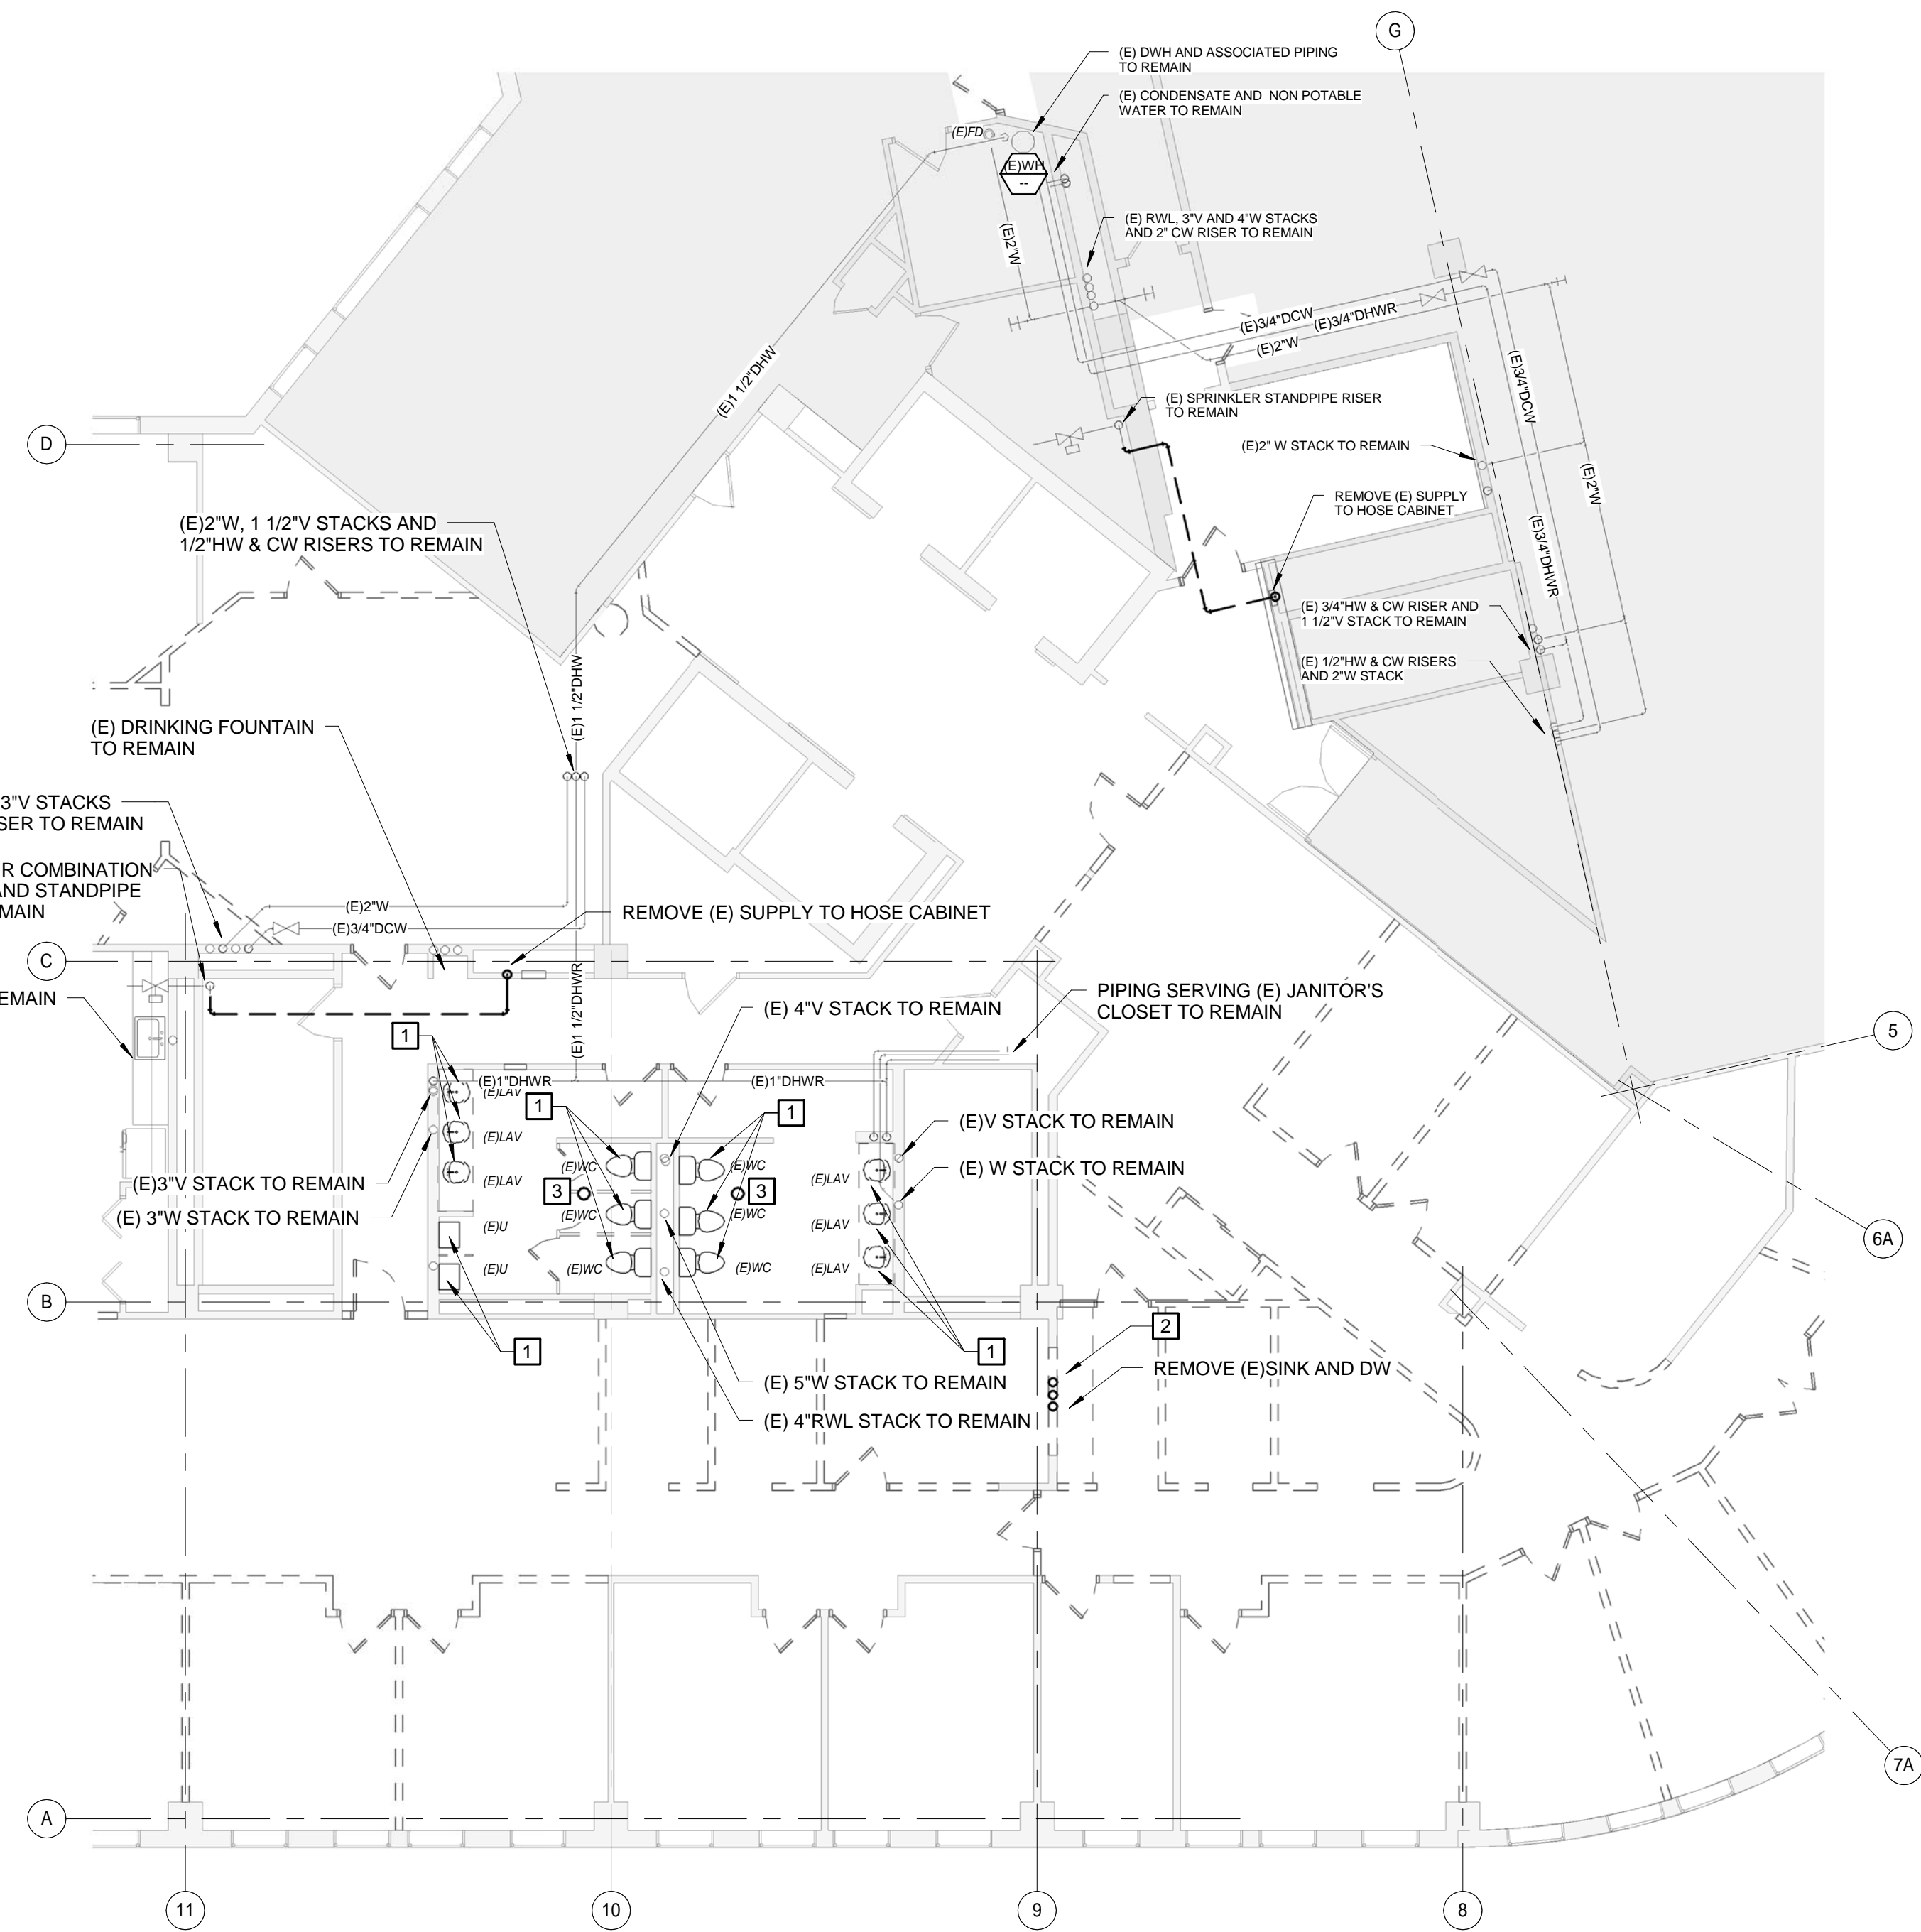

- DEMOLITION KEYED NOTES:**
- 1 REMOVE (E) PLUMBING FIXTURE. ROUGH IN SHALL REMAIN FOR NEW FIXTURE CONNECTIONS.
 - 2 REMOVE (E) PLUMBING FIXTURE AND ASSOCIATED PIPING BACK TO MAINS.
 - 3 REMOVE (E) FLOOR DRAIN GRATE DURING REMOVAL OF NEW TILE FLOORING. (E) FD BODY SHALL BE REUSED. REPLACE GRATE WITH NEW, MATCHING MANUFACTURER AND SIZE.

A1 SEVENTH FLOOR PLUMBING DEMOLITION PLAN

1/8" = 1'-0"

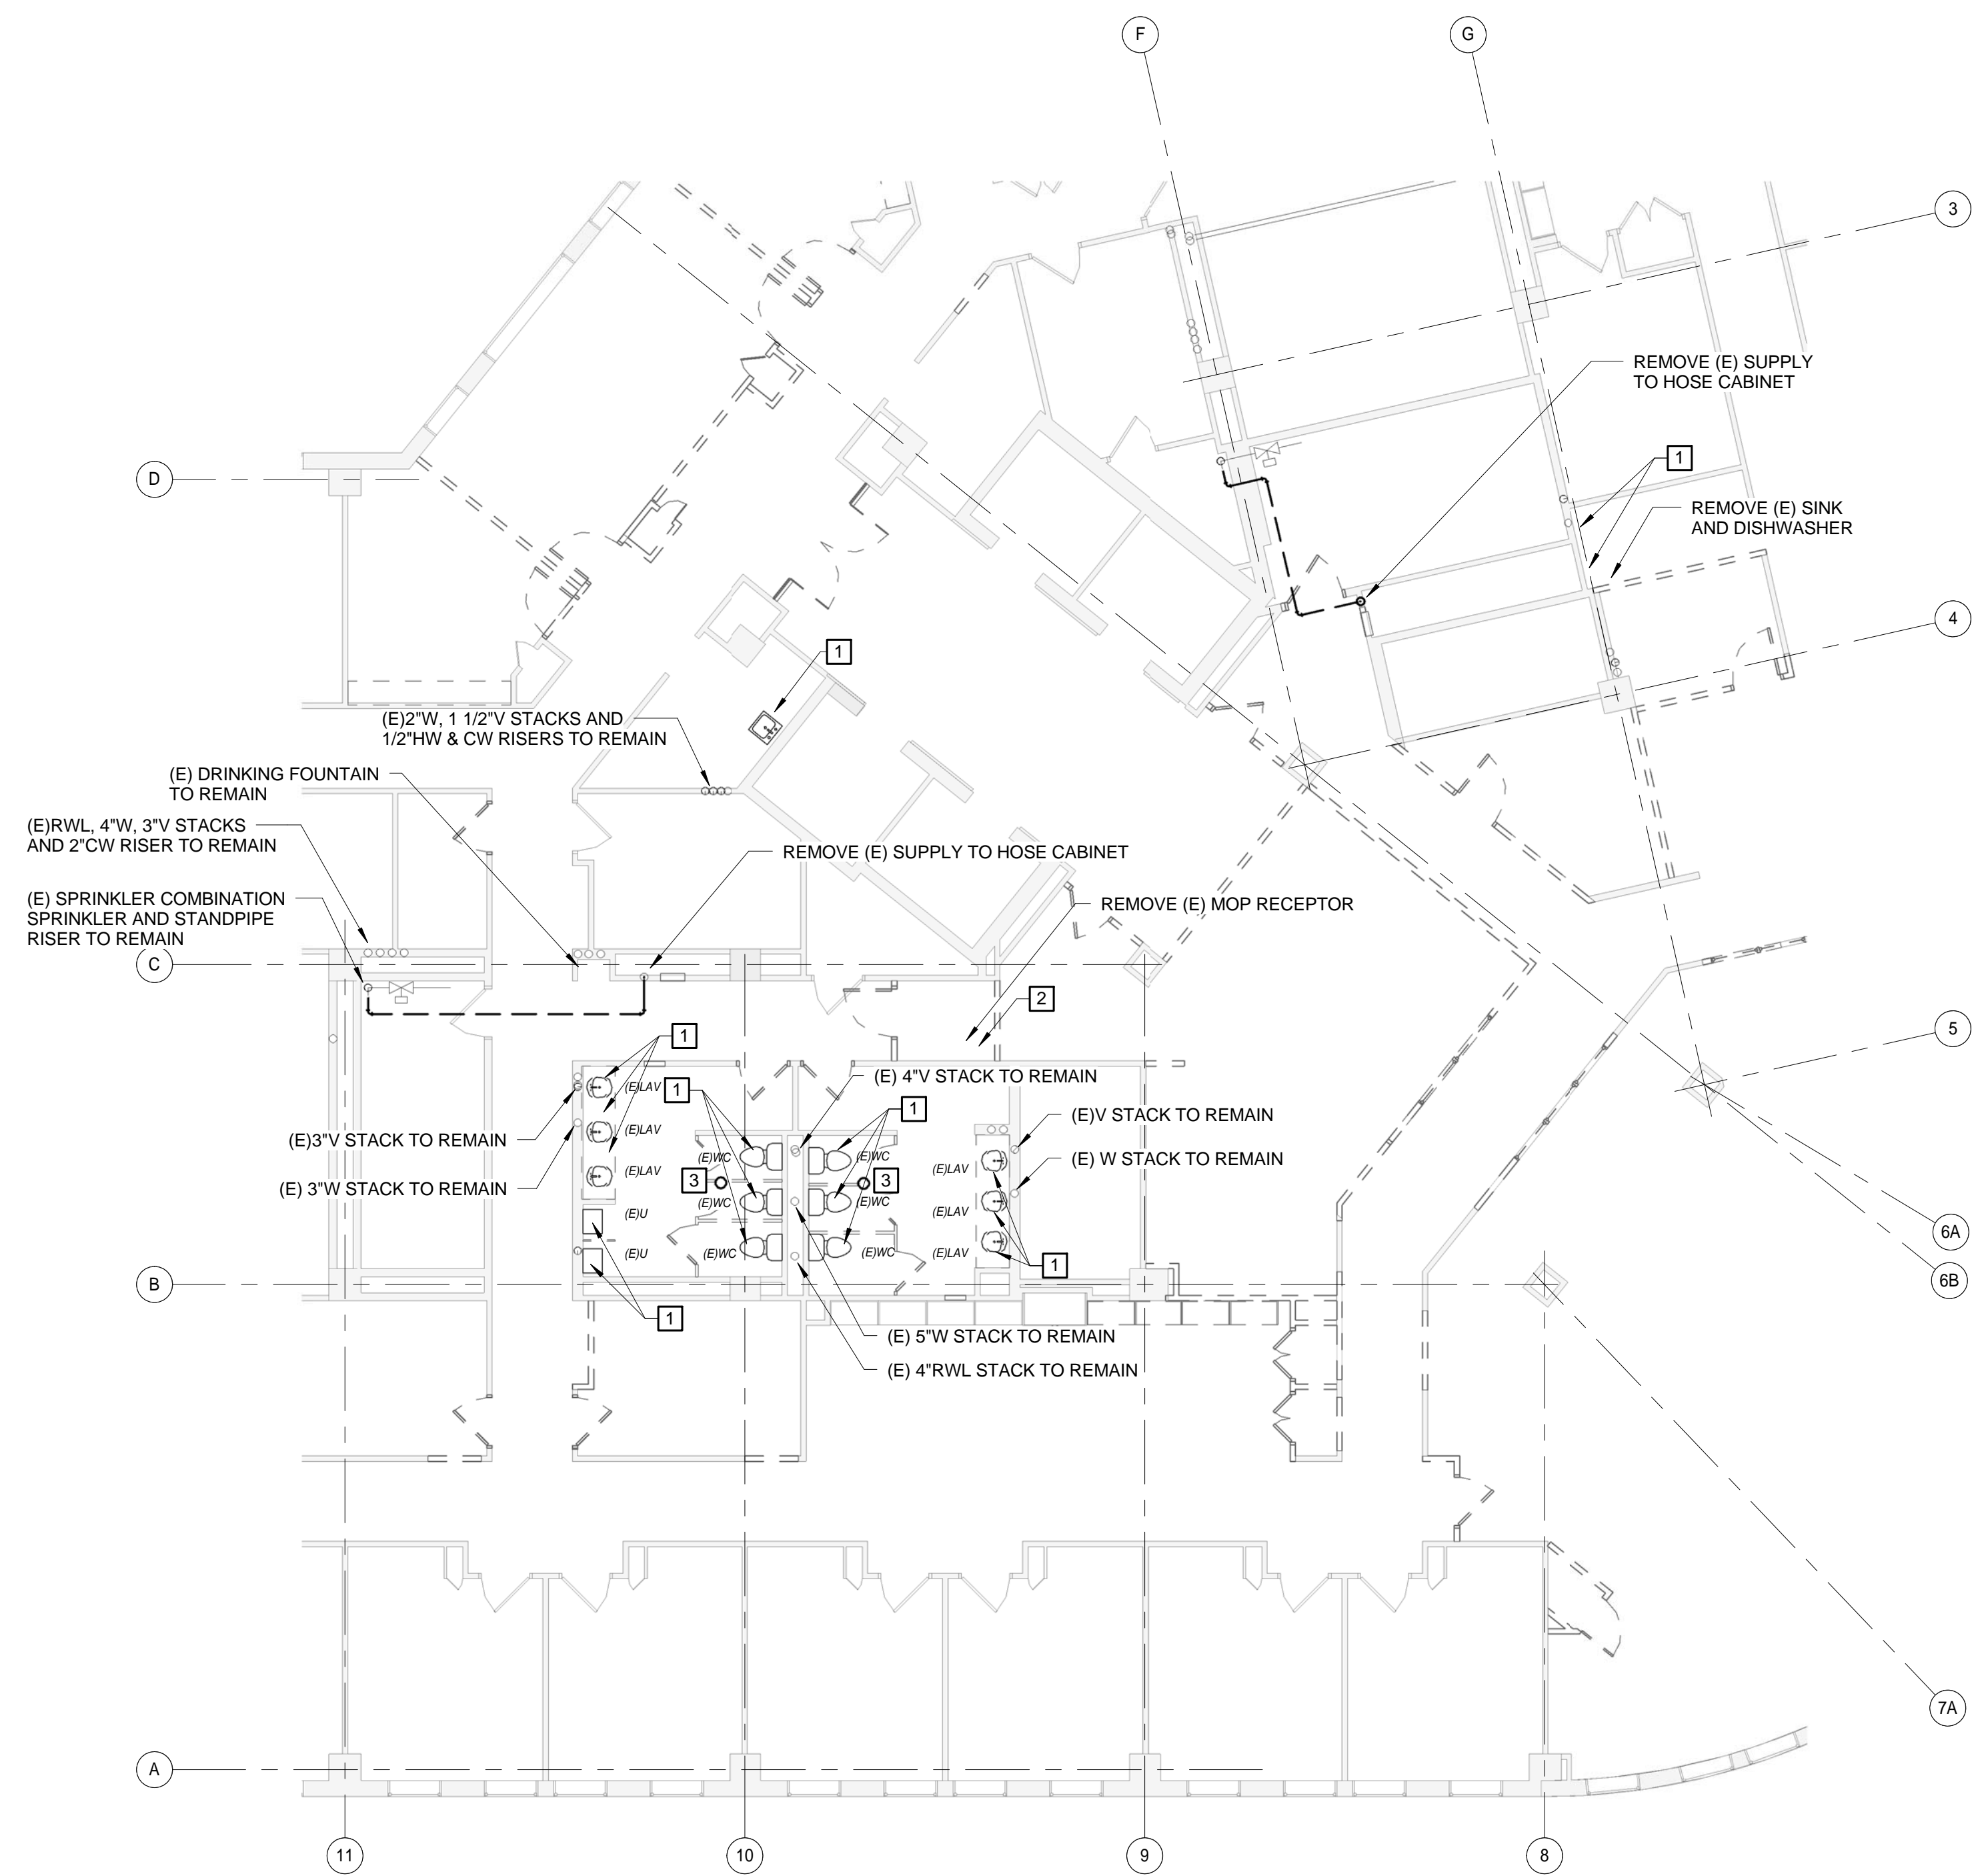

- DEMOLITION KEYED NOTES:**
- 1 REMOVE (E) PLUMBING FIXTURE. ROUGH IN SHALL REMAIN FOR NEW FIXTURE CONNECTIONS.
 - 2 REMOVE (E) PLUMBING FIXTURE AND ASSOCIATED PIPING BACK TO MAINS.
 - 3 REMOVE (E) FLOOR DRAIN GRATE DURING REMOVAL OF NEW TILE FLOORING. (E) FD BODY SHALL BE REUSED. REPLACE GRATE WITH NEW, MATCHING MANUFACTURER AND SIZE.

A6 EIGHTH FLOOR PLUMBING DEMOLITION PLAN

1/8" = 1'-0"