

Mark	Date	Description

ISSUED FOR
CONSTRUCTION

SEPTEMBER 21, 2016


Drawing Title

FLOOR 7 PART
PLANS -
PLUMBING

Scale: 1/8" = 1'-0"

Drawing Number

P10.1

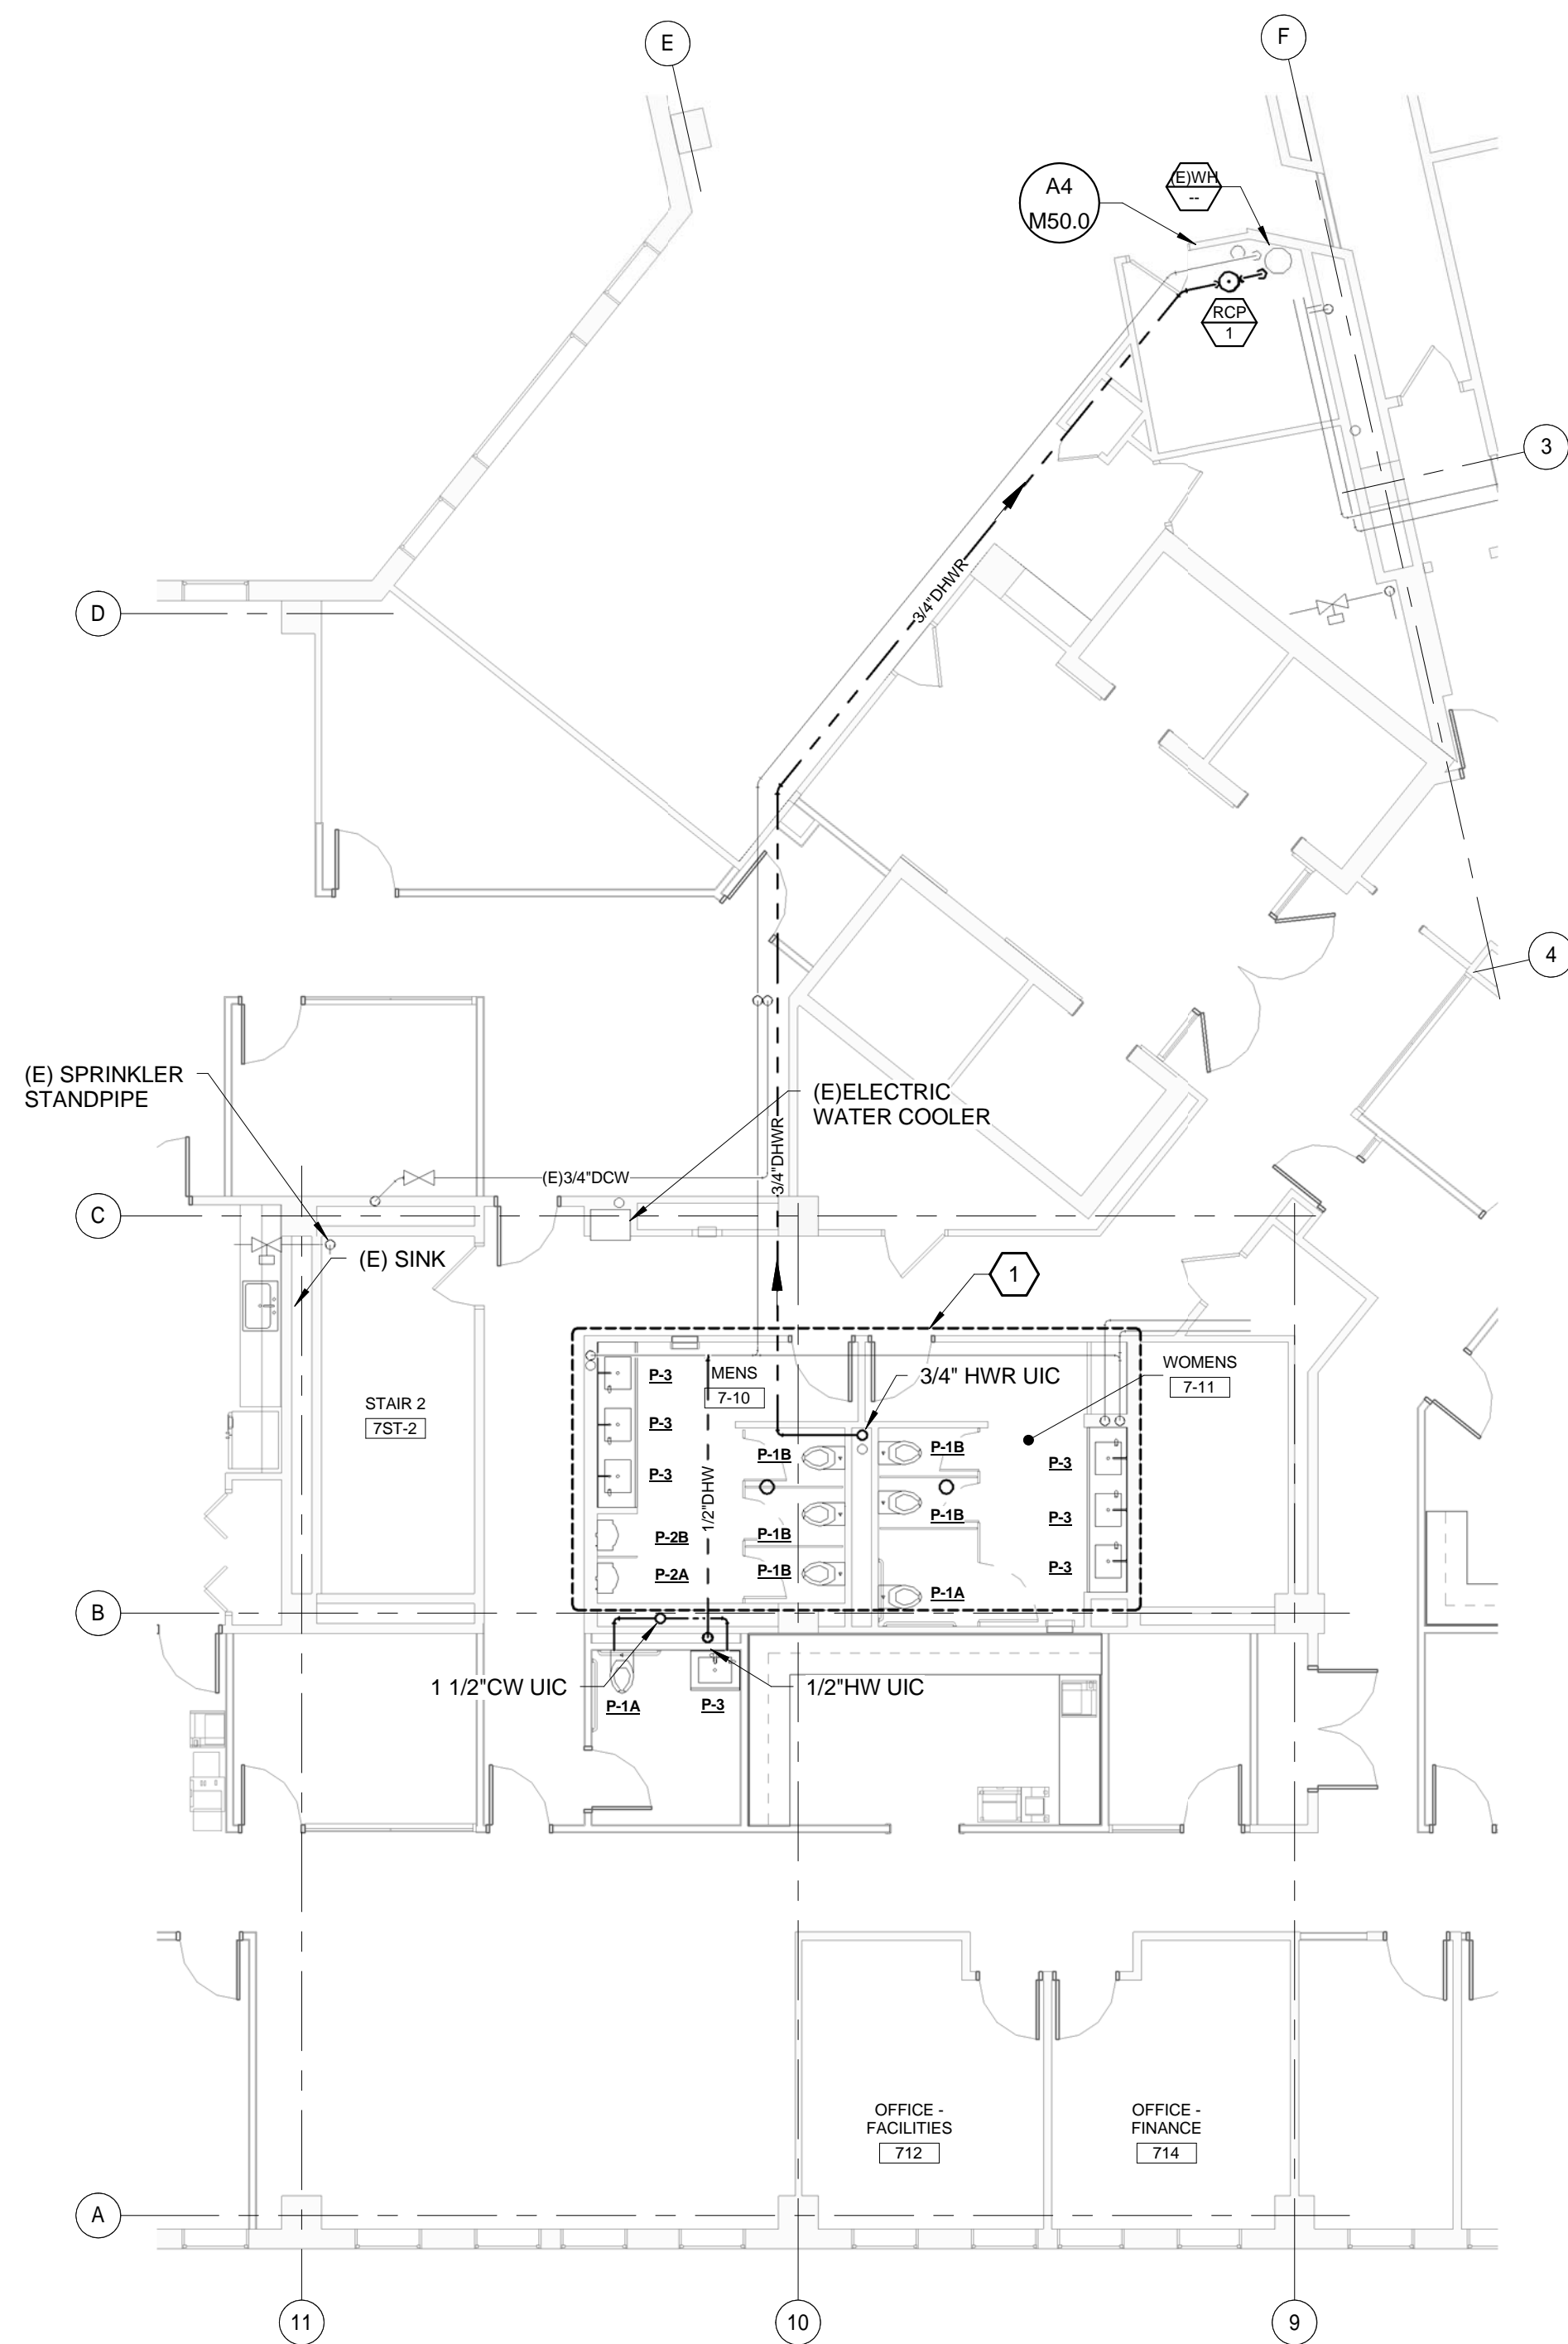

KEYED NOTES:

1 CONNECT NEW FIXTURES TO EXISTING HOT AND COLD WATER PIPING.

GENERAL NOTES:

1. REWORK SPRINKLERS TO PROVIDE ADEQUATE COVERAGE IN EACH NEW SPACE AS REQUIRED BY NFPA 13.



KEYED NOTES:

1 CONNECT NEW FIXTURES TO EXISTING SANITARY WASTE AND VENT PIPING.

2 CONNECT NEW 3\"/>

A1 SEVENTH FLOOR SUPPLY PLAN

1/8" = 1'-0"

A6 SEVENTH FLOOR DRAINAGE PLAN

1/8" = 1'-0"