

Mark Date Description
Project Status
ISSUED FOR CONSTRUCTION


SEPTEMBER 21, 2016

Drawing Title
FLOOR 10 PART PLANS - PLUMBING

Scale: 1/8" = 1'-0"


Drawing Number

P10.4

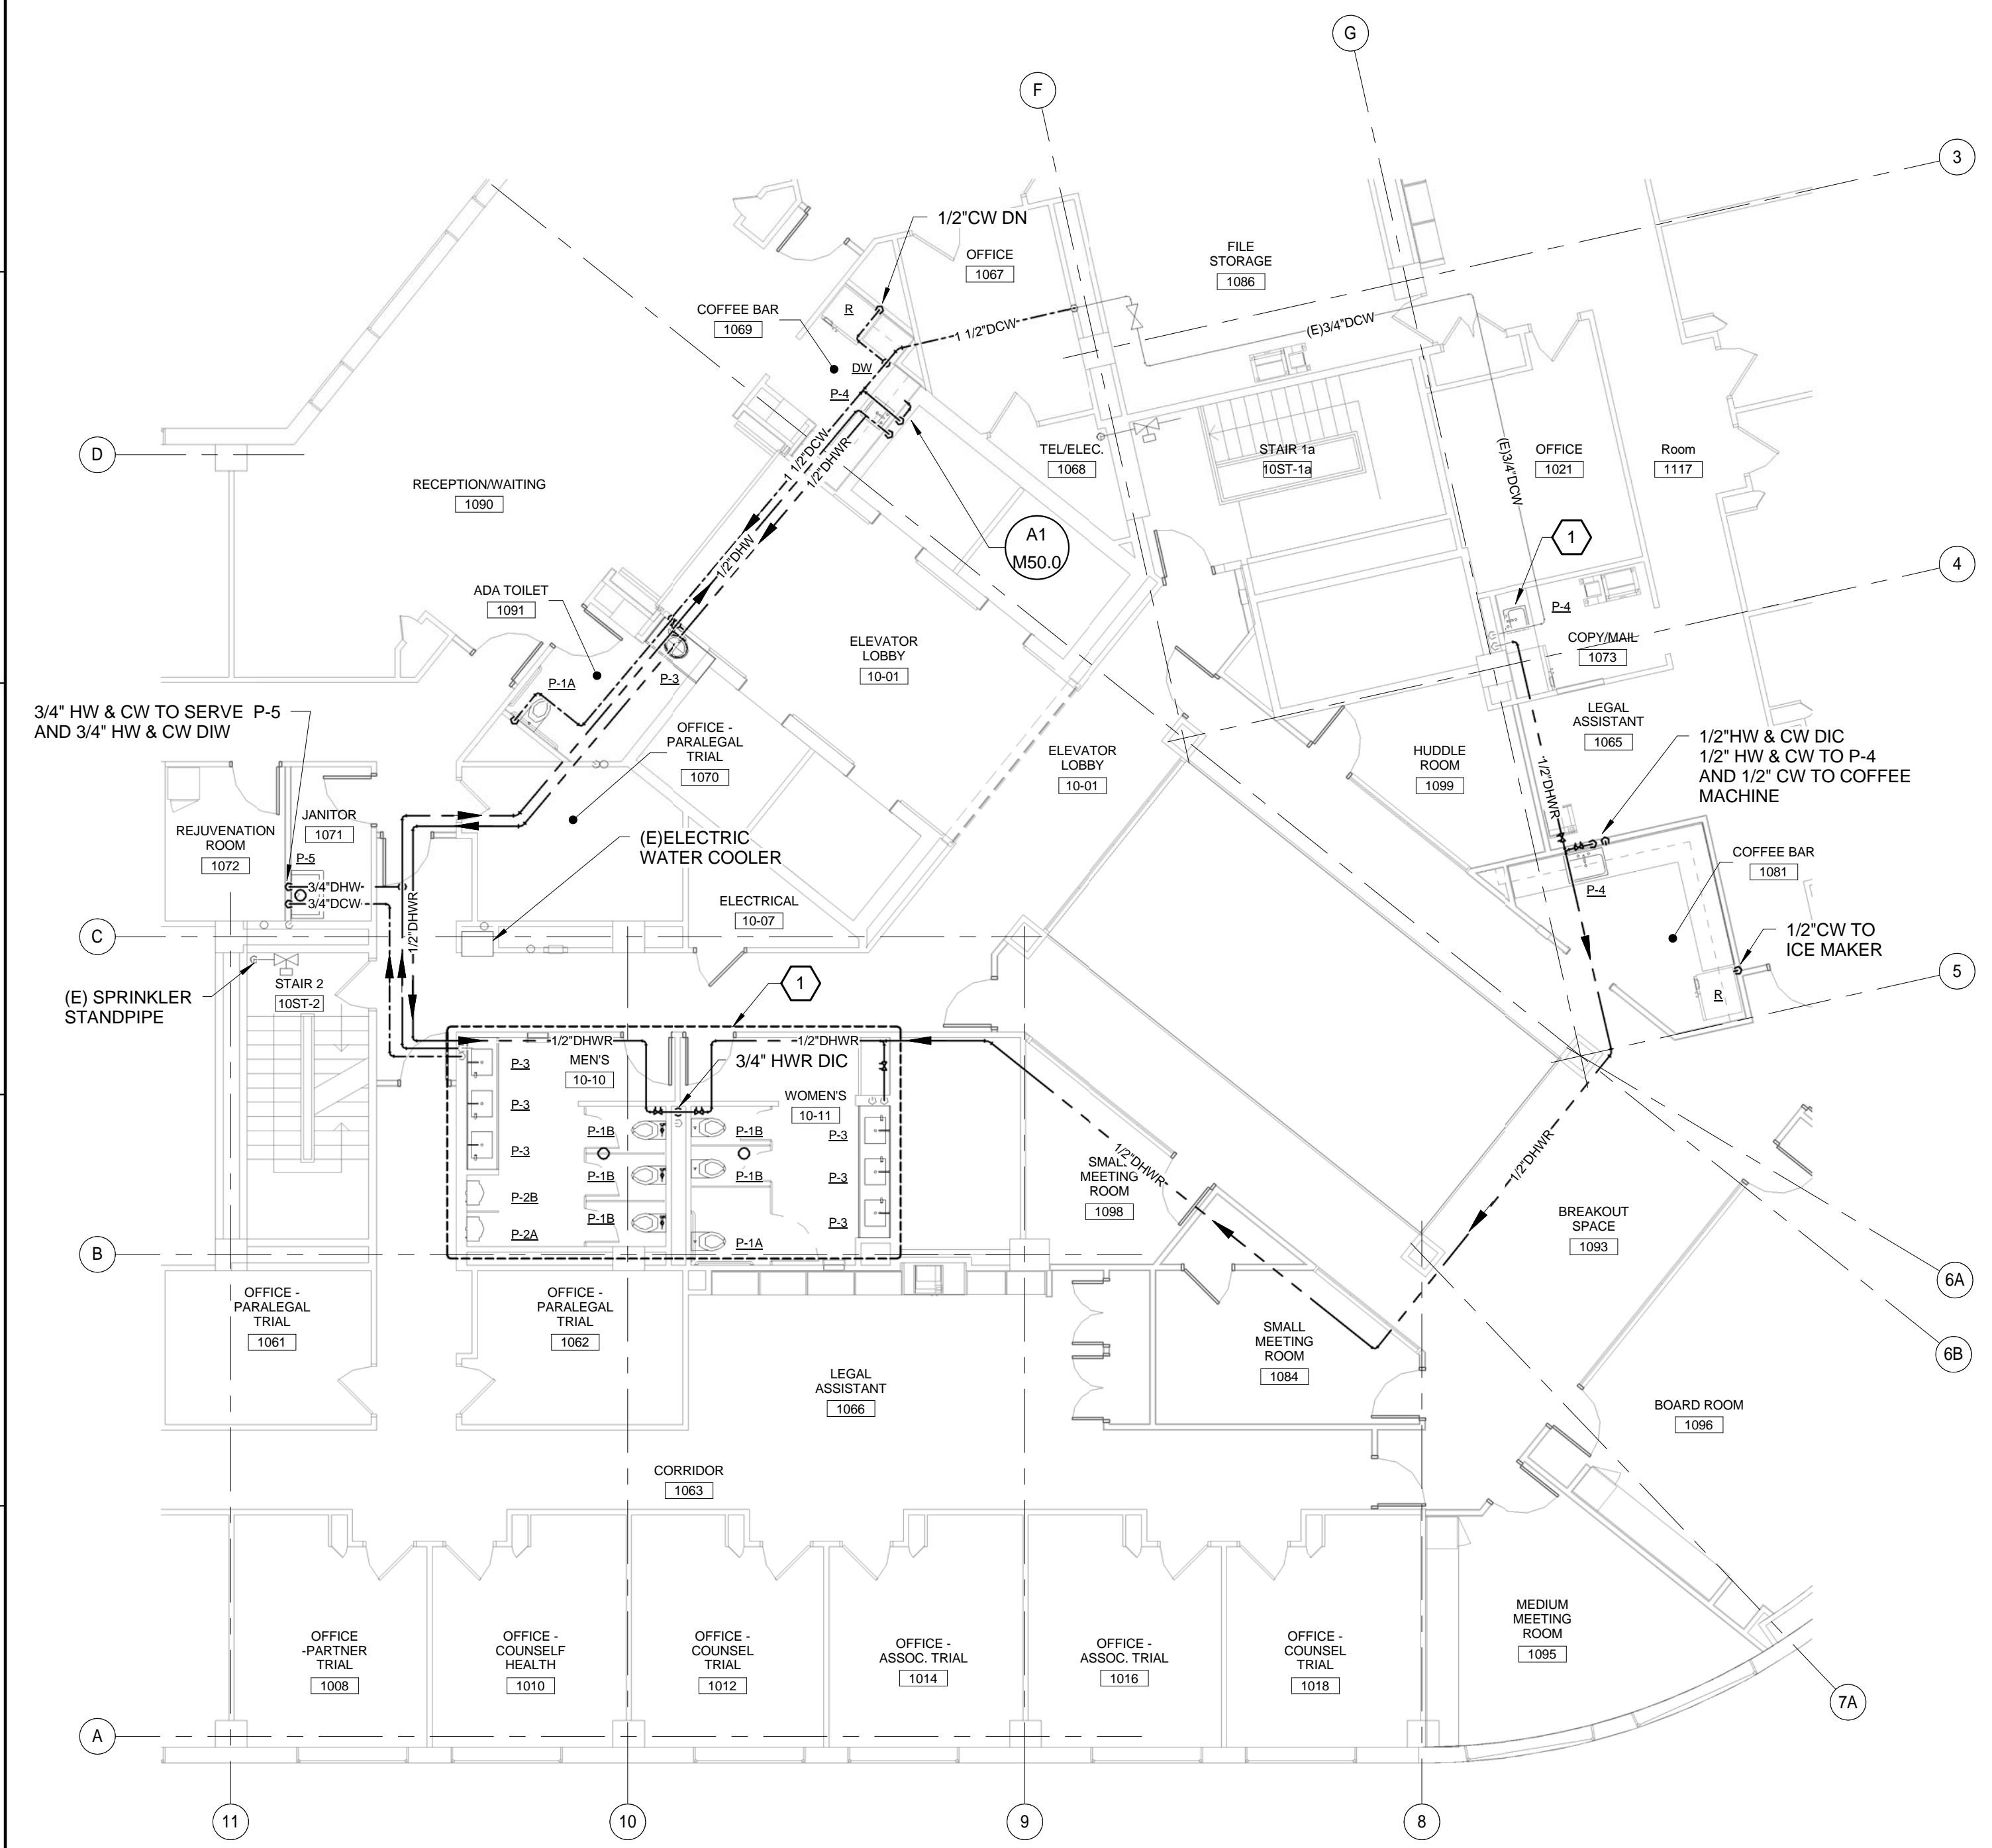

A1 TENTH FLOOR SUPPLY PLAN

1/8" = 1'-0"

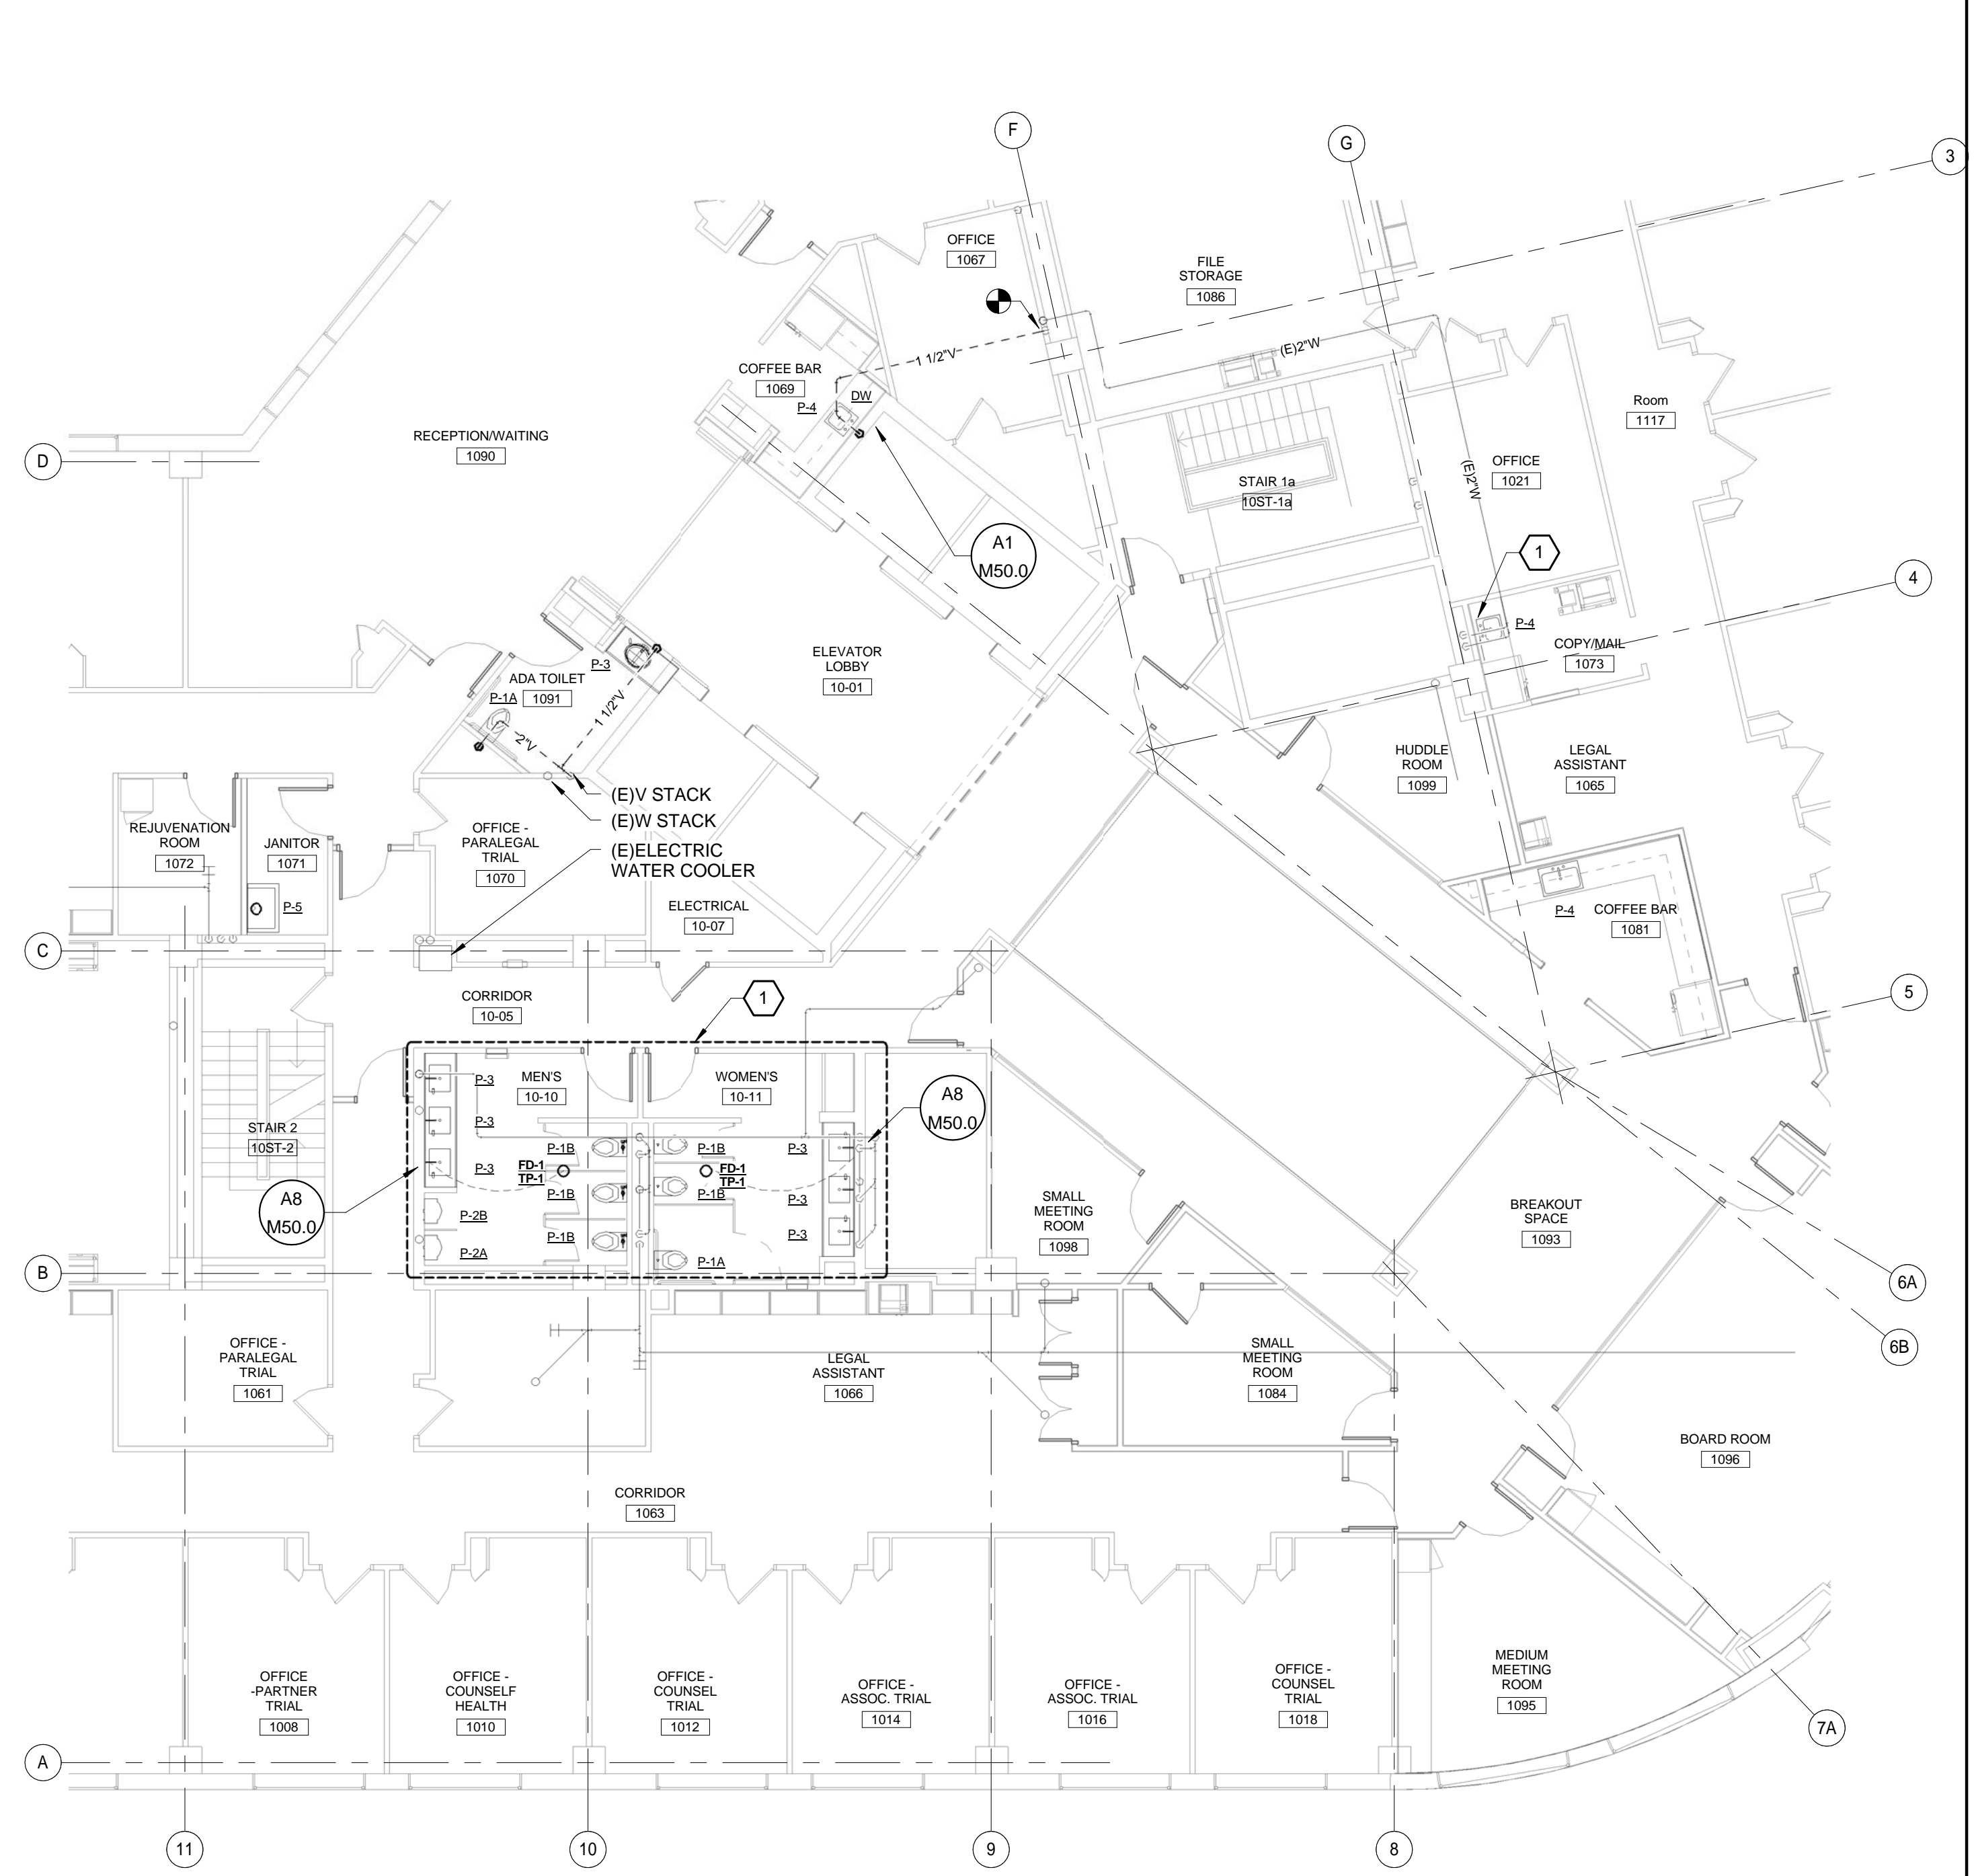

A6 TENTH FLOOR DRAINAGE PLAN

1/8" = 1'-0"