


E

D

C

B

A

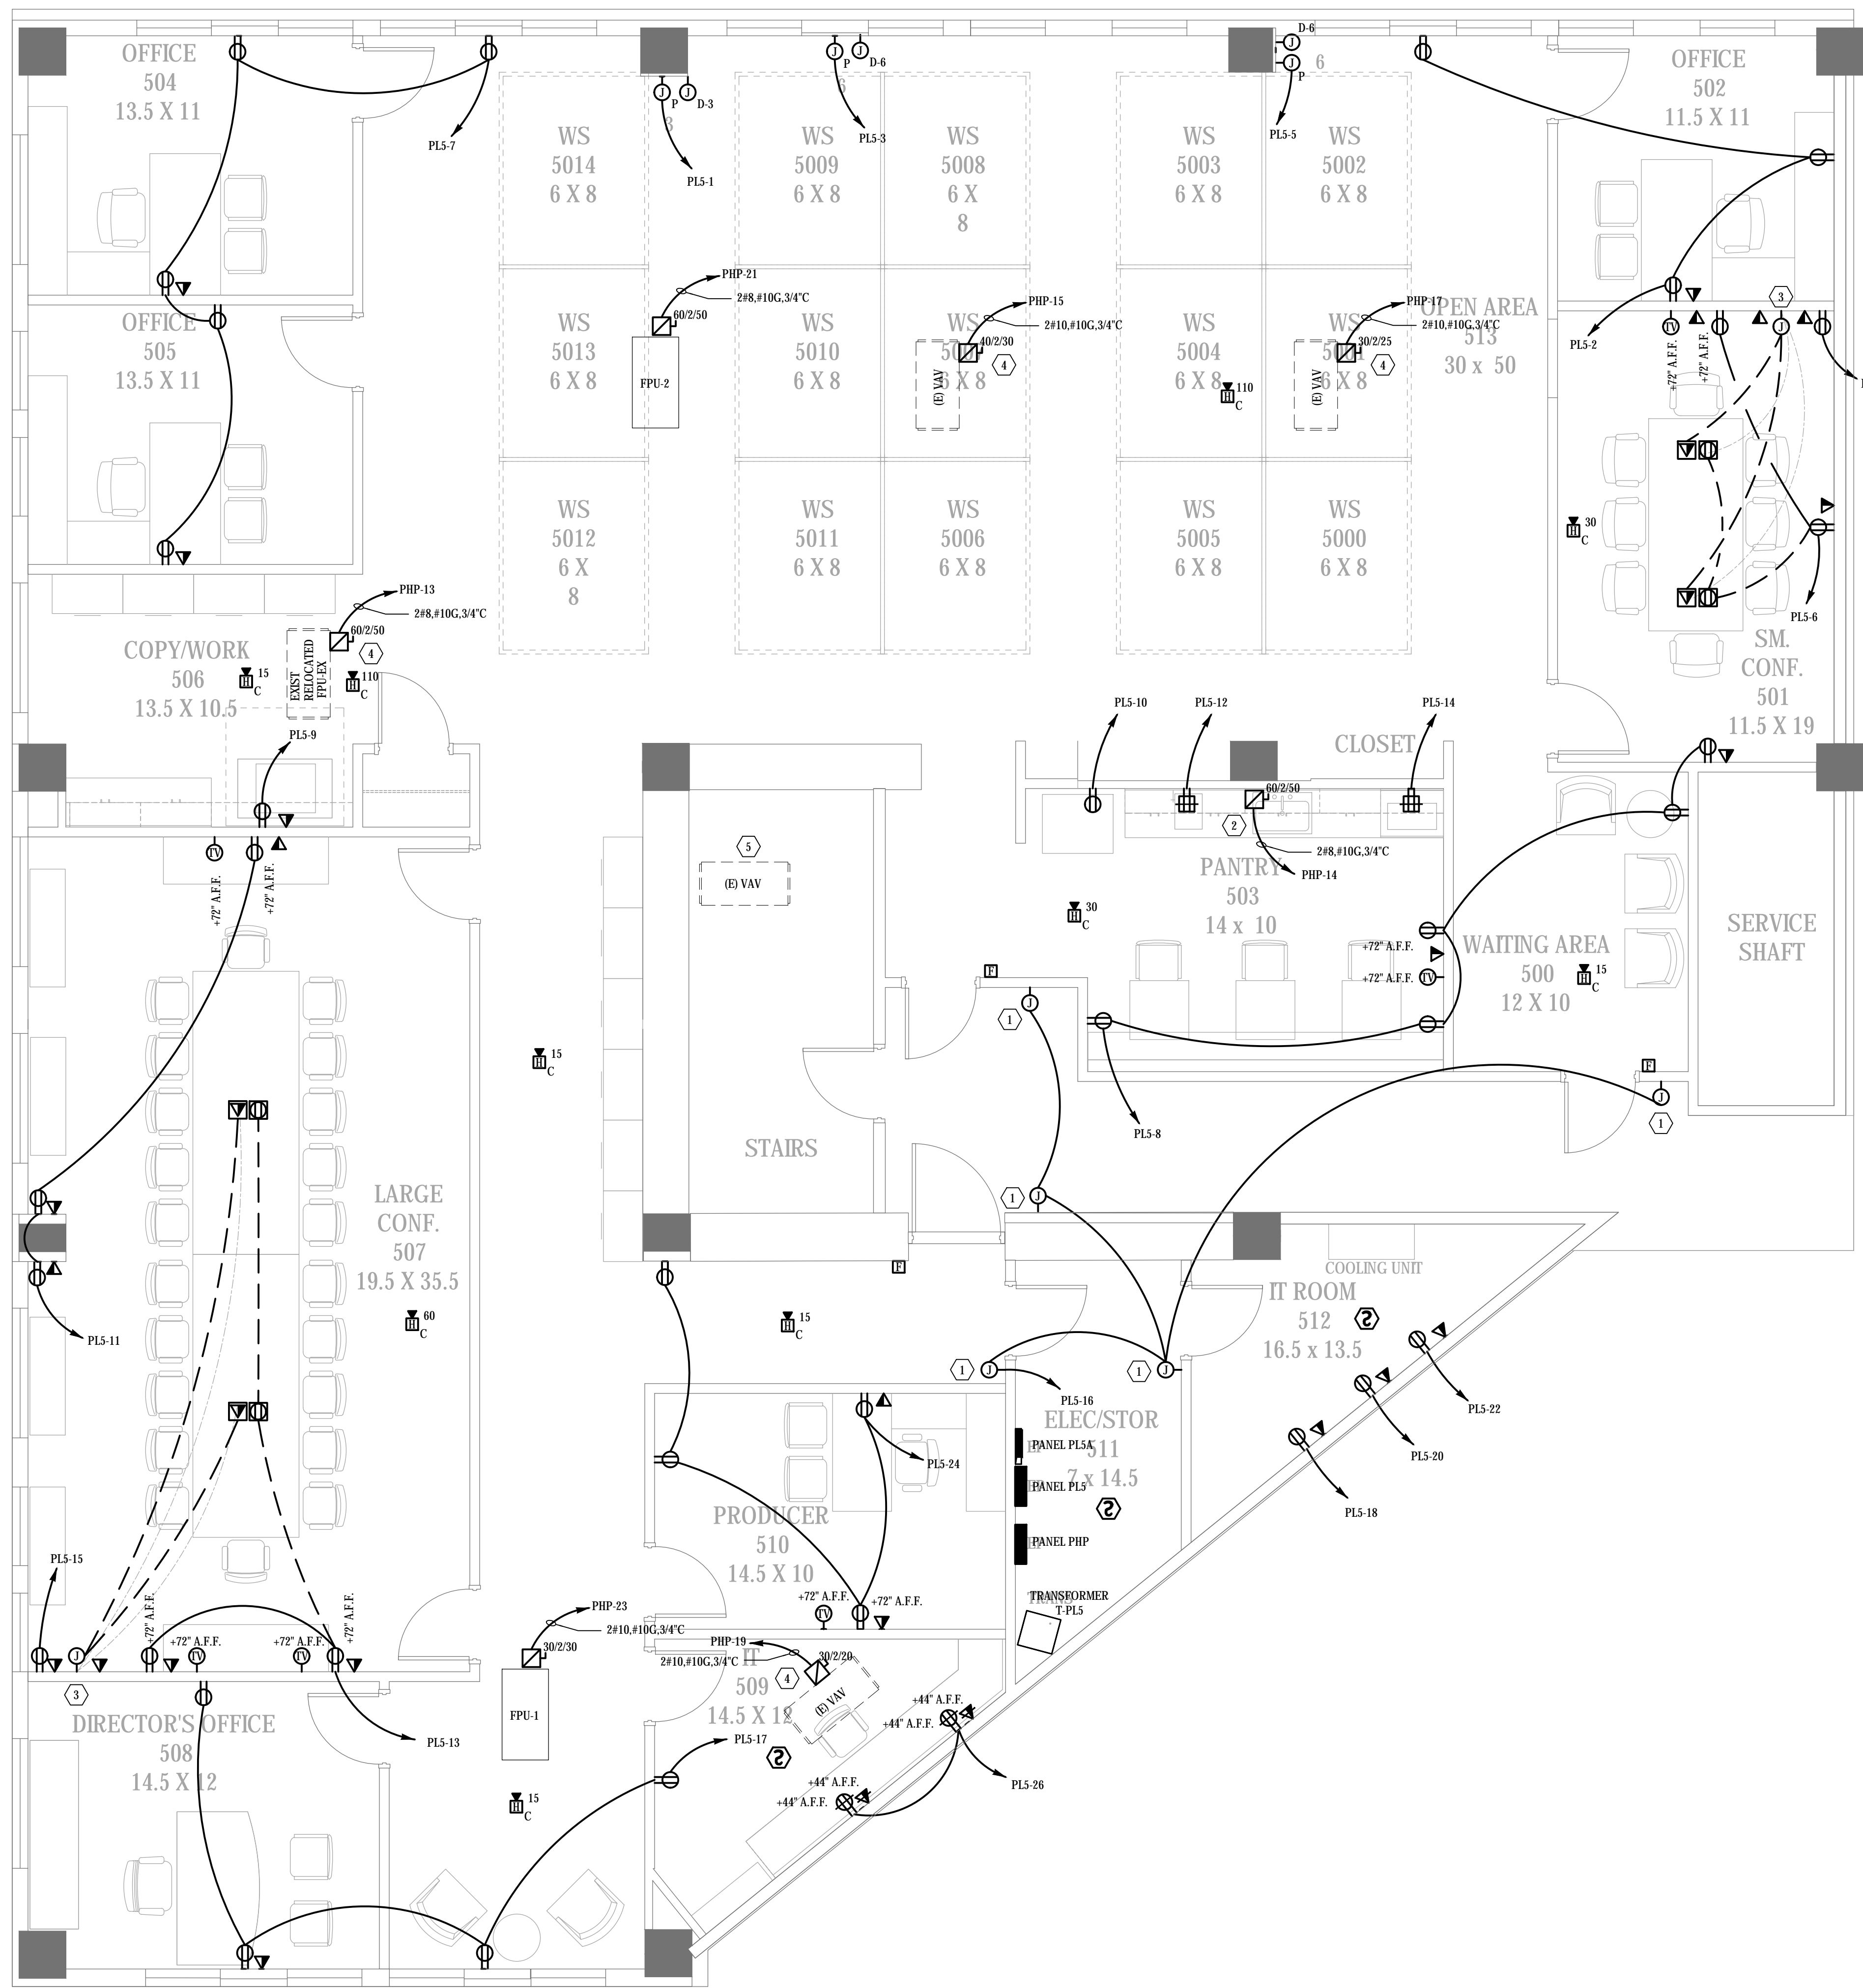

1 ELECTRICAL POWER FLOOR PLAN
 SCALE: 1/4" = 1'-0"

GENERAL NOTES:

1. ALL HVAC EQUIPMENT EXISTING TO REMAIN.
2. FIRE ALARM CONTROL PANEL IS LOCATED IN THE MAIN ELECTRICAL ROOM ON THE FIFTH FLOOR. CONNECT ALL FIRE ALARM DEVICES BACK TO THIS PANEL FOR PROPER OPERATION.
3. TELEPHONE BACKBOARD IS LOCATED IN THE MAIN ELECTRICAL ROOM ON THE FIFTH FLOOR.
4. ALL IN OR BELOW SLAB CONDUIT SHALL BE MINIMUM 1".

KEY NOTES: (DESIGNATED BY "#")

1. JUNCTION BOX FOR CARD READER.
2. DISCONNECT FOR WATER HEATER. COORDINATE EXACT LOCATION WITH PLUMBING CONTRACTOR.
3. PROVIDE 1" CONDUIT FROM UNDER CONFERENCE ROOM TABLE TO JUNCTION BOX ON WALL.
4. VAV BOX IS EXISTING. ELECTRICAL CONTRACTOR TO VERIFY EXISTING CIRCUITRY AND REROUTE CIRCUIT TO PANEL PHP WITHIN TENANT SPACE ELECTRICAL ROOM.
5. EXISTING PNEUMATIC VAV BOX.

THIS DOCUMENT HAS BEEN PREPARED BY PROGRESSIVE AS AN INSTRUMENT OF SERVICE AND PROGRESSIVE SHALL BE RESPONSIBLE FOR THE ACCURACY OF THE INFORMATION CONTAINED HEREIN. PROGRESSIVE SHALL NOT BE RESPONSIBLE FOR THE ACCURACY OF THE INFORMATION CONTAINED HEREIN. PROGRESSIVE SHALL NOT BE RESPONSIBLE FOR THE ACCURACY OF THE INFORMATION CONTAINED HEREIN.

If this document is sealed and signed by a professional engineer, it shall be deemed to be a true and correct copy of the original. The professional engineer shall be responsible for the accuracy of the information contained herein. The professional engineer shall not be responsible for the accuracy of the information contained herein.

ISSUANCES
 ISSUED FOR CONSTRUCTION
 2017-12-28

REVISIONS
 NO. DATE DESCRIPTION