


#KEYED NOTES


- ① LIMIT OF HVAC SCOPE
- ② 12x8 TRANSFER DUCT WITH W.A.S.
- ③ EXISTING VAV BOX
- ④ INSTAL VOLUME DAMPER
- ⑤ RELOCATED EXISTING VAV BOX REMOTE TEMPERATURE SENSOR LOCATION
- ⑥ 6" FLEX DUCT SHALL BE EXTENDED TO CONNECT TO NEW 2'x2' SUPPLY DIFFUSER
- ⑦ CONNECT TO EXISTING

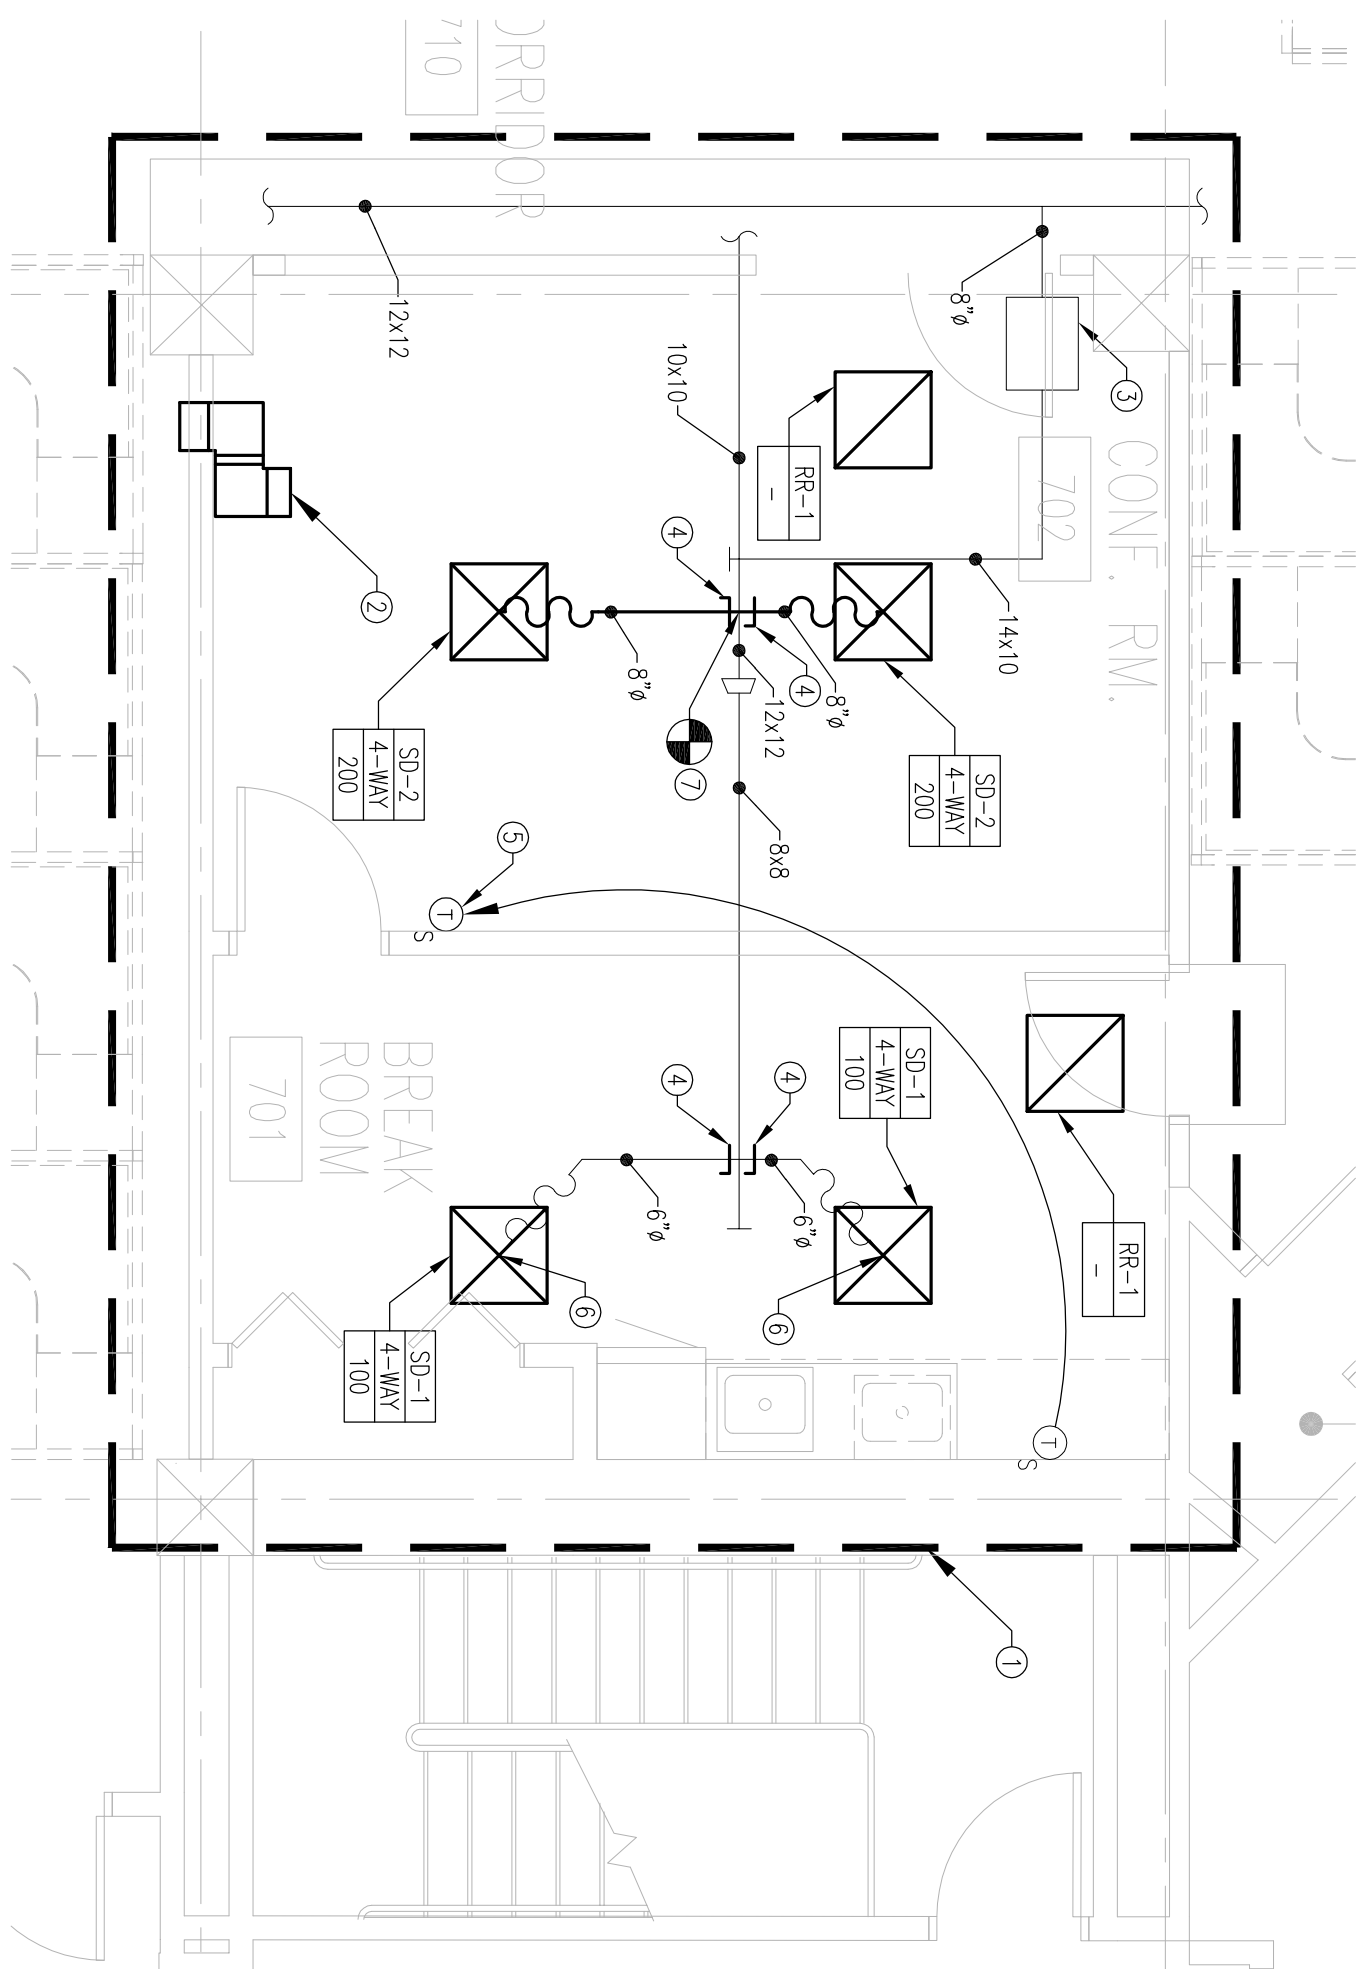

2 7TH FLOOR PLAN - HVAC
SCALE: 1/4"=1'-0"

#KEYED NOTES

- ① LIMIT OF HVAC SCOPE
- ② EXISTING VAV BOX TO REMAIN
- ③ COMBINATION SUPPLY DIFFUSER & LIGHT TO BE DEMOLISHED
- ④ COMBINATION RETURN REGISTER & LIGHT TO BE DEMOLISHED
- ⑤ RELOCATE EXISTING REMOTE TEMPERATURE SENSOR
- ⑥ DEMO TO LIMITS SHOWN
- ⑦ CAP DUCT


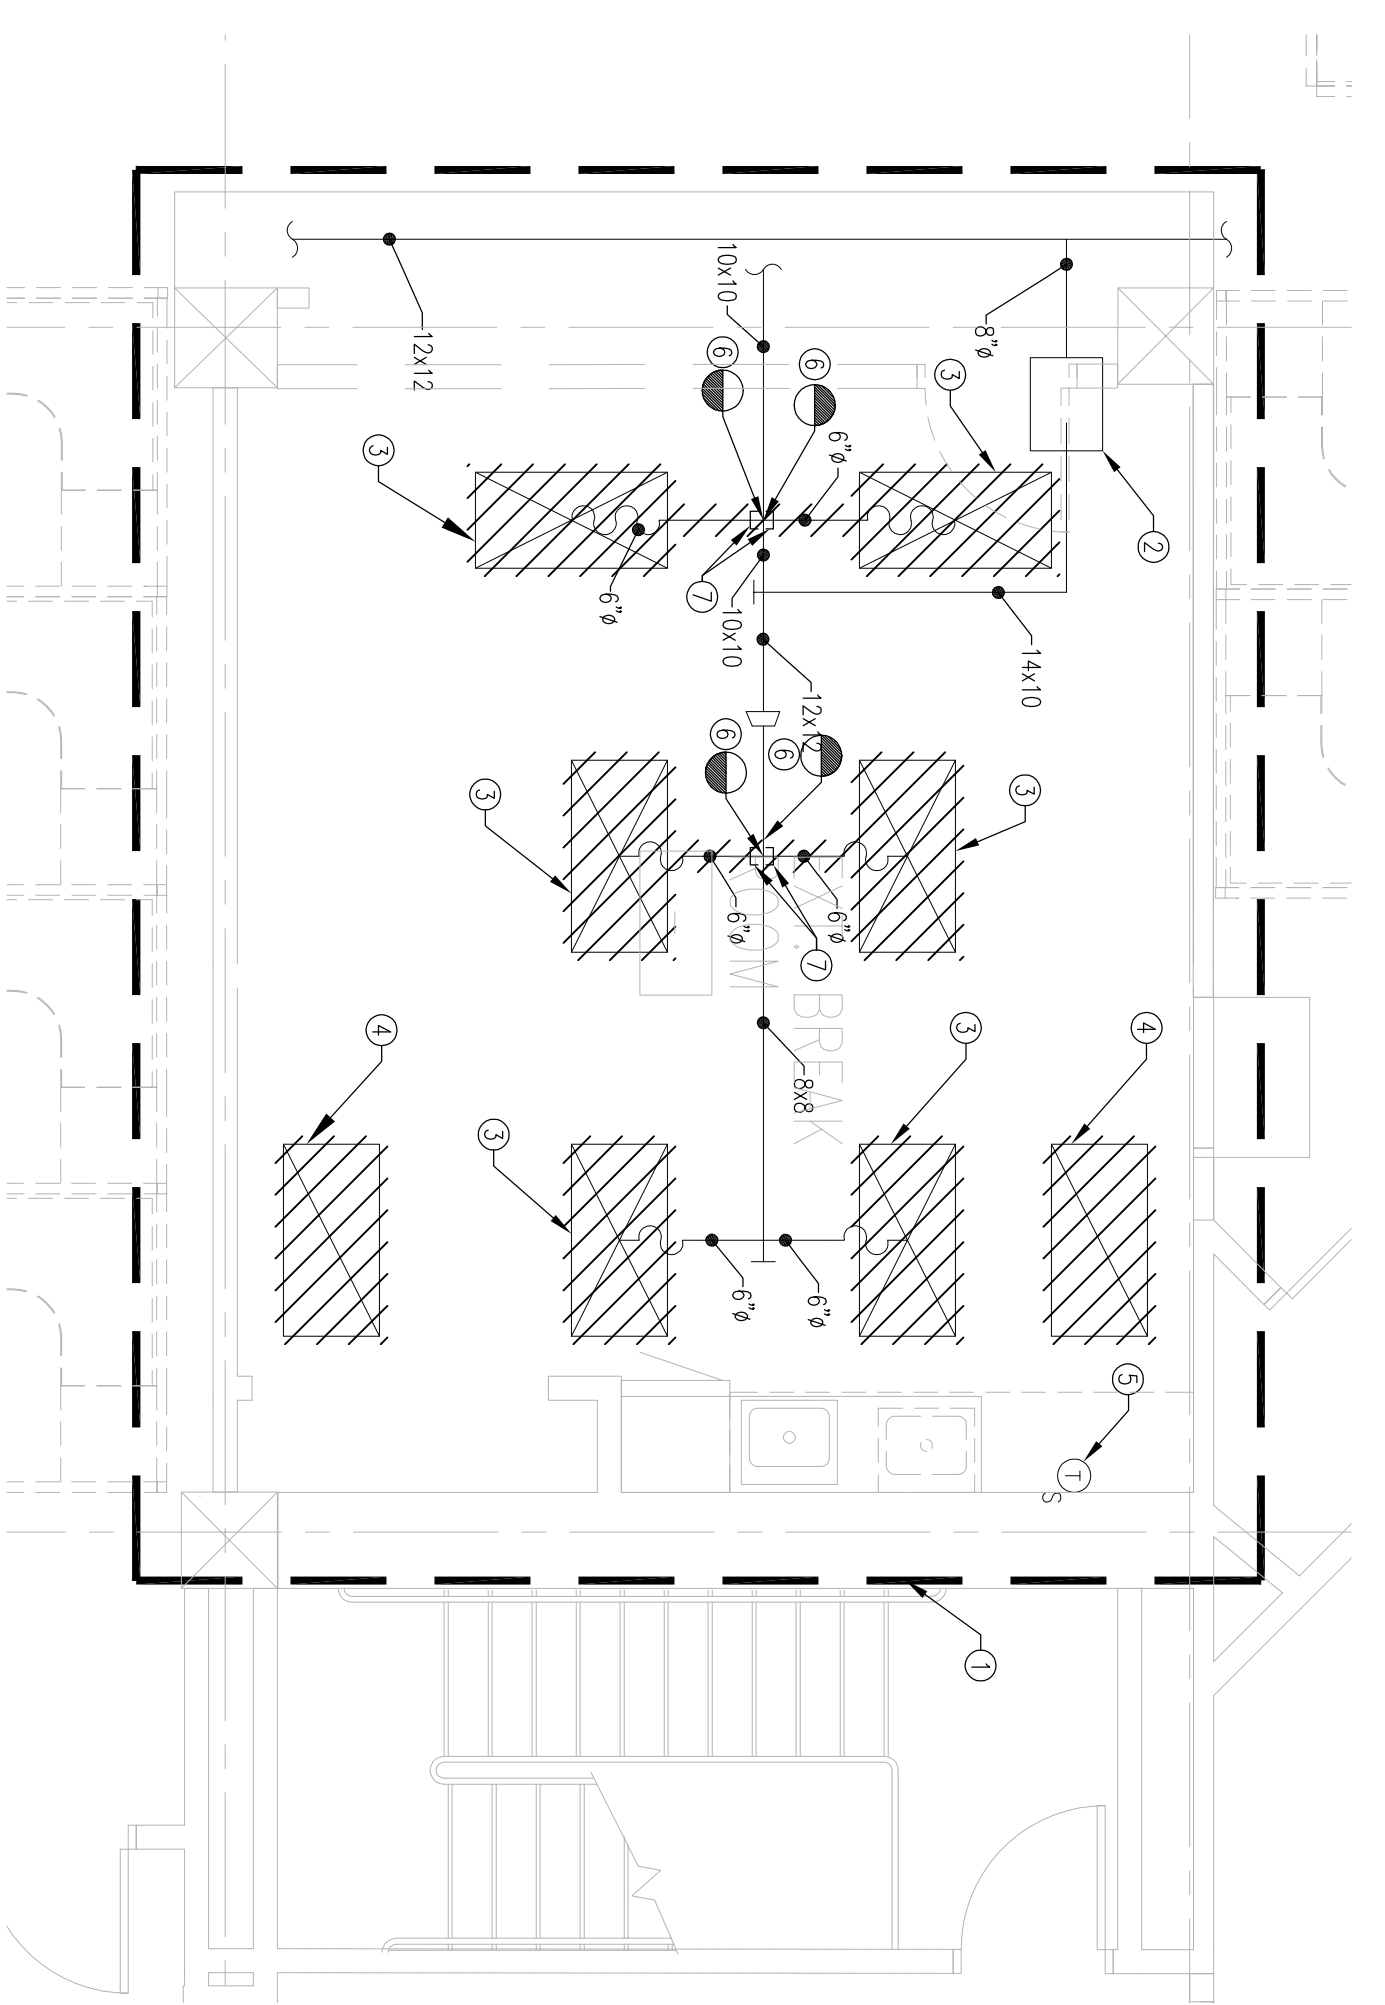


1 7TH FLOOR PLAN - DEMO HVAC
SCALE: 1/4"=1'-0"

REGISTER & DIFFUSER SCHEDULE

TAG NO.	SERVICE/ LOCATION	CFM RANGE	TYPE	BLOW INLET SIZE (IN.)	OVERALL SIZE (IN.)	MATERIAL	MAX. P.D.	MAX. N.C.	MANUFACTURER	MODEL NO.	REMARKS
SD-1	SEE PLANS	0-100	CEILING SUPPLY DIFFUSER	SEE PLANS	6ø	STEEL	.041	-	TTUS	TMS	4-WAY
SD-2	SEE PLANS	101-250	CEILING SUPPLY DIFFUSER	SEE PLANS	8ø	STEEL	.041	11	TTUS	TMS	4-WAY
RR-1	SEE PLANS	0-2000	EGS CRANE	SEE PLANS	24x24	STEEL	0.1	<20	TTUS	SOF	1" BORDER-LAY IN CEILING APPLICATION WITH SQUARE TO ROUND NECK

LEGEND

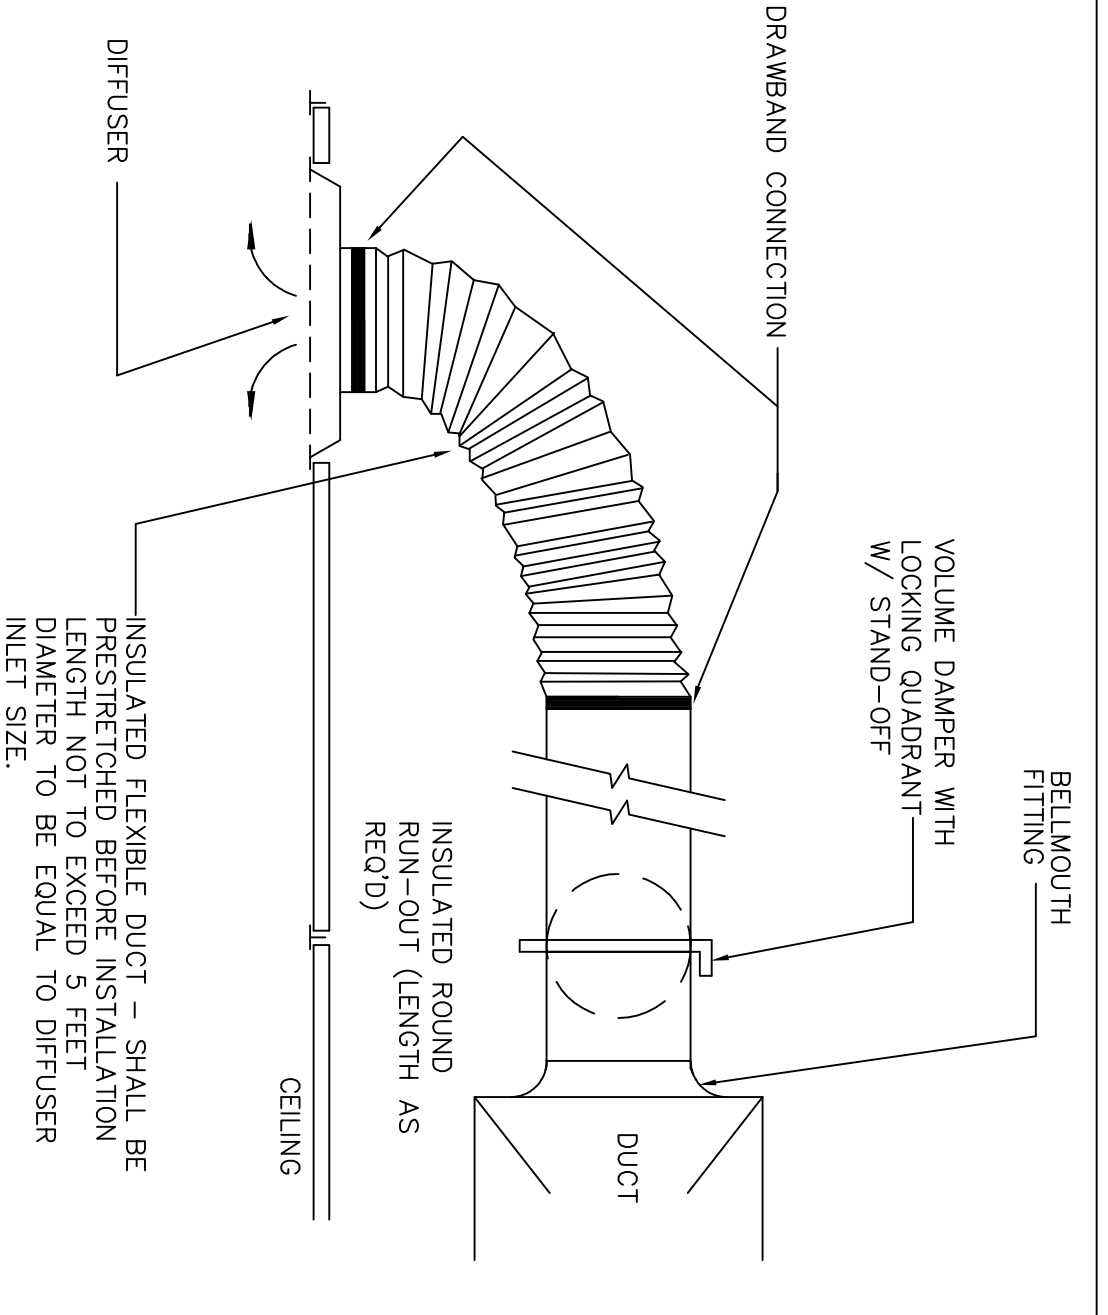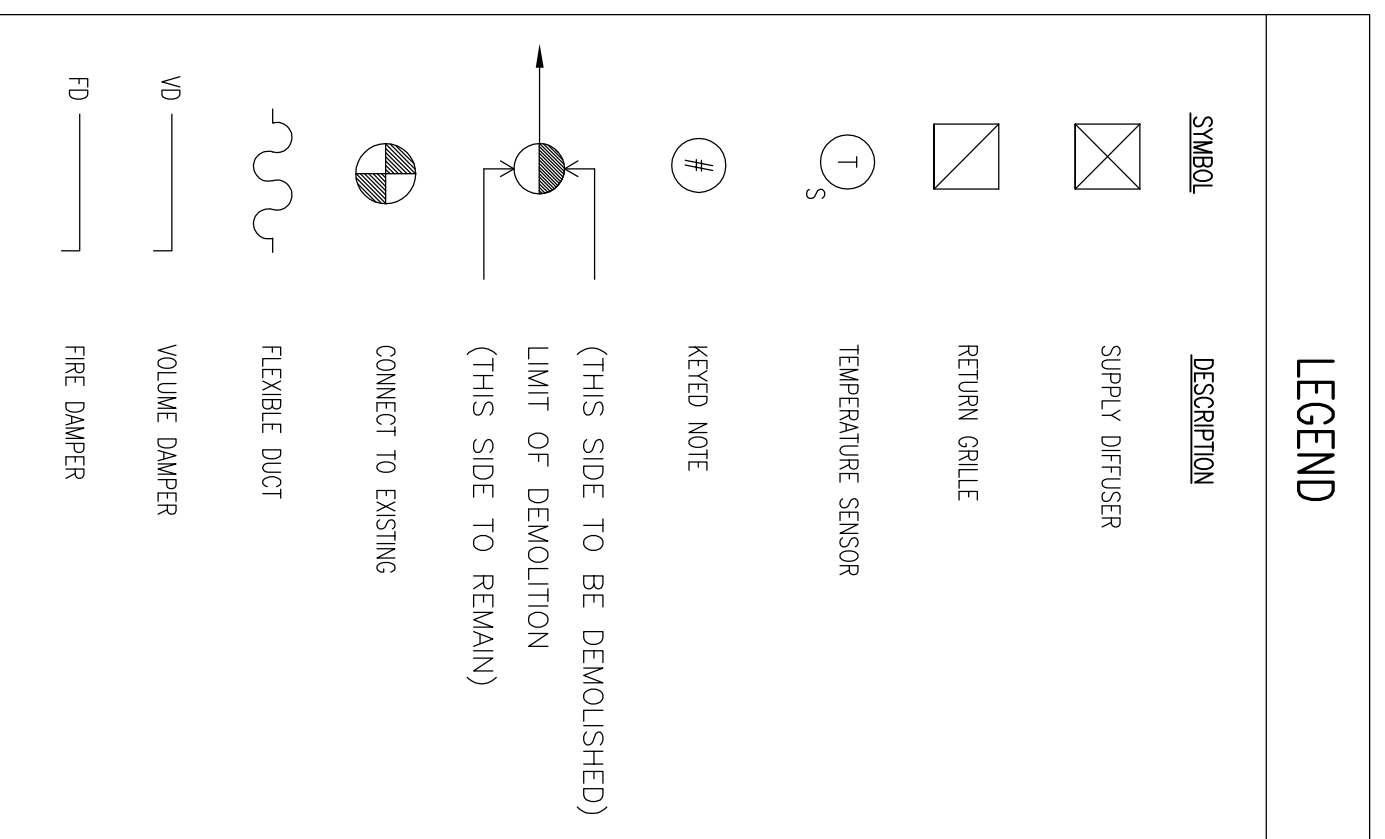

1 TYPICAL DIFFUSER TAKEOFF
SCALE: NONE

7TH FLOOR PLAN, SCHEDULE, LEGEND, & DETAILS

SCALE AS NOTED
DRAWN BY MGR
CHECKED BY
PROJ. ARCH./ ENGR. AAB/MOB
PROJ. MGR. SMD
JOB NO. 09095V 09063.01
SWANES MAINI & MCKEE ASSOCIATES, INC. 2010

M1.02

1 2/5/2010 PERMIT SET
NO. DATE DESCRIPTION
ISSUE LOG
Δ = CLOUED CHANGE
TD BANK
TENANT RENOVATION
1 PORTLAND SQUARE
CAMBRIDGE, MASS 02111