


3 ROD CONNECTIONS
ONTO STEEL CHANNEL
(TYPICAL)

FABRICATED ALUMINUM CABINET PAINTED PMS #341 GREEN, ILLUMINATED ACRYLIC SIGN FACES ON BLEED FRAME RETAINER SYSTEM TO HAVE TRANSLUCENT GREEN BACKGROUND TO MATCH PMS #341 WITH ALL LOGOS BEING NON-ILLUMINATED ALUMINUM PANELS PAINTED #341 GREEN.

TOP OF CABINET IS COMPLETELY COVERED AND SEALED AGAINST WEATHER.

EXISTING STEEL CHANNEL SPANNING BETWEEN COLUMNS. THIS STRUCTURE SUPPORTS THE ROOF ABOVE.

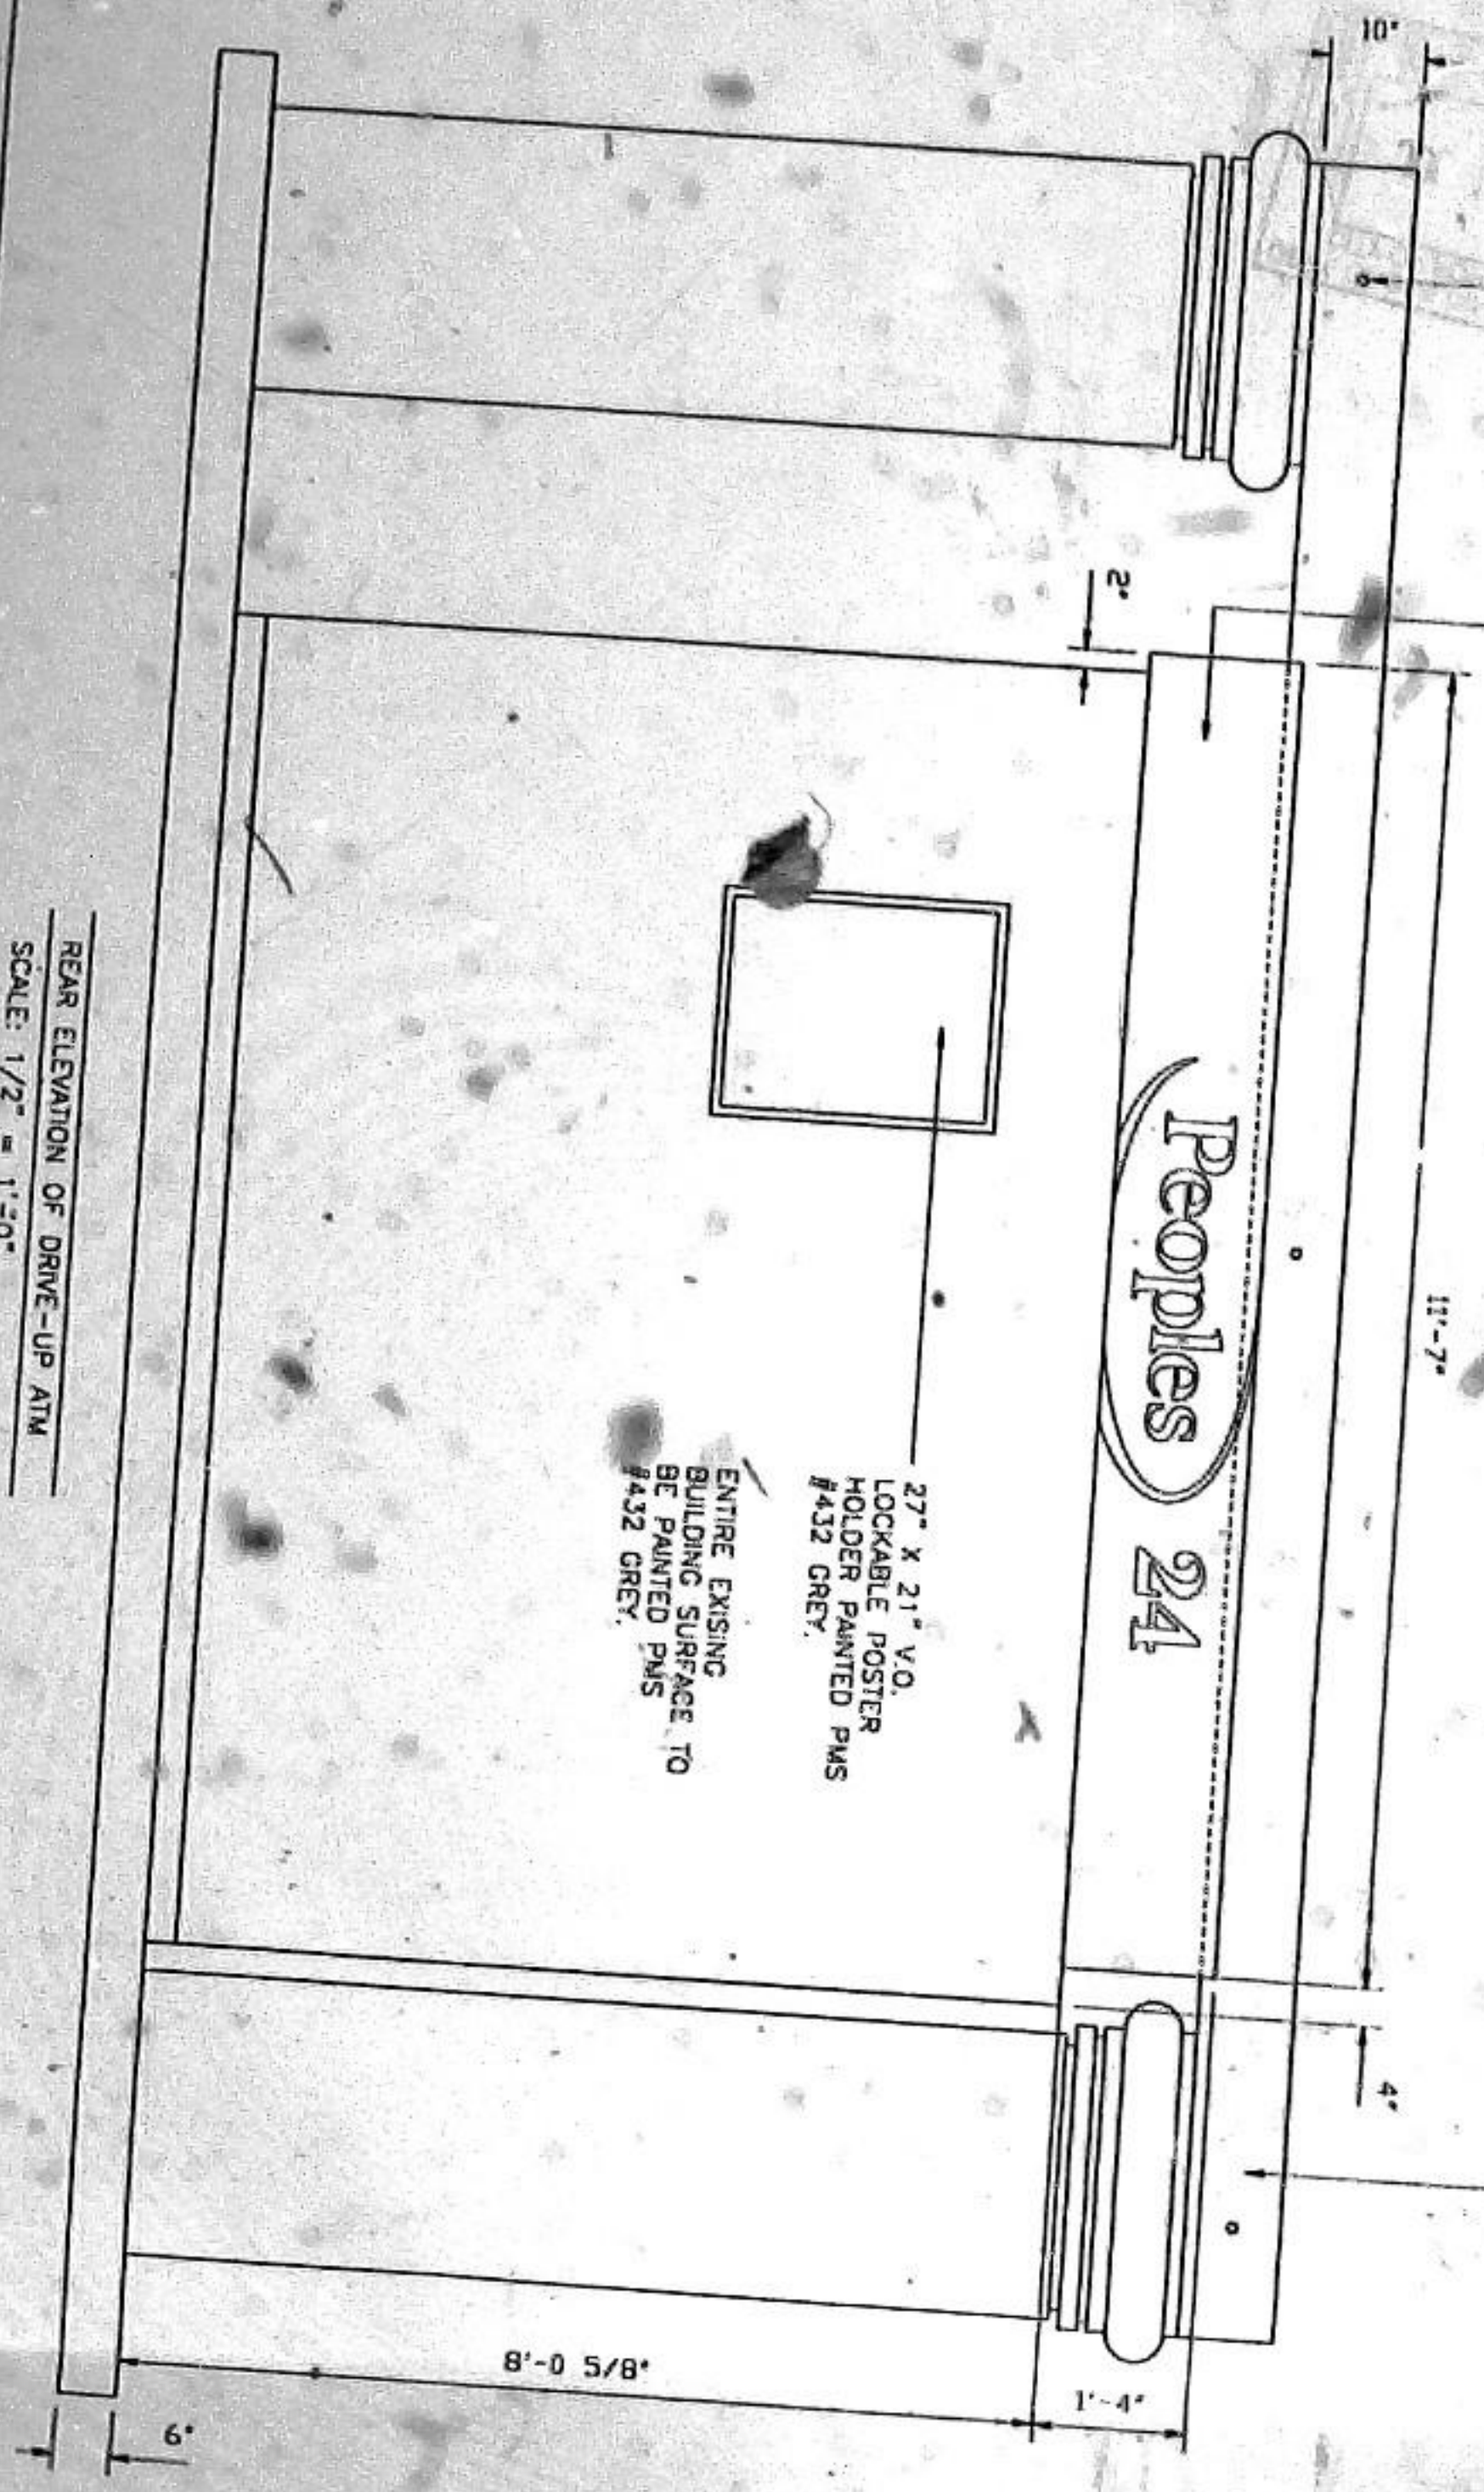

REAR ELEVATION OF DRIVE-UP ATM
SCALE: 1/2" = 1'-0"

DATE	2/5/98	SCALE	1/2"=1'-0"	REVISION		DATE
CLEAR RPA		ADDRESS	845 S. GRANT AVE			
CITY	COLUMBUS	STATE	OHIO			
SALVATION	TO PEENA	ISSUED	11	APP'D		
DATE		DATE				

PROJECT: REPAIRS BANK DRIVE-UP ATM ON WESTLAND SQUARE EASTLAND, MAINE

1997 S. 1000 NORTH COLUMBUS, OHIO 43261 TEL: 614.762.1000