




PLUMBING PLAN
SCALE - 1/4" = 1'-0"

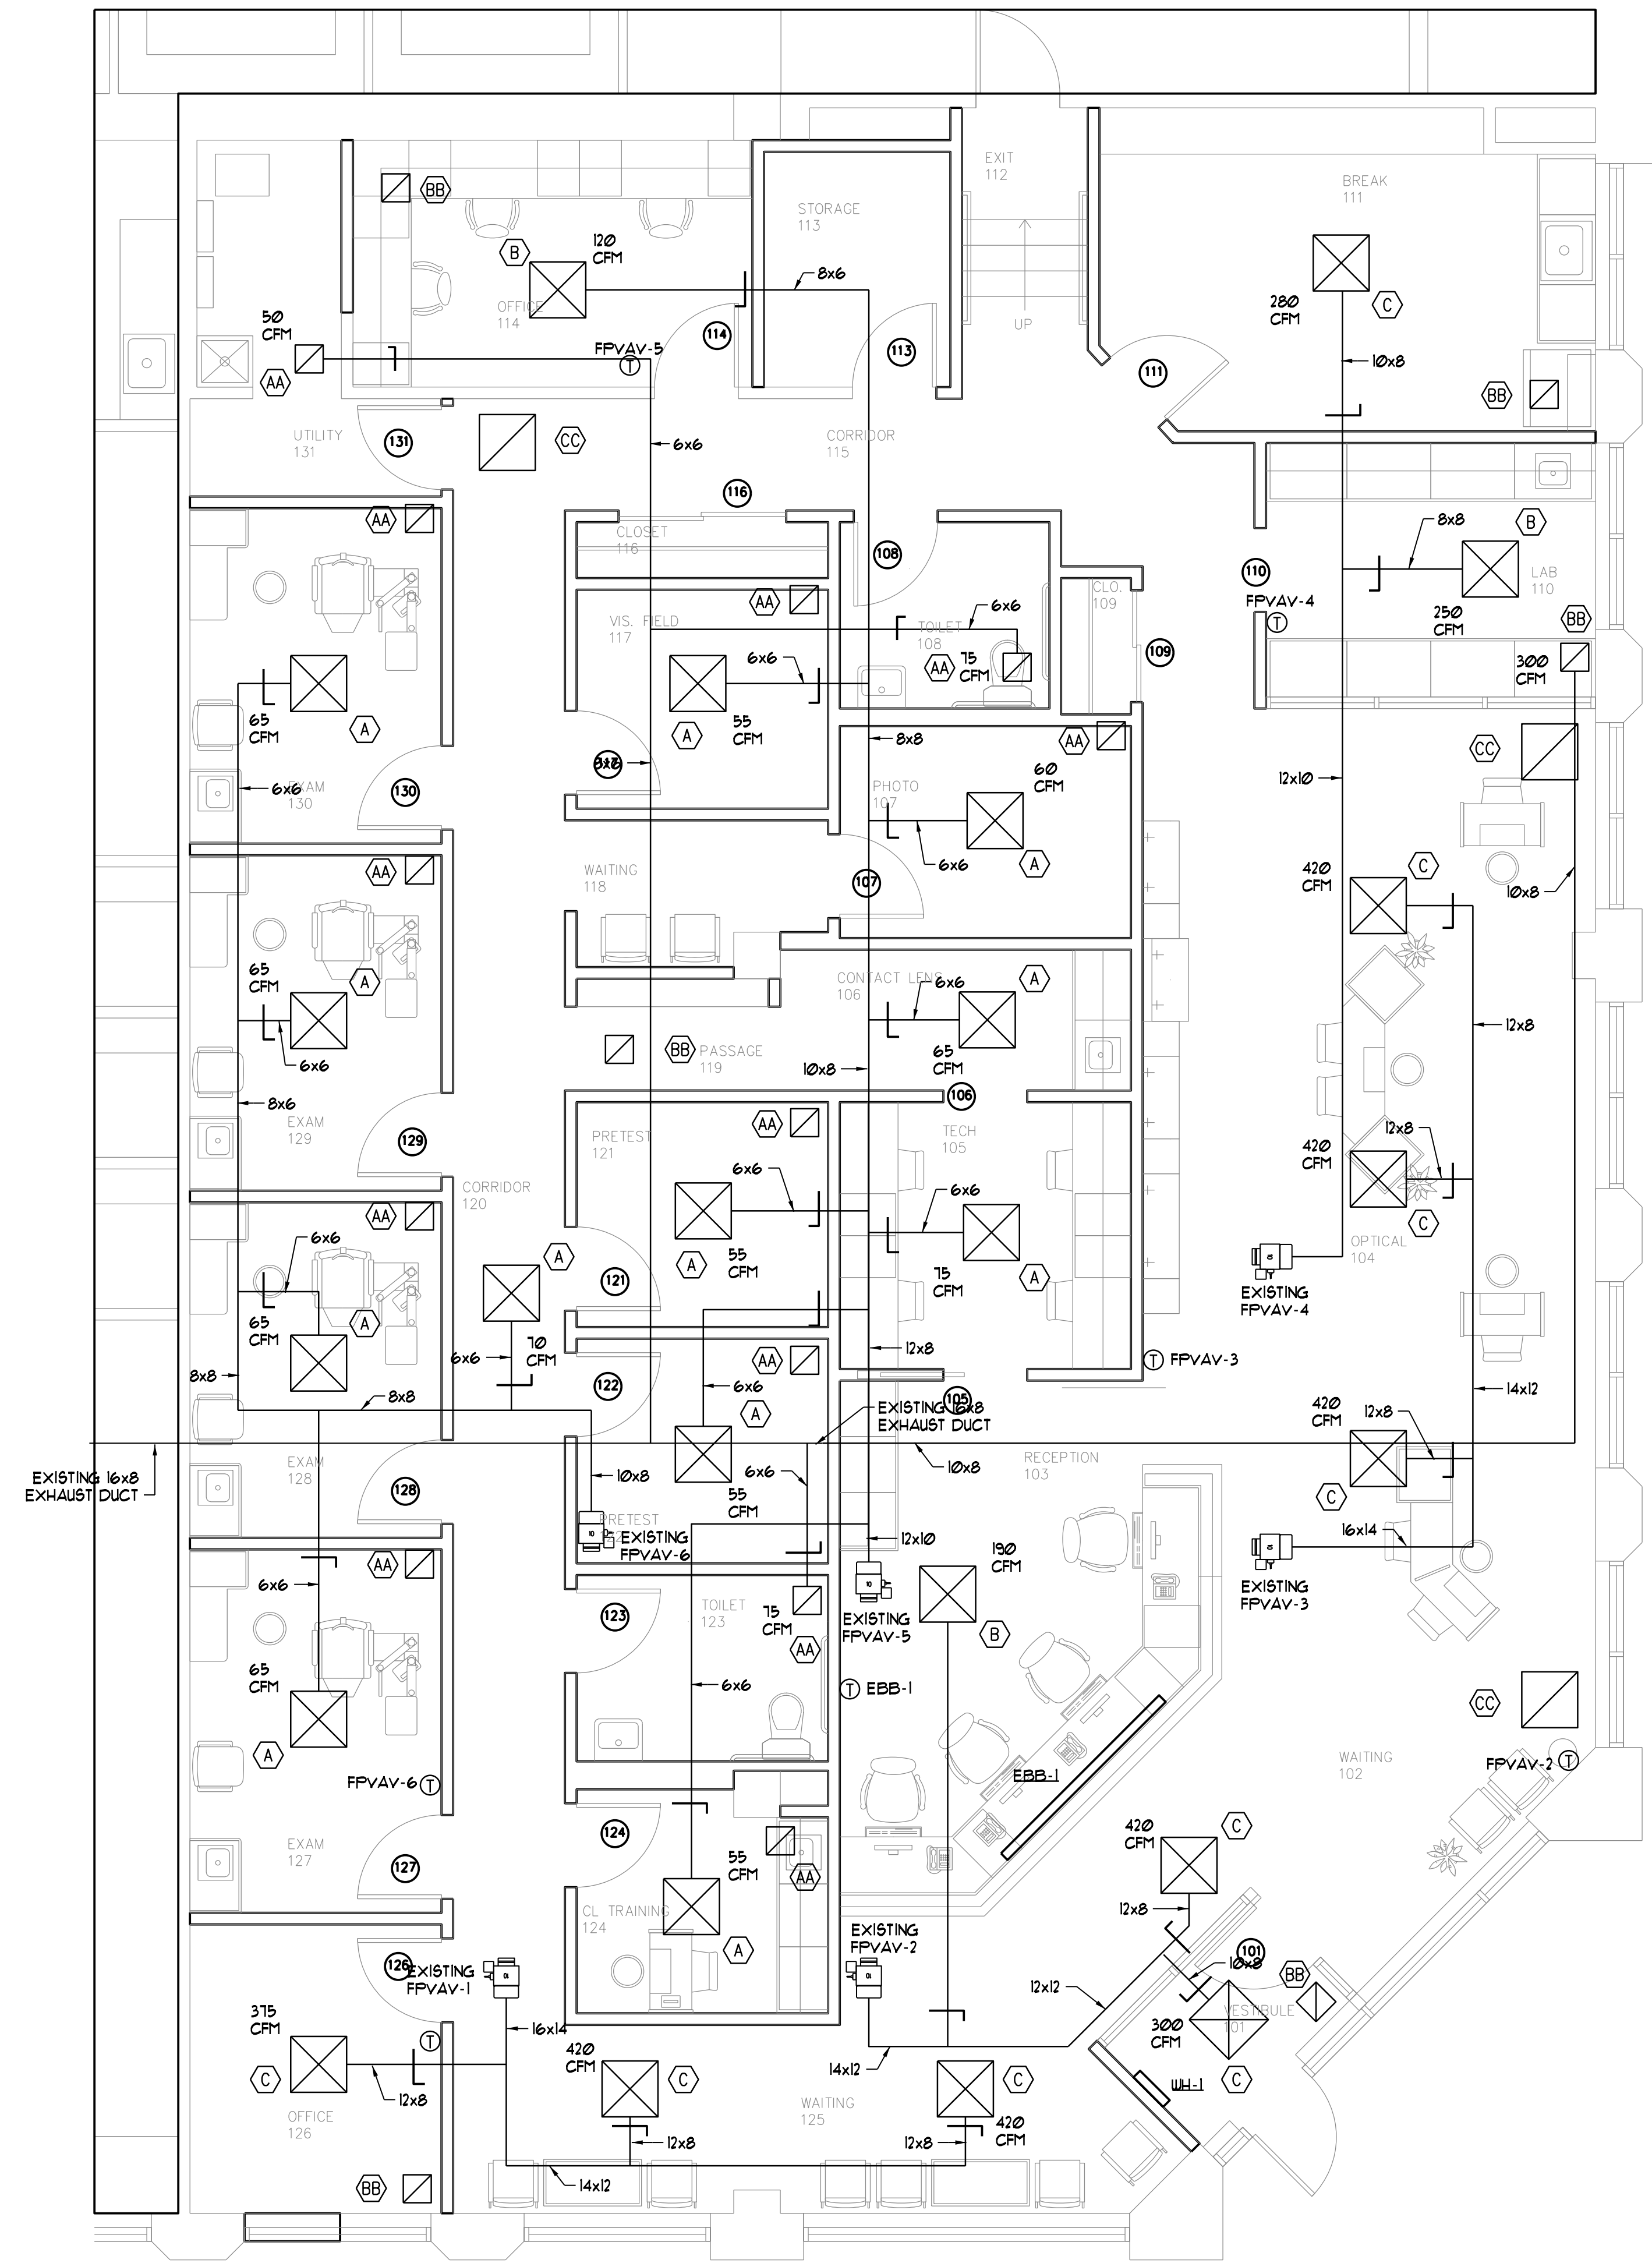

MECHANICAL PLAN
SCALE - 1/4" = 1'-0"

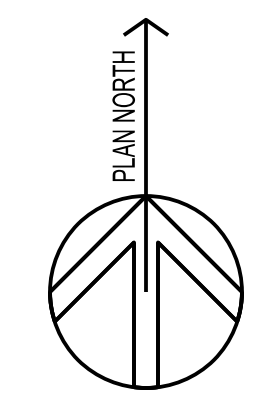

Michael Charek Architects
25 Hartley Street
Portland, Maine 04103
(207) 761-0556

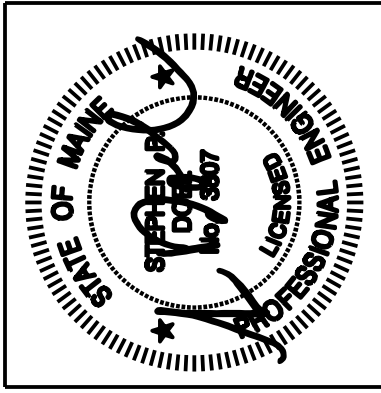

Offices for Casco Bay Eyecare
2 Portland Square
Portland, ME 04101

Title
MECHANICAL PLAN

Scale: 1/4" = 1'-0"

Date:

Revisions
1. 09/09/15 CD SUBMISSION

Sheet
M1