





LIGHTING PLAN

CONTRACTOR SHALL REFER TO ARCHITECTURAL REFLECTED CEILING PLAN FOR ALL CEILING MOUNTED ITEMS PRIOR TO ROUGH-IN.

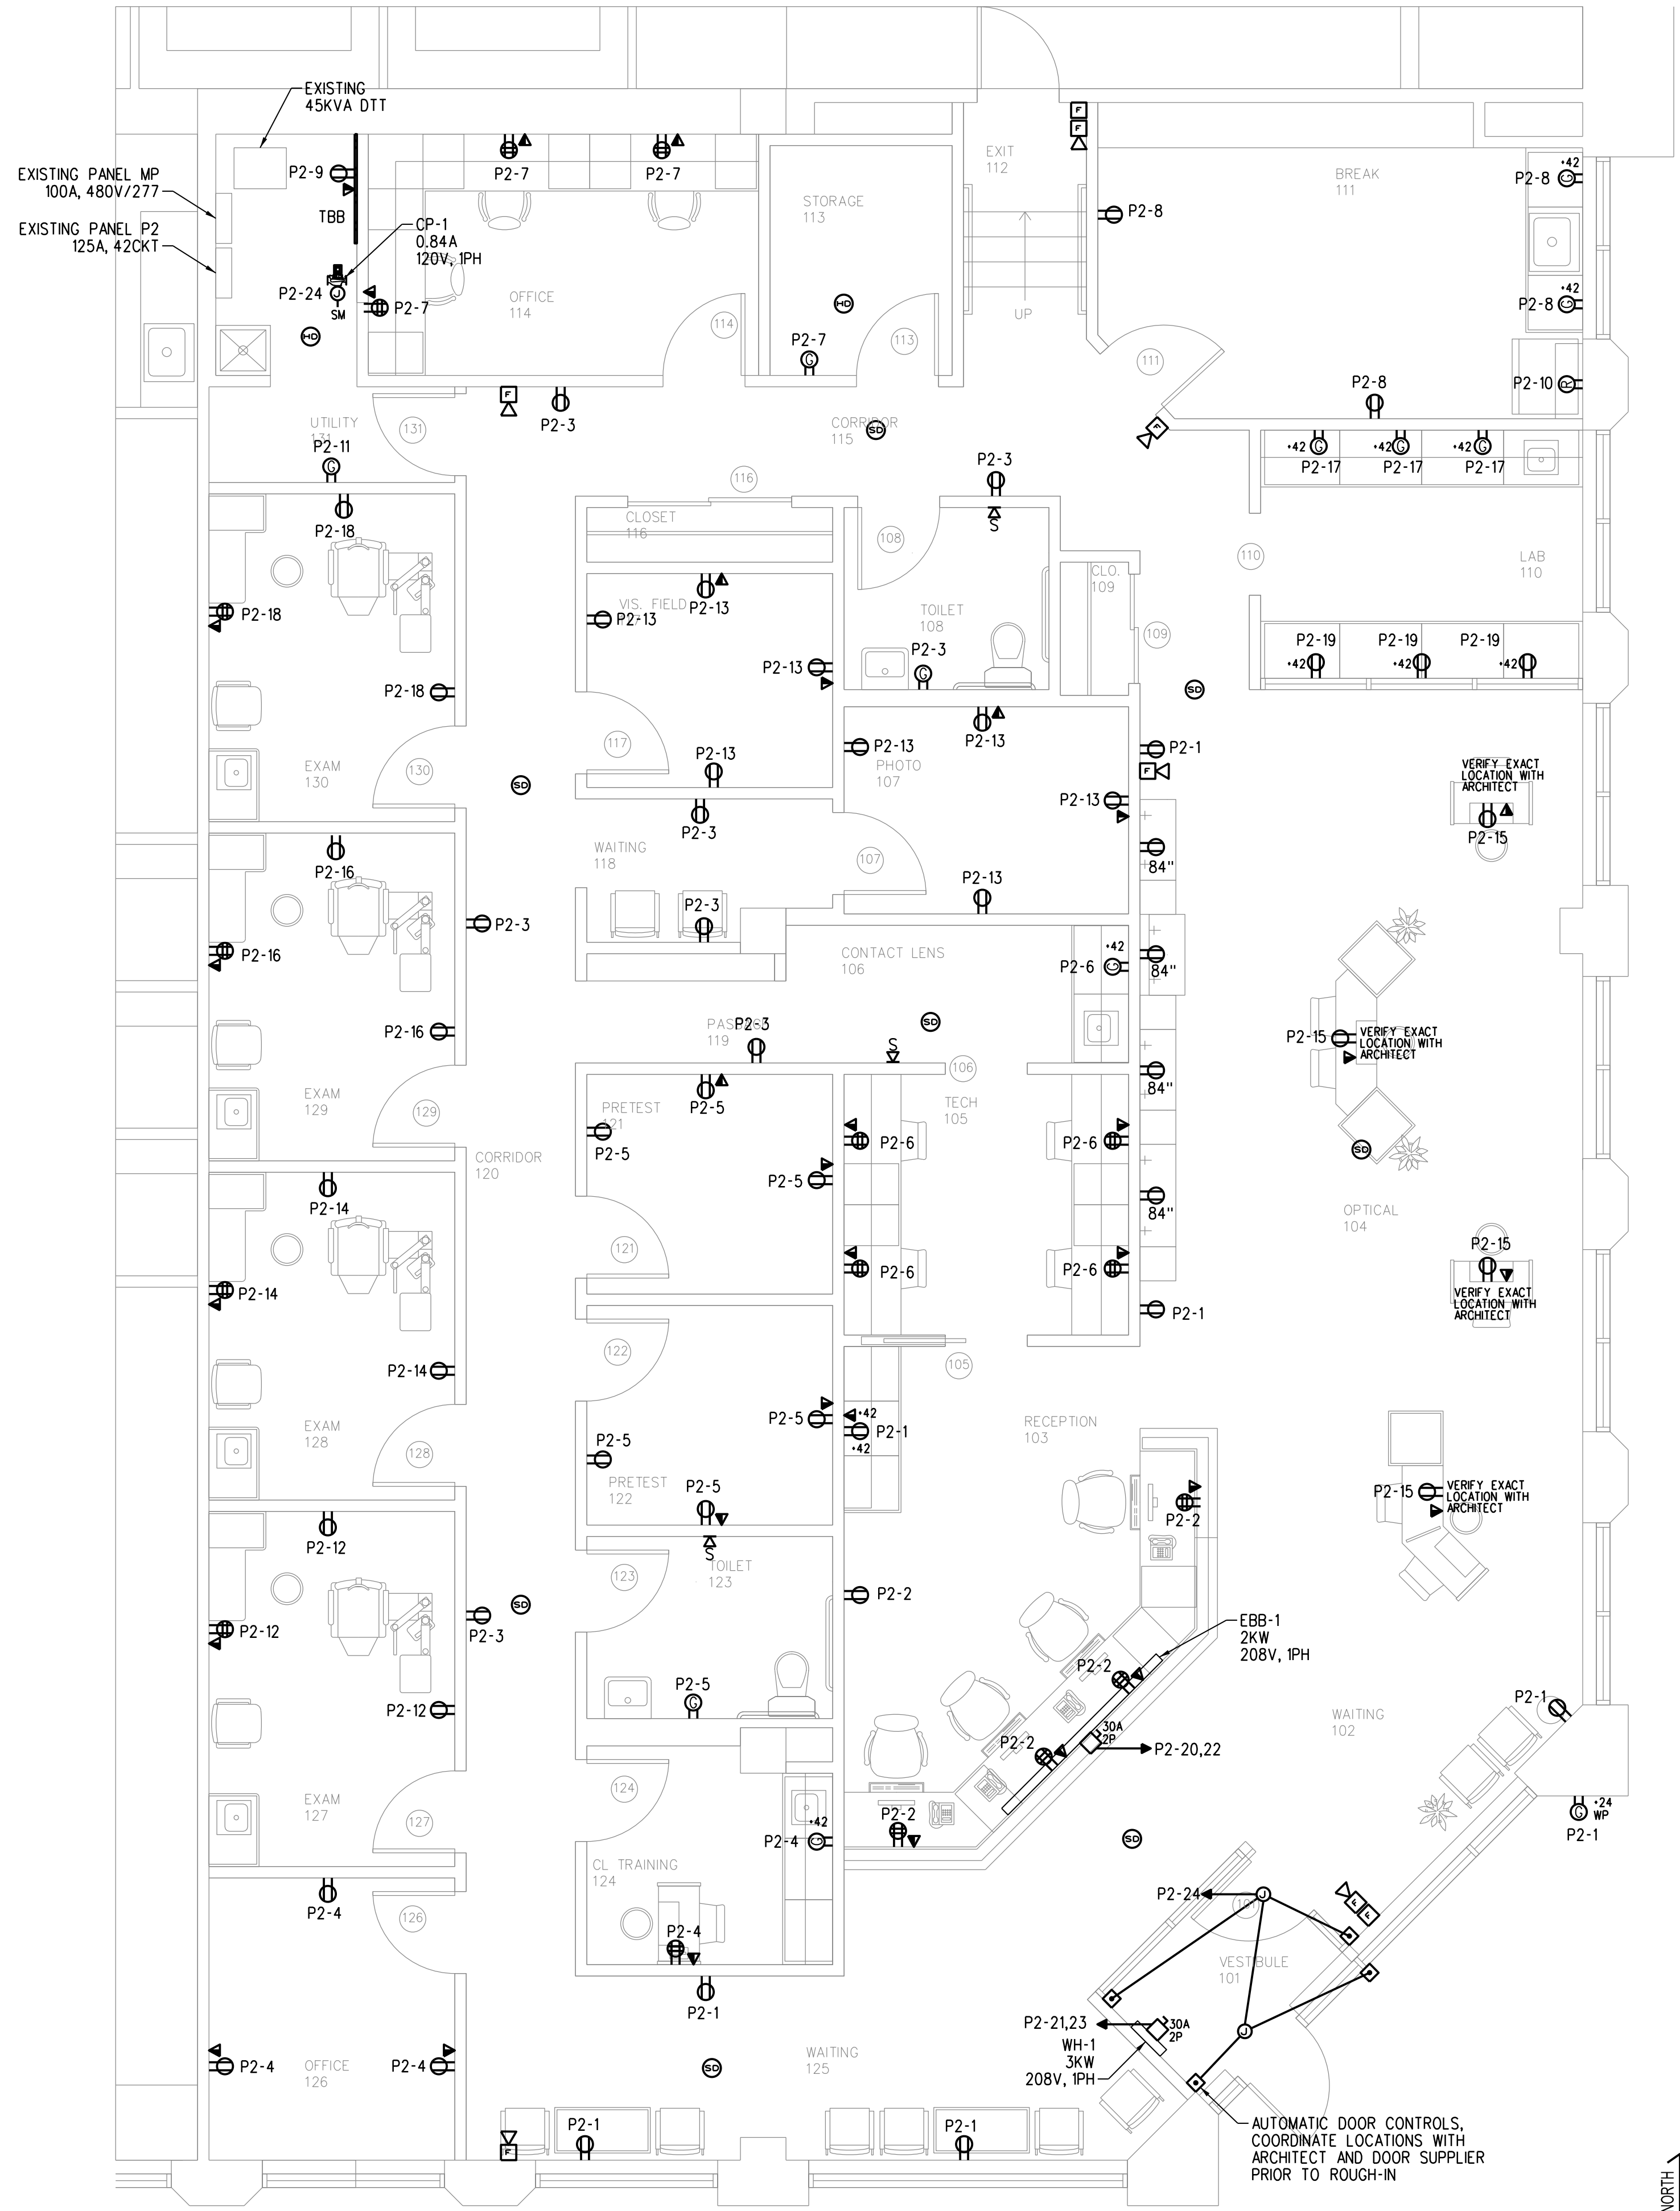

POWER PLAN

CONTRACTOR SHALL REFER TO ARCHITECTURAL REFLECTED CEILING PLAN FOR ALL CEILING MOUNTED ITEMS PRIOR TO ROUGH-IN.

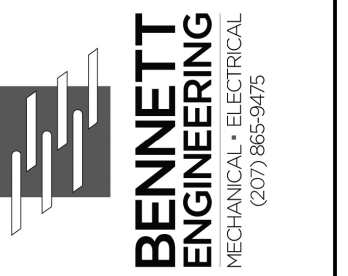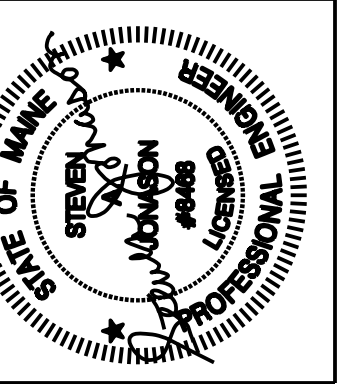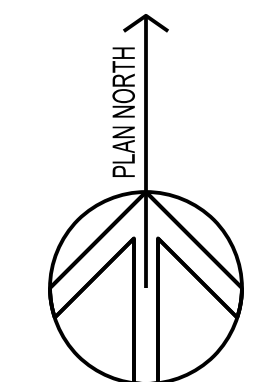

Title

ELECTRICAL PLAN

Scale: 1/4" = 1'-0"

Date:

Revisions
1. 09/09/15 CD SUBMISSION

Sheet

E1