

DATE: 2017-09-21

REVISIONS:

NO.	DATE	DESCRIPTION	BY

CLIENT NAME:



J+J FIT, LLC
OWNER: JAMIE CALEDA
18 PARKER AVENUE
WARREN, RI 02885
EMAIL: JCALEDA@PUREBARRE.COM

PROJECT NAME:



INTERIOR UP-FIT

TWO PORTLAND SQUARE
477 FORE STREET - SUITE 128
PORTLAND, MAINE 04101

SHEET TITLE:

POWER & LIGHTING PLAN

PROJECT NUMBER: 17-A094


DATE: 2017-09-21

SHEET NO.

AE-1

SHEET 1 OF 2


THE ARCHITECT SHALL NOT BE RESPONSIBLE FOR ACTUAL CONDITIONS, CONSTRUCTION AND/OR USE THEREOF. THIS DRAWING IS TO CONVEY DESIGN INTENTIONS AND/OR CODE COMPLIANCE ONLY. USE OF THESE DRAWINGS IMPLIES AGREEMENT WITH THESE CONDITIONS. THE CONTRACTOR IS TO VERIFY ALL DIMENSIONS.

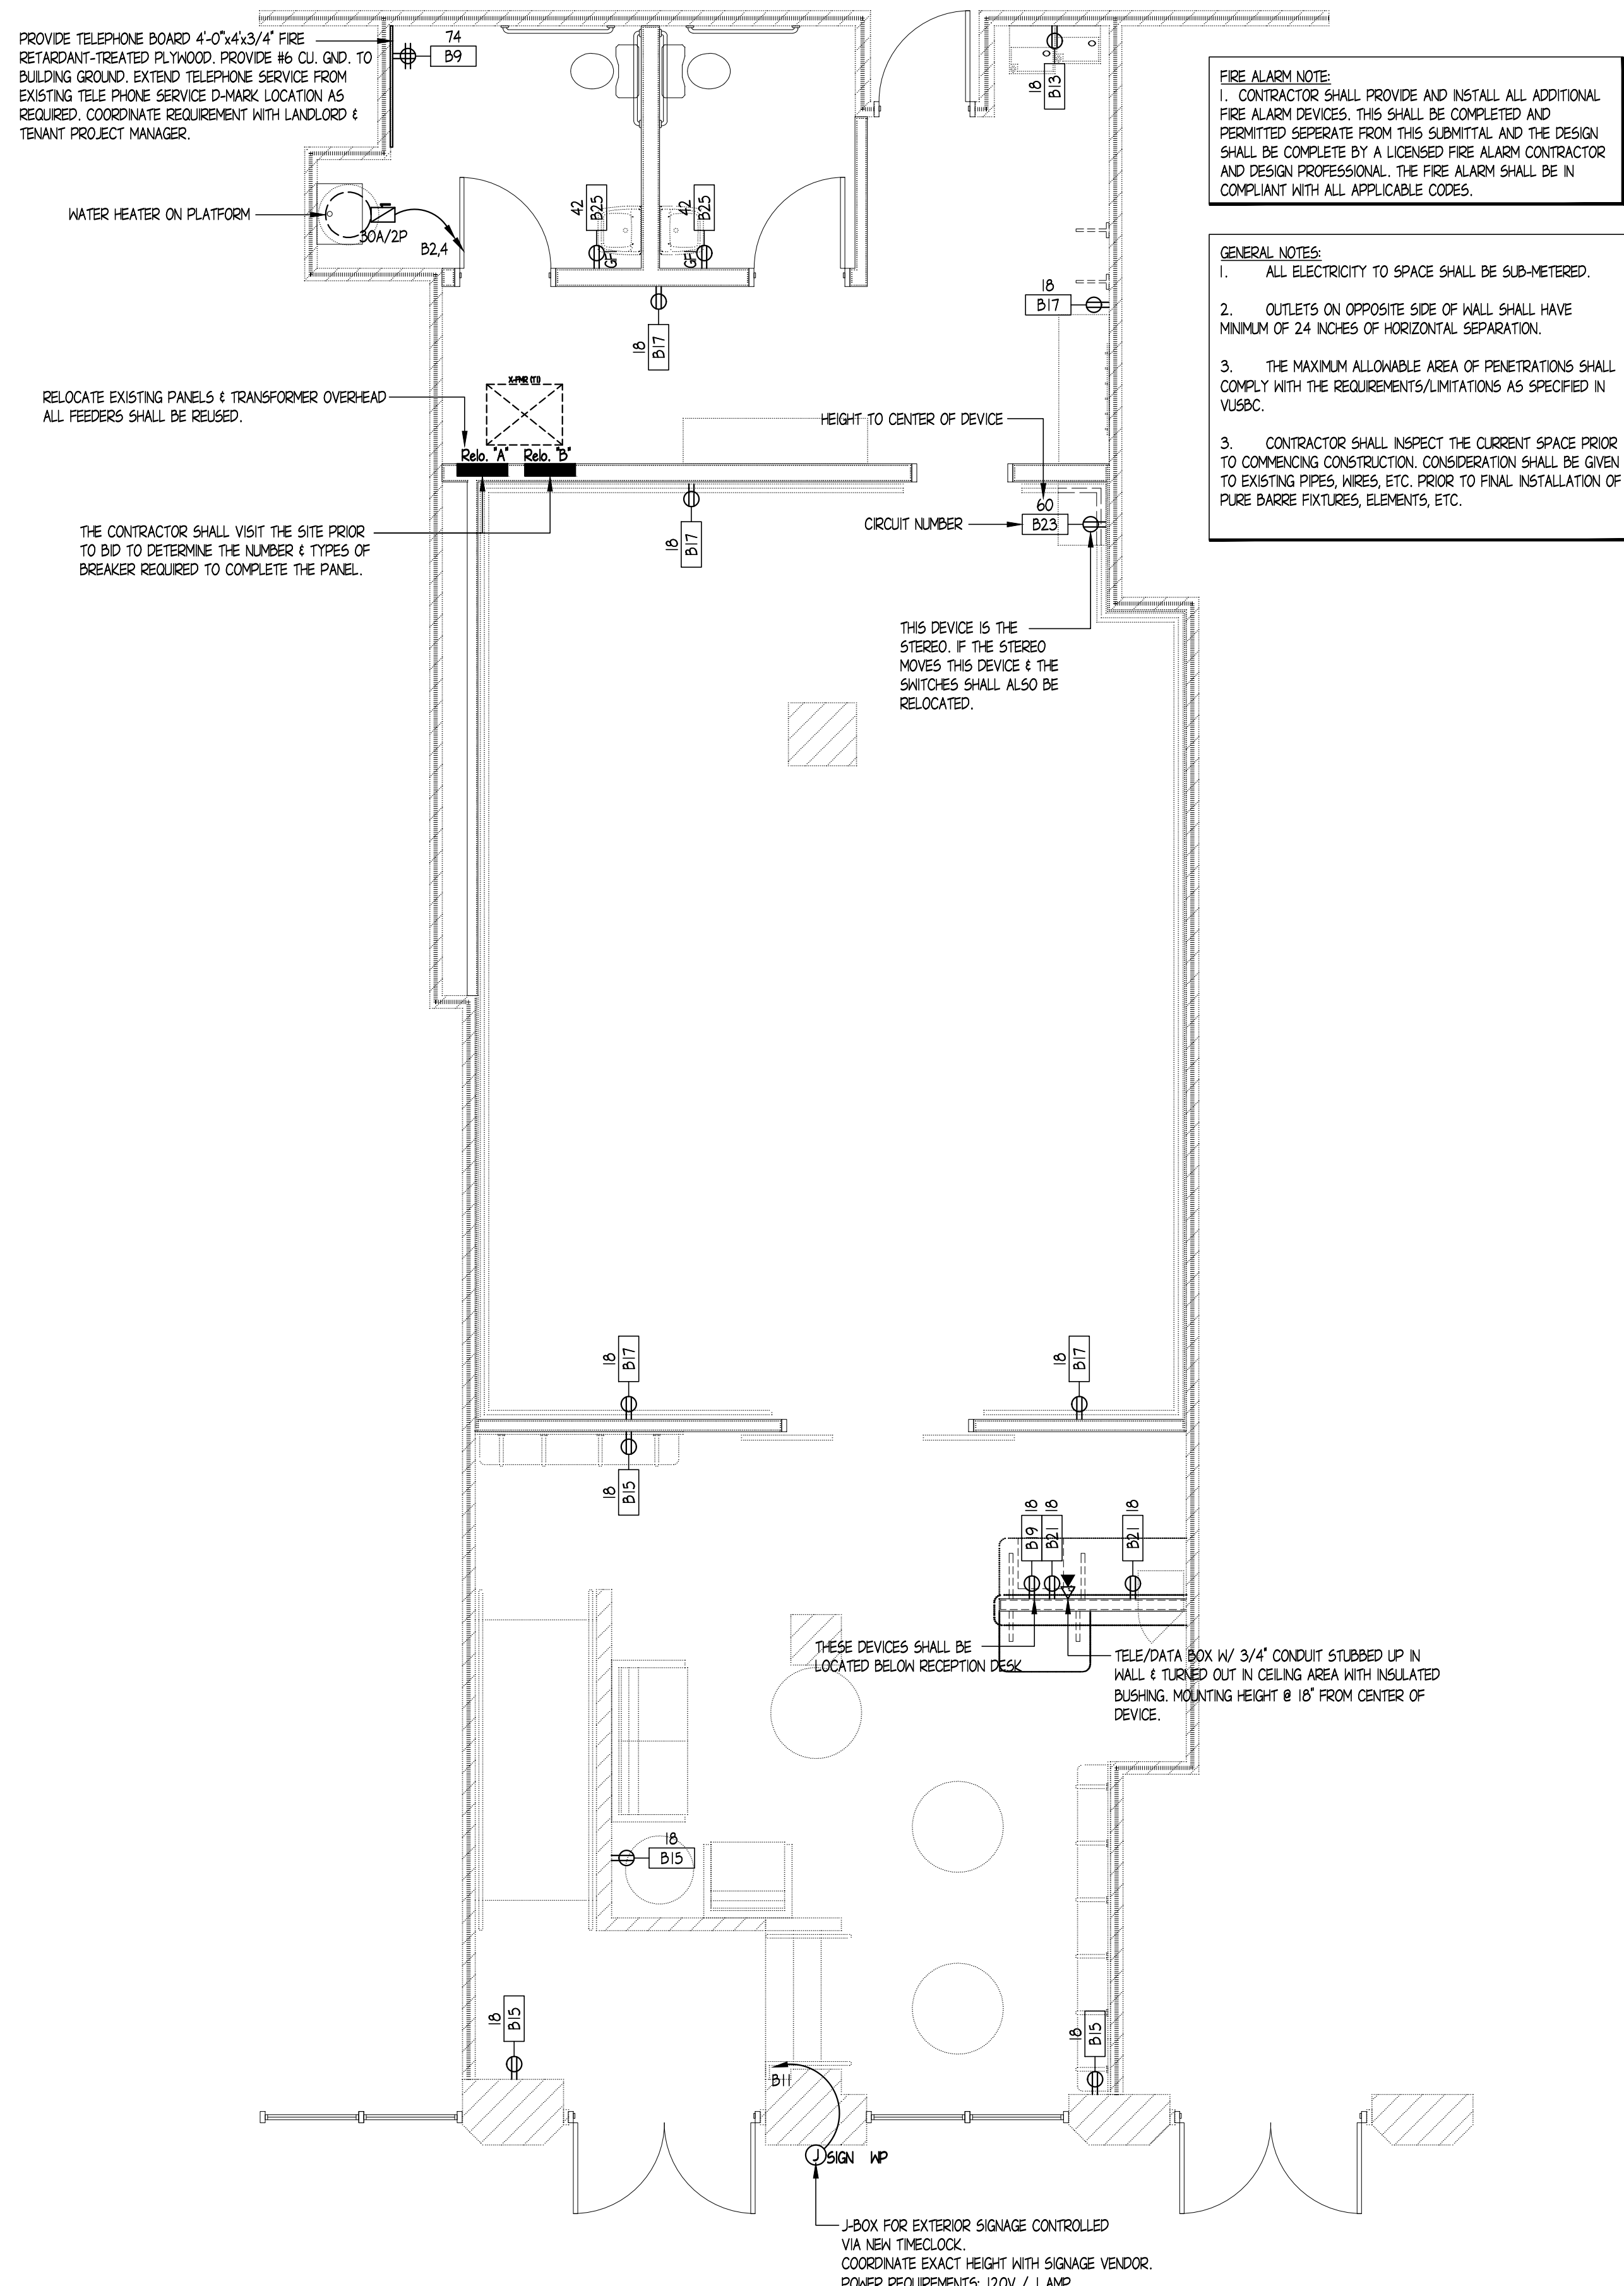

FIRE ALARM NOTE:
1. CONTRACTOR SHALL PROVIDE AND INSTALL ALL ADDITIONAL FIRE ALARM DEVICES. THIS SHALL BE COMPLETED AND PERMITTED SEPARATE FROM THIS SUBMITTAL AND THE DESIGN SHALL BE COMPLETE BY A LICENSED FIRE ALARM CONTRACTOR AND DESIGN PROFESSIONAL. THE FIRE ALARM SHALL BE IN COMPLIANT WITH ALL APPLICABLE CODES.

GENERAL NOTES:
1. ALL ELECTRICITY TO SPACE SHALL BE SUB-METERED.
2. OUTLETS ON OPPOSITE SIDE OF WALL SHALL HAVE MINIMUM OF 24 INCHES OF HORIZONTAL SEPARATION.
3. THE MAXIMUM ALLOWABLE AREA OF PENETRATIONS SHALL COMPLY WITH THE REQUIREMENTS/LIMITATIONS AS SPECIFIED IN VUSBC.
3. CONTRACTOR SHALL INSPECT THE CURRENT SPACE PRIOR TO COMMENCING CONSTRUCTION. CONSIDERATION SHALL BE GIVEN TO EXISTING PIPES, WIRES, ETC. PRIOR TO FINAL INSTALLATION OF PURE BARRE FIXTURES, ELEMENTS, ETC.

1 POWER PLAN
SCALE: 1/4" = 1'-0"

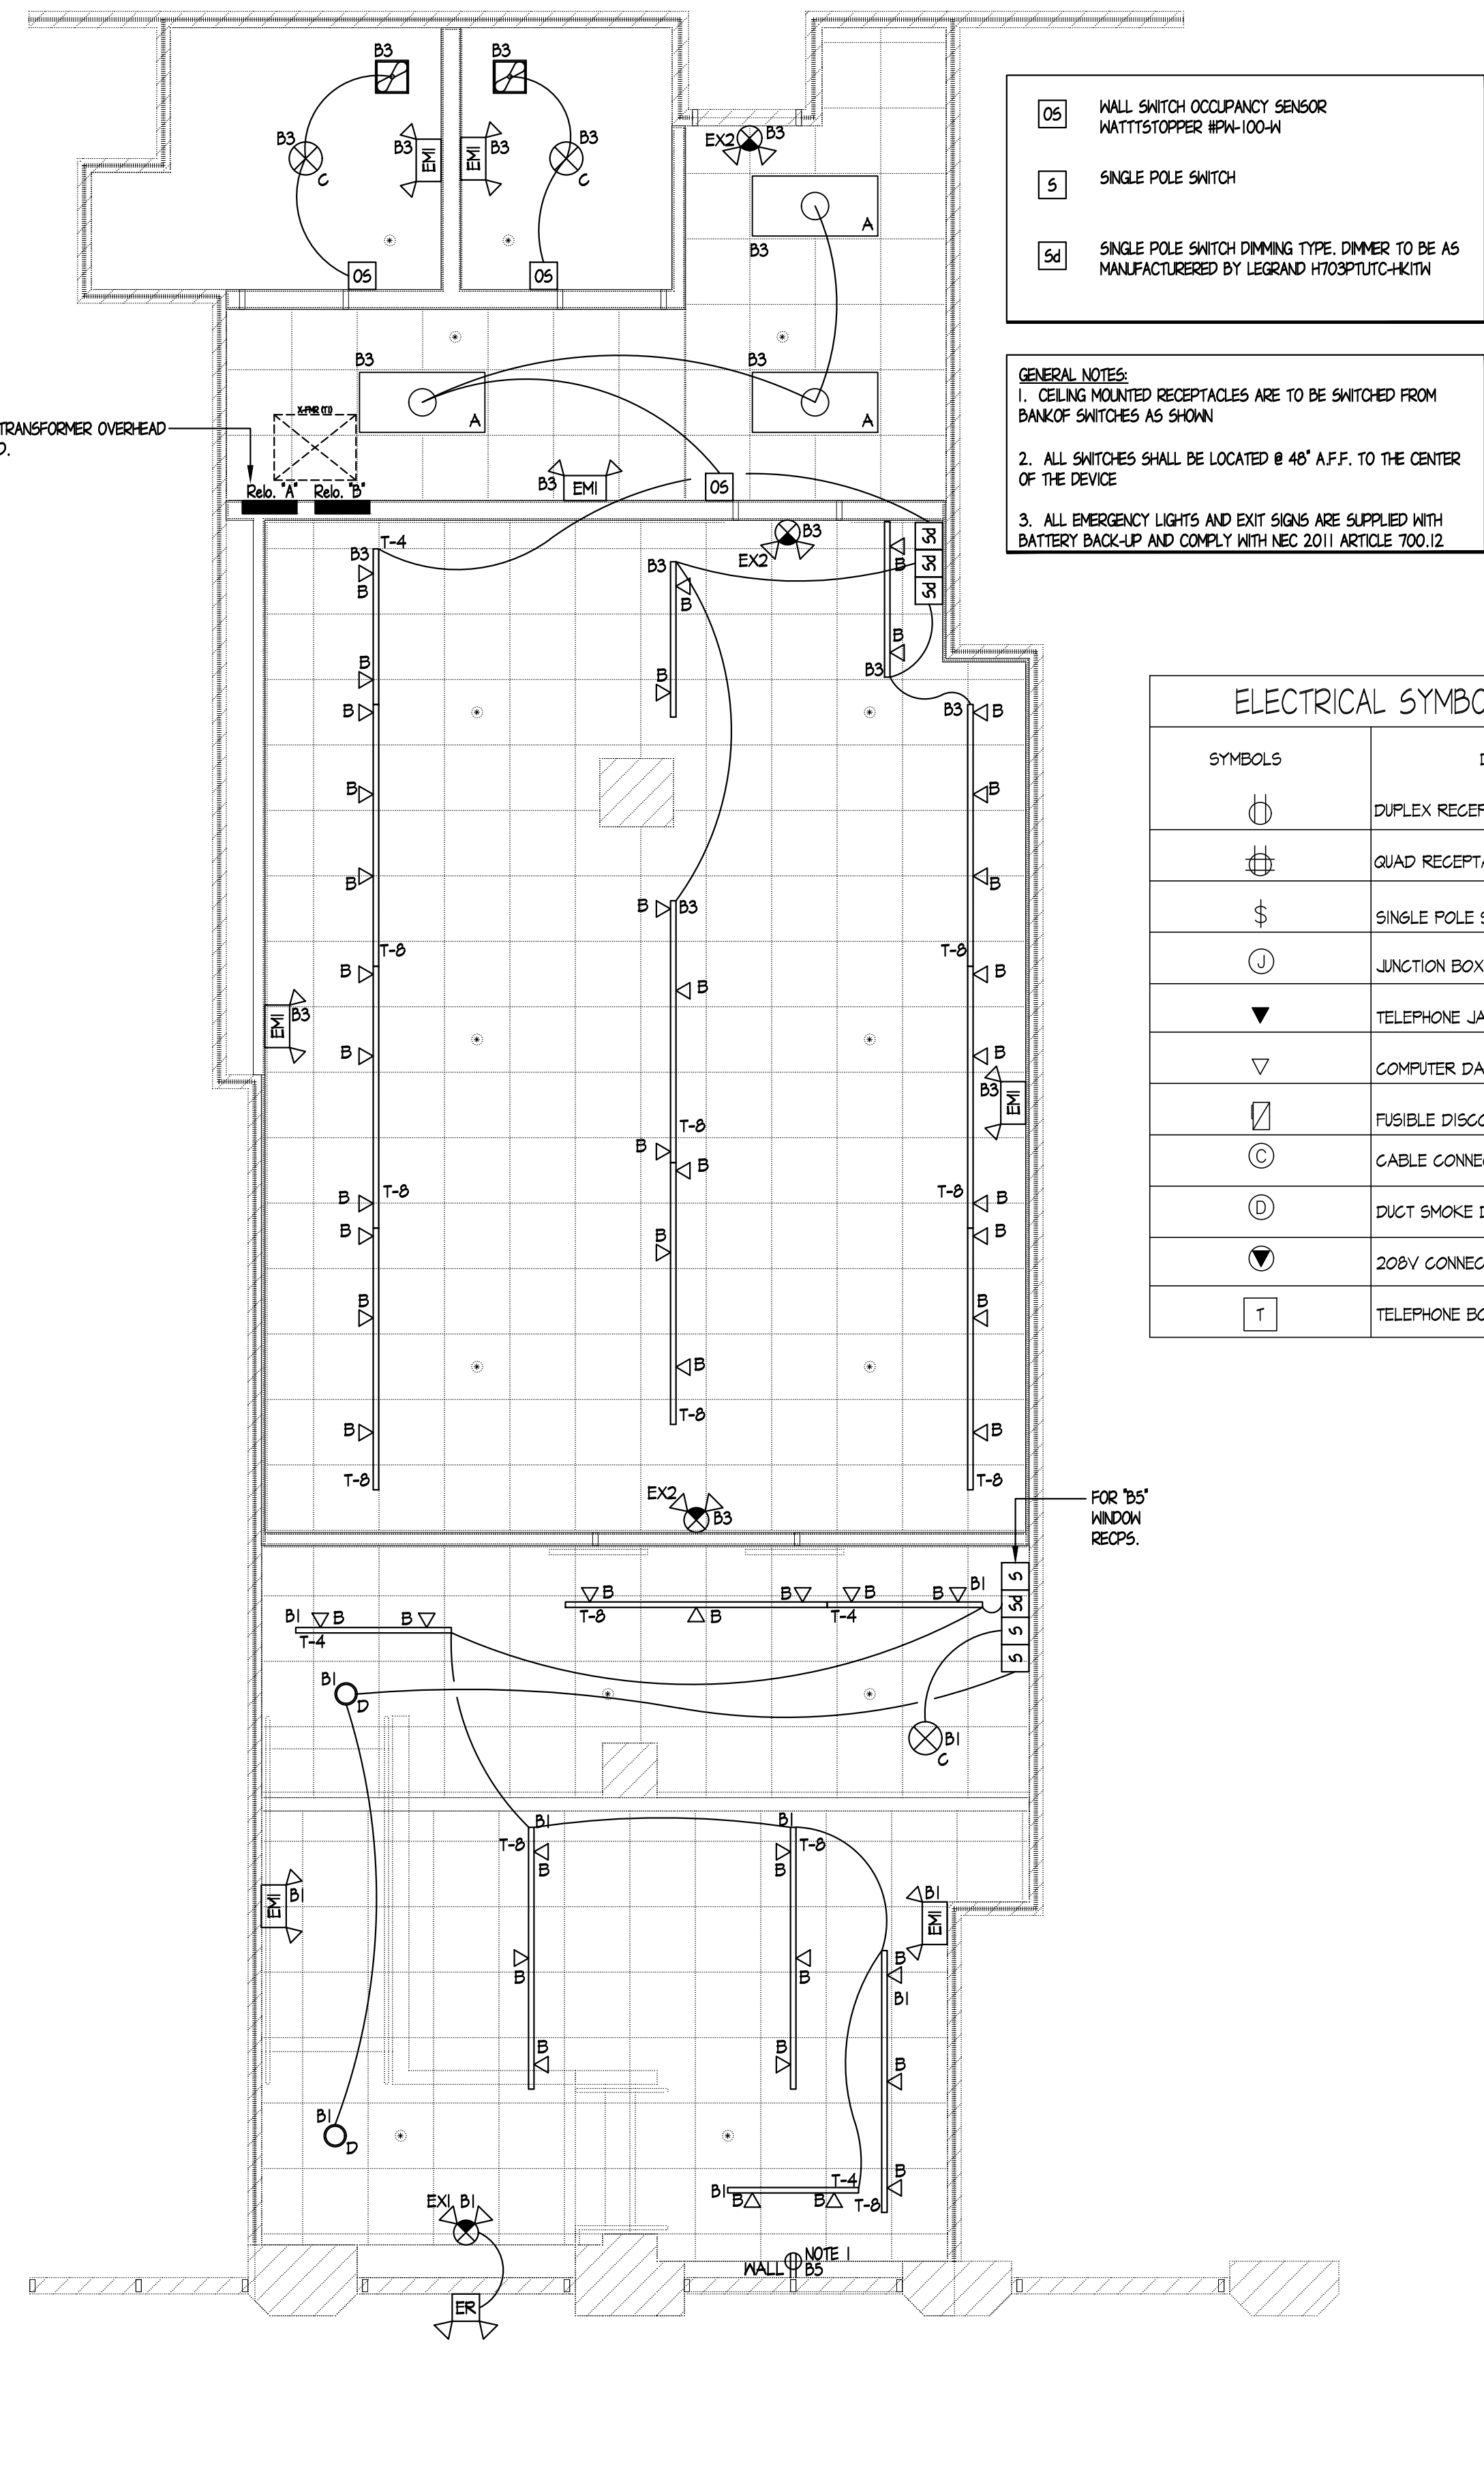

OS WALL SWITCH OCCUPANCY SENSOR WATTSTOPPER IPW-100-W

S SINGLE POLE SWITCH

Sd SINGLE POLE SWITCH DIMMING TYPE. DIMMER TO BE AS MANUFACTURED BY LEGRAND HT03PLTUC-HKITW

GENERAL NOTES:
1. CEILING MOUNTED RECEPTACLES ARE TO BE SWITCHED FROM BANK OF SWITCHES AS SHOWN
2. ALL SWITCHES SHALL BE LOCATED @ 48" A.F.F. TO THE CENTER OF THE DEVICE
3. ALL EMERGENCY LIGHTS AND EXIT SIGNS ARE SUPPLIED WITH BATTERY BACK-UP AND COMPLY WITH NEC 2011 ARTICLE 700.12

ELECTRICAL SYMBOLS LEGEND

SYMBOLS	DESCRIPTION
	DUPLEX RECEPTACLE
	QUAD RECEPTACLE
	SINGLE POLE SWITCH
	JUNCTION BOX
	TELEPHONE JACK
	COMPUTER DATA TERMINAL OUTLET
	FUSIBLE DISCONNECT SWITCH
	CABLE CONNECTION
	DUCT SMOKE DETECTOR
	208V CONNECTION
	TELEPHONE BOARD

2 LIGHTING PLAN
SCALE: 1/4" = 1'-0"