
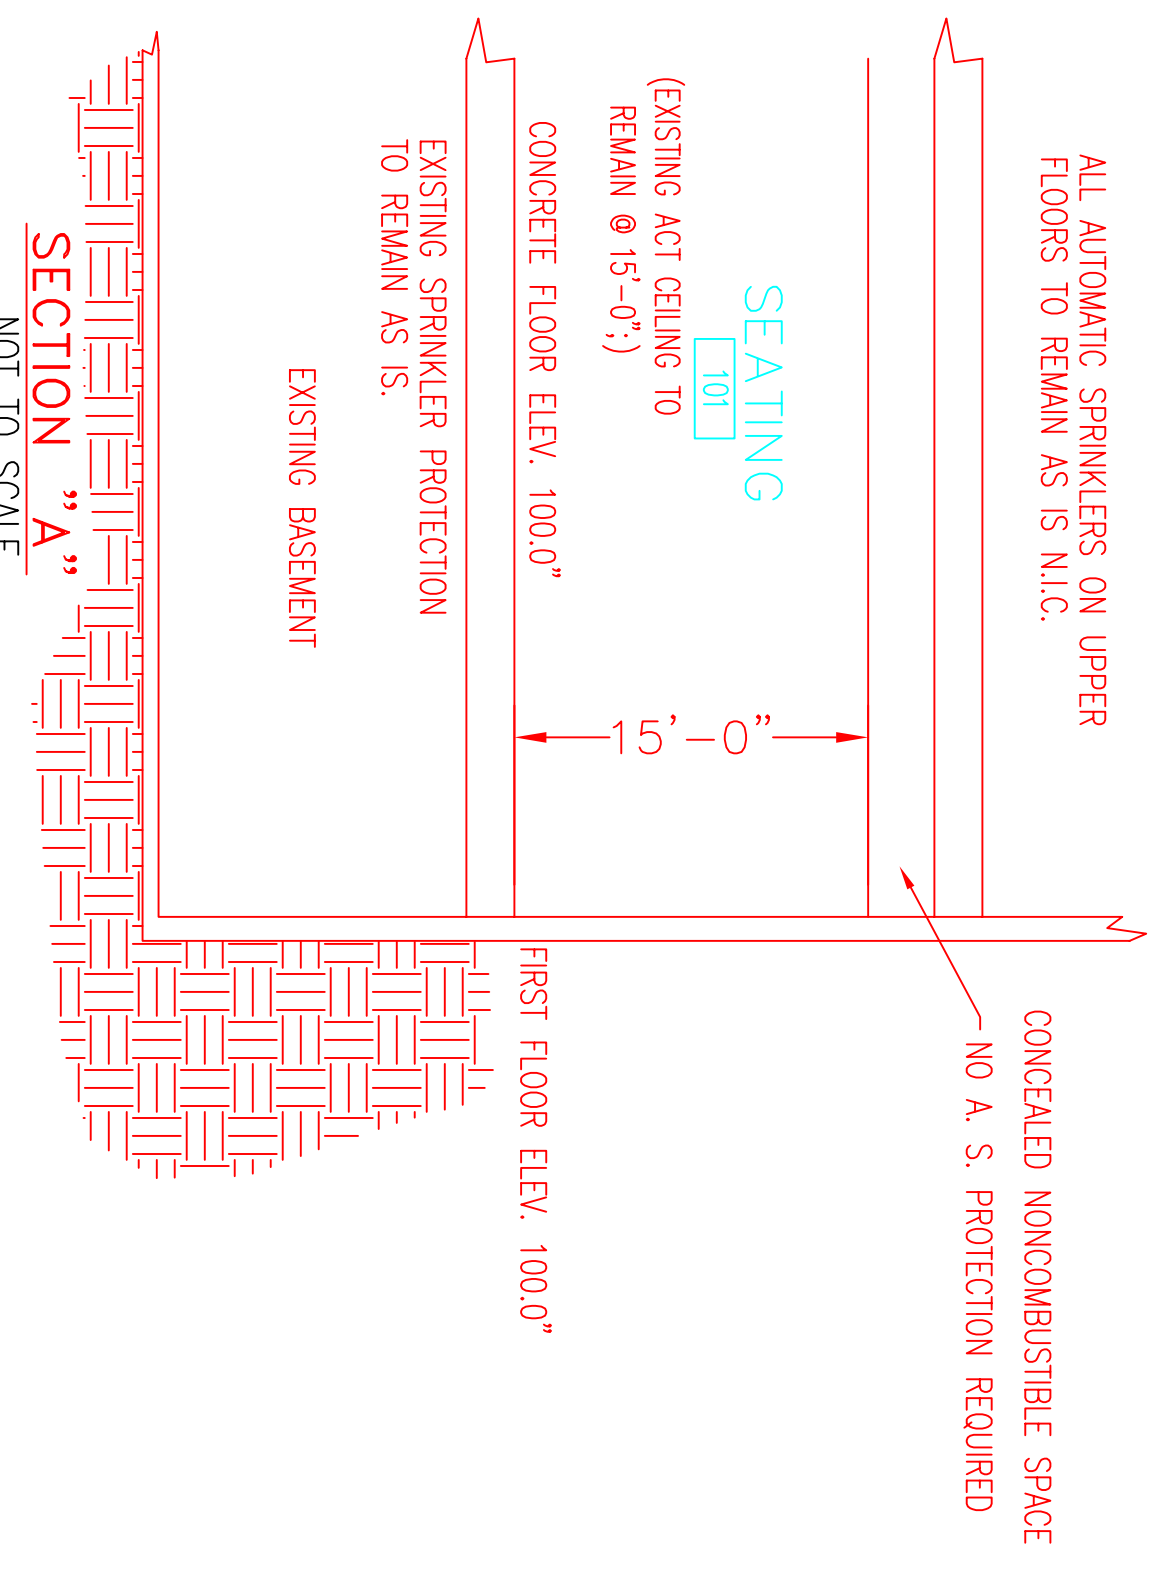


SCOPE OF WORK


- REWORK EXISTING SPRINKLER SYSTEM IN ACCORDANCE WITH NFPA PARAGRAPH # 13
- REMOVE EXISTING SPRINKLERS BEING TO ACCOMMODATE NEW WALL AND CEILING RENOVATIONS FOR WALTERS RESTAURANT. TO LIMIT OF WORK LINE.
- ALL OTHER PORTIONS OF THE BUILDING TO REMAIN AS IS N.I.C. TO REMAIN AS IS.
- EXISTING FIRE PROTECTION CO. TO START A NEW SPRINKLER MAIN INSIDE WALTERS RESTAURANT TENANT SPACE.

GENERAL NOTES

- SPRINKLER SYSTEM RENOVATIONS TO COMPLY WITH NFPA PARAGRAPH # 13
- ALL DIMENSIONS ARE SHOWN FOR GENERAL LOCATION OF SPRINKLER HEADS : PIPING MAY VARY TO SUIT ACTUAL CONDITIONS.
- OCCUPANCY RESERVATION AND CLASSIFICATION, DINING AND BATHROOM SPACES LIGHT HAZARD MECHANICAL/STORAGE, KITCHEN (ORDINARY HAZARD)
- ADD & INDICATES BOTTOM OF DECK TO CENTERLINE OF PIPE, F.P.P. & INDICATES FINISH FLOOR UP TO CENTERLINE OF PIPE
- MAXIMUM HEIGHT OF WISC. STORAGE 8'-0" A.F.F. TO TOP OF STORAGE
- NEW BRANCH LINES, AND MAINS, SIZED PER EXISTING PIPE SIZES.

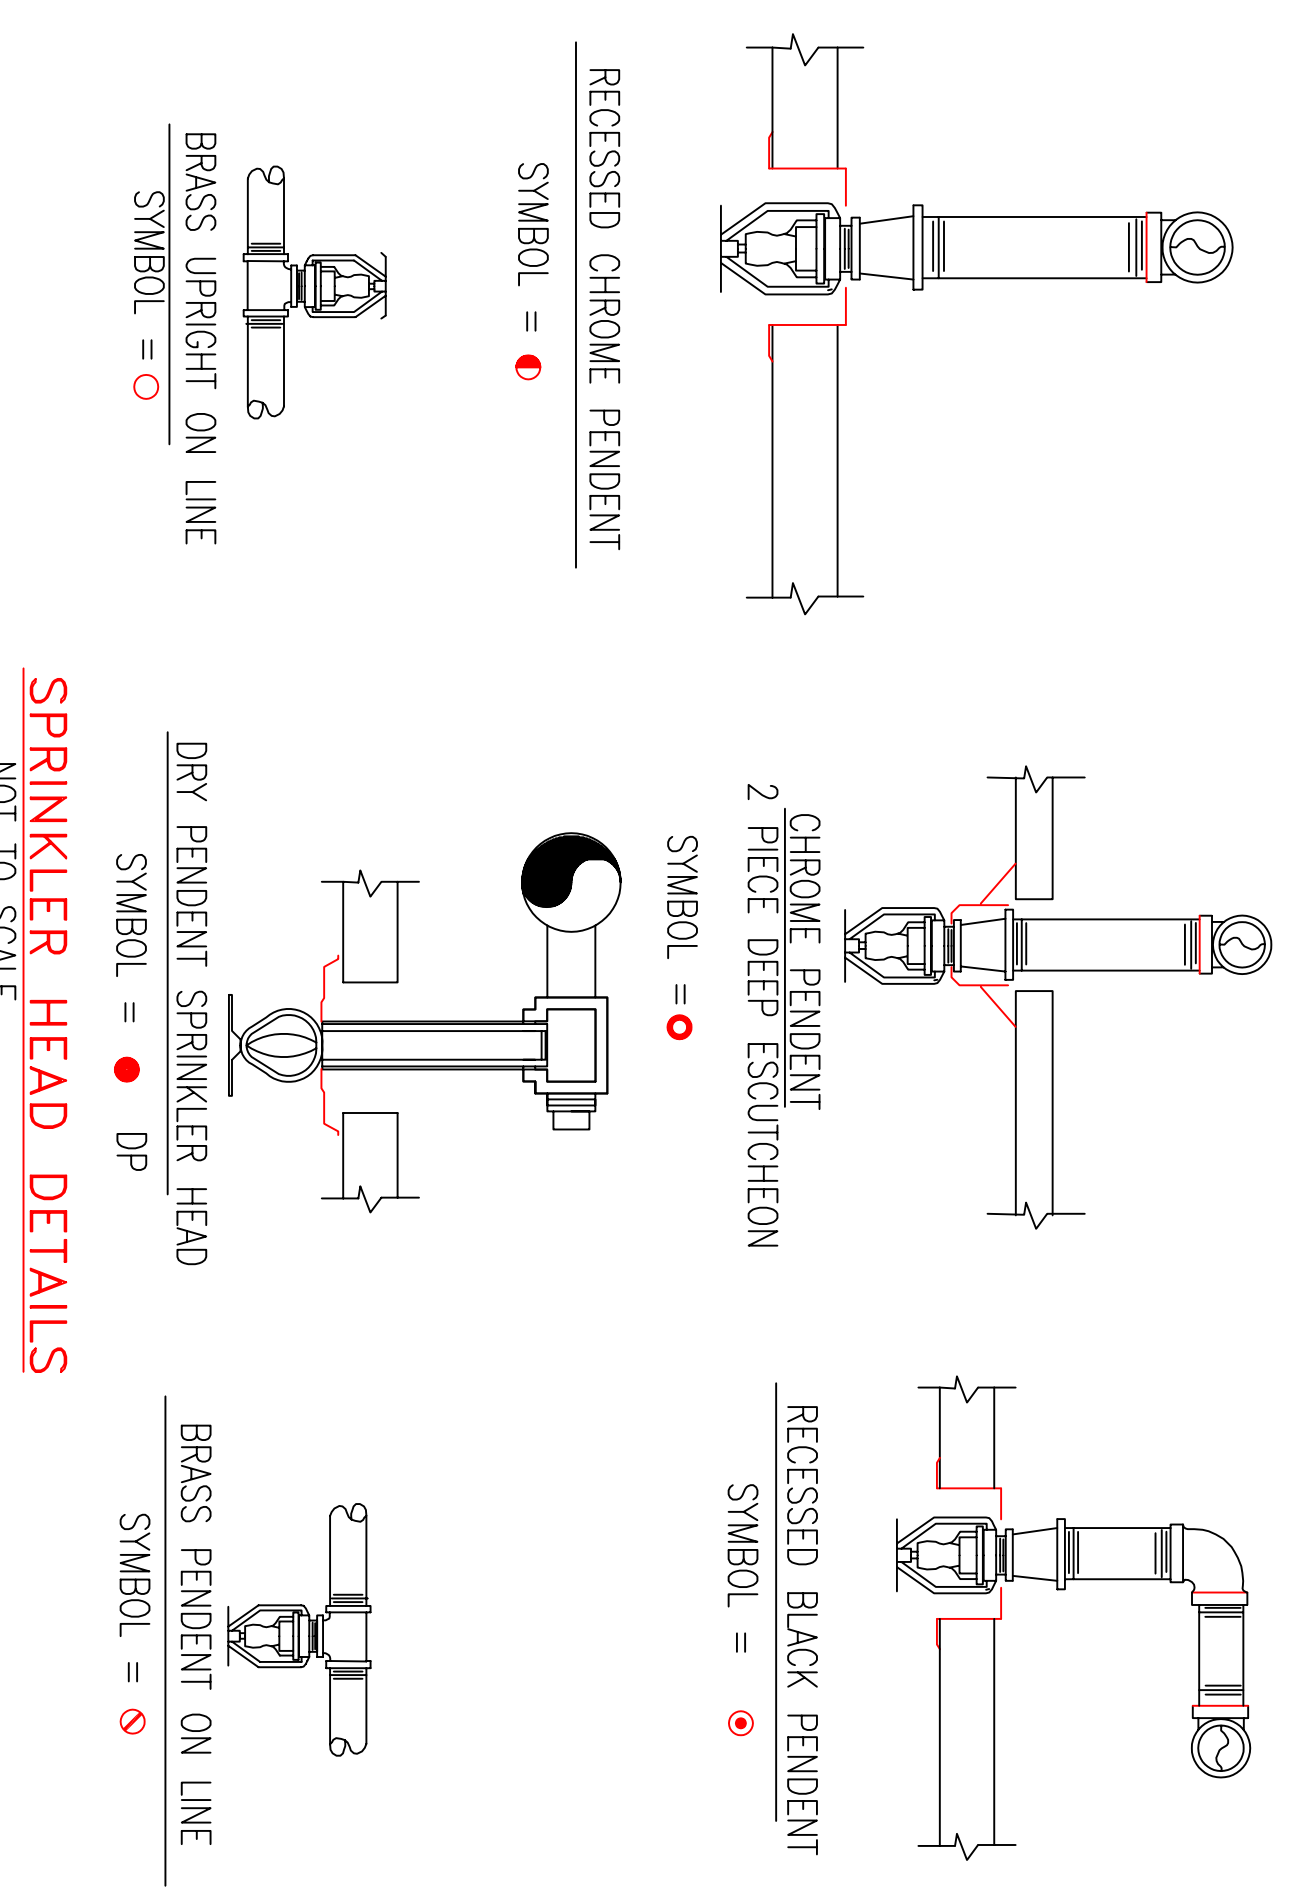

KEY PLAN

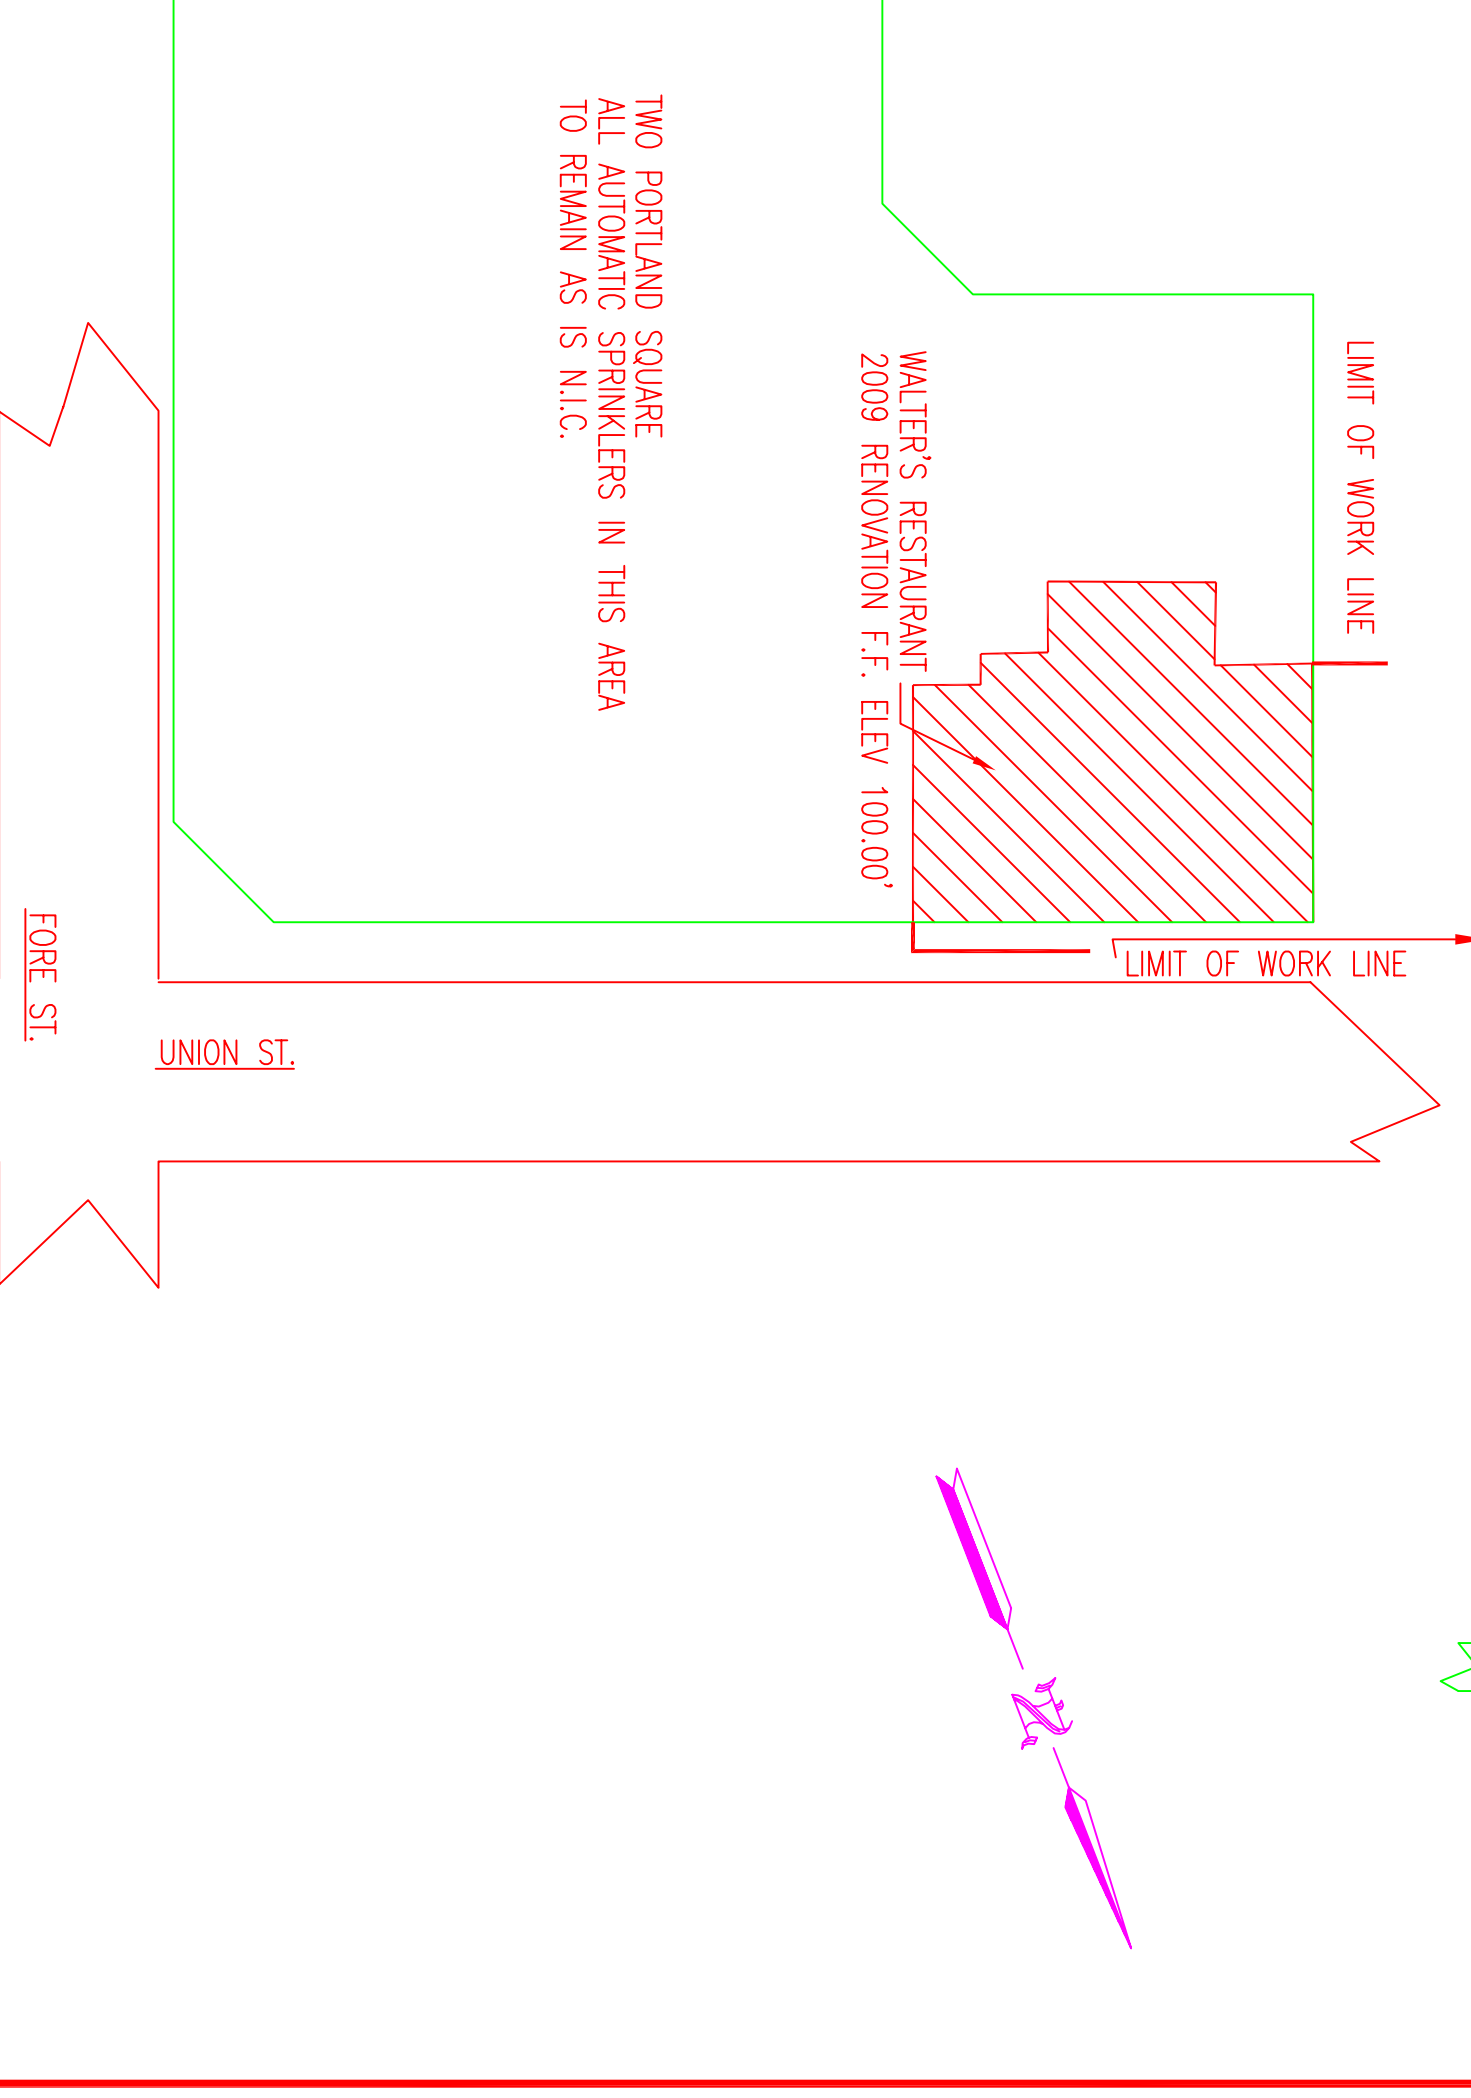

GENERAL NOTES	
SPRINKLER SYSTEM INSTALLATION TO COMPLY WITH NFPA PARAGRAPH # 13	DATE
NEW BRANCH LINE PIPING TO BE BLACK SCHEDULE 40 JOINED BY THREADED DUCTILE IRON FITTINGS	REVISIONS
EXISTING MAIN PIPING SCHEDULE # 10 BLACK WITH GROOVED ENDS & MECHANICAL OUTLETS JOINED BY MECHANICAL COUPLERS	REQUIRED APPROVALS
OWNER TO PROVIDE SUFFICIENT HEAT THROUGHOUT BUILDING TO PREVENT FREEZING OF WATER FILLED SPRINKLER PIPING AND EQUIPMENT (40° F)	OWNER / ARCHITECT STATE FIRE MARSHAL PORTLAND FIRE DEPARTMENT
	DESIGNED BY JMD CHECKED BY WJE CONTRACTOR LICENSE # 101 CONTRACTOR INS # 368
WALTERS RESTAURANT 2009 SPRINKLER RENOVATION	
CONTRACT WITH: R.S.E. CONSTRUCTION LLC	
EASTERN FIRE PROTECTION	
AUBURN/LEWISTON INDUSTRIAL AIRPARK AUBURN, MAINE 04210	
JOB NUMBER AW-4447-09	FIRE SPRINKLER PLANS & DETAILS
SCALE 1 OF 1	DWG. NO.
DATE 8-10-09	