



LIGHTING PLAN

CONTRACTOR SHALL REFER TO ARCHITECTURAL REFLECTED CEILING PLAN FOR ALL CEILING MOUNTED ITEMS PRIOR TO ROUGH-IN.


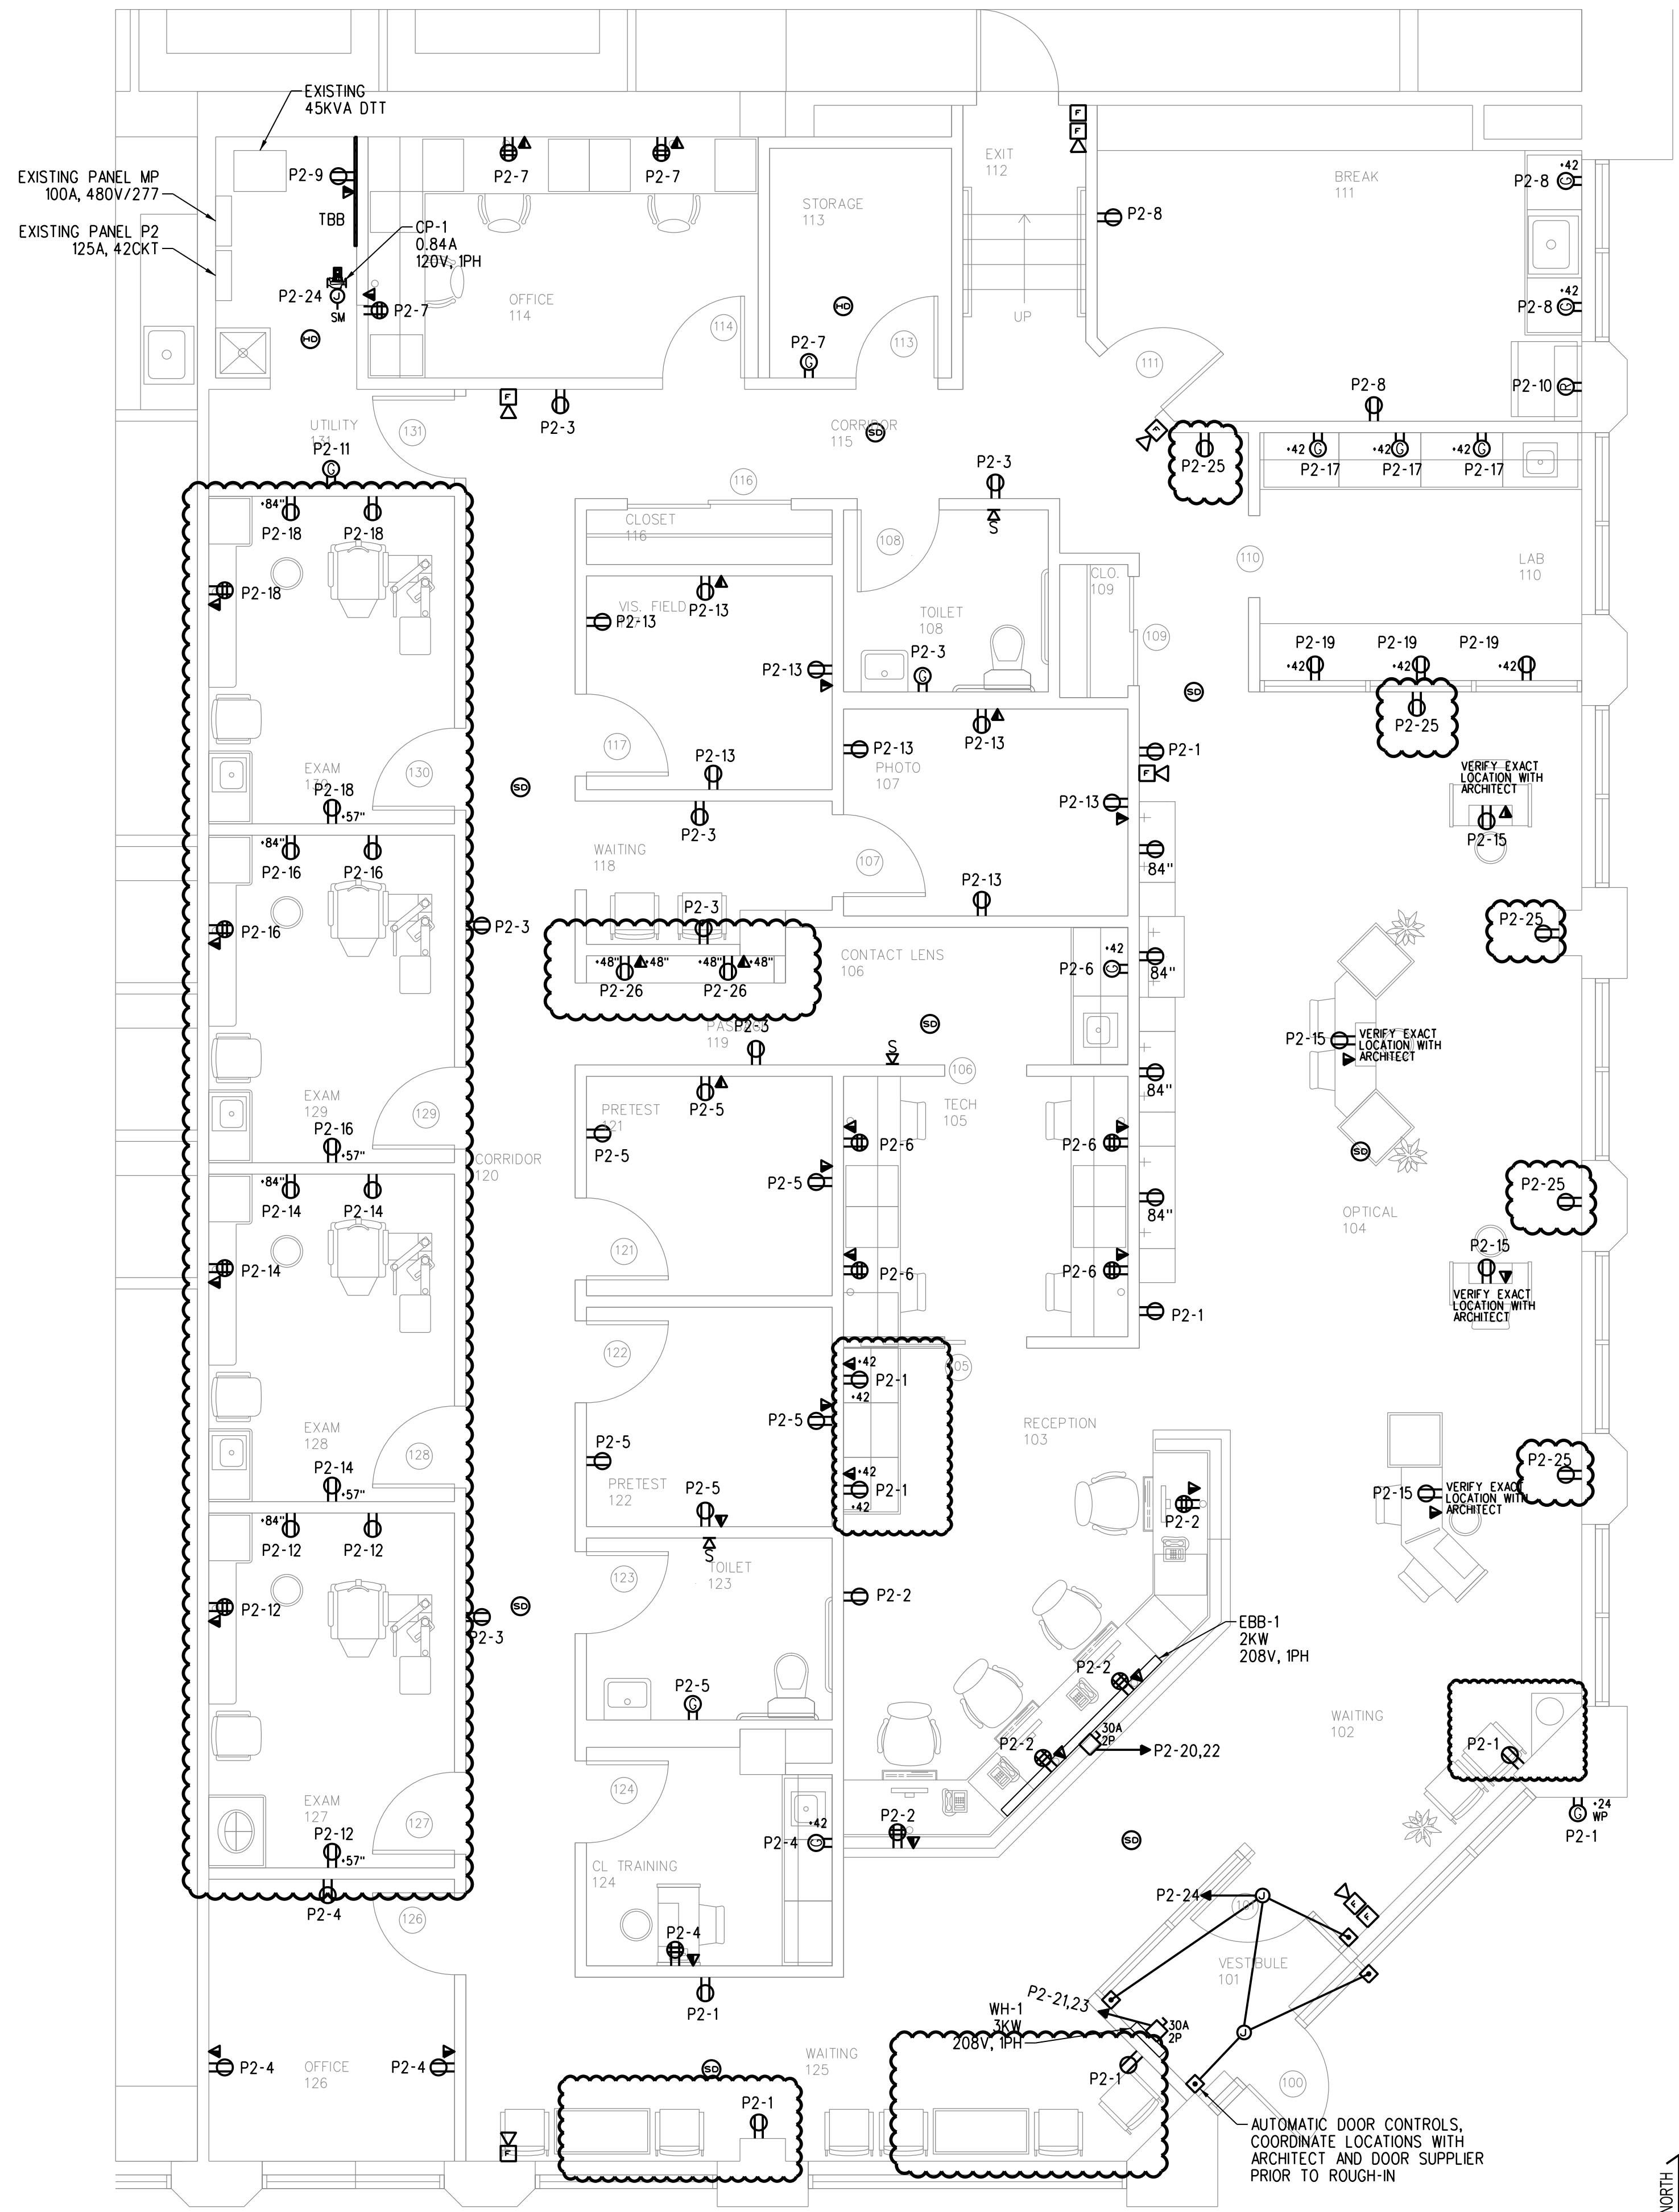


POWER PLAN

CONTRACTOR SHALL REFER TO ARCHITECTURAL REFLECTED CEILING PLAN FOR ALL CEILING MOUNTED ITEMS PRIOR TO ROUGH-IN.

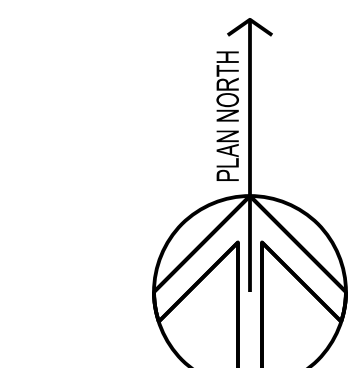

Michael Charek Architects
25 Hartley Street
Portland, Maine 04103
(207) 761-0556

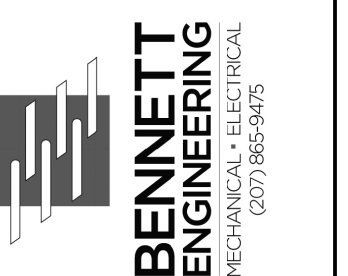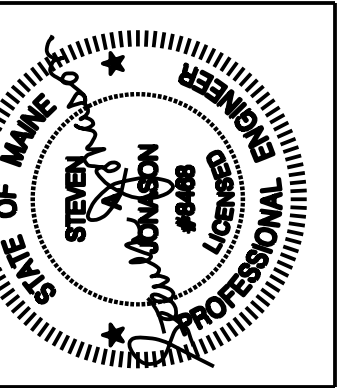

Offices for Casco Bay Eyecare
2 Portland Square
Portland, ME 04101

Title
ELECTRICAL PLAN

Scale: 1/4" = 1'-0"

Date: 9/29/15

Revisions

Sheet
E1