

LIGHTING LEGEND


- 2x4 RT5
- 6" INTERIOR RECESSED FLUORESCENT DOWNLIGHT
- DECORATIVE SMALL PENDANT - KENROY SANCTUARY CONTEMPORARY LIGHT - KR-05009 FROM ACADIAN LIGHTING WITH FROSTED RIBBED GLASS SHADE AND GRAPHITE FINISH
<http://www.arcadianlighting.com/kr-05009.html>
- DECORATIVE SEMI-FLUSH PENDANT - KENROY SANCTUARY CONTEMPORARY SEMI-FLUSH MOUNT KR-04591 FROSTED RIB GLASS SHADE AND GRAPHITE FINISH
<http://www.arcadianlighting.com/kr-04591.html>
- 6" INTERIOR RECESSED WALL WASHER

ACT1- ARMSTRONG CEILING, DUNE 18" ANGLED REGULAR 24x24"
 ACT2- MATCH EXISTING 2x2 ACT CEILING TILE & GRID SYSTEM


NOTES:

1. INTERIOR FIXTURE LEGEND FOR DESIGN INTENT ONLY. REFER TO ELECTRICAL DRAWINGS FOR LIGHT FIXTURE TYPES AND CIRCUITING.
2. MECHANICAL SUBCONTRACTOR TO VERIFY SIZE AND LOCATION OF ANY MECHANICAL REGISTERS WITH ARCHITECT PRIOR TO CONSTRUCTION. LIGHTING LOCATIONS SHALL TAKE PRECEDENCE.
3. SWITCH ALL OFFICES INDEPENDENTLY. DOUBLE SWITCH ALL CONFERENCE ROOMS.
4. INDEPENDENTLY AND DOUBLE SWITCH LAMPS OF 2x4 RT5 FIXTURES.
5. INDEPENDENTLY SWITCH DECORATIVE PENDANT LIGHTS.
6. GENERAL CONTRACTOR TO LAYOUT THE LOCATION OF CIRCULAR PARTITIONS & SOFFITS BY MARKING-UP ON THE CONC. FLOOR FOR ARCHITECTS REVIEW AND APPROVAL PRIOR TO CONSTRUCTION.
7. ELECTRICAL CONTRACTOR SHALL COORDINATE OWNER SUPPLIED TELEPHONE & DATA BOXES WITH LOCATIONS OF OUTLETS.
8. G.C. TO COORDINATE ALL SPECIALTY EQUIPMENT WITH TENANTS VENDOR.
9. G.C. TO INVENTORY ALL EXISTING PARABOLICS AND PROVIDE A QUANTITY FOR HOW MANY CAN BE REUSED.
10. STAFF LOUNGE 433 - DOUBLE SWITCH LAMPS SO THAT 2 LAMPS ARE ON ONE SWITCH AND 1 LAMP IS ON ONE SWITCH.
11. SWITCH RECESSED LIGHTS AT RECEPTION AREA INDEPENDENT FROM WAITING ROOM & ENTRY.
12. PROVIDE A SEPARATE SWITCH FOR AV PROJECTION.
13. INDEPENDENTLY SWITCH RECESSED CANS AT CONFERENCE 2 415.

D17 FIXTURE LEGEND/NOTES

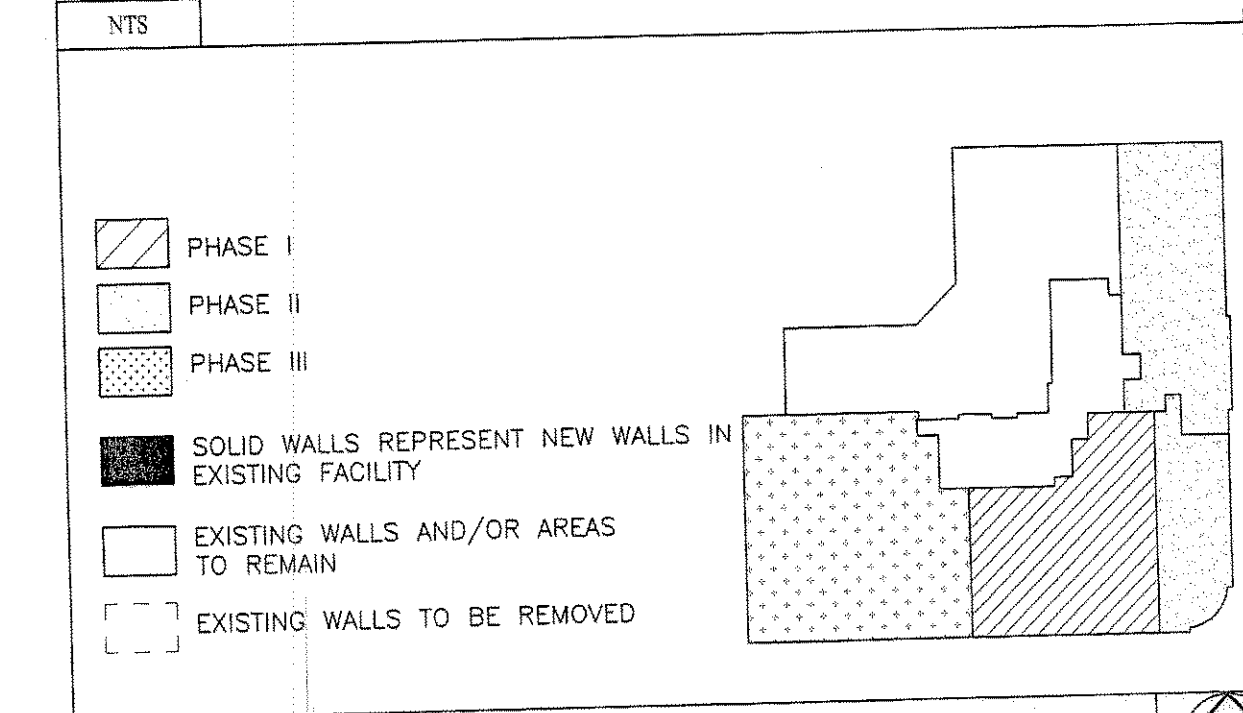

A17 KEY PLAN

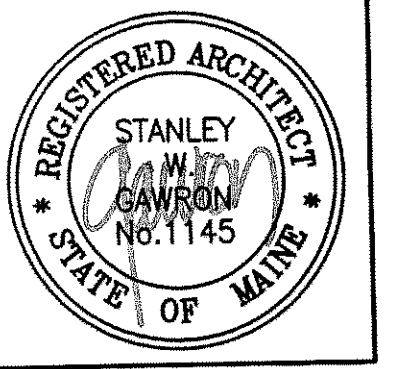

GAWRON TURGEON ARCHITECTS
 29 Black Point Road
 Scarborough, ME 04074
www.gawronturgen.com
 Tel. 207.883.6307
 Fax. 207.883.0361

PRUDENTIAL
 TWO PORTLAND SQUARE FOURTH FLOOR
 PORTLAND, MAINE

REVISIONS		
#	DATE	DESCRIPTION
1	02.11.08	RE-ISSUED FOR CONSTRUCTION
2	09.04.08	RE-ISSUED FOR CONSTRUCTION EXPANSION OF PHASE 3

DATE:	09.04.08
PROJECT #	110807
DRAWN BY:	DLP
CHECKED BY:	MET/SWG
DRAWING SCALE	AS NOTED

SHEET TITLE
 FOURTH FLOOR PLAN
 REFLECTED CEILING PLAN

A300

© COPYRIGHT 1985-2003
 REPRODUCTION OR USE OF THIS DOCUMENT WITHOUT WRITTEN PERMISSION OF GAWRON ARCHITECTS IS PROHIBITED

A1 FOURTH FLOOR PLAN - REFLECTED CEILING PLAN

1/8"=1'-0"