



R  
Q  
P  
O  
N  
M  
L  
K  
J  
I  
H  
G  
F  
E  
D  
C  
B  
A  
1 2 3 4 5 6 7 8 9 10 11 12 13 14 15 16 17 18 19 20


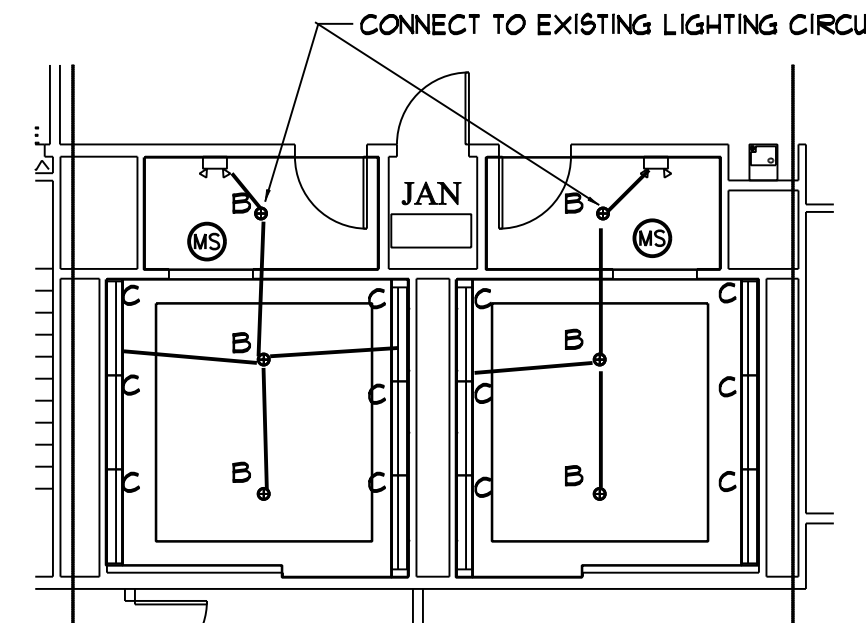


**FOURTH FLOOR PARTIAL LIGHTING PLAN**  
SCALE - 1/8" = 1'-0"

① HOMERUN TO EXISTING PANEL HP3 211/480V PANEL PROVIDE 20A, 1P BREAKER AS NEEDED.

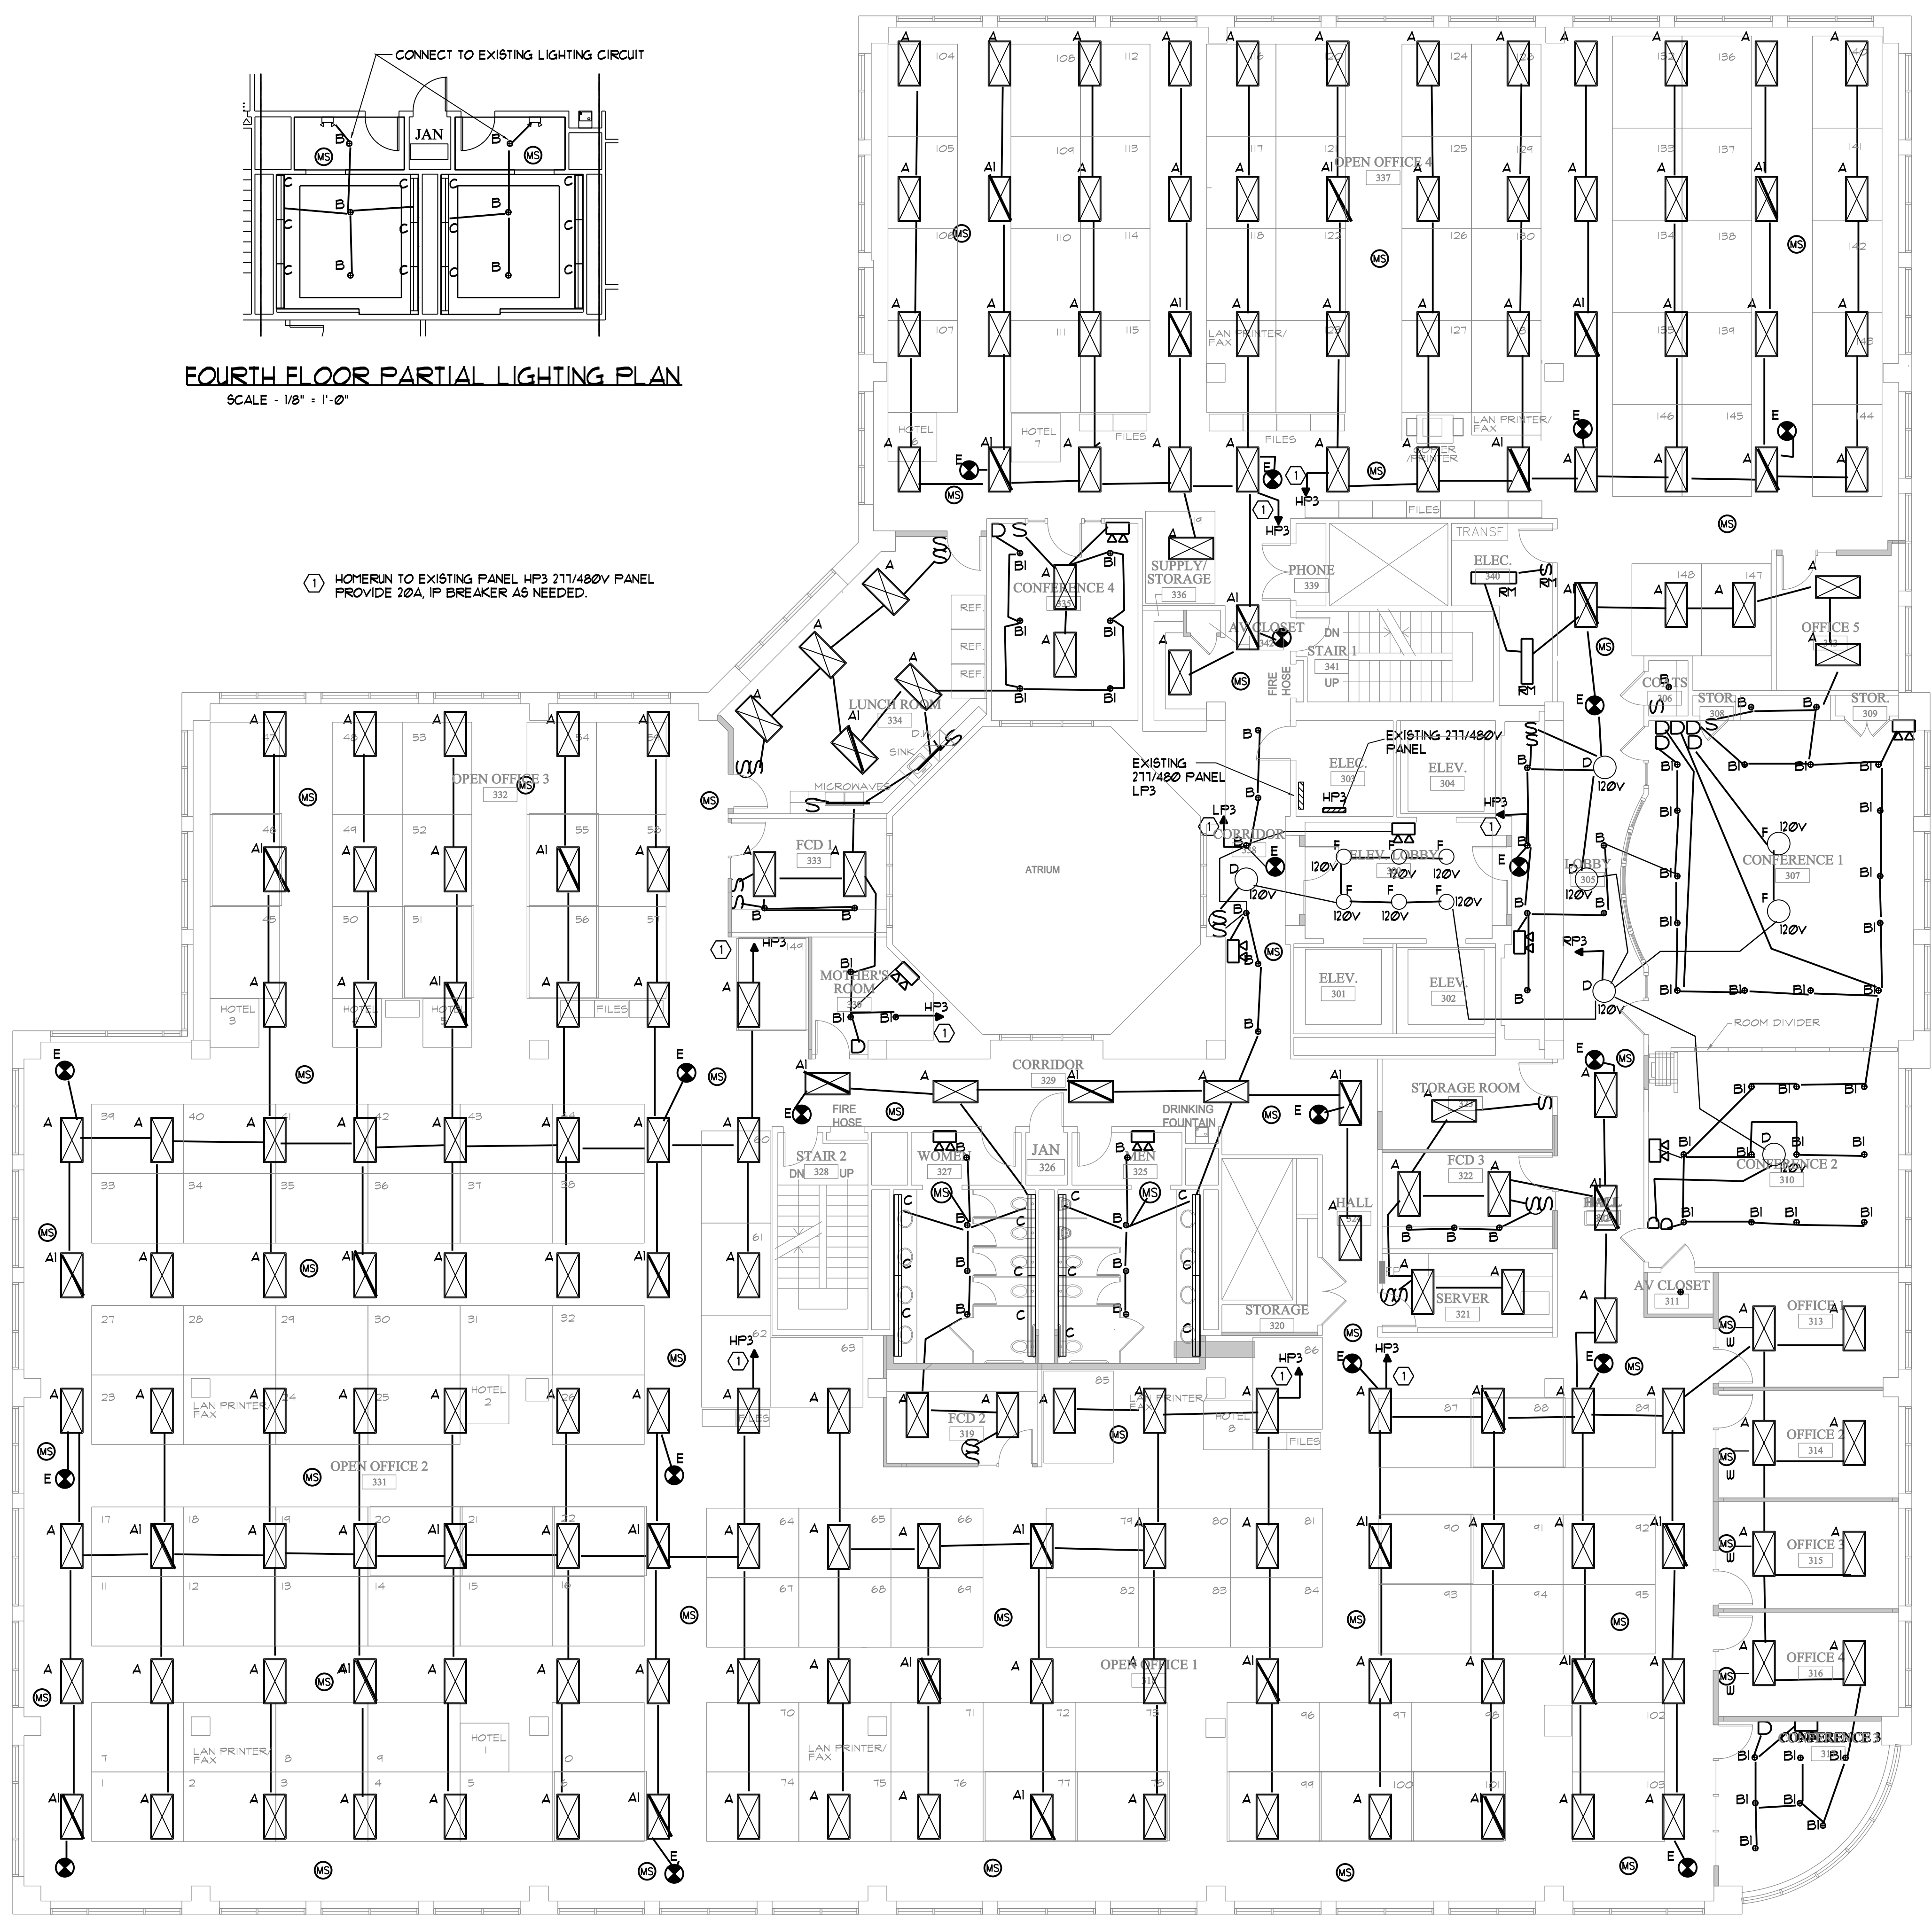

**THIRD FLOOR LIGHTING PLAN**  
SCALE - 1/8" = 1'-0"

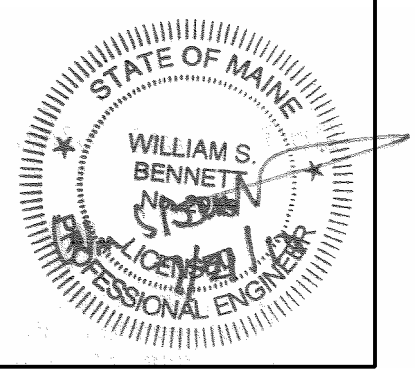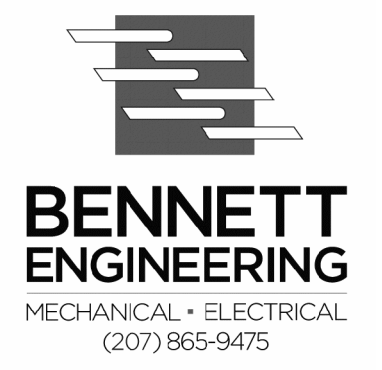

**Gawron Turgeon**  
ARCHITECTS  
29 Black Point Road  
Scarborough, Maine 04074  
www.gawronturgeon.com  
207-863-4307 / 207-863-4361 fax

**PRUDENTIAL**  
TWO PORTLAND SQUARE THIRD FLOOR  
PORTLAND, MAINE

REVISIONS		
#	DATE	DESCRIPTION

DATE:	06.08.10
PROJECT #	040510
DRAWN BY:	JMV
CHECKED BY:	WSBJR
DRAWING SCALE	AS NOTED

**SHEET TITLE**  
THIRD FLOOR LIGHTING PLAN

**E101**

© COPYRIGHT 1985-2010  
REPRODUCTION OR USE OF  
THIS DOCUMENT WITHOUT  
THE WRITTEN PERMISSION OF  
GAWRON ARCHITECTS IS PROHIBITED