
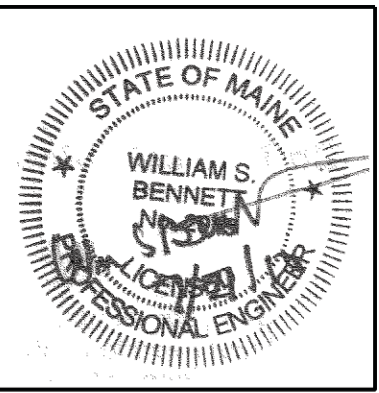
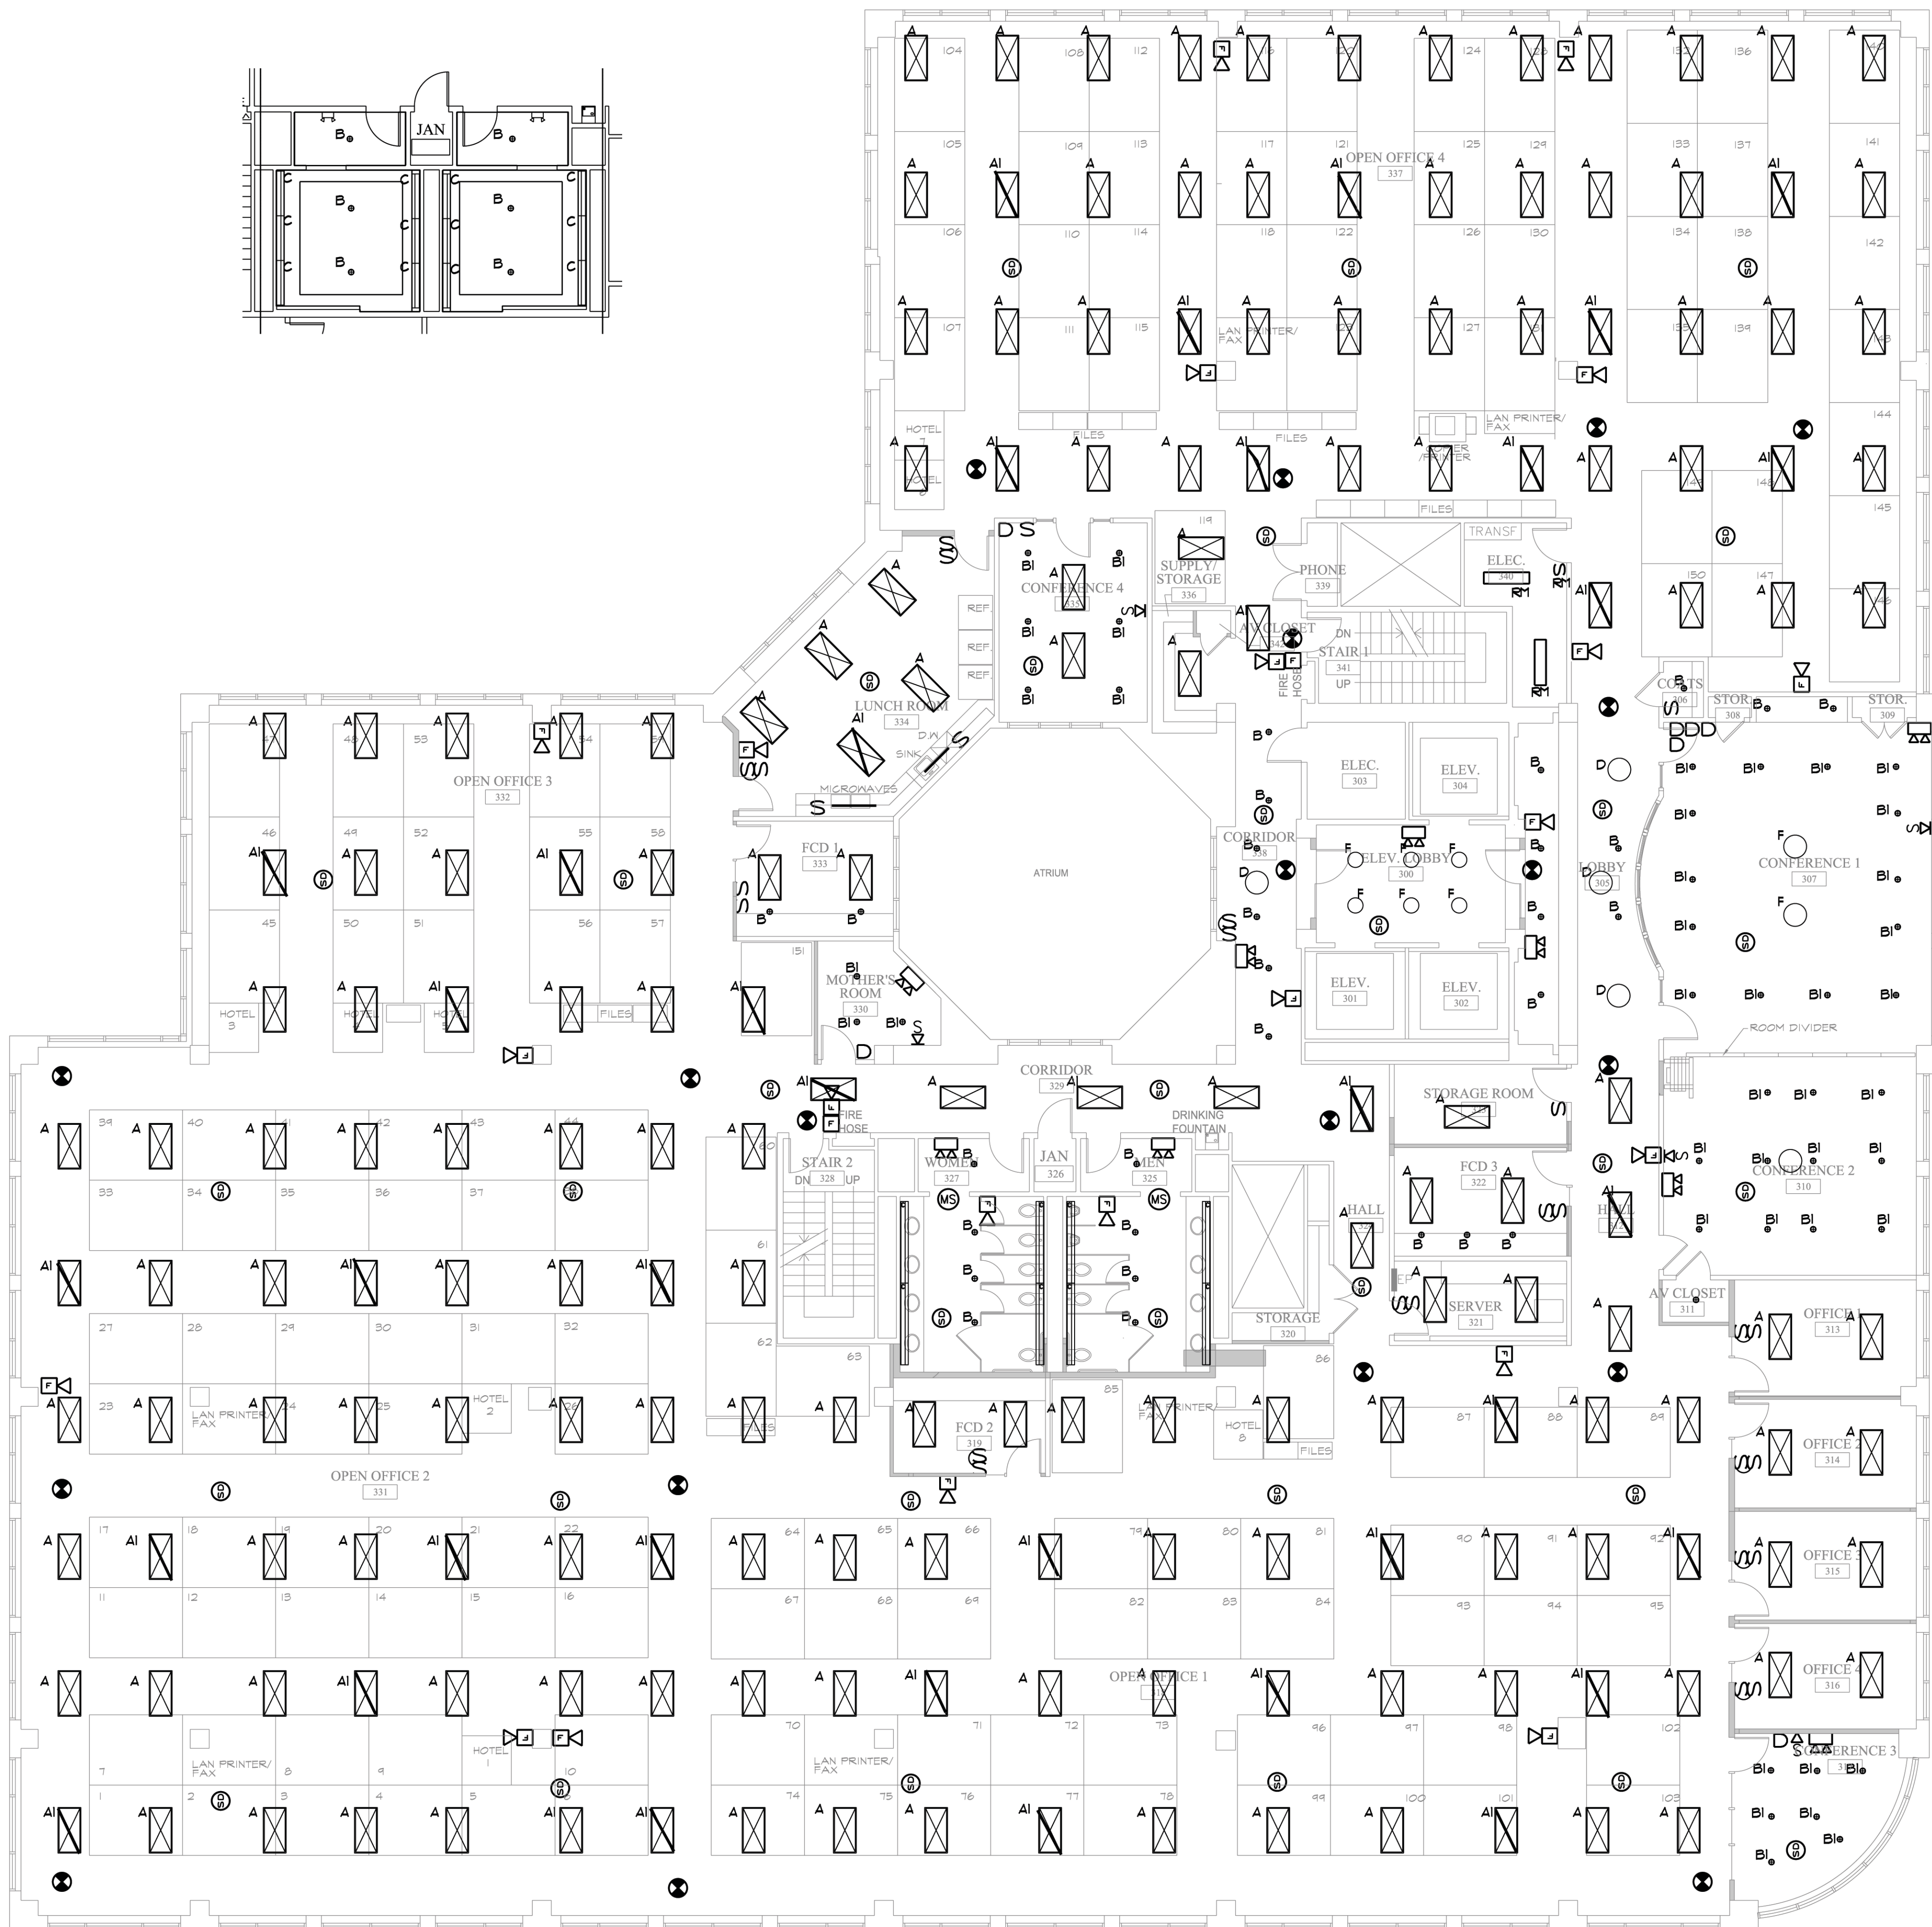


1
2
3
4
5
6
7
8
9
10
11
12
13
14
15
16
17
18
19
20

K
J
I
H
G
F
E
D
C
B
A

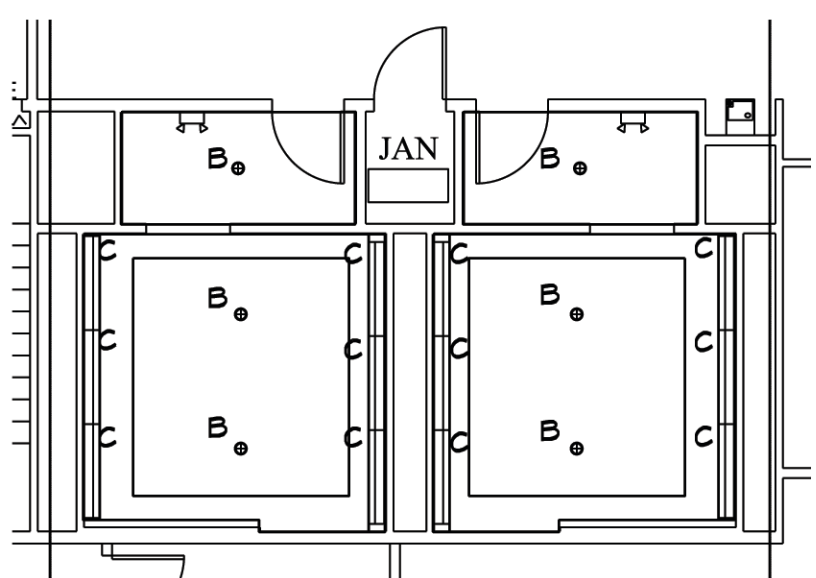

PRUDENTIAL
 TWO PORTLAND SQUARE THIRD FLOOR
 PORTLAND, MAINE

REVISIONS		
#	DATE	DESCRIPTION

DATE:	06.08.10
PROJECT #	040510
DRAWN BY:	JMV
CHECKED BY:	SPDoel
DRAWING SCALE	AS NOTED

SHEET TITLE
 THIRD FLOOR
 LIFE SAFETY PLAN

LS 01

© COPYRIGHT 1985-2003
 REPRODUCTION OR RESALE OF
 THIS DOCUMENT WITHOUT
 WRITTEN PERMISSION OF
 GAWRON ARCHITECTS IS PROHIBITED

THIRD FLOOR LIGHTING PLAN
 SCALE - 1/8" = 1'-0"