
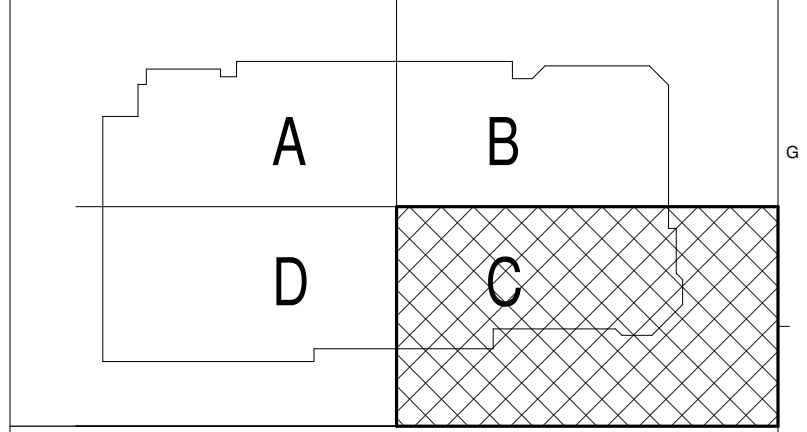



SINK COMBS DETHLEFS

Copyright by
Sink Combs
Dethlefs, P.C.
475 Lincoln Street,
Suite 100
Denver, Colorado 80203
303.398.0200
FAX 303.398.0222

TECHNICAL NOTES:
① CONNECT TO FIRE ALARM SYSTEM FOR AUTOMATIC OPEN ON ACTIVATION OF SMOKE CONTROL SYSTEM (ZONE 2)

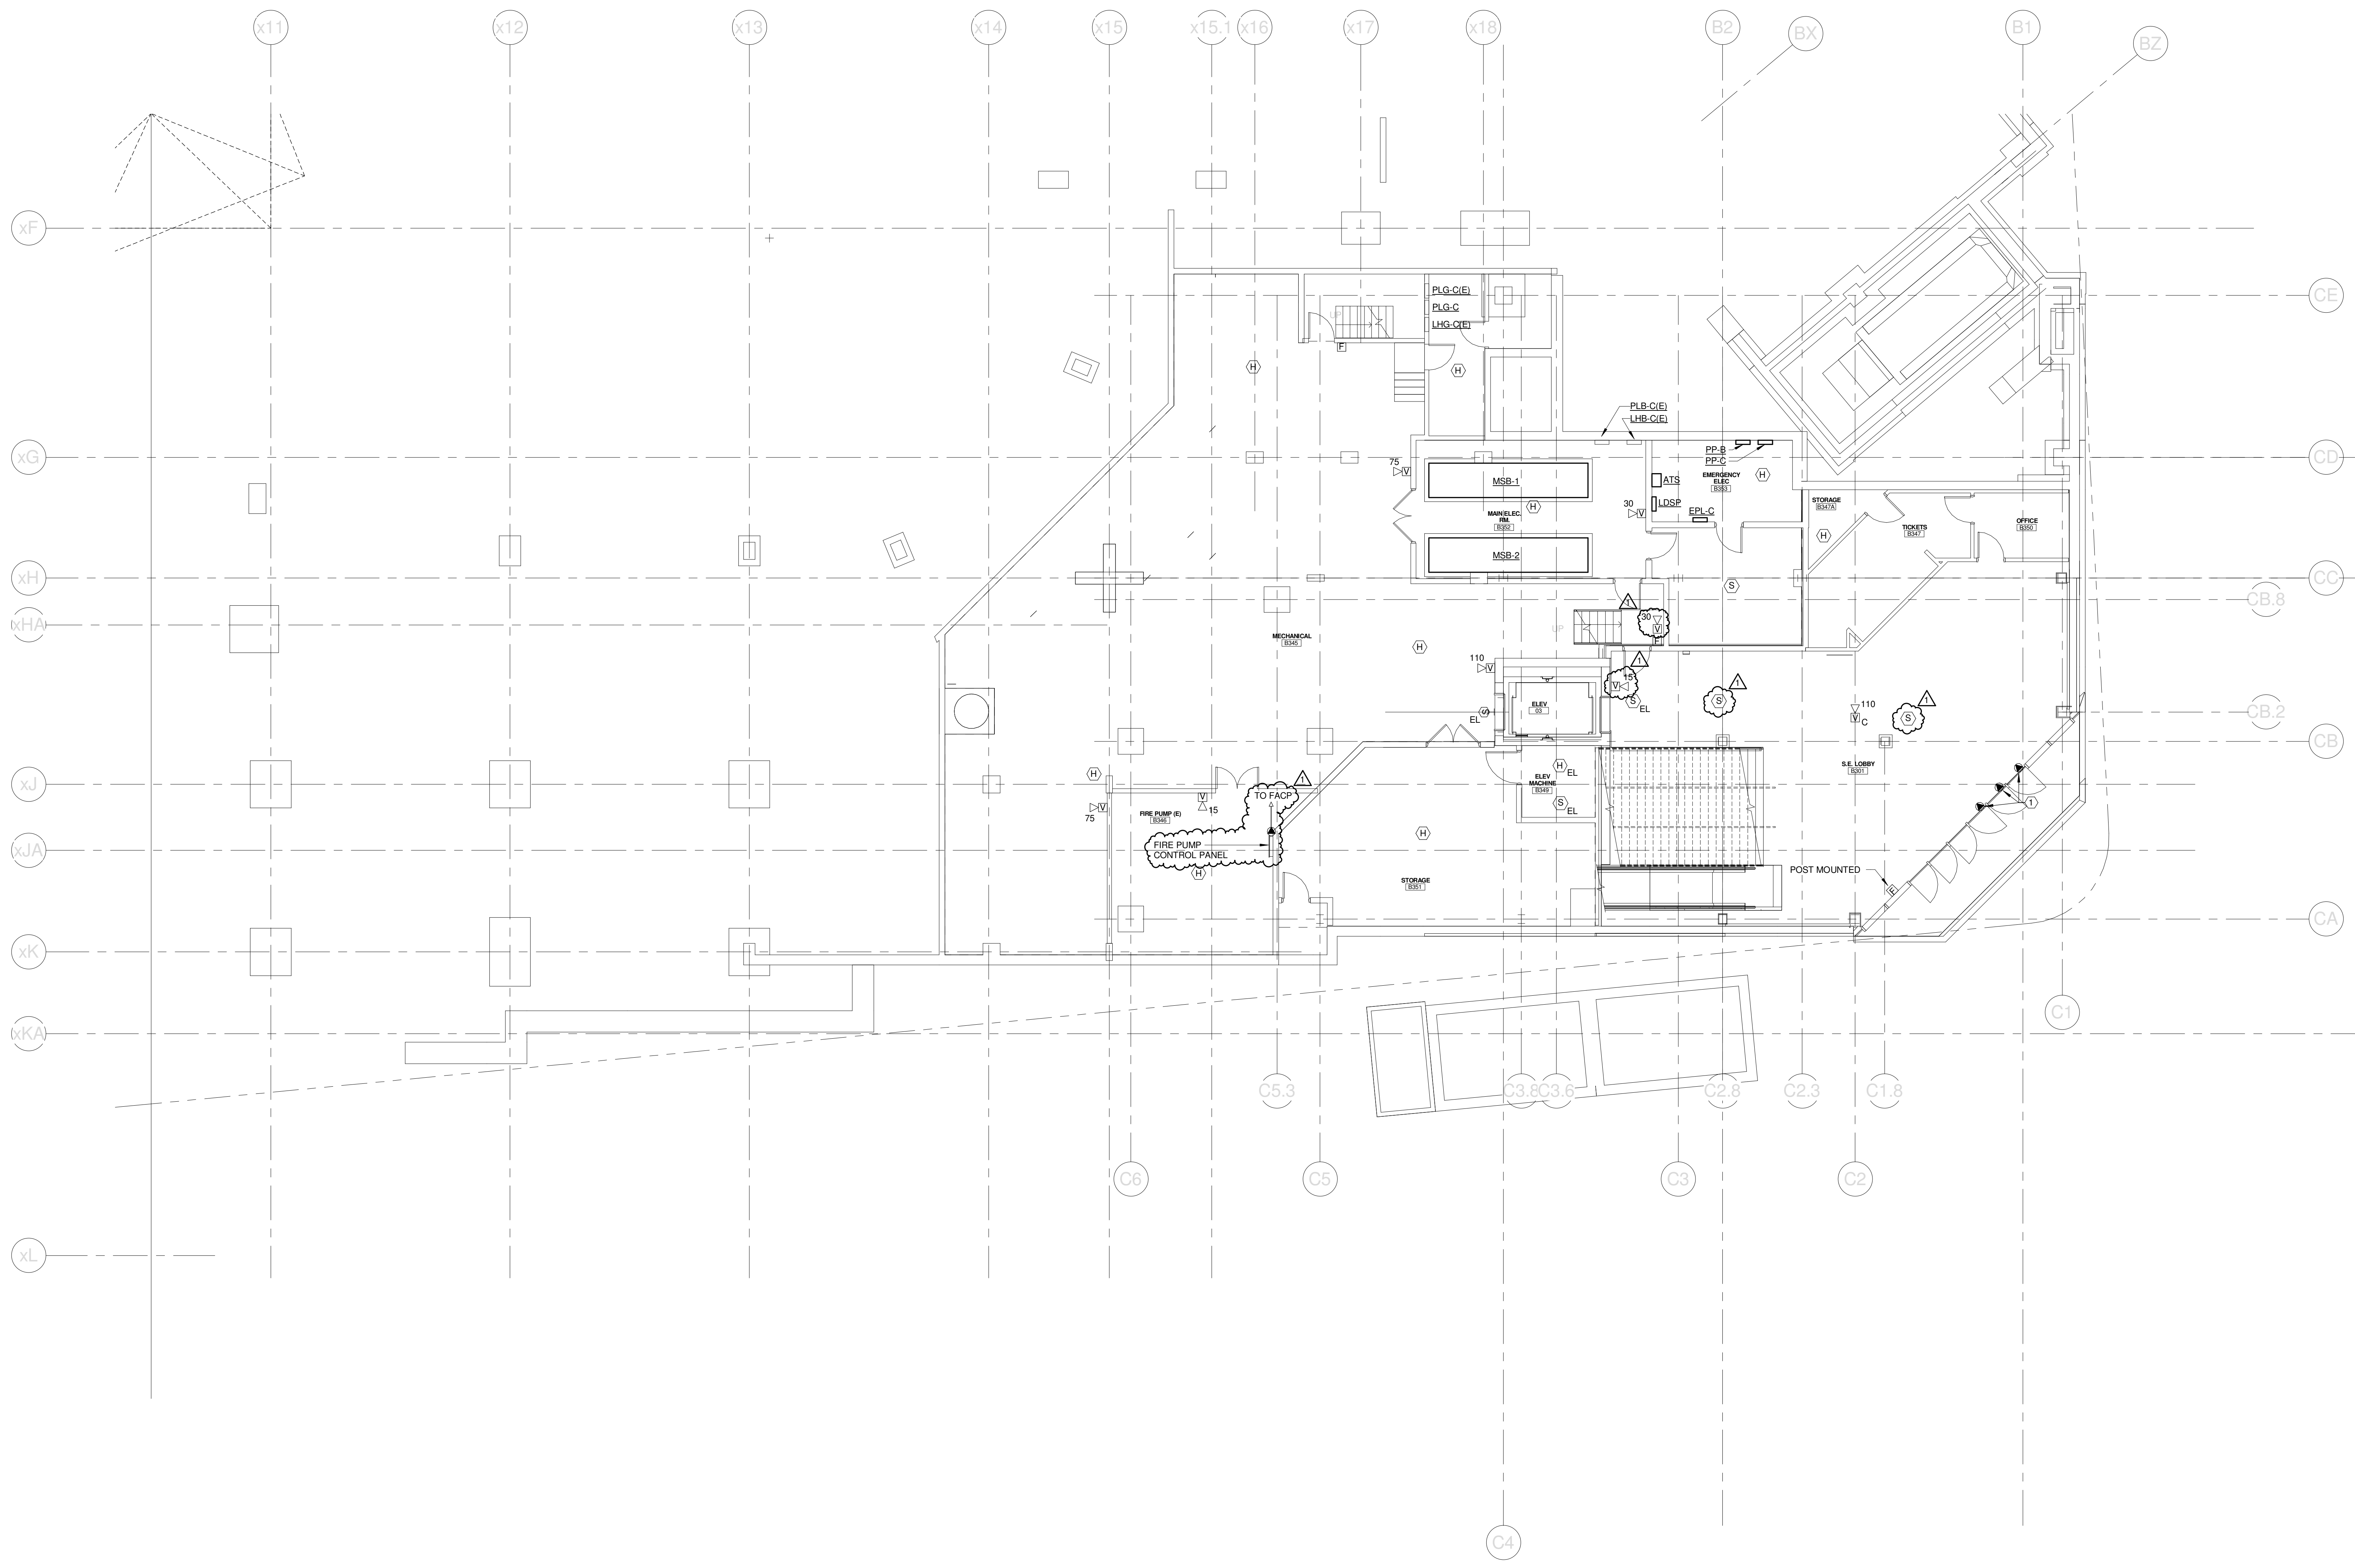

1	SI #073	04-12-2013
0		
REV.	DESCRIPTION	DATE
	SI #073	
	04-12-2013	

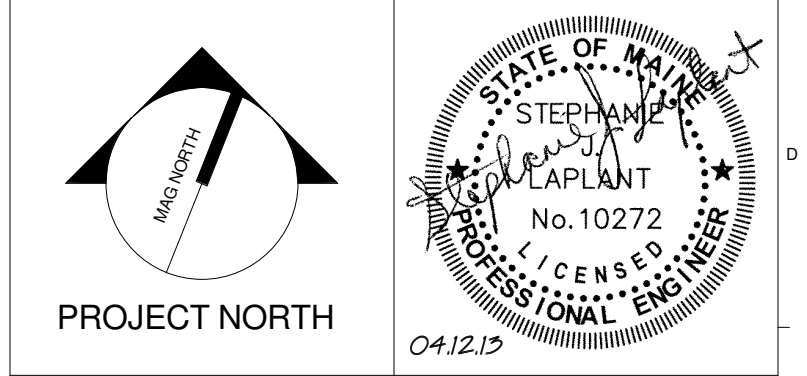

WBRC
ARCHITECTS • ENGINEERS
WWW.WBRCAL.COM
BANGOR, MAINE 307-947-4511
PORTLAND, MAINE 307-838-4511
SARASOTA, FLORIDA 888-556-0727

CUMBERLAND COUNTY CIVIC CENTER RENOVATION
PROJECT: PORTLAND, ME
MECHANICAL LEVEL FIRE ALARM PLAN - QUAD C

WBRC CAD FILE: C:\Users\jaye.mahar\Documents\375700 - CCCC Electrical_jaye.mahar.rvt	
PROJECT No. 375700	GRAPHIC SCALE 1" = 10'
SCALE 1/8" = 1'-0"	
PROJECT MANAGER: JRB	SHEET No. FA.03
DRAWN BY: KRM	
CHECKED BY: S.JL	



4/12/2013 2:07:42 PM C:\Users\jaye.mahar\Documents\375700 - CCCC Electrical_jaye.mahar.rvt

SINK COMBS DETHLEFS


Copyright by
Sink Combs
Dethlefs, P.C.
475 Lincoln Street,
Suite 100
Denver, Colorado 80203
303.398.0200
FAX: 303.398.0202

TECHNICAL NOTES:

- ① OVERHEAD DOOR - CONNECT TO FIRE ALARM SYSTEM FOR AUTOMATIC OPEN ON ACTIVATION OF SMOKE CONTROL SYSTEM (ALL ZONES).

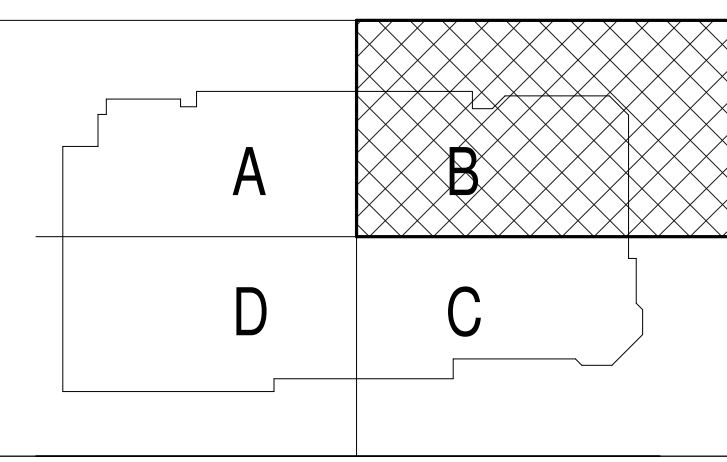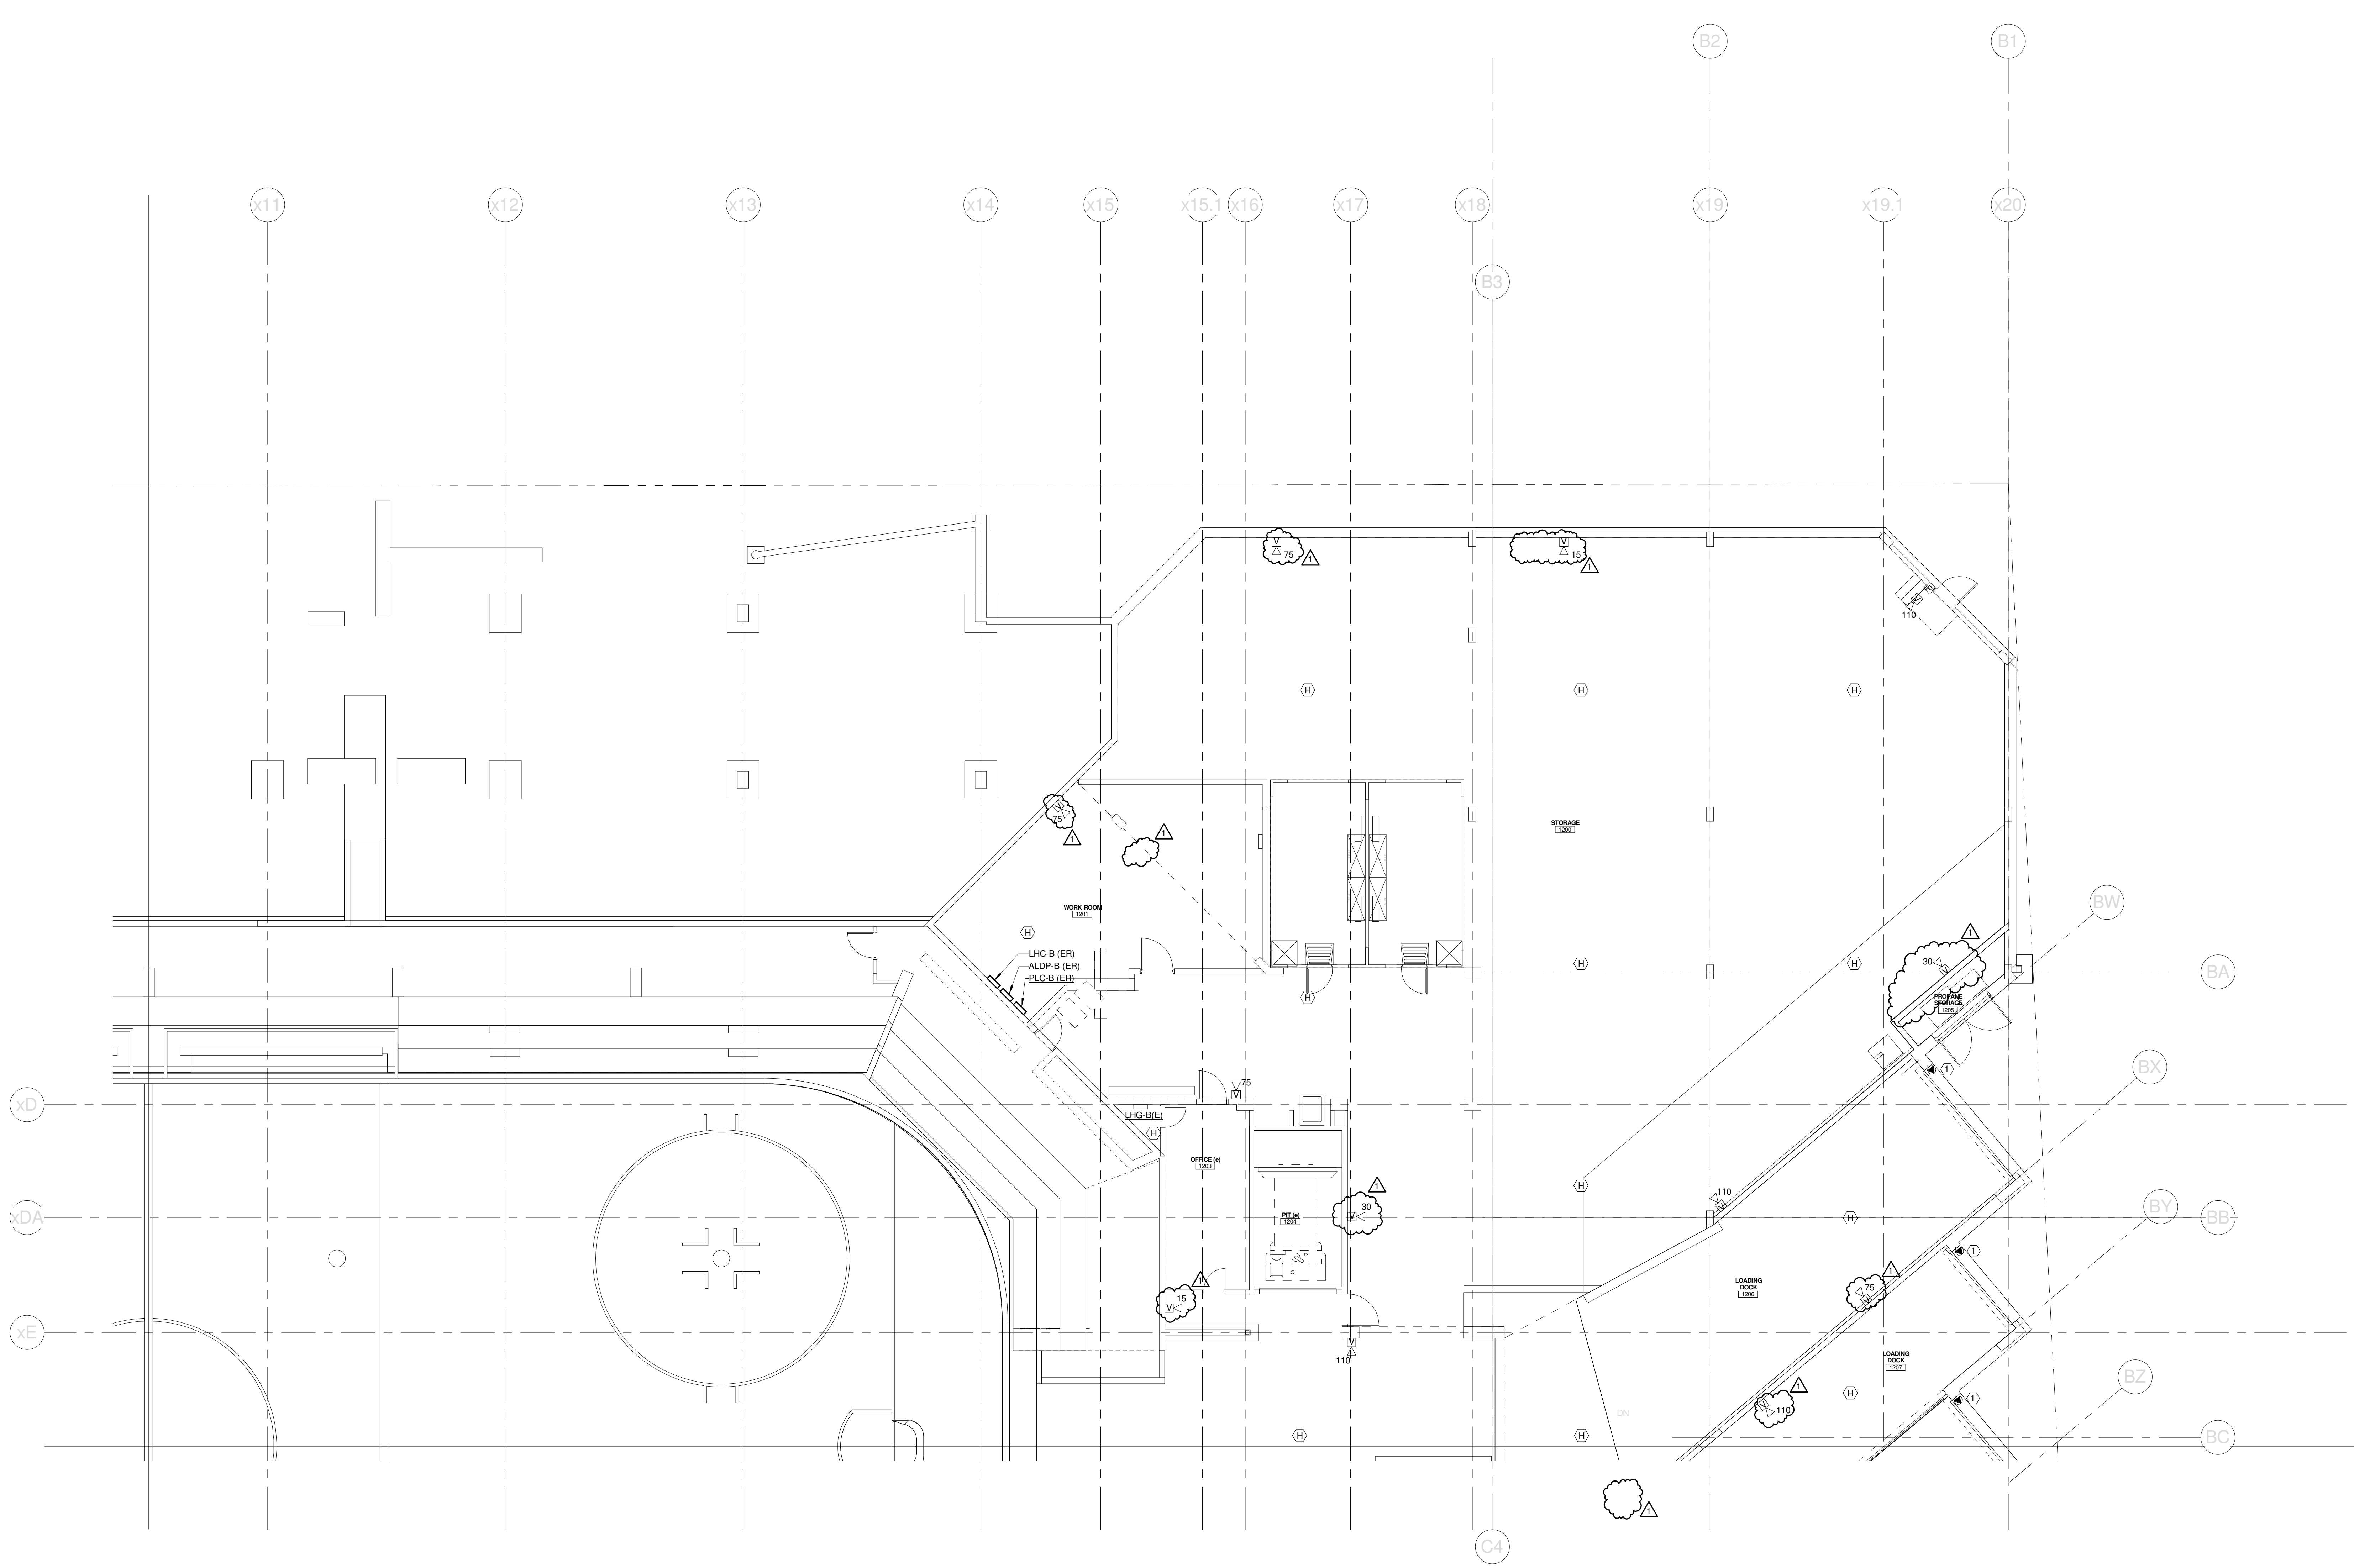

1	SI #073	04-12-2013
0		
REV.	DESCRIPTION	DATE
	SI #073	
	04-12-2013	

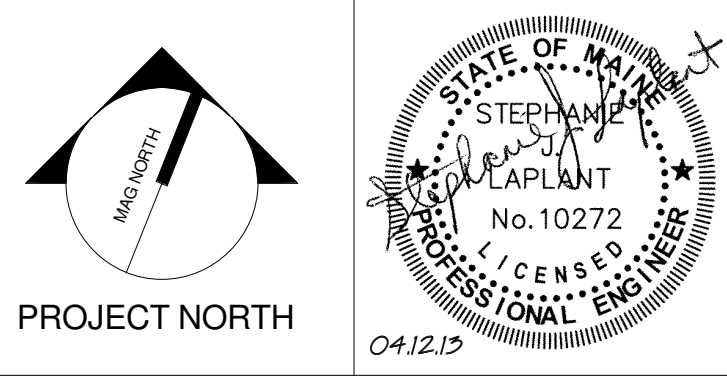

WBRC
ARCHITECTS • ENGINEERS
www.wbrcal.com
BANGOR, MAINE 207.947.4511
PORTLAND, MAINE 207.838.4511
SARASOTA, FLORIDA 941.556.0727

CUMBERLAND COUNTY CIVIC CENTER RENOVATION
PROJECT: PORTLAND, ME
EVENT LEVEL FIRE ALARM PLAN - QUAD B

SHEET TITLE	
WBRC CAD FILE: C:\Users\jlmahar\Documents\375700 - CCCC Electrical_1\jlmahar.rvt	
PROJECT No. 375700	GRAPHIC SCALE: 1" = 1'-0"
SCALE: 1/8" = 1'-0"	
PROJECT MANAGER: JRB	SHEET No.
DRAWN BY: KRM	FA.12B
CHECKED BY: SLL	



4/12/2013 3:26:03 PM C:\Users\jlmahar\Documents\375700 - CCCC Electrical_1\jlmahar.rvt

SINK COMBS DETHLEFS

Copyright by
Sink Combs
Dethlefs, P.C.
475 Lincoln Street,
Suite 100
Denver, Colorado 80203
303.398.0200
FAX 303.398.0222


TECHNICAL NOTES:

- ① OVERHEAD DOOR - CONNECT TO FIRE ALARM SYSTEM FOR AUTOMATIC OPEN ON ACTIVATION OF SMOKE CONTROL SYSTEM (ALL ZONES).

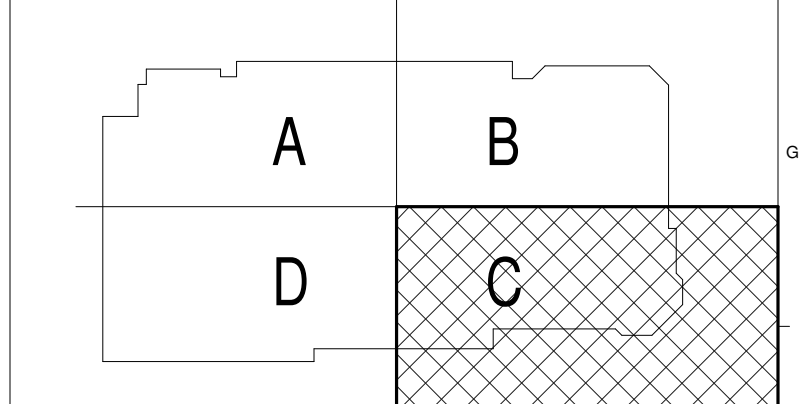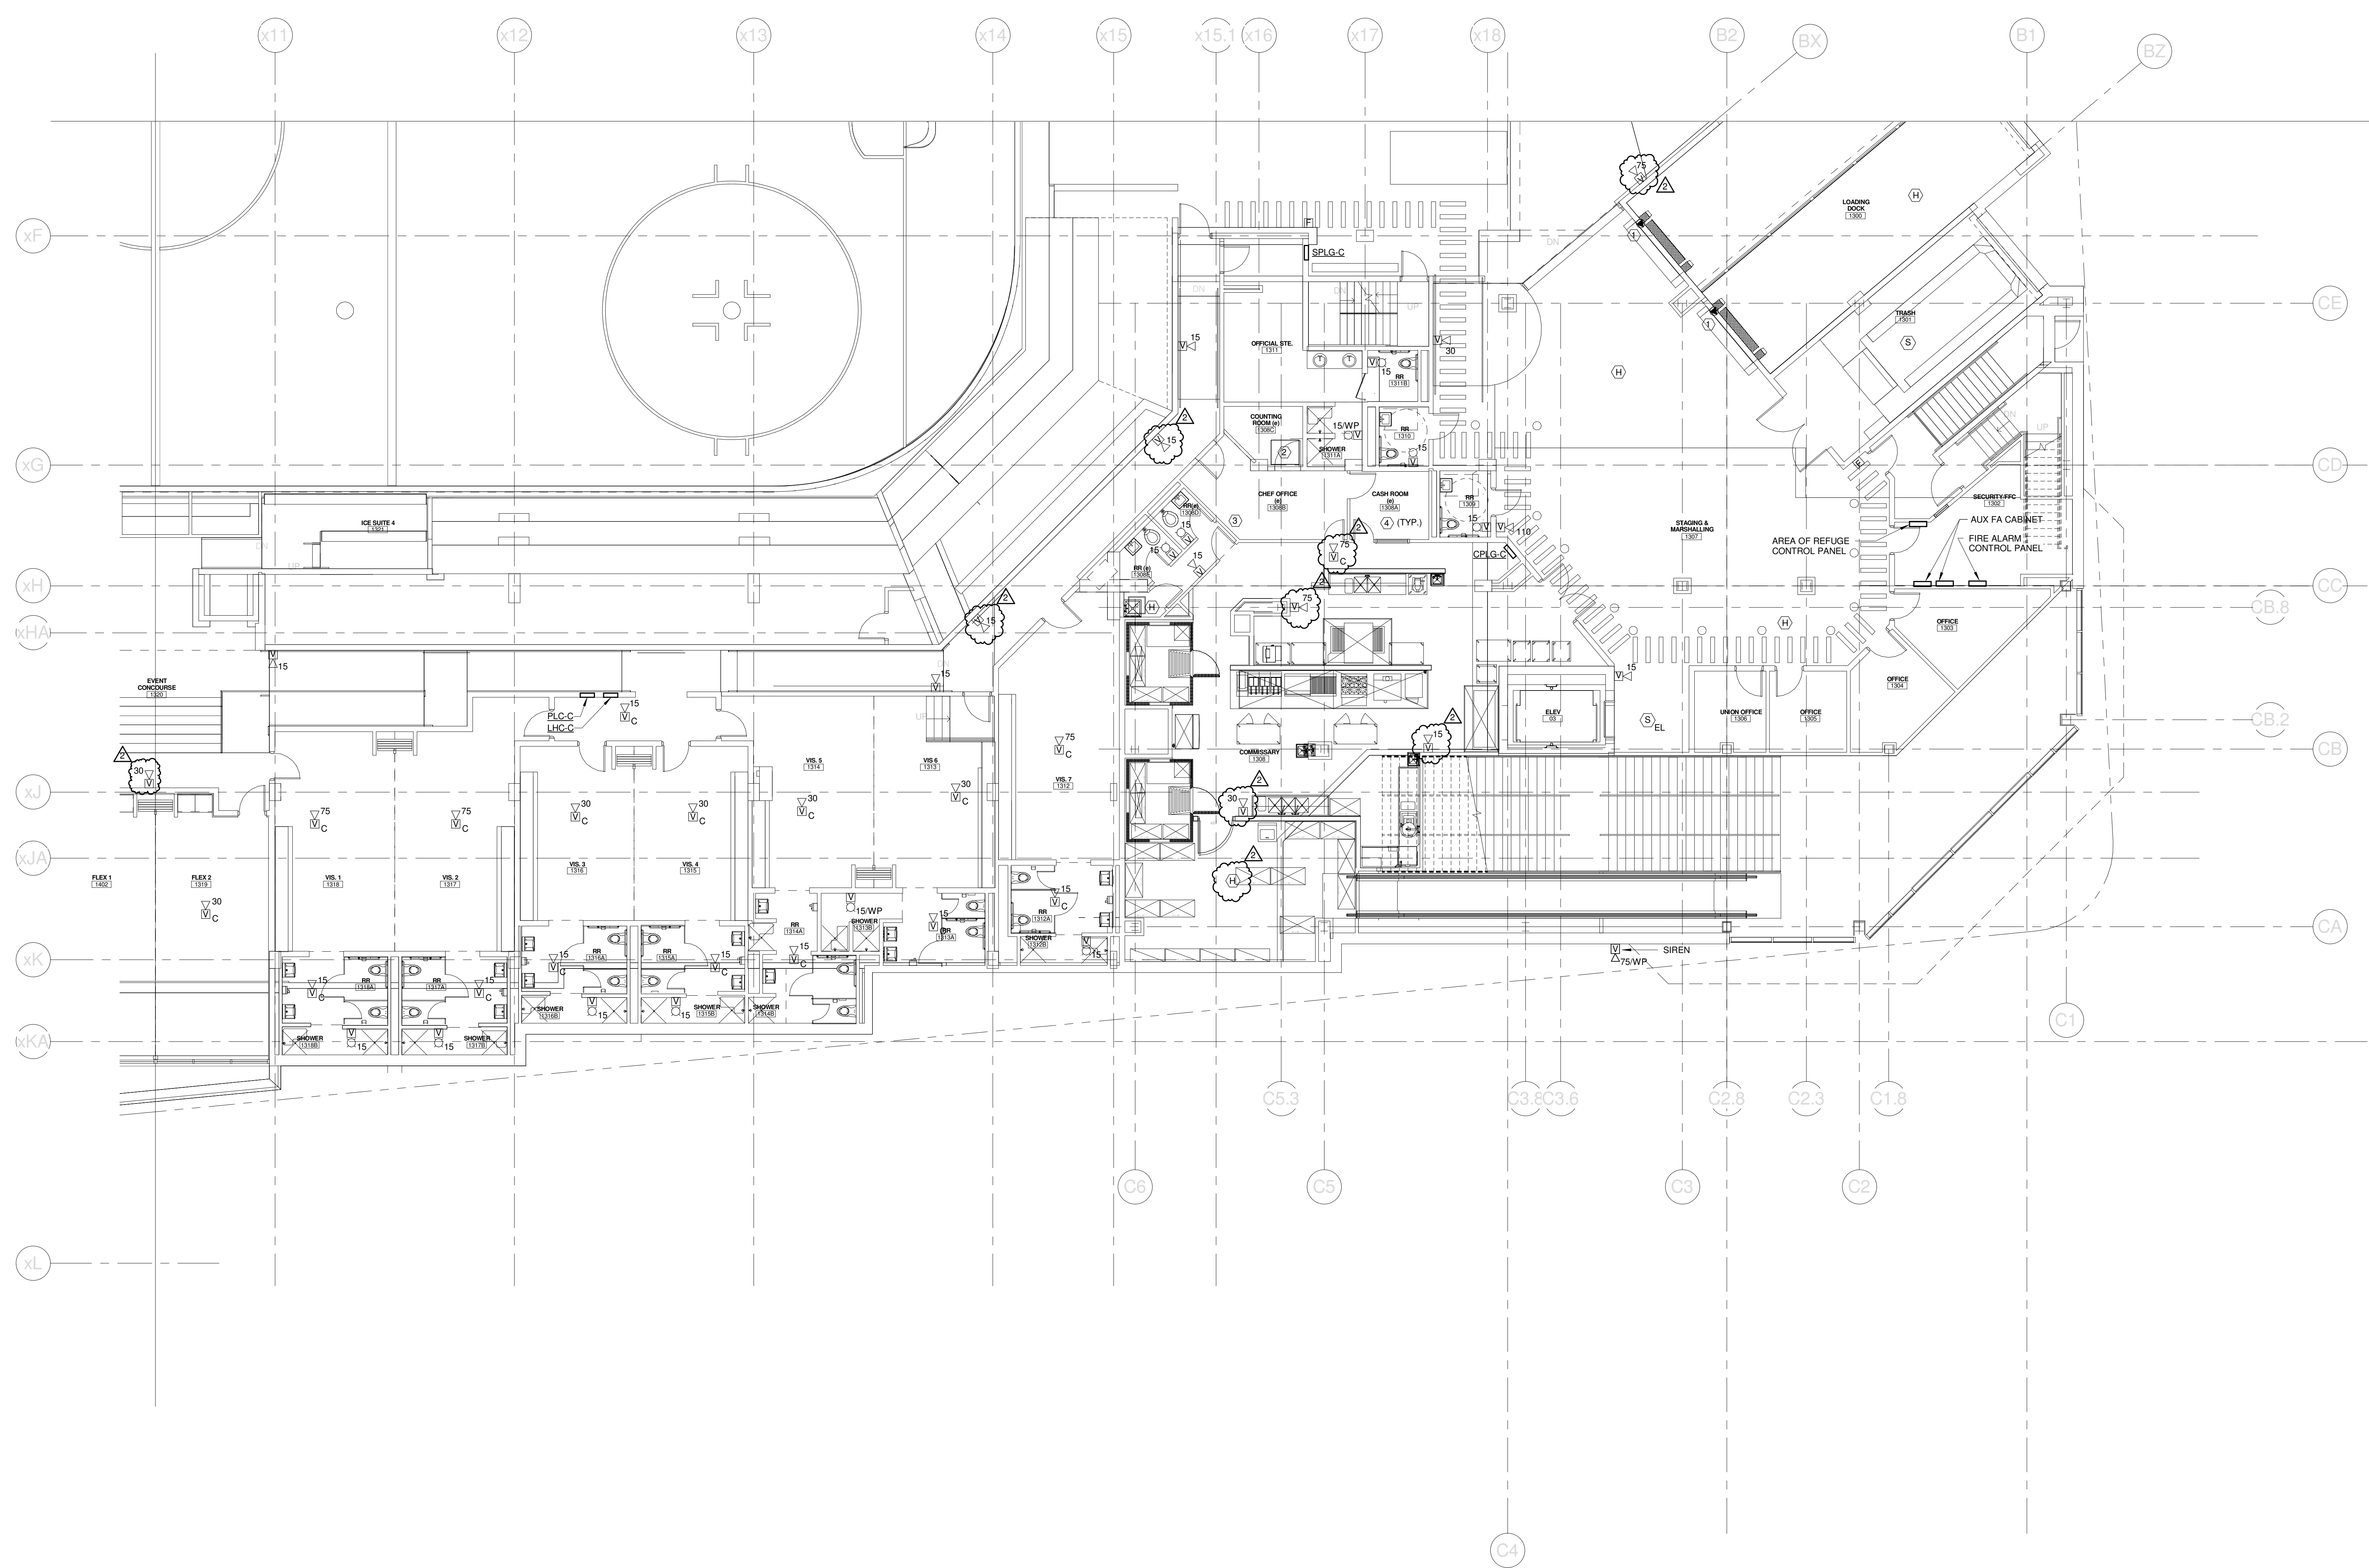

2	SI #073	04-12-2013
1	SI #027.1	02-06-2013
0		

REV.	DESCRIPTION	DATE
	SI #073	
	04-12-2013	

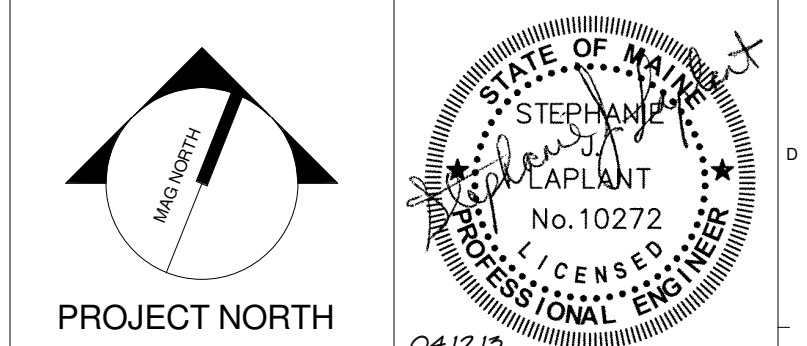

WBRC
ARCHITECTS • ENGINEERS
WWW.WBRCAL.COM
BANGOR, MAINE 207.947.4511
PORTLAND, MAINE 207.838.4511
SARASOTA, FLORIDA 941.556.0727



CUMBERLAND COUNTY CIVIC CENTER RENOVATION

PROJECT: PORTLAND, ME
EVENT LEVEL FIRE ALARM PLAN - QUAD C


SHEET TITLE	EVENT LEVEL FIRE ALARM PLAN - QUAD C
WBRC CAD FILE	C:\Users\jaye\Documents\375700 - CCCC Electrical\jaye.mahr.rvt
PROJECT No.	375700
SCALE	1/8" = 1'-0"
PROJECT MANAGER	JRB
DRAWN BY	KRM
CHECKED BY	SJL
SHEET No.	FA.13B

SINK COMBS DETHLEFS

Copyright by
Sink Combs
Dethlefs, P.C.
475 Lincoln Street,
Suite 100
Denver, Colorado 80202
303.398.0200
FAX 303.398.0222

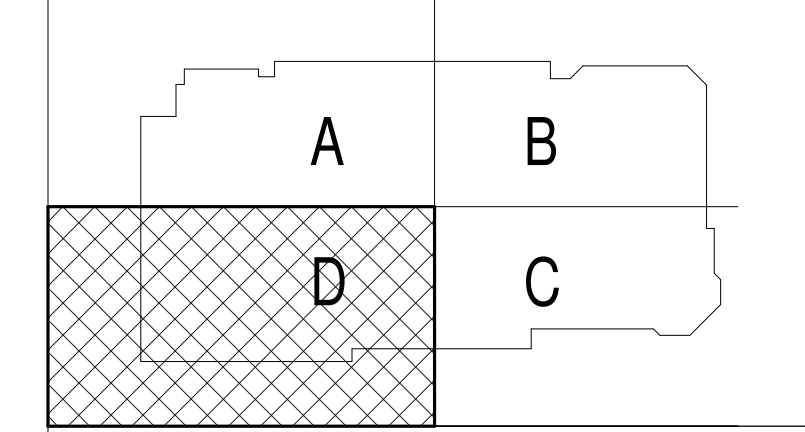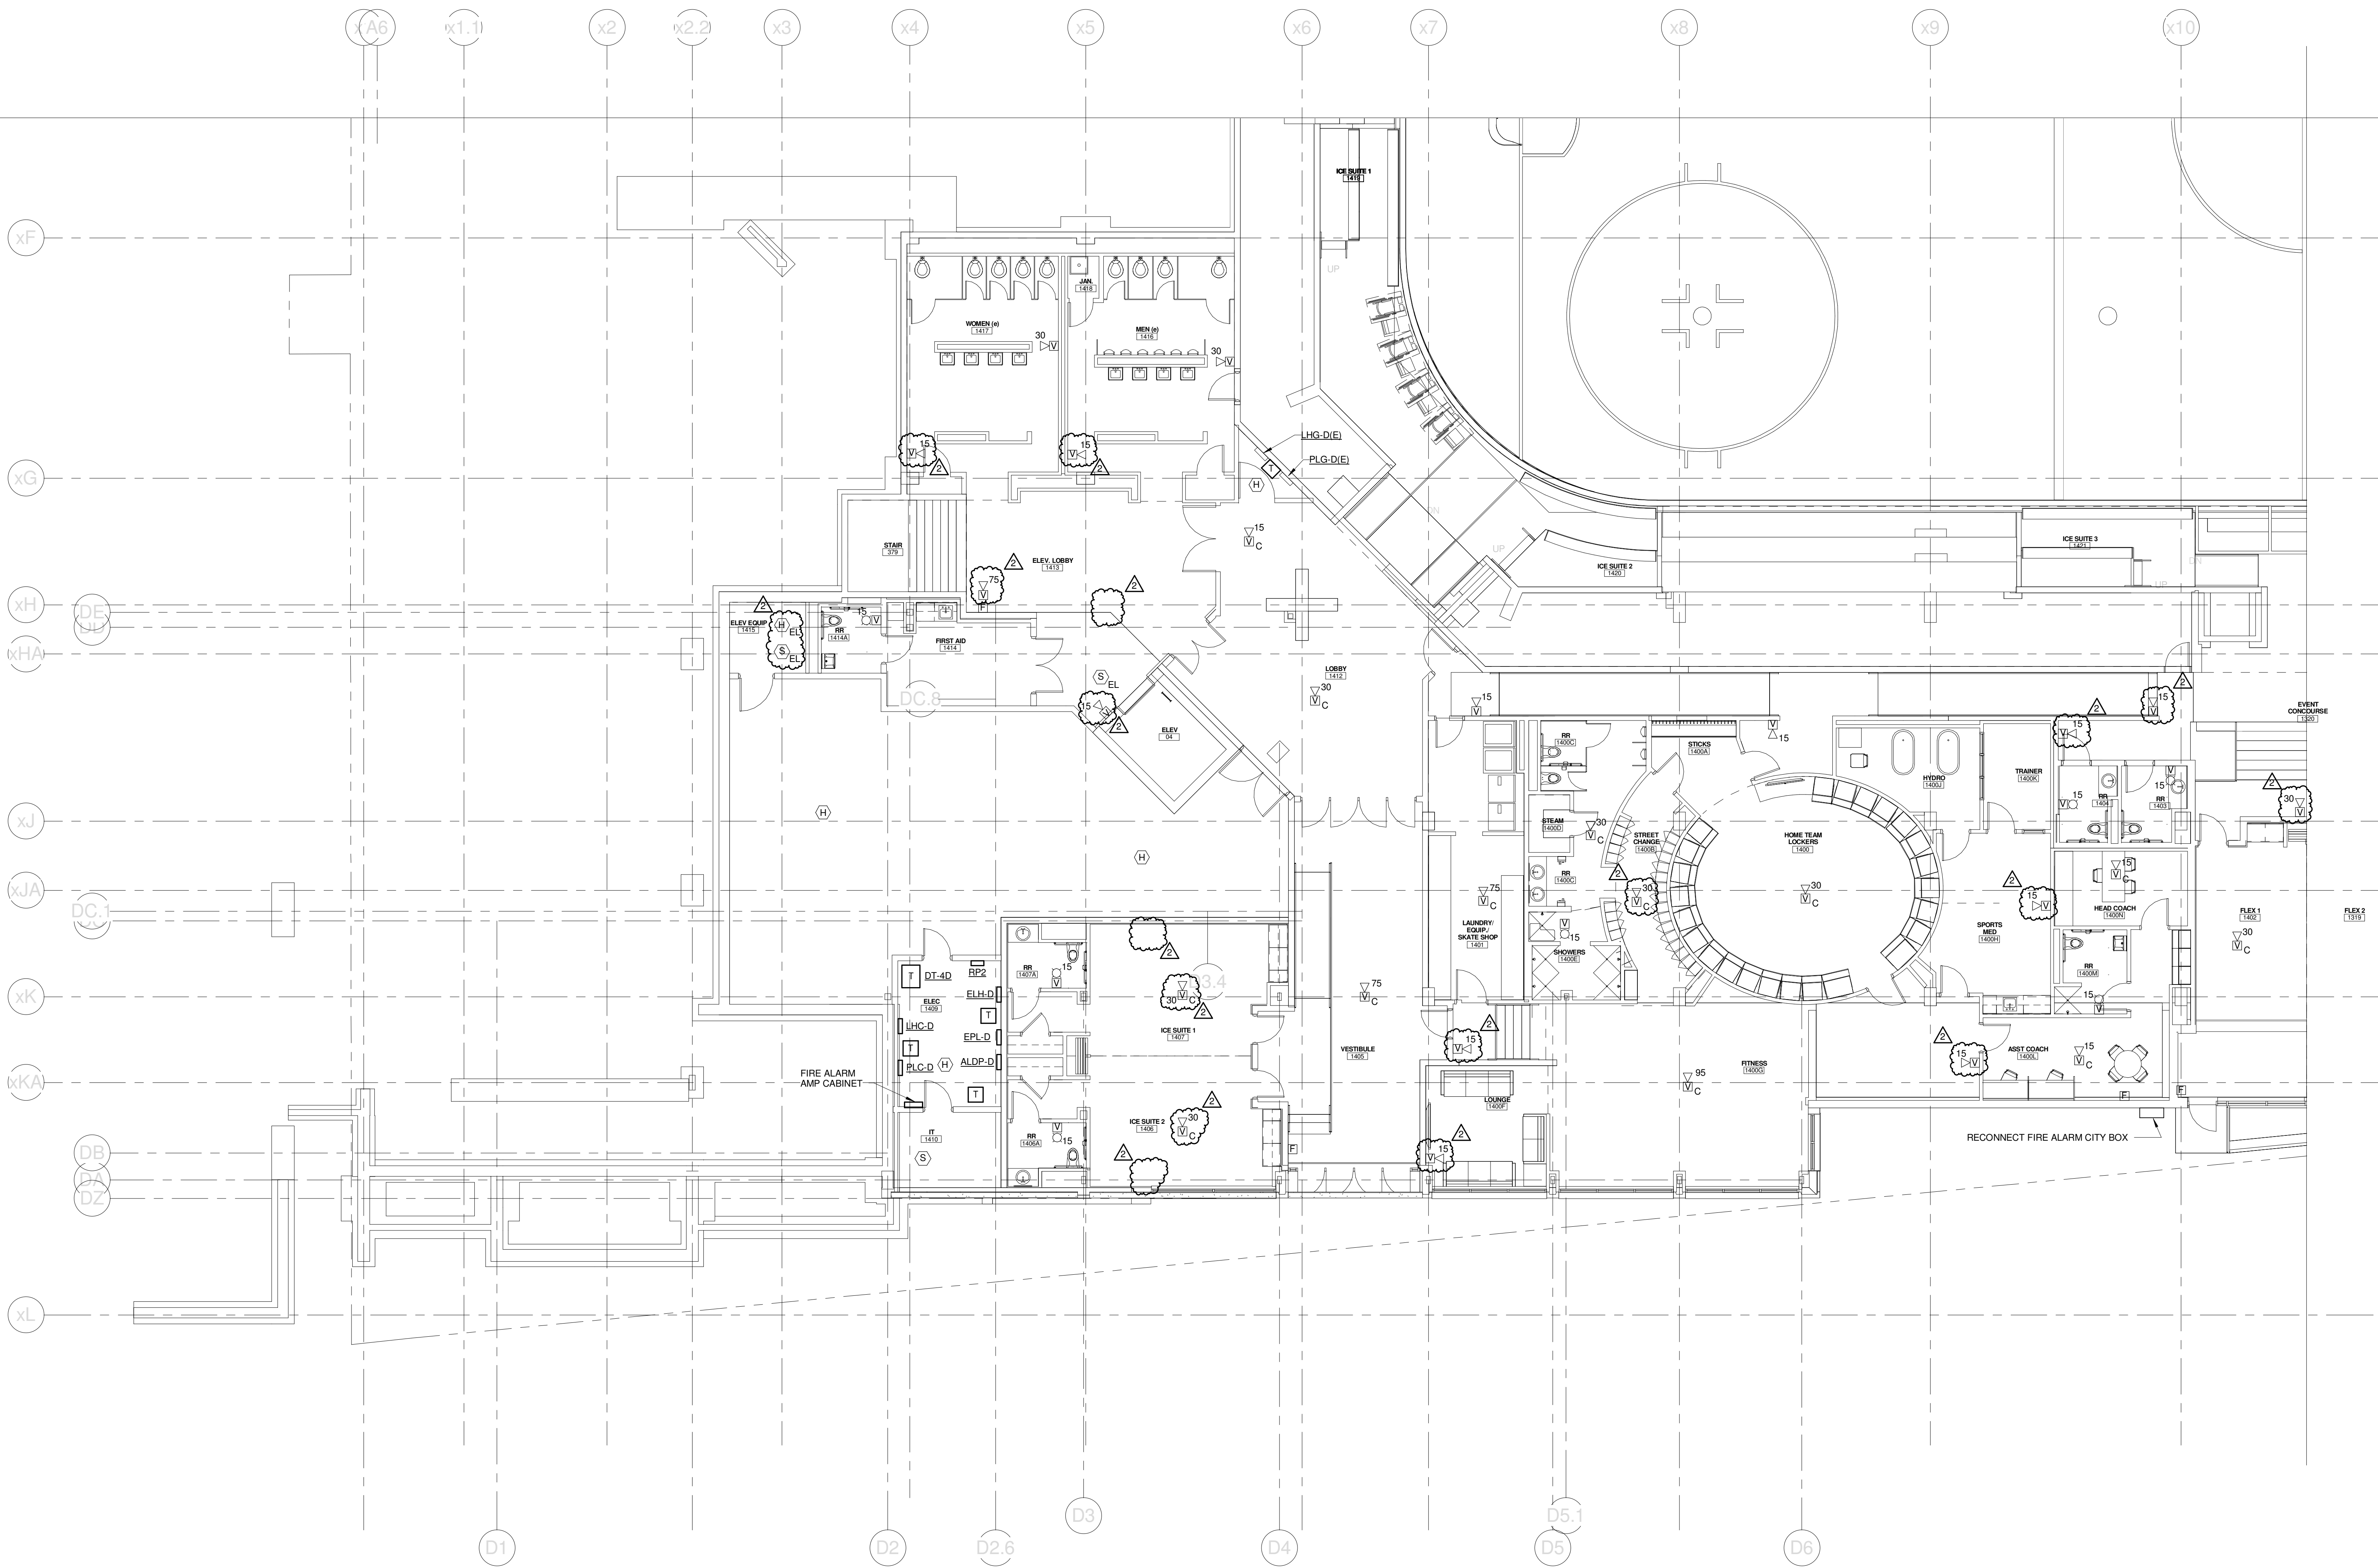

2	SI #073	04-12-2013
1	SI #027.1	02-06-2013
0		
REV.	DESCRIPTION	DATE
	SI #073	
	04-12-2013	

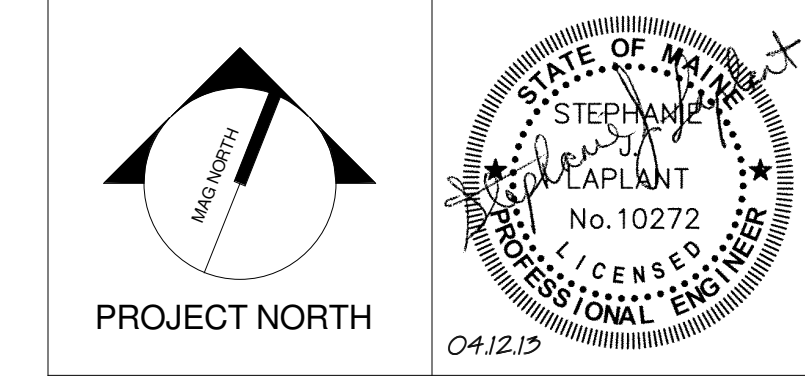

WBRC
ARCHITECTS • ENGINEERS
WWW.WBRCAL.COM
BANGOR, MAINE 207.947.4511
PORTLAND, MAINE 207.838.4511
SARASOTA, FLORIDA 941.556.0727

CUMBERLAND COUNTY CIVIC CENTER RENOVATION
PROJECT: PORTLAND, ME
EVENT LEVEL FIRE ALARM PLAN - QUAD D



SHEET TITLE	
WBRC CAD FILE: C:\Users\jaye\Documents\375700 - CCCC Electrical_jaye.mahar.rvt	
PROJECT No. 375700	GRAPHIC SCALE OF 1" = 1'-0"
SCALE 1/8" = 1'-0"	
PROJECT MANAGER: JRB	SHEET No.
DRAWN BY: KRM	FA.14B
CHECKED BY: S.L.	

SINK COMBS DETHLEFS


Copyright by
Sink Combs
Dethlefs, P.C.
475 Lincoln Street,
Suite 100
Denver, Colorado 80203
303.398.0200
FAX 303.398.0202

TECHNICAL NOTES:

- ④ CONNECT TO FIRE ALARM SYSTEM FOR AUTOMATIC OPEN ON ACTIVATION OF SMOKE CONTROL SYSTEM (ZONE 3).

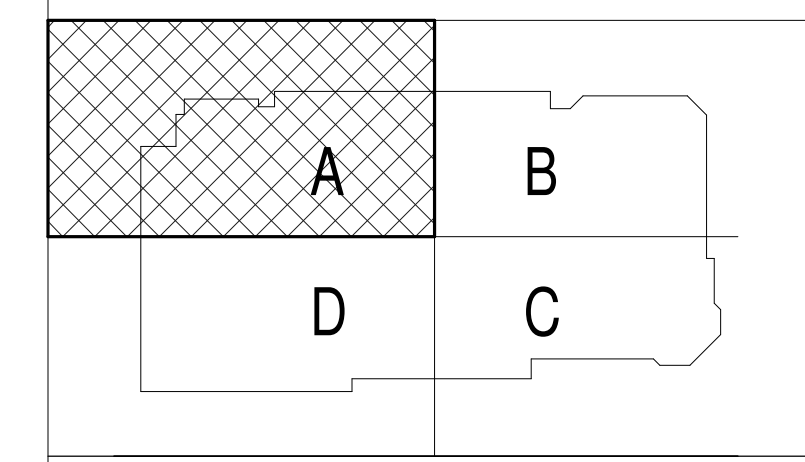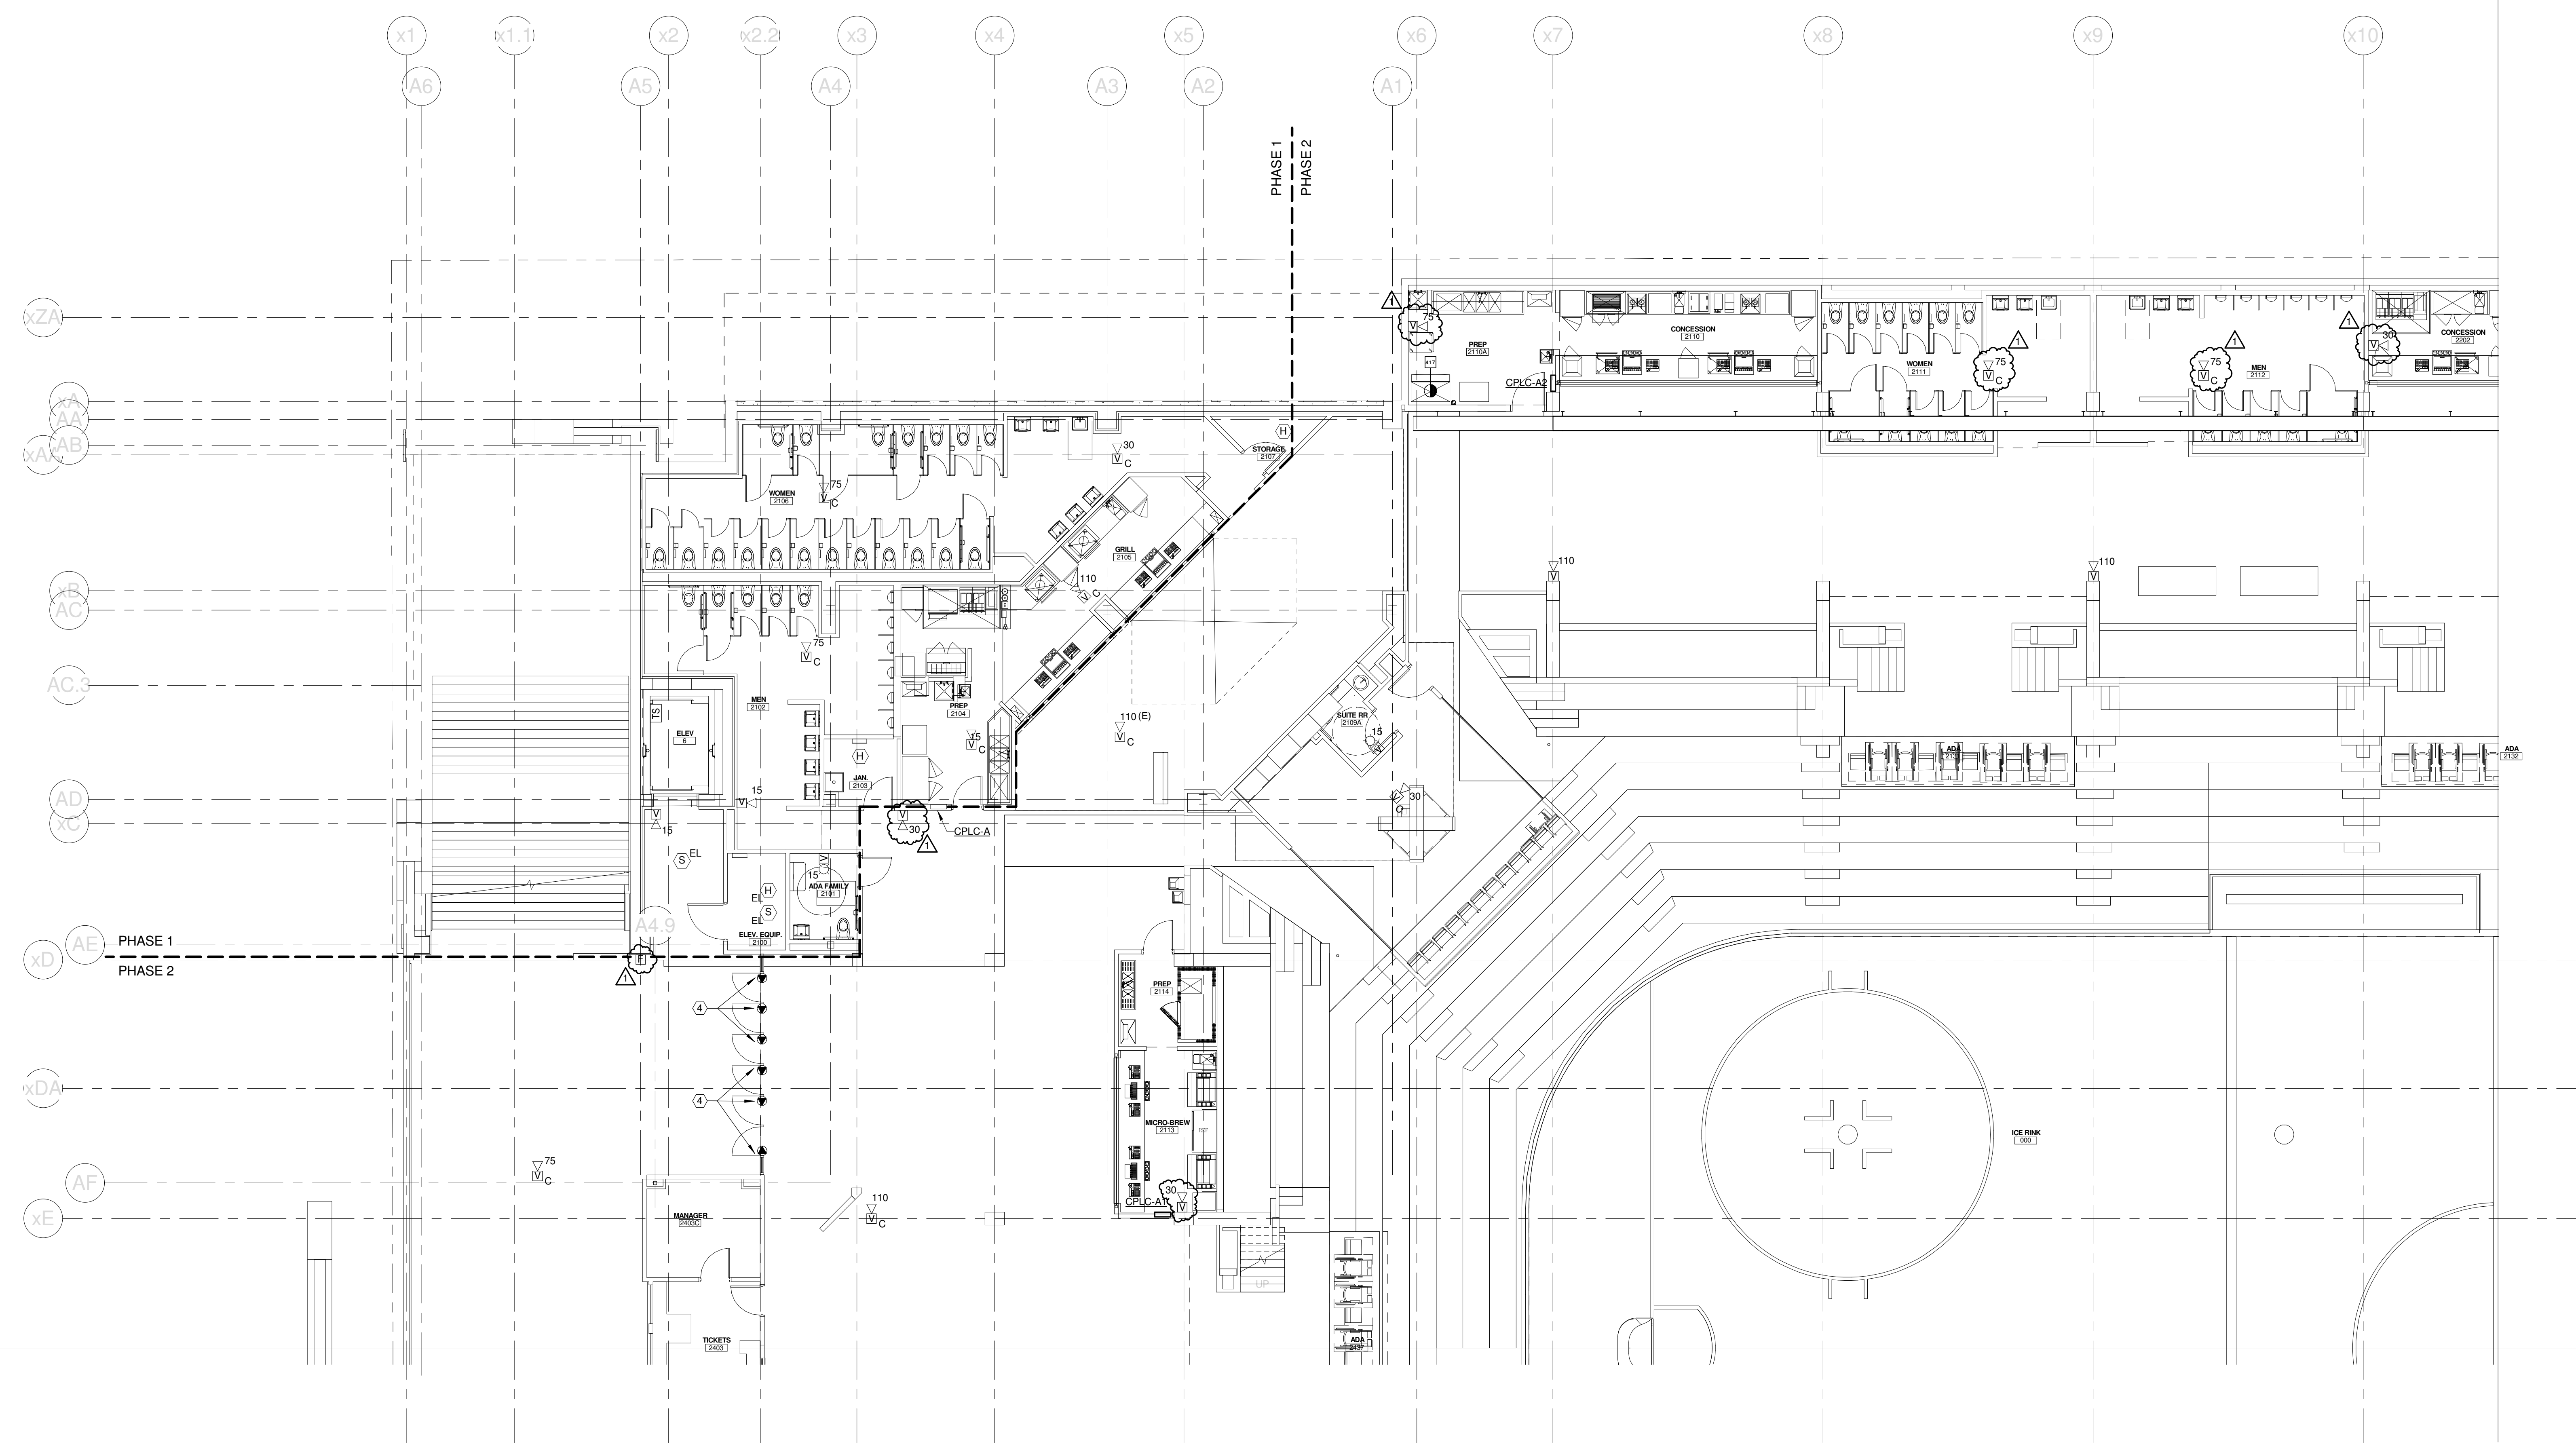

1	SI #073	04-12-2013
0		
REV.	DESCRIPTION	DATE
	SI #073	
	04-12-2013	

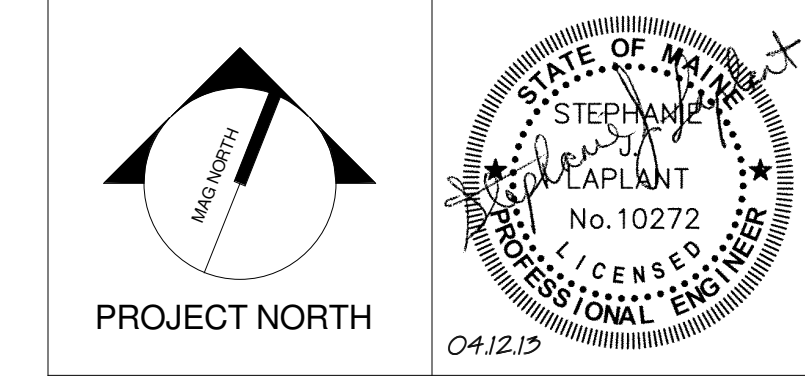



WBRC
ARCHITECTS • ENGINEERS
WWW.WBRCAL.COM
BANGOR, MAINE 307-947-4511
PORTLAND, MAINE 307-838-4511
SARASOTA, FLORIDA 813-556-0727

CUMBERLAND COUNTY CIVIC CENTER RENOVATION
PROJECT: PORTLAND, ME
CONCOURSE LEVEL FIRE ALARM PLAN - QUAD A


WBRC CAD FILE: C:\Users\jaye.mahar\Documents\375700 - CCCC Electrical_1.jaye.mahar.rvt	
PROJECT No. 375700	GRAPHIC SCALE: 1" = 1'-0"
SCALE: 1/8" = 1'-0"	
PROJECT MANAGER: JRB	SHEET No. FA.21B
DRAWN BY: KRM	
CHECKED BY: SJL	

SINK COMBS DETHLEFS

Copyright by
WBRC
Dethlefs, P.C.
475 Lincoln Street,
Suite 100
Denver, Colorado 80203
303.398.0200
FAX 303.398.0202

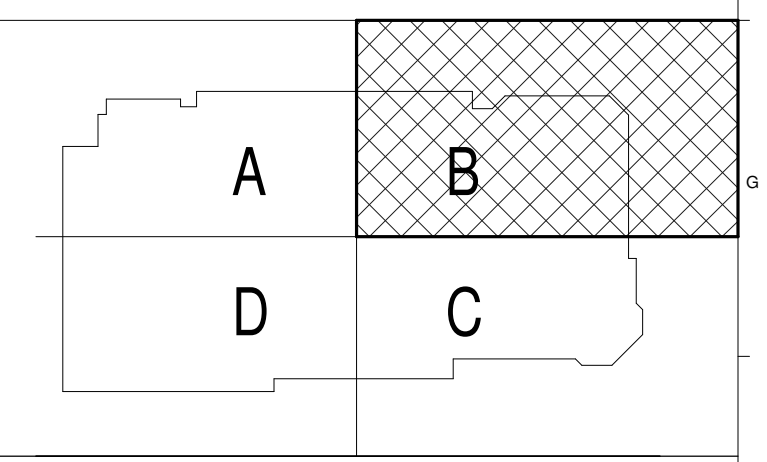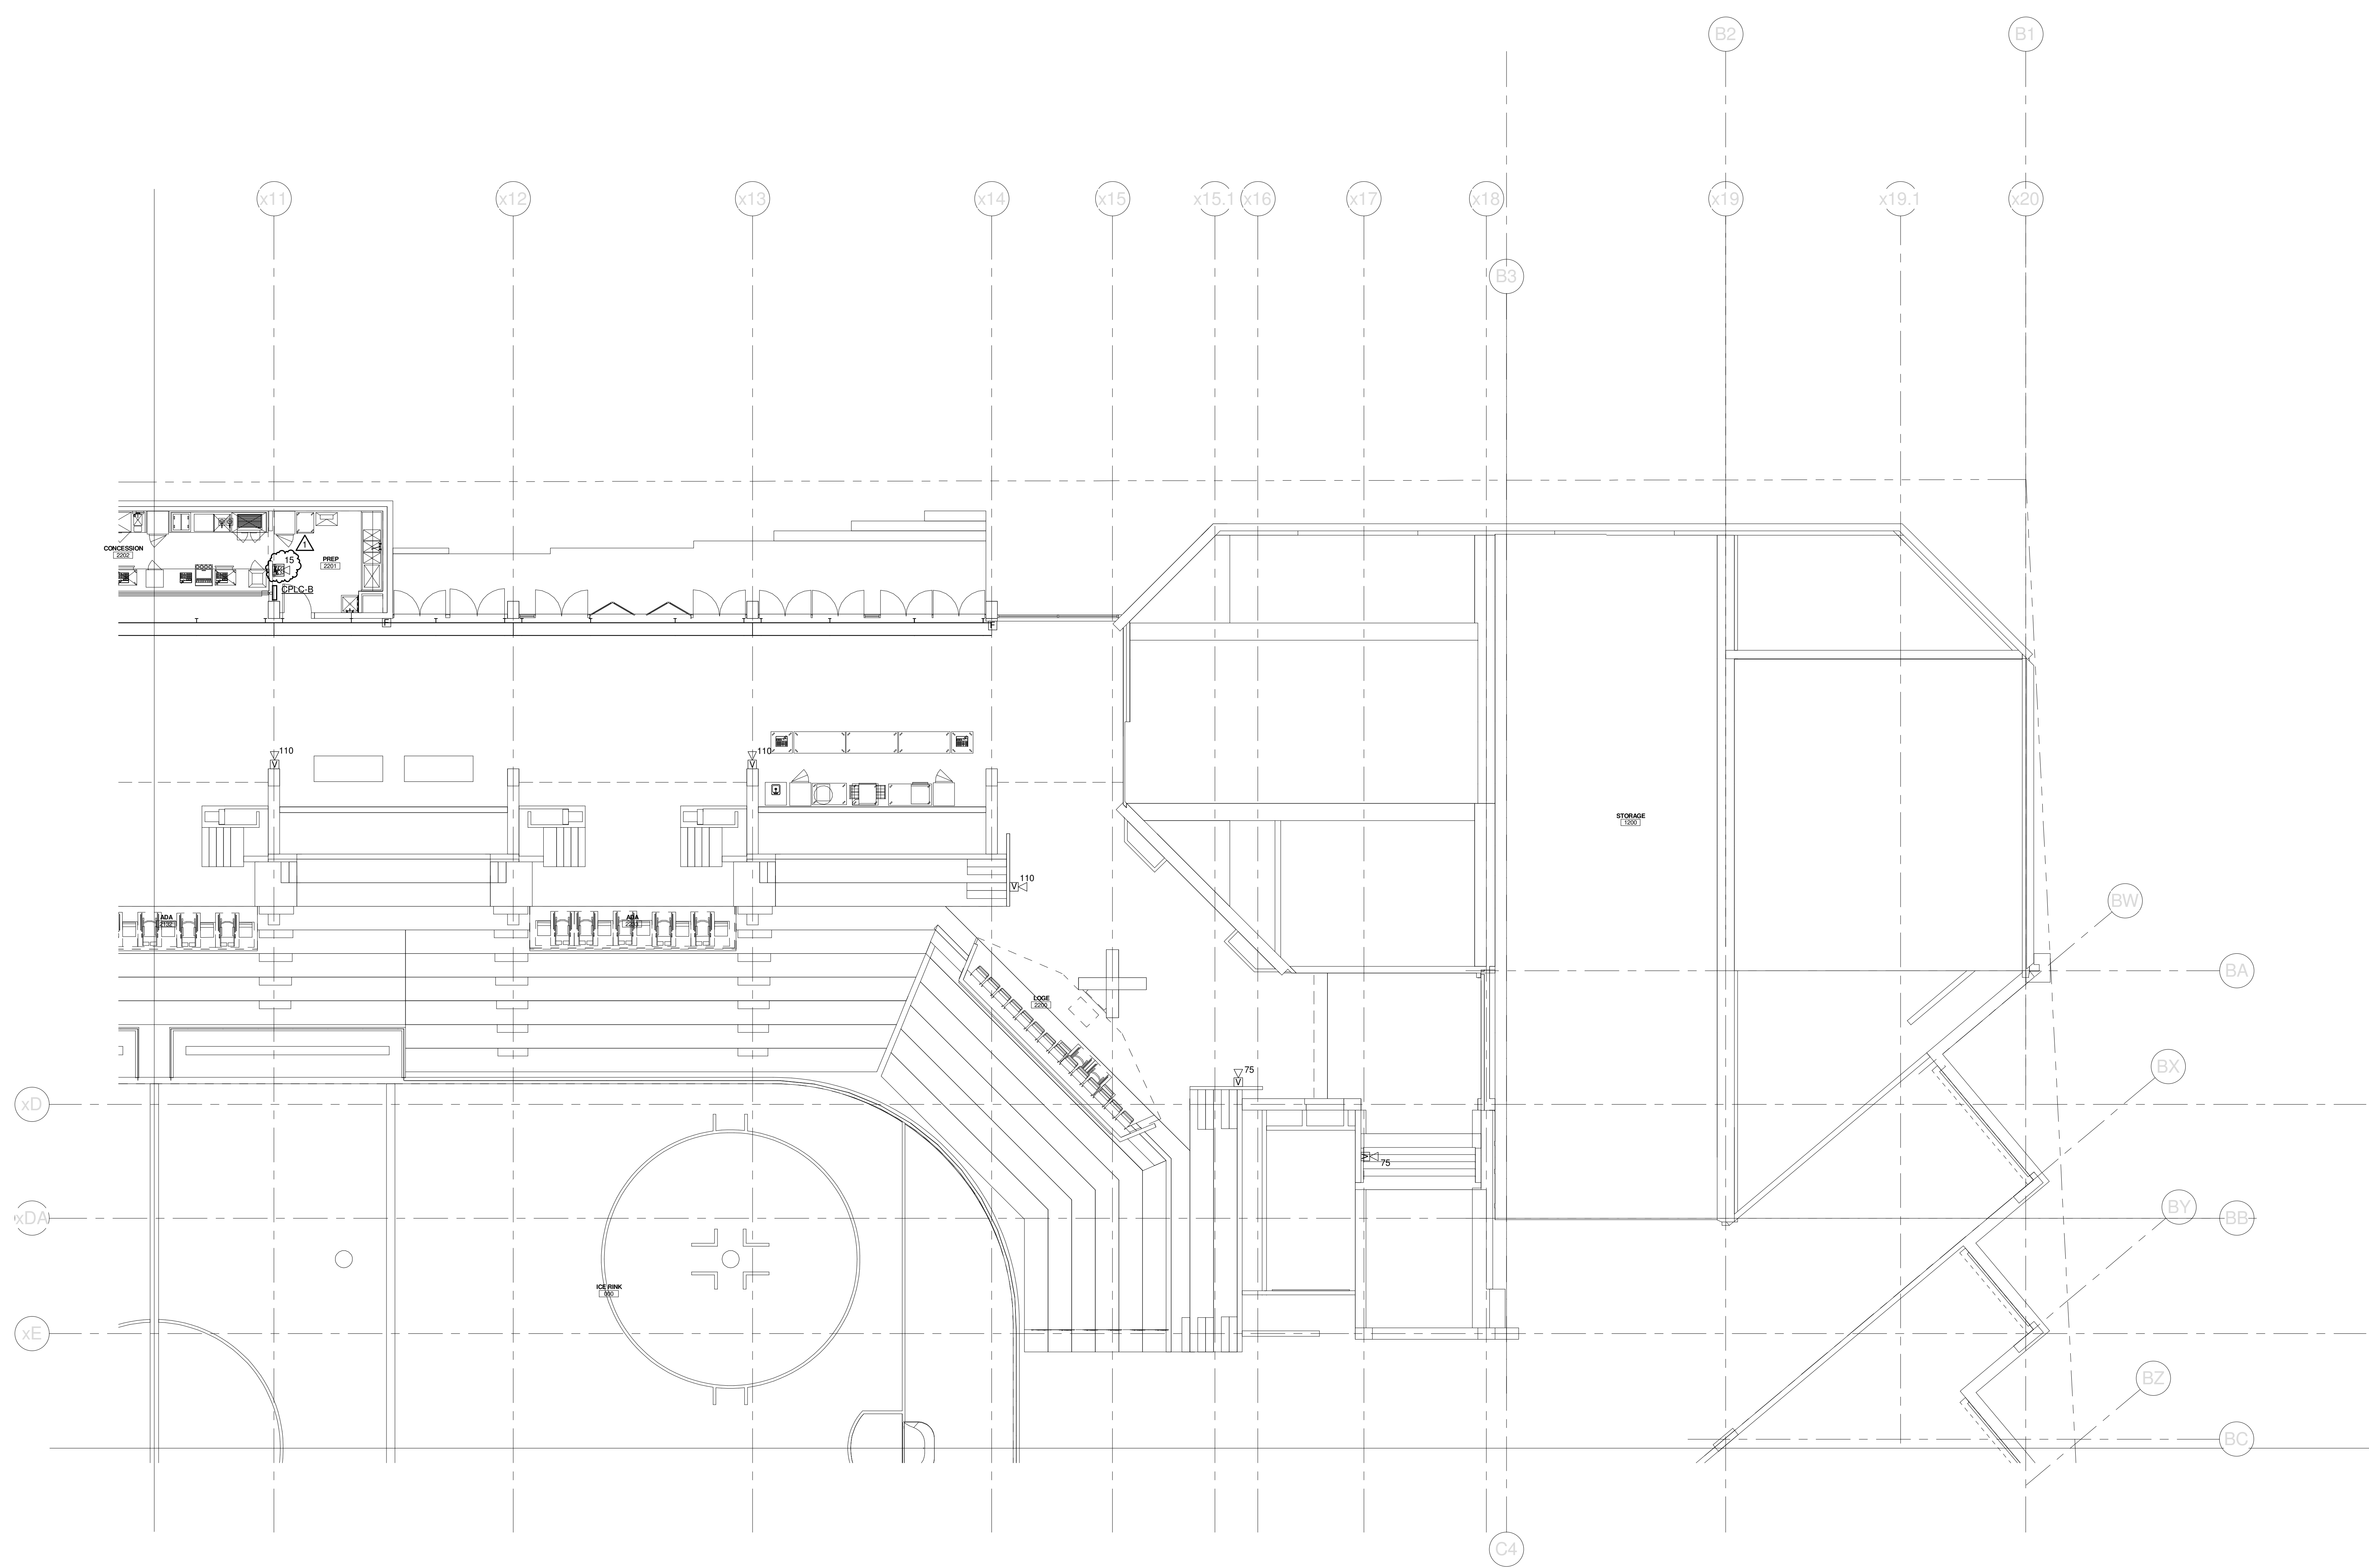

1	SI #073	04-12-2013
0		
REV.	DESCRIPTION	DATE
	SI #073	
	04-12-2013	

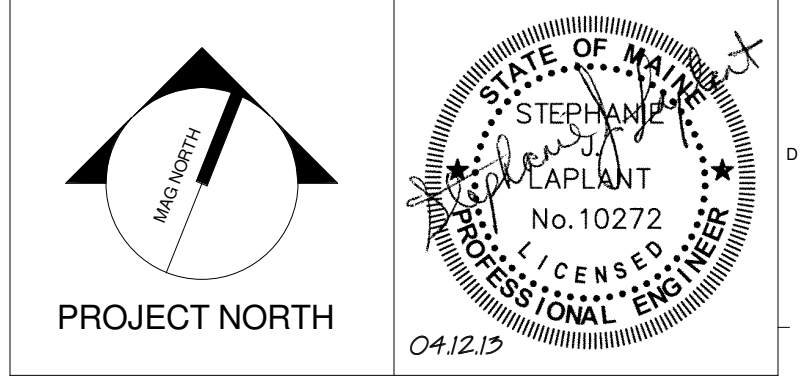

WBRC
ARCHITECTS • ENGINEERS
WWW.WBRCAL.COM
BANGOR, MAINE 307-947-4511
PORTLAND, MAINE 307-838-4511
SARASOTA, FLORIDA 941-556-0727

CUMBERLAND COUNTY CIVIC CENTER RENOVATION
PROJECT: PORTLAND, ME
CONCOURSE LEVEL FIRE ALARM PLAN - QUAD B

SHEET TITLE	
WBRC CAD FILE: C:\Users\jlaplant\Documents\375700 - CCCC Electrical_1\jlaplant.rvt	
PROJECT No. 375700	GRAPHIC SCALE: 1" = 1'-0"
SCALE: 1/8" = 1'-0"	
PROJECT MANAGER: JRB	SHEET No. FA.22B
DRAWN BY: KRM	
CHECKED BY: SLL	



4/12/2013 3:21:57 PM C:\Users\jlaplant\Documents\375700 - CCCC Electrical_1\jlaplant.rvt

SINK COMBS DETHLEFS


Copyright by
WBRC
Dethlefs, P.C.
475 Lincoln Street,
Suite 100
Denver, Colorado 80203
303.398.0200
FAX: 303.398.0222

TECHNICAL NOTES:

- ④ DUCT MOUNTED SMOKE DETECTOR PROVIDED BY DIV. 28. INSTALLED BY DIV. 23, & CONNECTED TO THE FIRE ALARM SYSTEM BY DIV. 25. OBTAIN 120V POWER FROM NEARBY RECEPTACLE CIRCUIT.

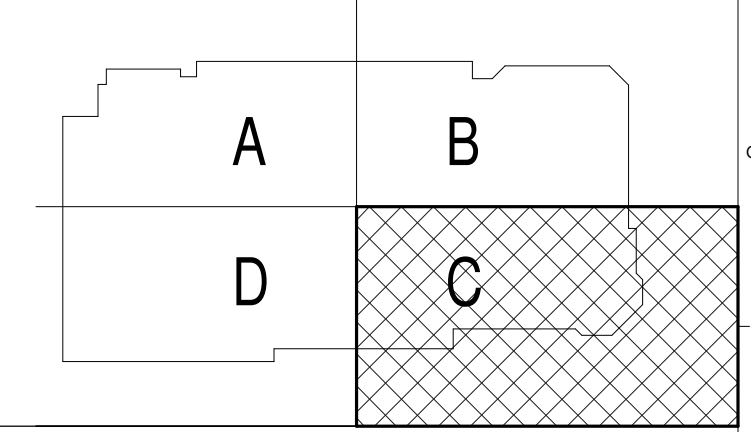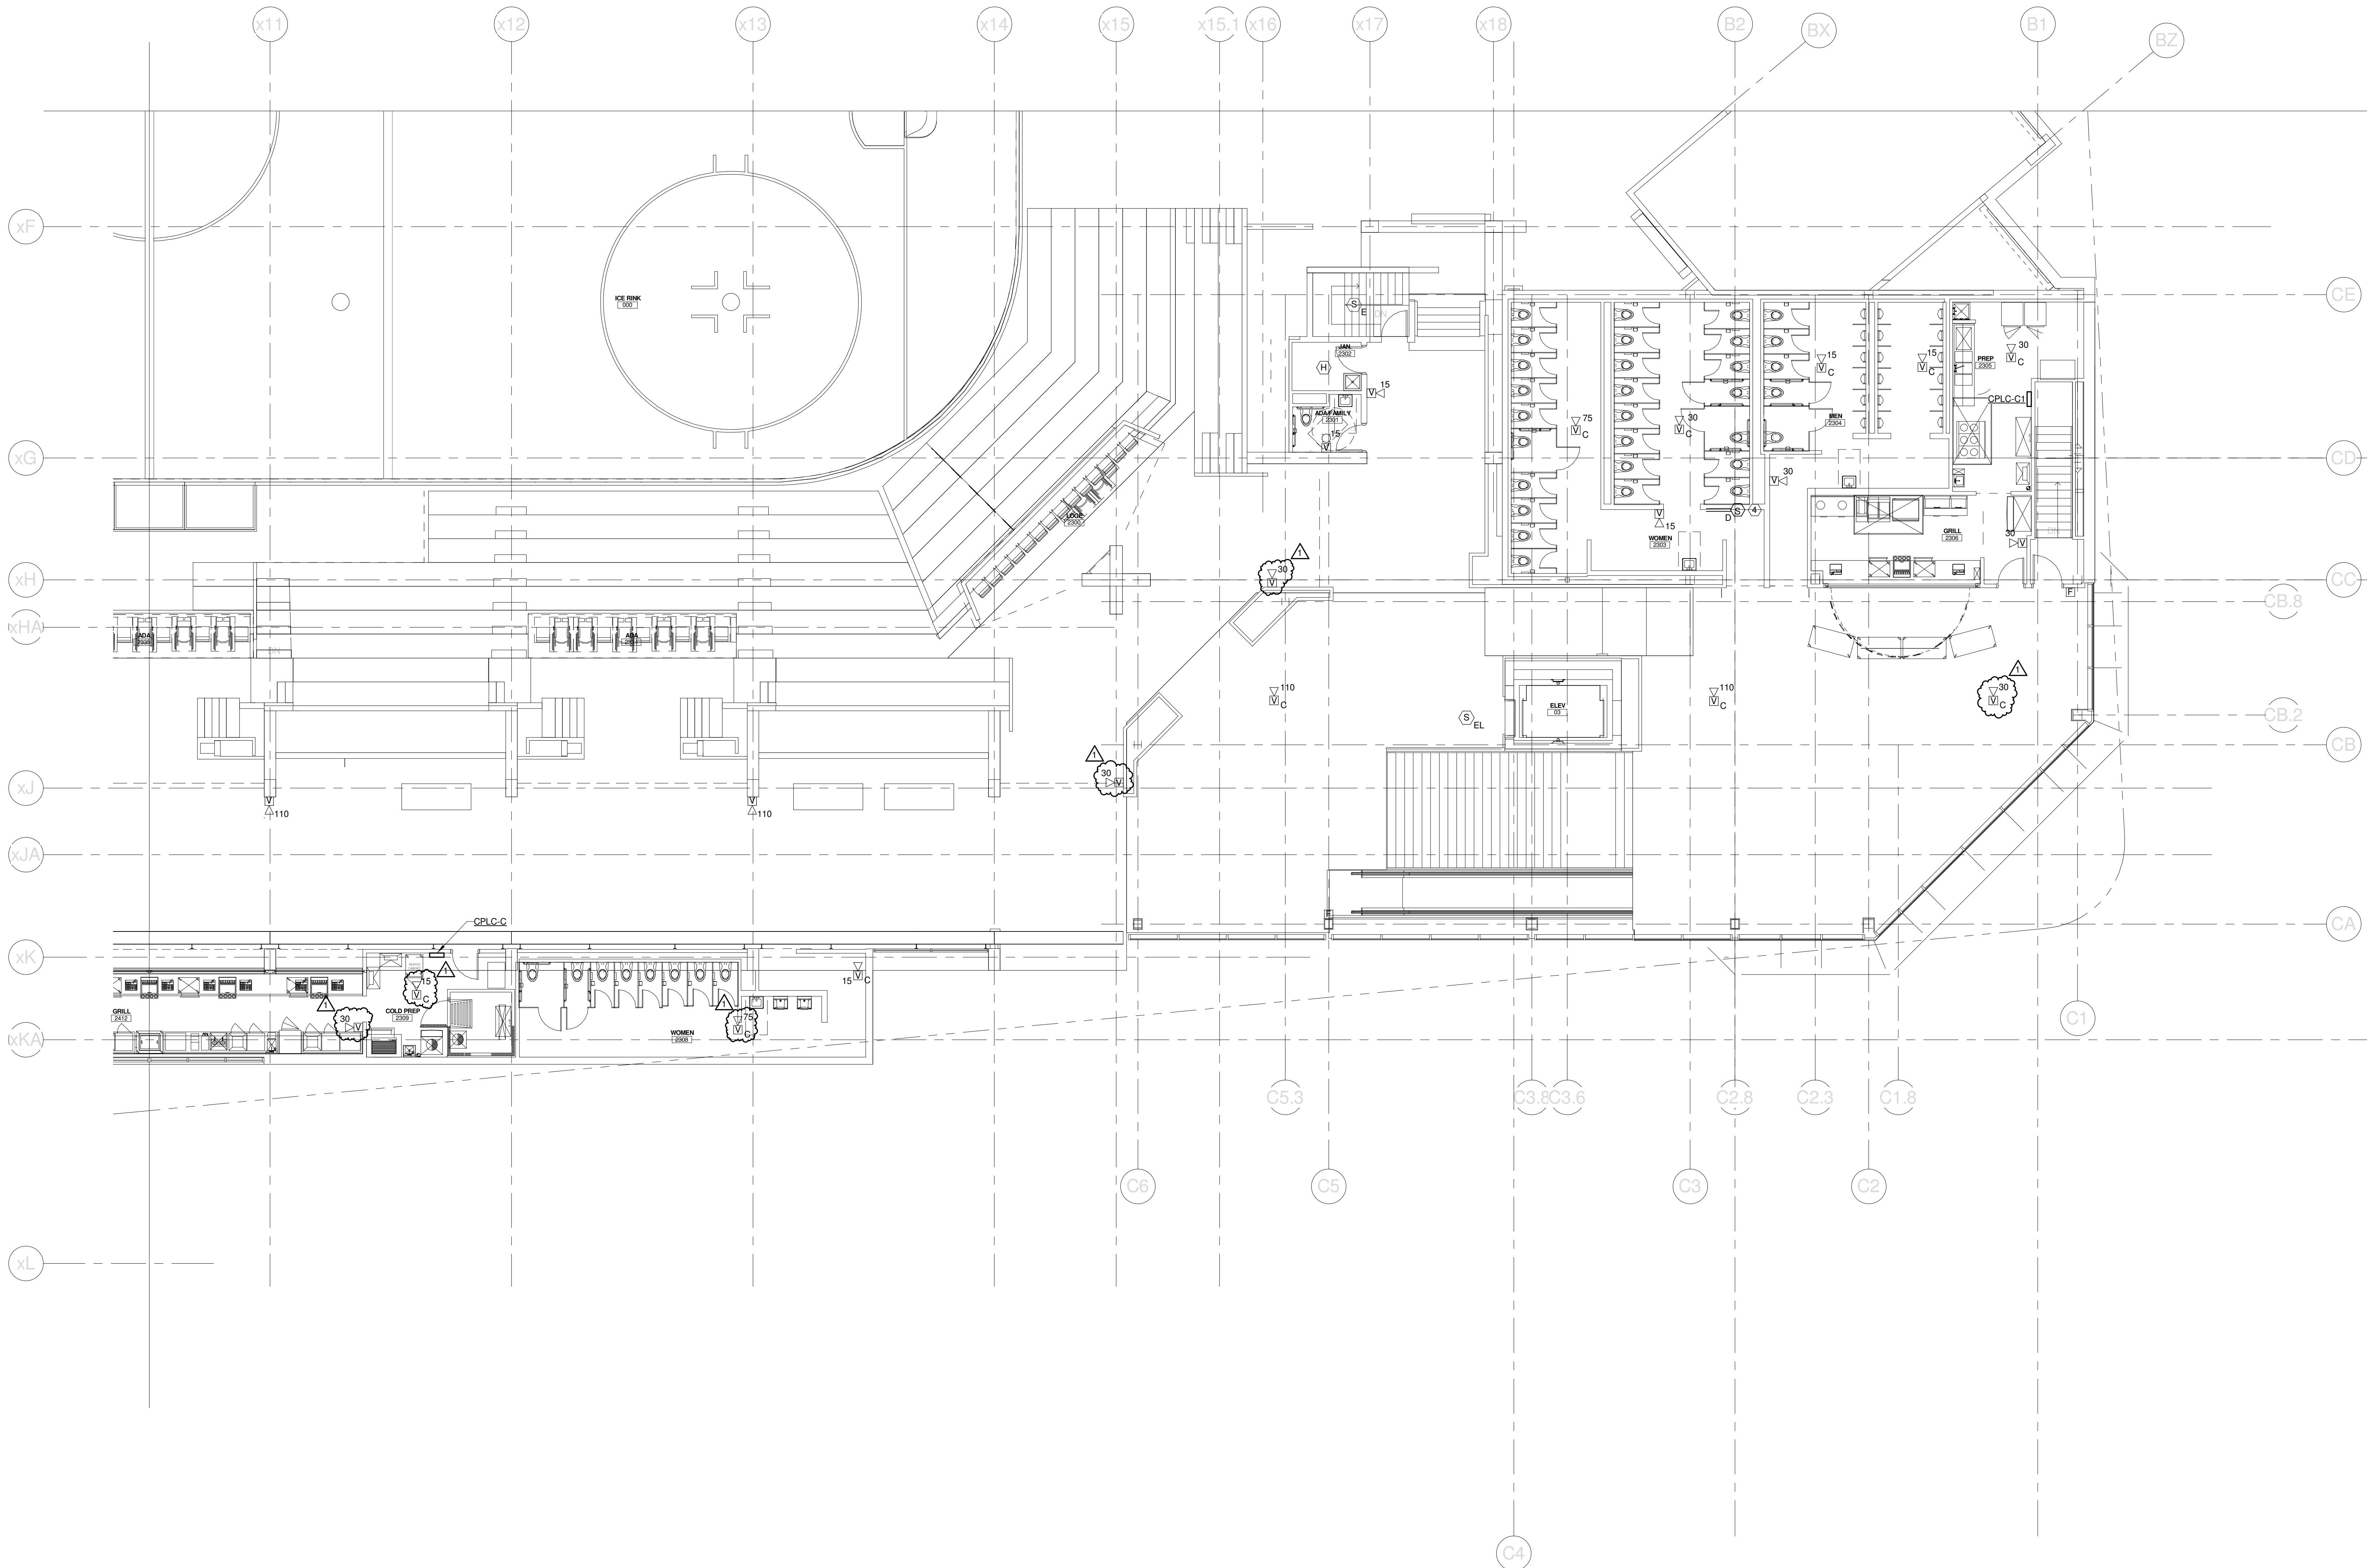

1	SI #073	04-12-2013
0		
REV.	DESCRIPTION	DATE
	SI #073	
	04-12-2013	

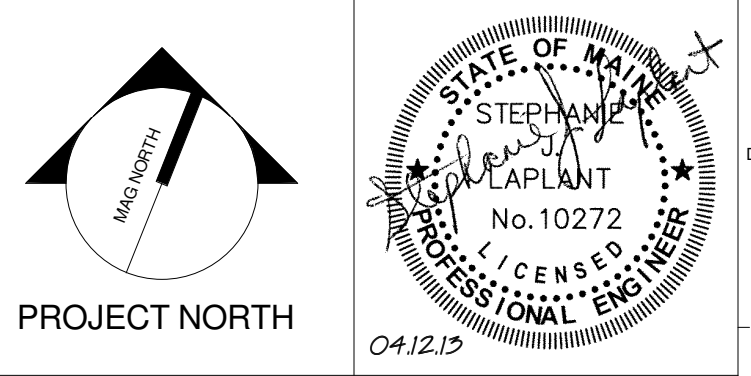

WBRC
ARCHITECTS • ENGINEERS
WWW.WBRCAL.COM
BANGOR, MAINE 207.947.4511
PORTLAND, MAINE 207.838.4511
SARASOTA, FLORIDA 941.556.0727

CUMBERLAND COUNTY CIVIC CENTER RENOVATION
PROJECT: PORTLAND, ME
CONCOURSE LEVEL FIRE ALARM PLAN - QUAD C



SHEET TITLE	CONCOURSE LEVEL FIRE ALARM PLAN - QUAD C
WBRC CAD FILE	C:\Users\jaye.mahar\Documents\375700 - CCCC Electrical_jaye.mahar.rvt
PROJECT No.	375700
SCALE	1/8" = 1'-0"
PROJECT MANAGER	JRB
DRAWN BY	KRM
CHECKED BY	SJL
SHEET No.	FA.23B

SINK COMBS DETHLEFS


Copyright by
Sink Combs
Dethlefs, P.C.
475 Lincoln Street,
Suite 100
Denver, Colorado 80203
303.398.0200
FAX 303.398.0222

TECHNICAL NOTES:

- ④ CONNECT TO FIRE ALARM SYSTEM FOR AUTOMATIC OPEN ON ACTIVATION OF SMOKE CONTROL SYSTEM (ZONE 3)
- ⑤ DUCT MOUNTED SMOKE DETECTOR PROVIDED BY DIV. 28. INSTALLED BY DIV. 23, & CONNECTED TO THE FIRE ALARM SYSTEM BY DIV. 28. OBTAIN 120V POWER FROM NEARBY RECEPTACLE CIRCUIT.

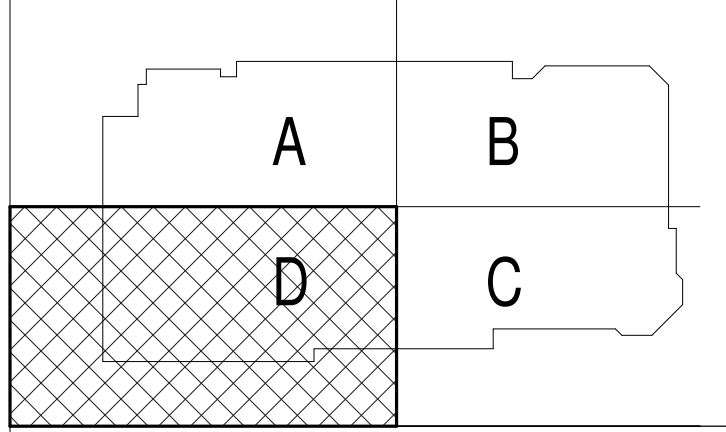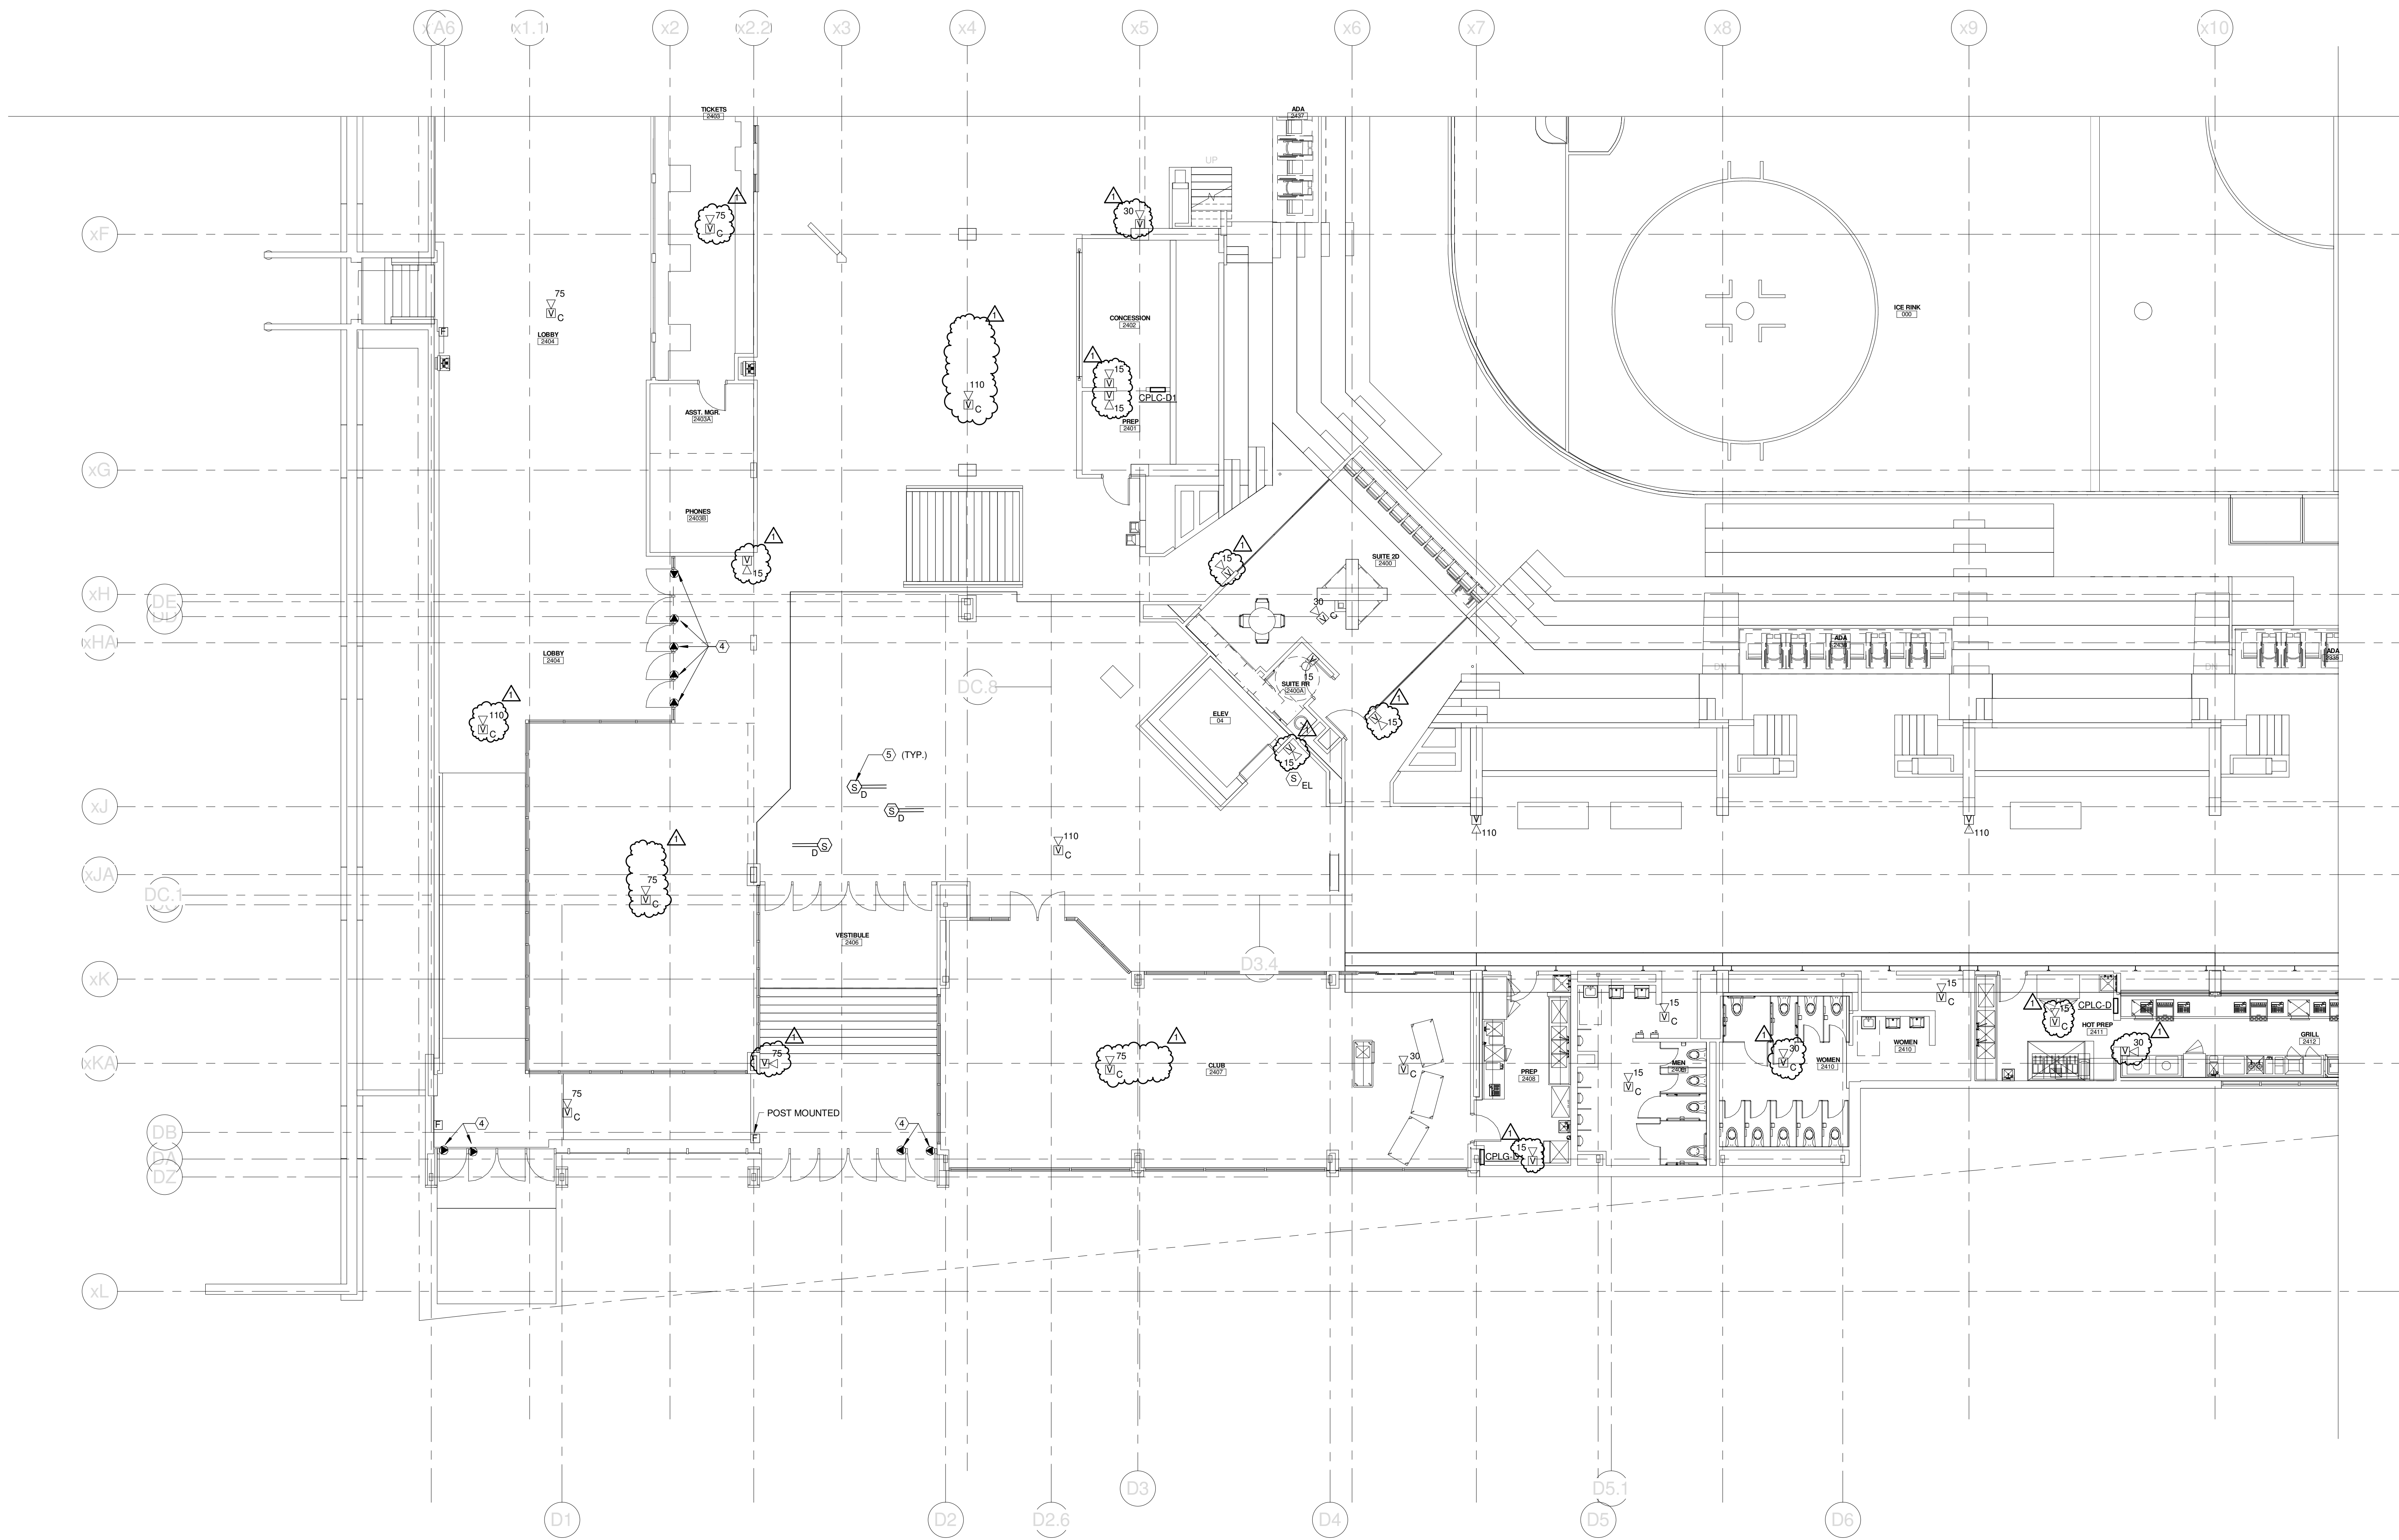

1	SI #073	04-12-2013
0		
REV.	DESCRIPTION	DATE
	SI #073	
	04-12-2013	

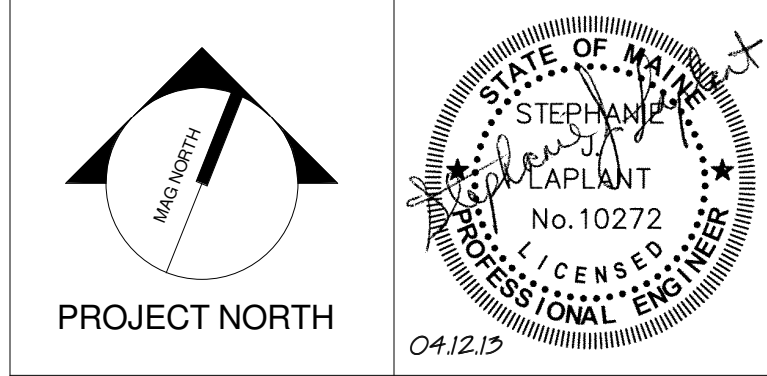



WBRC
ARCHITECTS • ENGINEERS
WWW.WBRCAE.COM
BANGOR, MAINE 207-947-4511
PORTLAND, MAINE 207-838-4511
SARASOTA, FLORIDA 941-556-0727

CUMBERLAND COUNTY CIVIC CENTER RENOVATION
PROJECT: PORTLAND, ME
CONCOURSE LEVEL FIRE ALARM PLAN - QUAD D


PROJECT No.	375700	GRAPHIC SCALE	1" = 1'-0"
SCALE	1/8" = 1'-0"		
PROJECT MANAGER	JRB	SHEET No.	FA.24B
DRAWN BY	KRM		
CHECKED BY	SJL		

SINK COMBS DETHLEFS

Copyright by
Sink Combs
Dethlefs, P.C.
475 Lincoln Street,
Suite 100
Denver, Colorado 80203
303.398.0200
FAX 303.398.0222

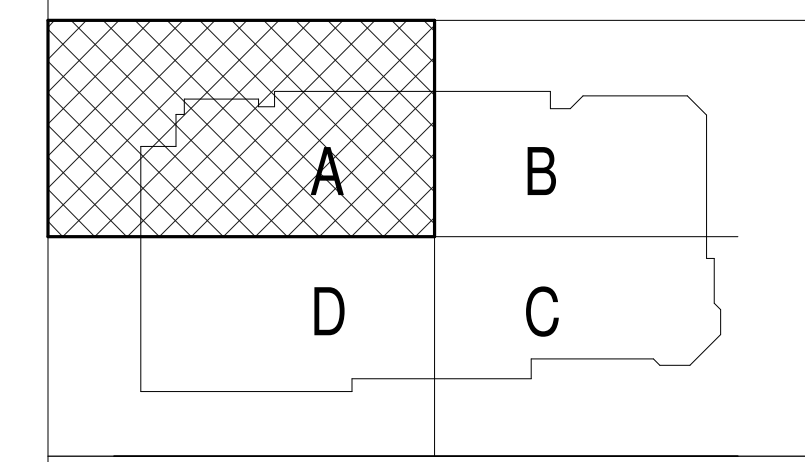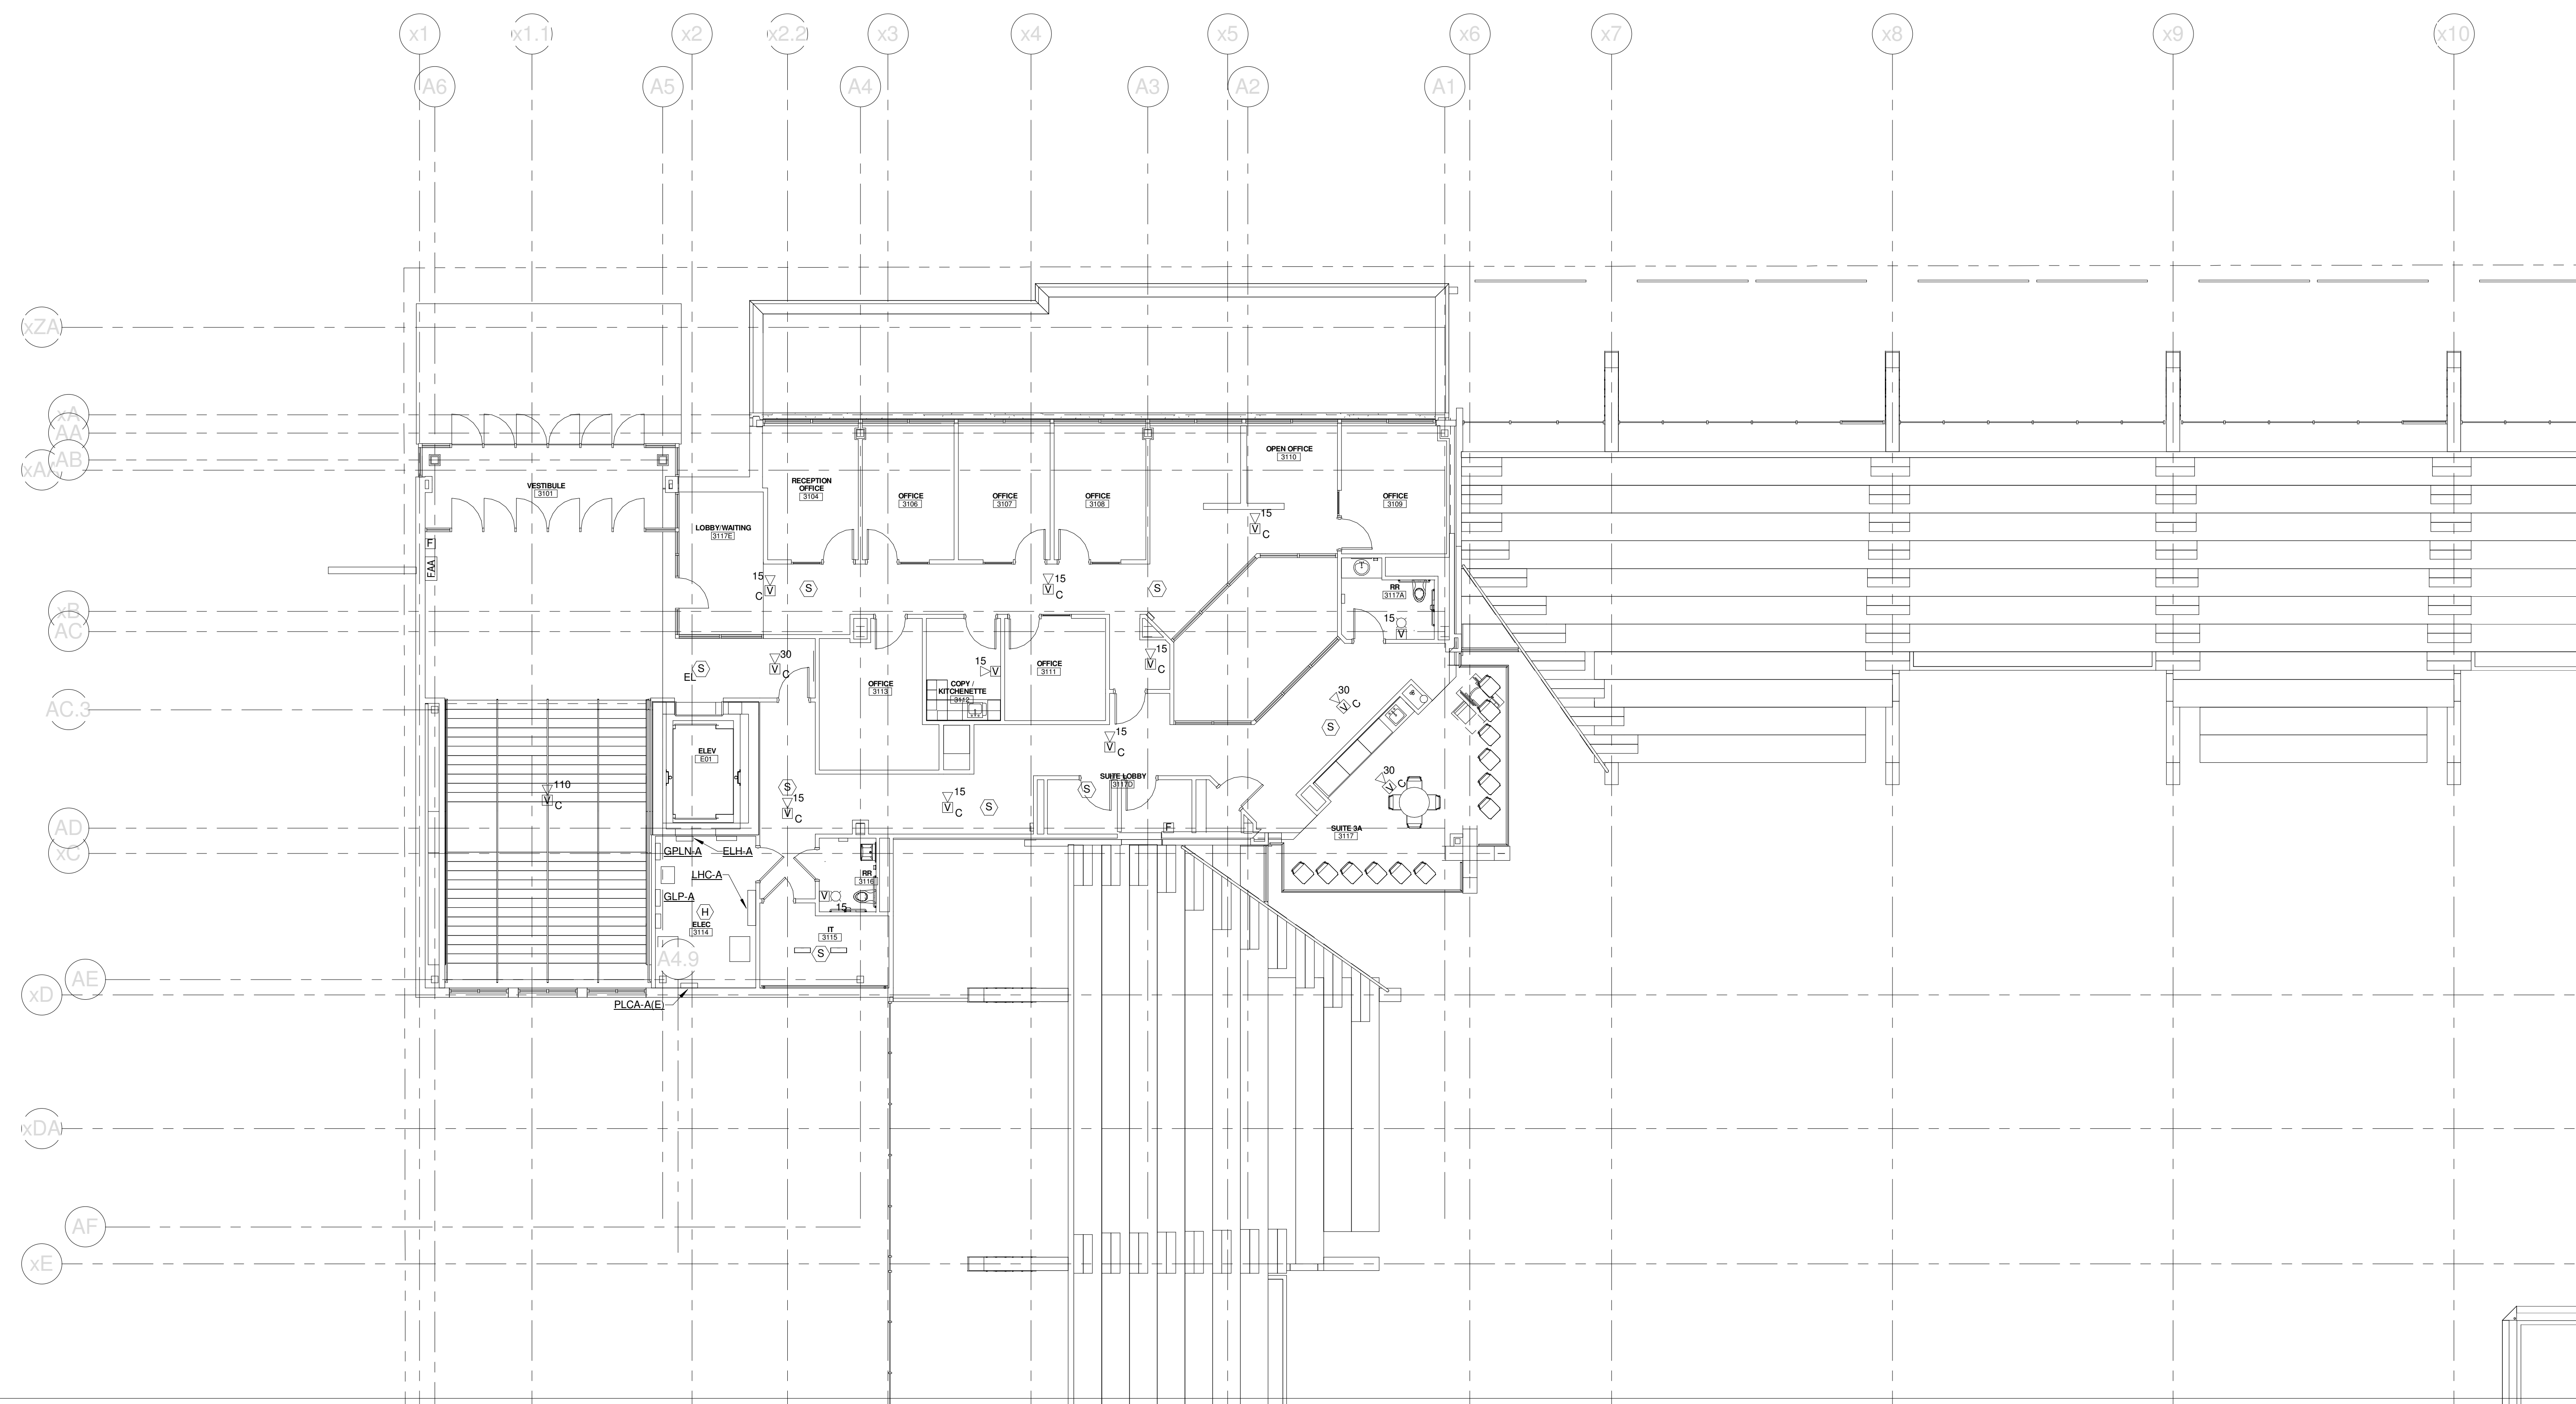

REV.	DESCRIPTION	DATE
0	SI #073	
	04-12-2013	

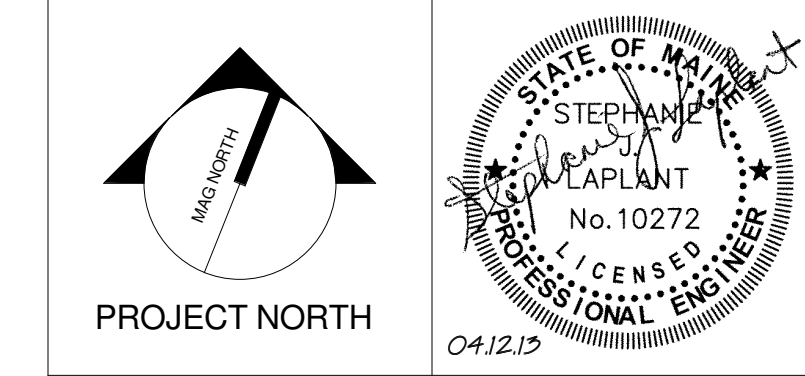



CUMBERLAND COUNTY CIVIC CENTER RENOVATION
 PORTLAND, ME
MID SUITES LEVEL FIRE ALARM PLAN - QUAD A

PROJECT No.	375700	GRAPHIC SCALE	1" = 10'
SCALE	1/8" = 1'-0"		
PROJECT MANAGER	JRB	SHEET No.	FA.31B
DRAWN BY	KRM		
CHECKED BY	SJL		


4/12/2013 2:08:51 PM C:\Users\jaye.mahar\Documents\375700 - CCCC Electrical\jaye.mahar.rvt

SINK COMBS DETHLEFS

Copyright by
WBRC
475 Lincoln Street,
Suite 100
Denver, Colorado 80203
303.398.0200
FAX 303.398.0225

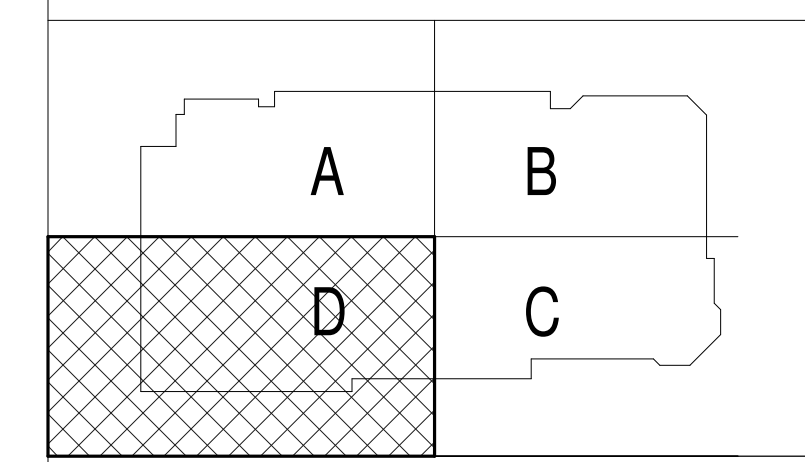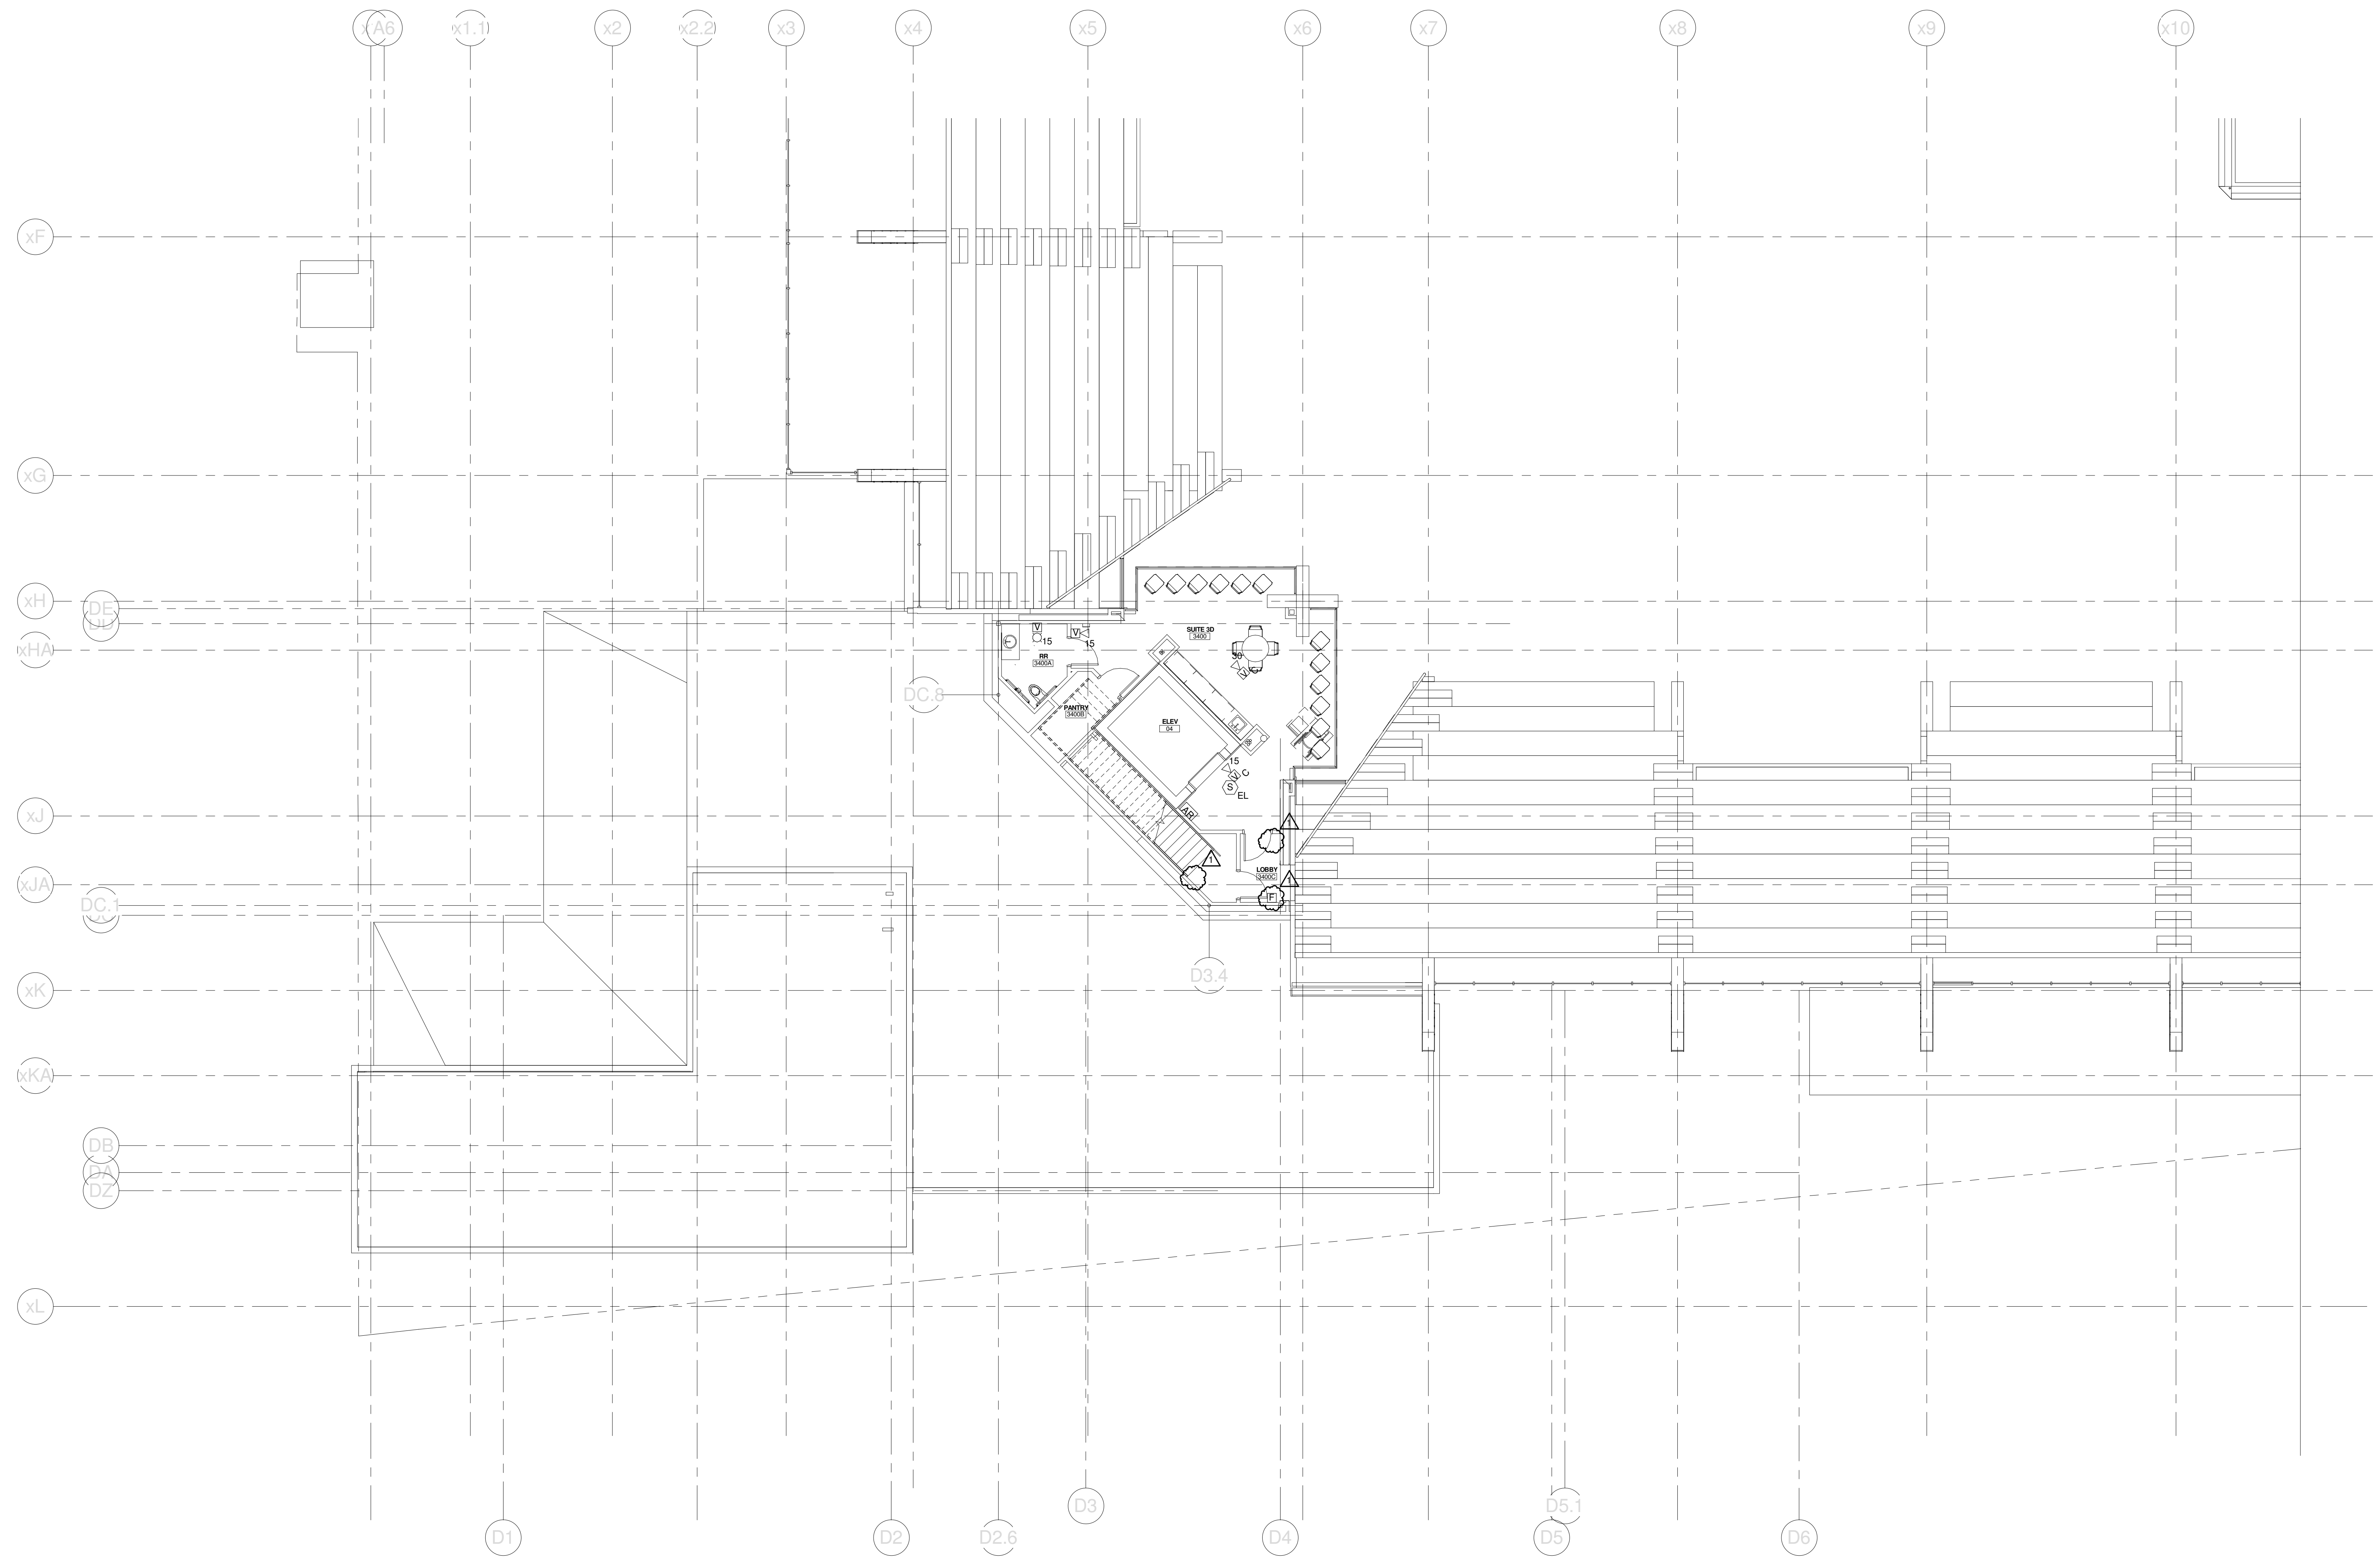

1	SI #073	04-12-2013
0		
REV.	DESCRIPTION	DATE
	SI #073	
	04-12-2013	

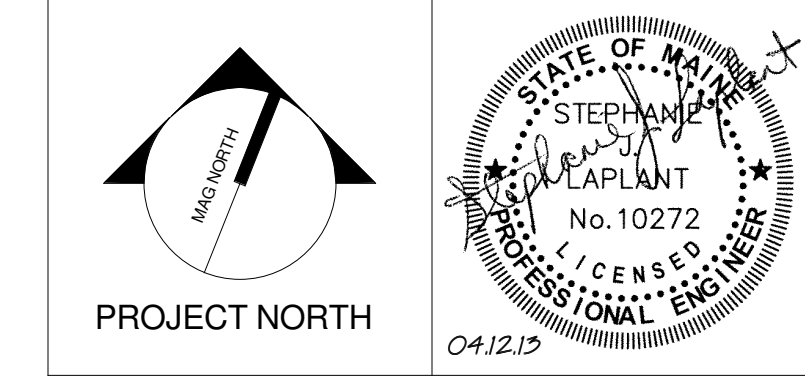

WBRC
ARCHITECTS • ENGINEERS
WWW.WBRCAL.COM
BANGOR, MAINE 207-947-4511
PORTLAND, MAINE 207-838-4511
SUBAROTA, FLORIDA 941-556-0727



CUMBERLAND COUNTY CIVIC CENTER RENOVATION
PROJECT: PORTLAND, ME
MID SUITES LEVEL FIRE ALARM PLAN - QUAD D

WBRC CAD FILE: C:\Users\jlmahar\Documents\375700 - CCCC Electrical\jlmahar.rvt	
PROJECT No. 375700	GRAPHIC SCALE 1" = 1'-0"
SCALE 1/8" = 1'-0"	
PROJECT MANAGER: JRB	SHEET No. FA.34B
DRAWN BY: KRM	
CHECKED BY: S.L.	


4/12/2013 3:12:24 PM C:\Users\jlmahar\Documents\375700 - CCCC Electrical\jlmahar.rvt

SINK COMBS DETHLEFS

Copyright by
Sink Combs
Dethlefs, P.C.
475 Lincoln Street,
Suite 100
Denver, Colorado 80202
303.398.0200
FAX 303.398.0202

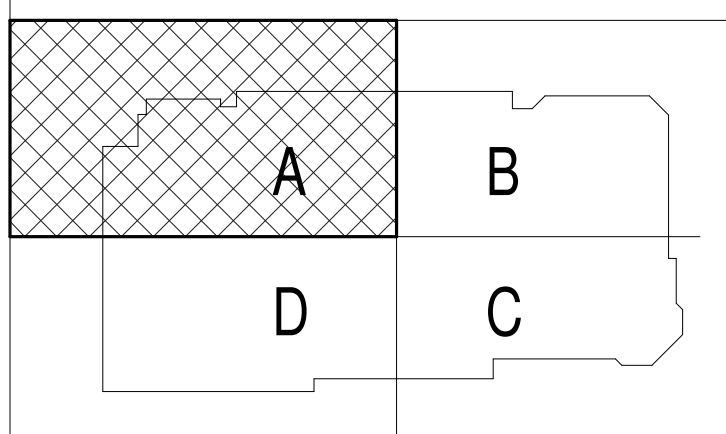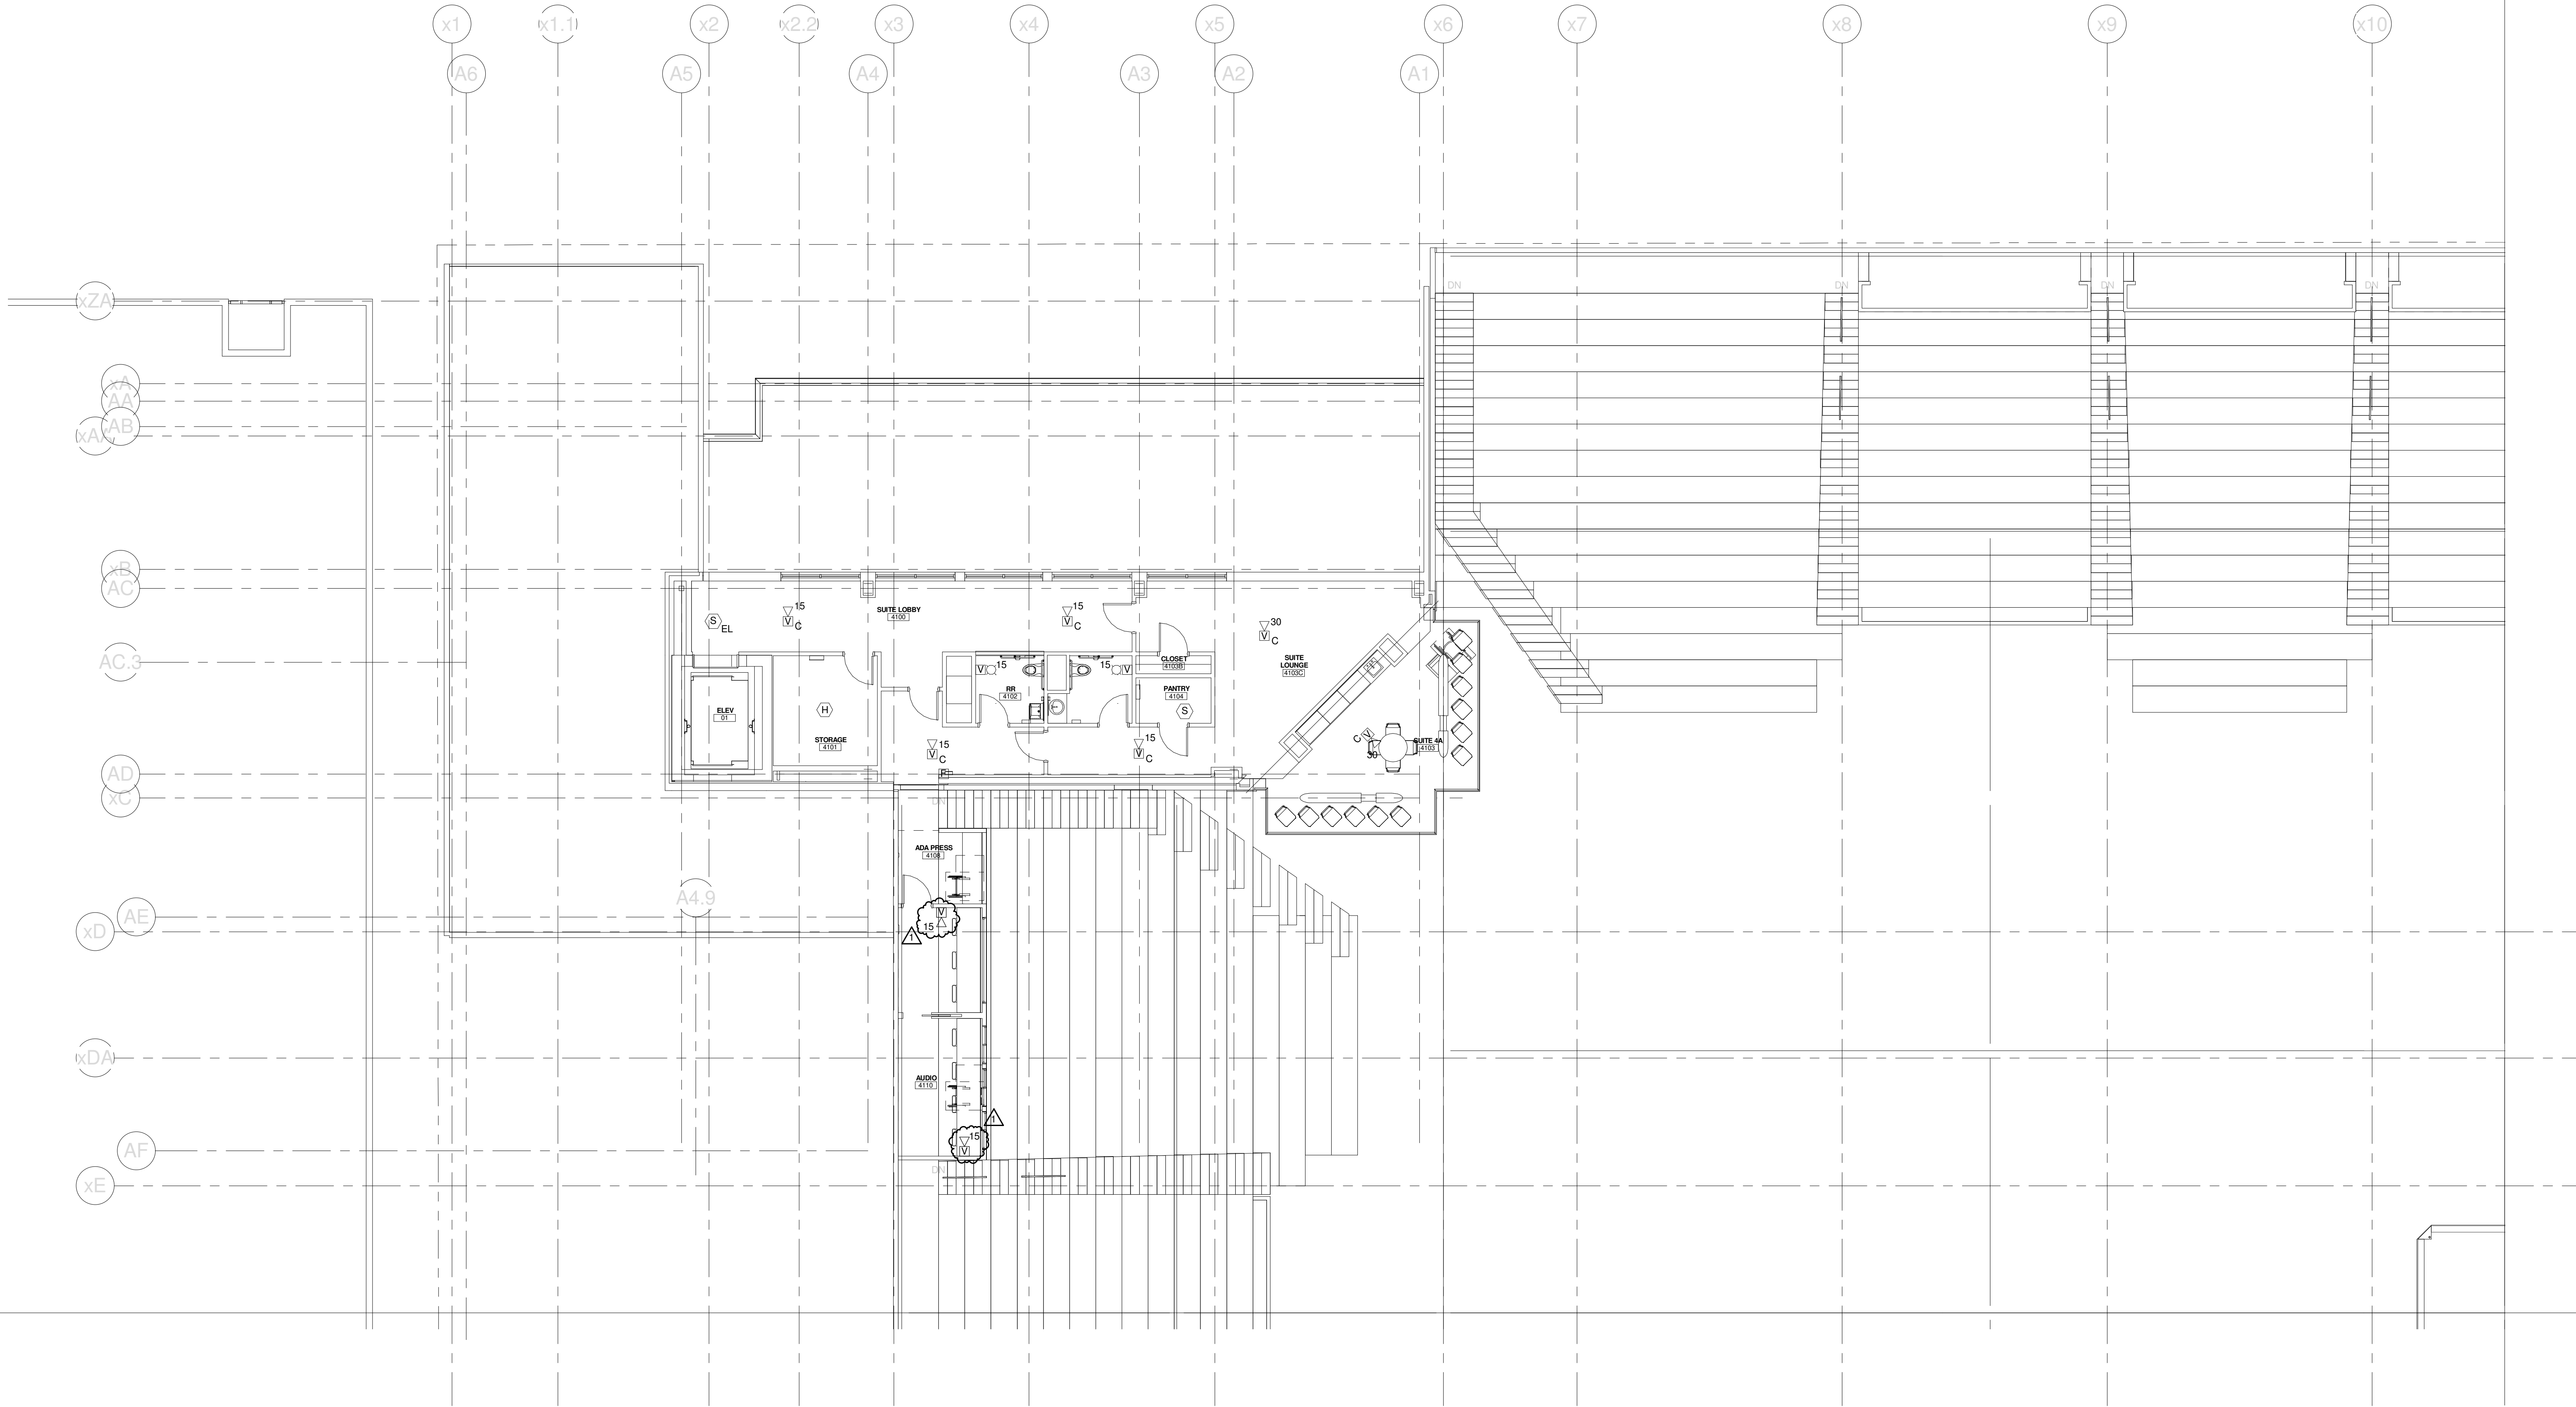

1	SI #073	04-12-2013
0		
REV.	DESCRIPTION	DATE
	SI #073	
	04-12-2013	

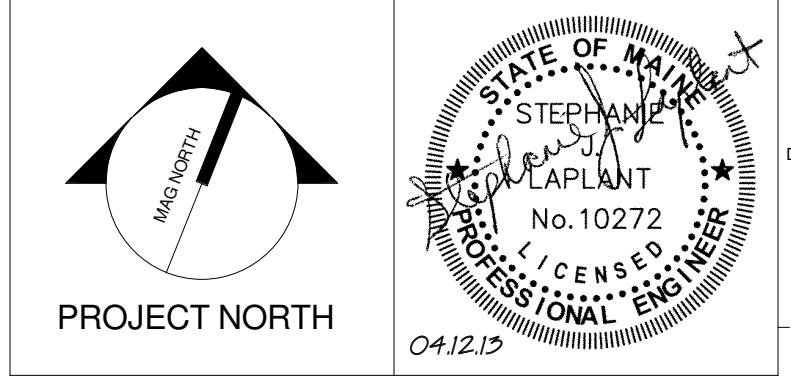



WBRC
ARCHITECTS • ENGINEERS
WWW.WBRCAL.COM
BANGOR, MAINE 207.947-4511
PORTLAND, MAINE 207.838-4511
SARASOTA, FLORIDA 941.556-0727

CUMBERLAND COUNTY CIVIC
CENTER RENOVATION
PORTLAND, ME
UPPER SUITES LEVEL FIRE
ALARM PLAN - QUAD A


WBRC CAD FILE: C:\Users\jaye.mahar\Documents\375700 - CCCC Electrical_1.jaye.mahar.rvt	
PROJECT No. 375700	GRAPHIC SCALE 1" = 10'
SCALE 1/8" = 1'-0"	
PROJECT MANAGER: JRB	SHEET No.
DRAWN BY: KRM	FA.41B
CHECKED BY: S.JL	

SINK COMBS DETHLEFS

Copyright by
SINK COMBS
Dethlefs, P.C.
475 Lincoln Street,
Suite 100
Denver, Colorado 80203
303.398.0200
FAX 303.398.0222

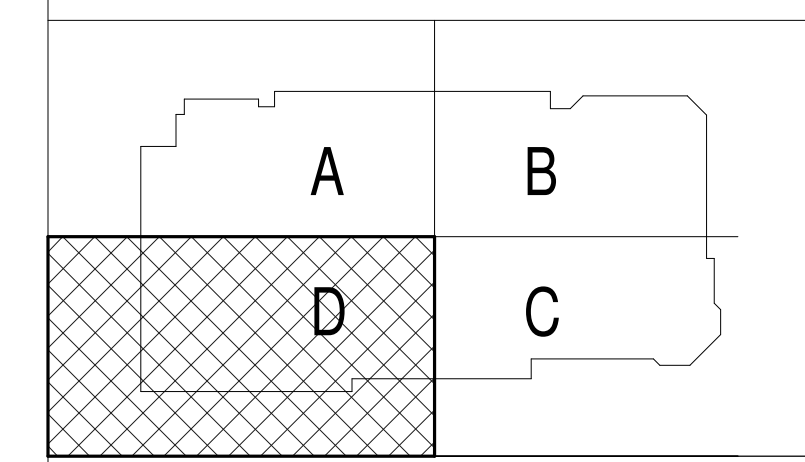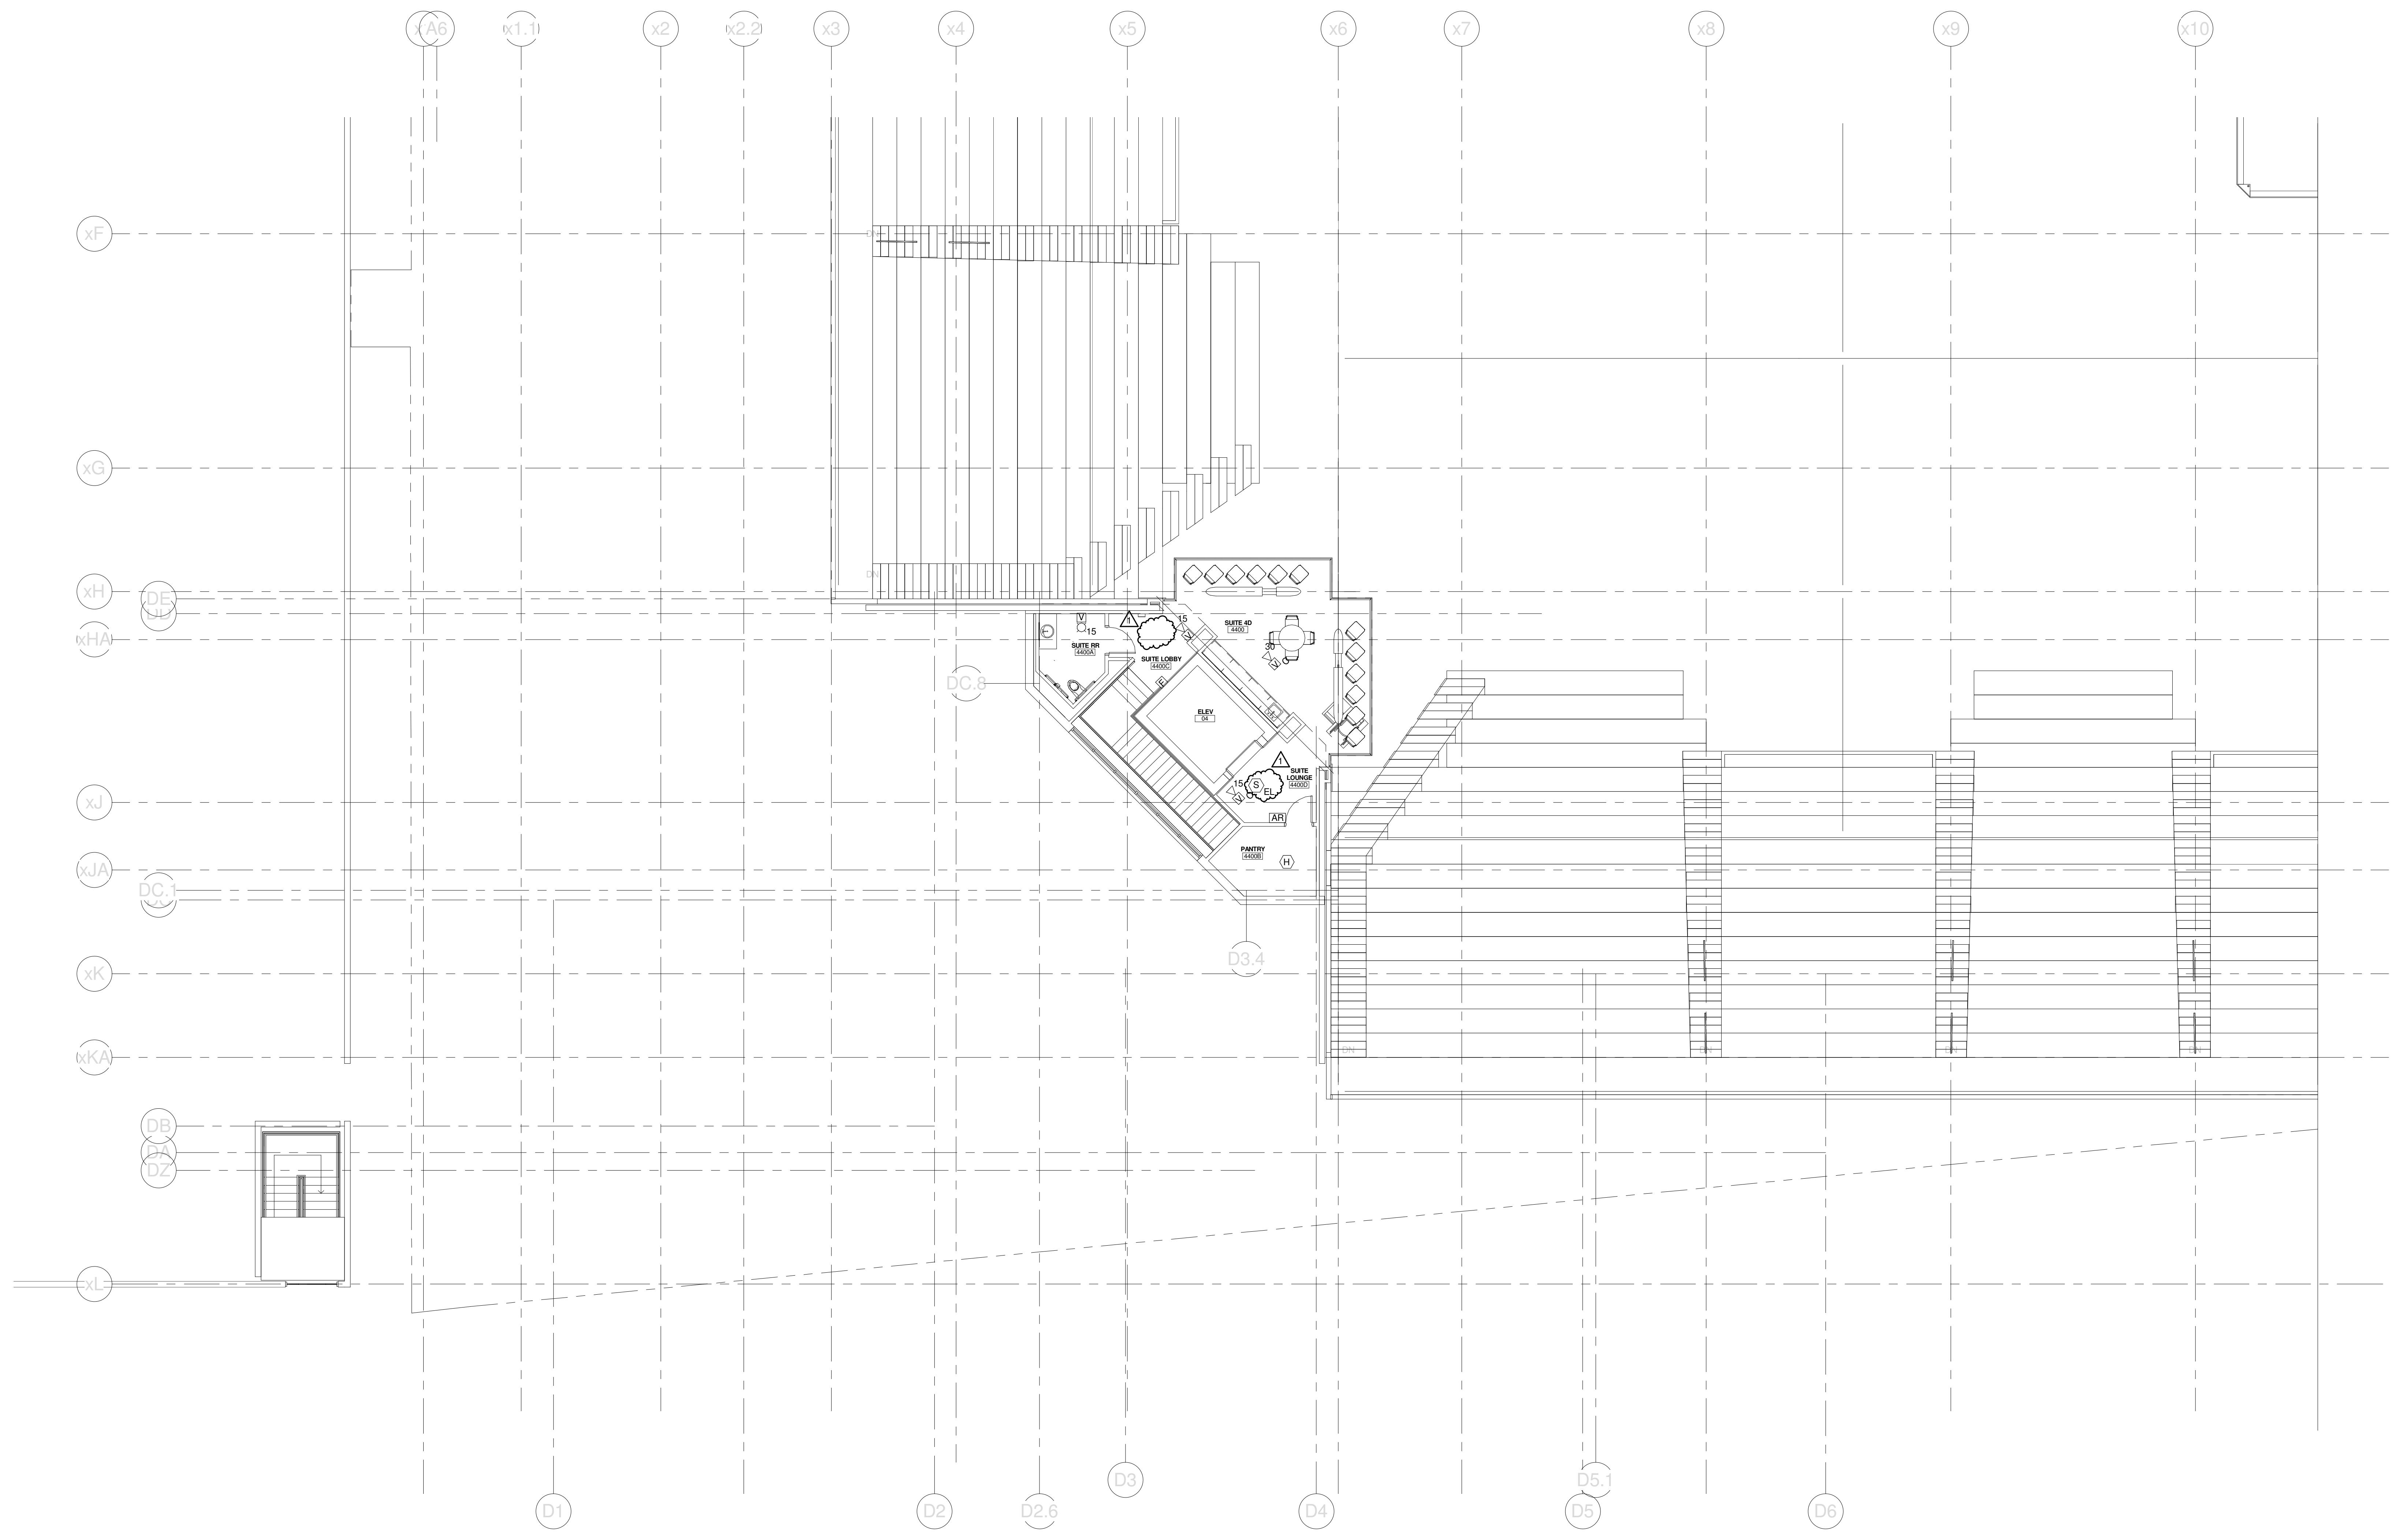

1	SI #073	04-12-2013
0		
REV.	DESCRIPTION	DATE
	SI #073	
	04-12-2013	

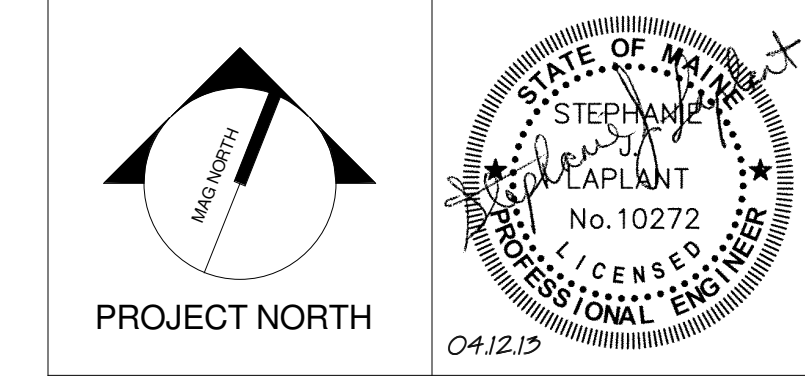

WBRC
ARCHITECTS • ENGINEERS
WWW.WBRCAL.COM
BANGOR, MAINE 207-947-4511
PORTLAND, MAINE 207-838-4511
SARASOTA, FLORIDA 941-556-0727

PROJECT: PORTLAND, ME
UPPER SUITES LEVEL FIRE ALARM PLAN - QUAD D

SHEET TITLE:
WBRC CAD FILE: C:\Users\jaye.mahar\Documents\375700 - CCCC Electrical_1.jaye.mahar.rvt
PROJECT No. 375700 GRAPHIC SCALE: 1" = 1'-0"
SCALE: 1/8" = 1'-0"
PROJECT MANAGER: JRB SHEET No. FA.44B
DRAWN BY: KRM
CHECKED BY: SJL



4/12/2013 3:18:47 PM C:\Users\jaye.mahar\Documents\375700 - CCCC Electrical_1.jaye.mahar.rvt

SINK COMBS DETHLEFS


Copyright by
WBRC
475 Lincoln Street
Suite 100
Denver, Colorado 80202
303.398.0200
FAX 303.398.0202

TECHNICAL NOTES:

- ① DUCT MOUNTED SMOKE DETECTOR PROVIDED BY DIV. 28, INSTALLED BY DIV. 23, & CONNECTED TO THE FIRE ALARM SYSTEM BY DIV. 28. OBTAIN 120V POWER FROM NEARBY RECEPTACLE CIRCUIT.
- ② MOUNT TO UNDERSIDE OF CATWALK.
- ③ BEAM DETECTORS SHALL BE LOCATED 3'-0" BELOW THE UNDERSIDE OF THE FAN ROOM FLOOR SLAB. ALL SHALL BE MOUNTED AT THE SAME ELEVATION ABOVE THE ARENA FLOOR.

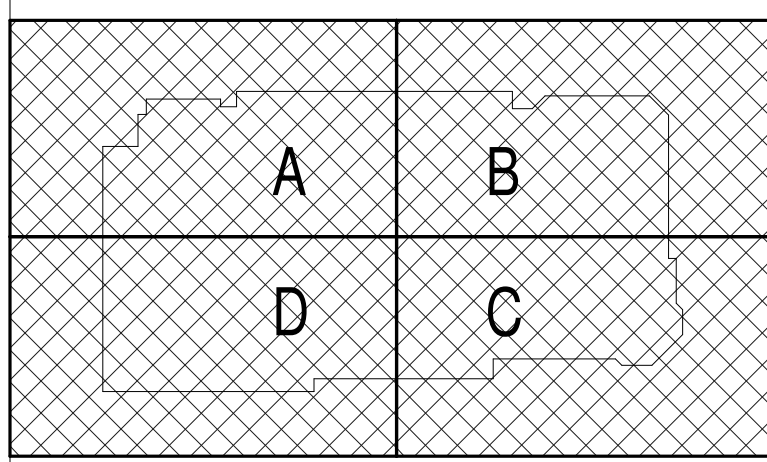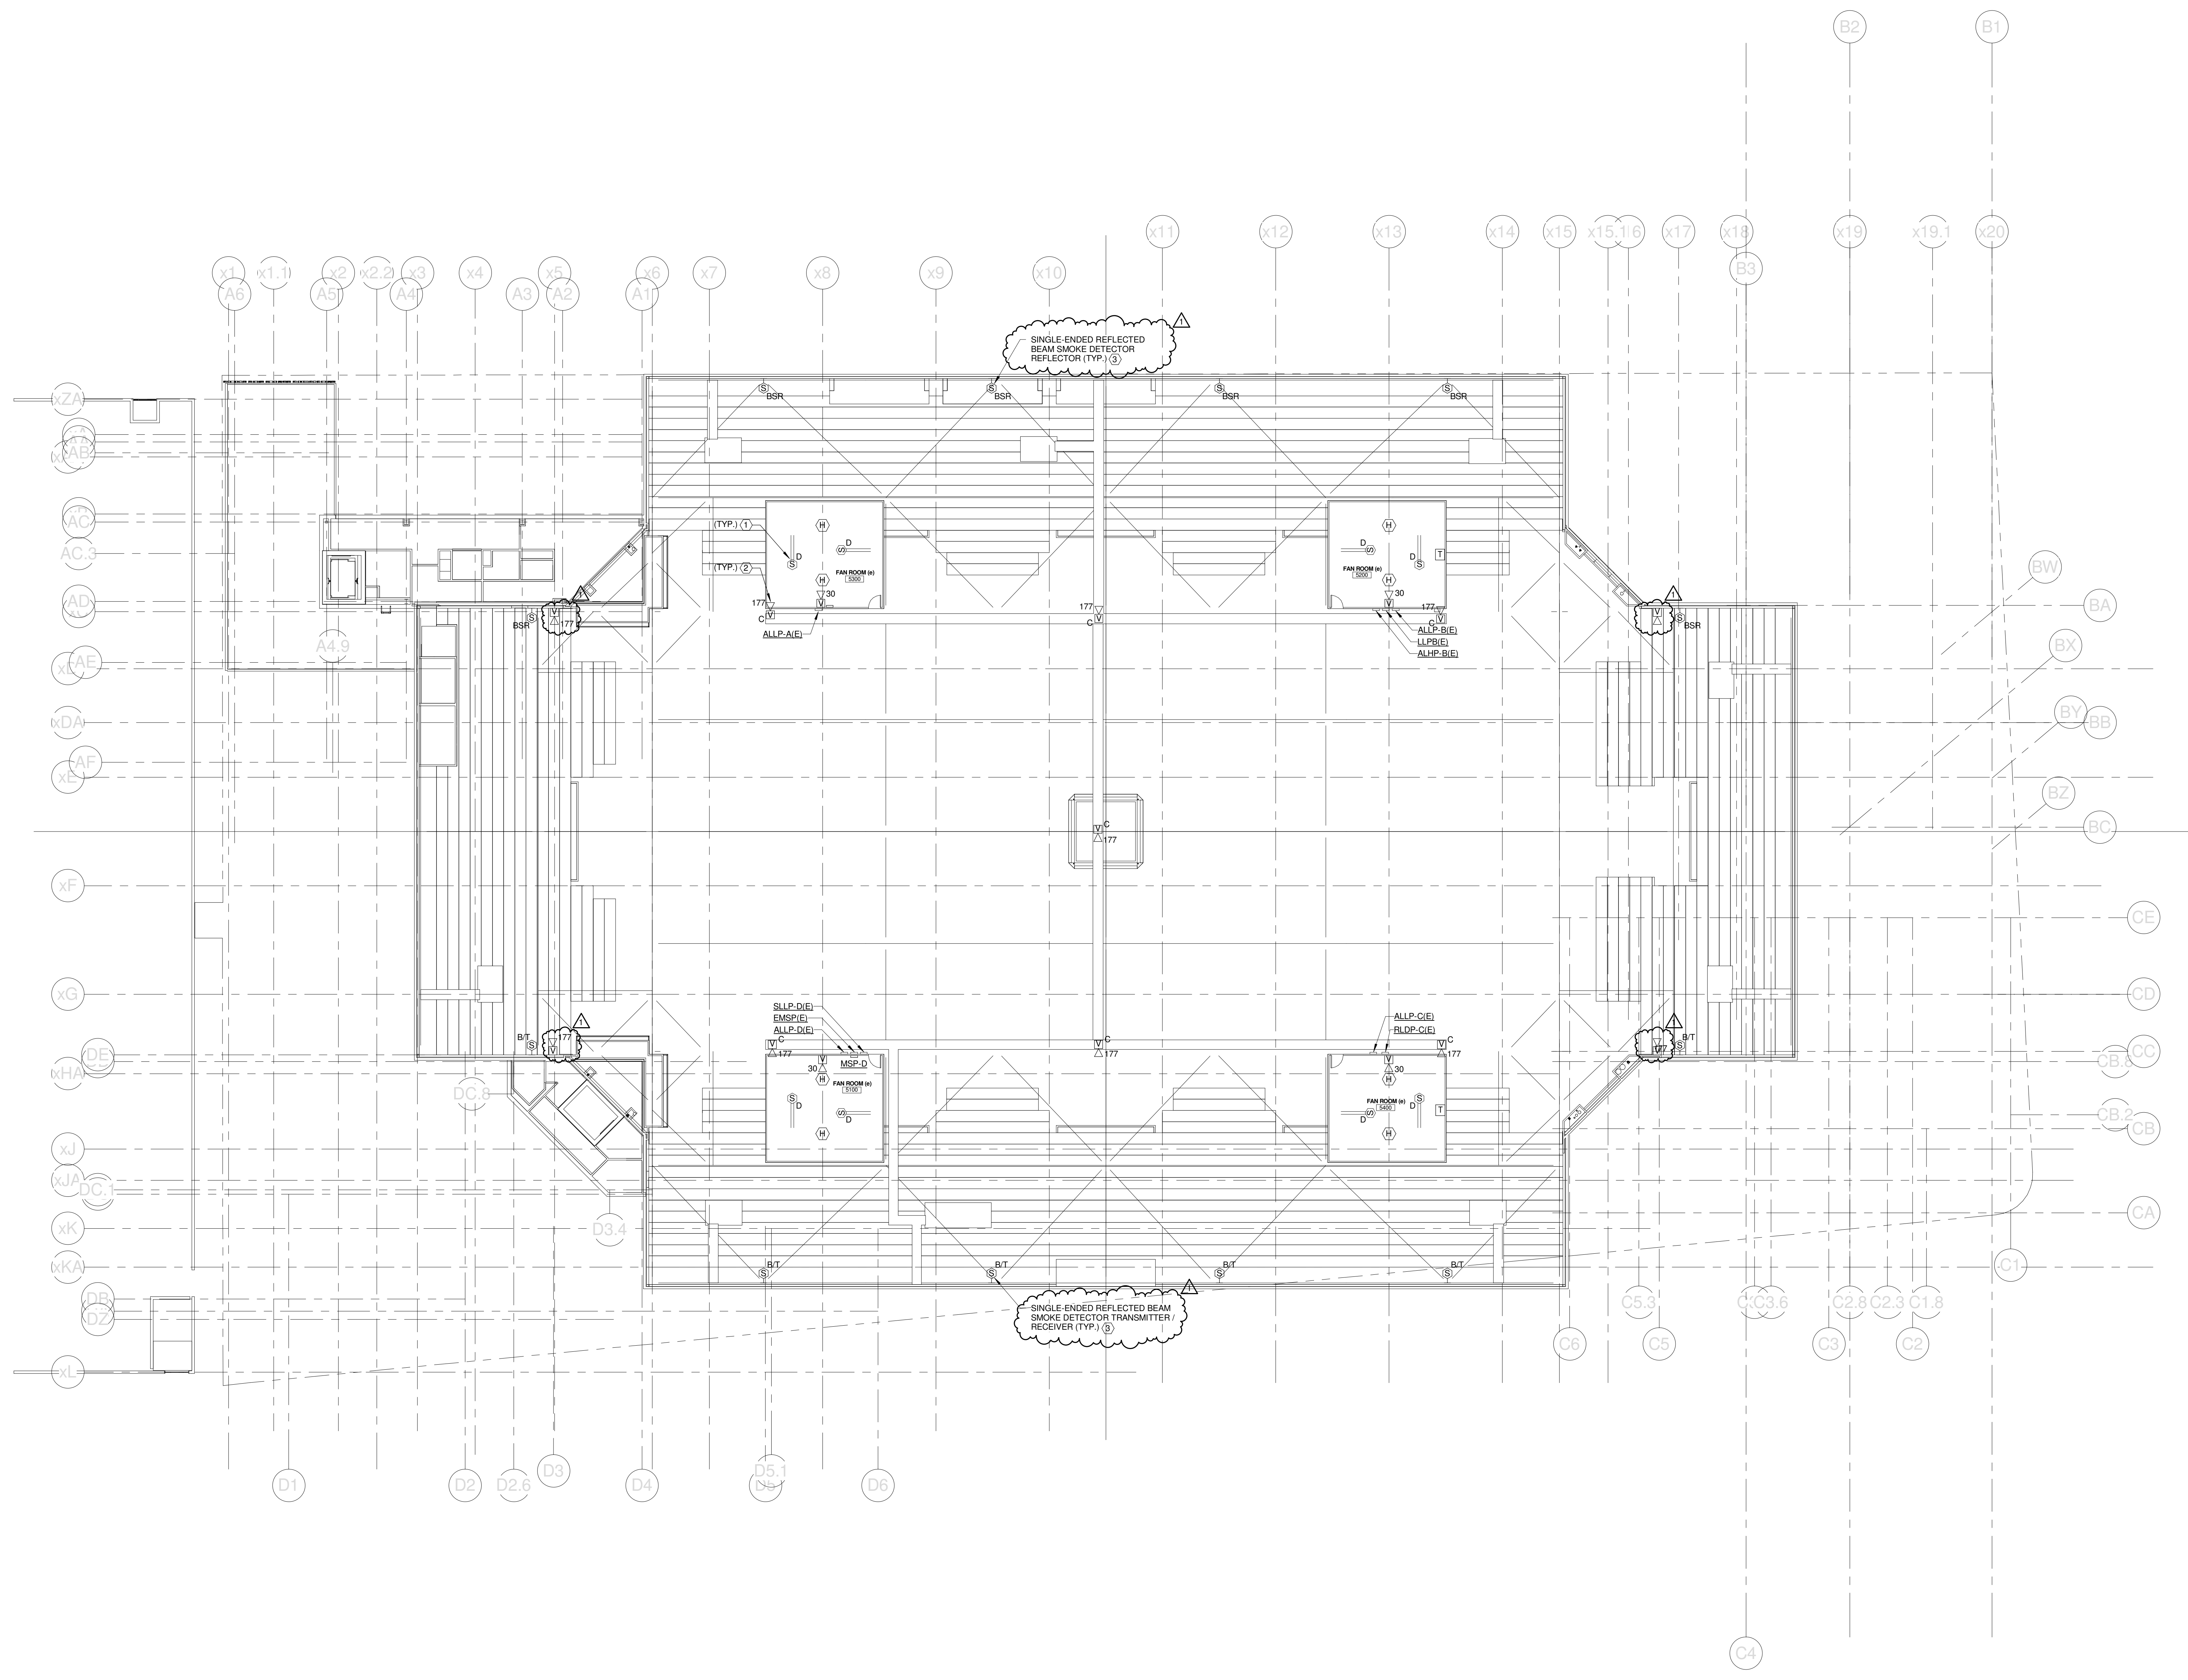

1	SI #073	04-12-2013
0		
REV.	DESCRIPTION	DATE
	SI #073	
	04-12-2013	

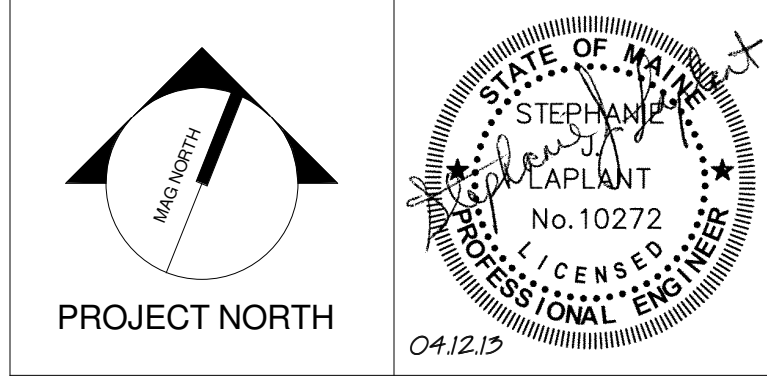

WBRC
ARCHITECTS • ENGINEERS
WWW.WBRCAL.COM
BANGOR, MAINE 207.947.4511
PORTLAND, MAINE 207.838.4511
SARASOTA, FLORIDA 813.556.0727

CUMBERLAND COUNTY CIVIC CENTER RENOVATION
PROJECT: PORTLAND, ME
CATWALK LEVEL FIRE ALARM PLAN

SHEET TITLE:
WBRC CAD FILE: C:\Users\jlmahar\Documents\375700 - CCCC Electrical_1.jm.mahar.rvt
PROJECT No: 375700 GRAPHIC SCALE: 1" = 1'-0"
SCALE: 1/16" = 1'-0"
PROJECT MANAGER: JRB SHEET No:
DRAWN BY: KRM **FA.50B**
CHECKED BY: SJL