




1 BOWL SMOKE CONTROL - EVENT LEVEL AIRFLOWS
1/32" = 1'-0"

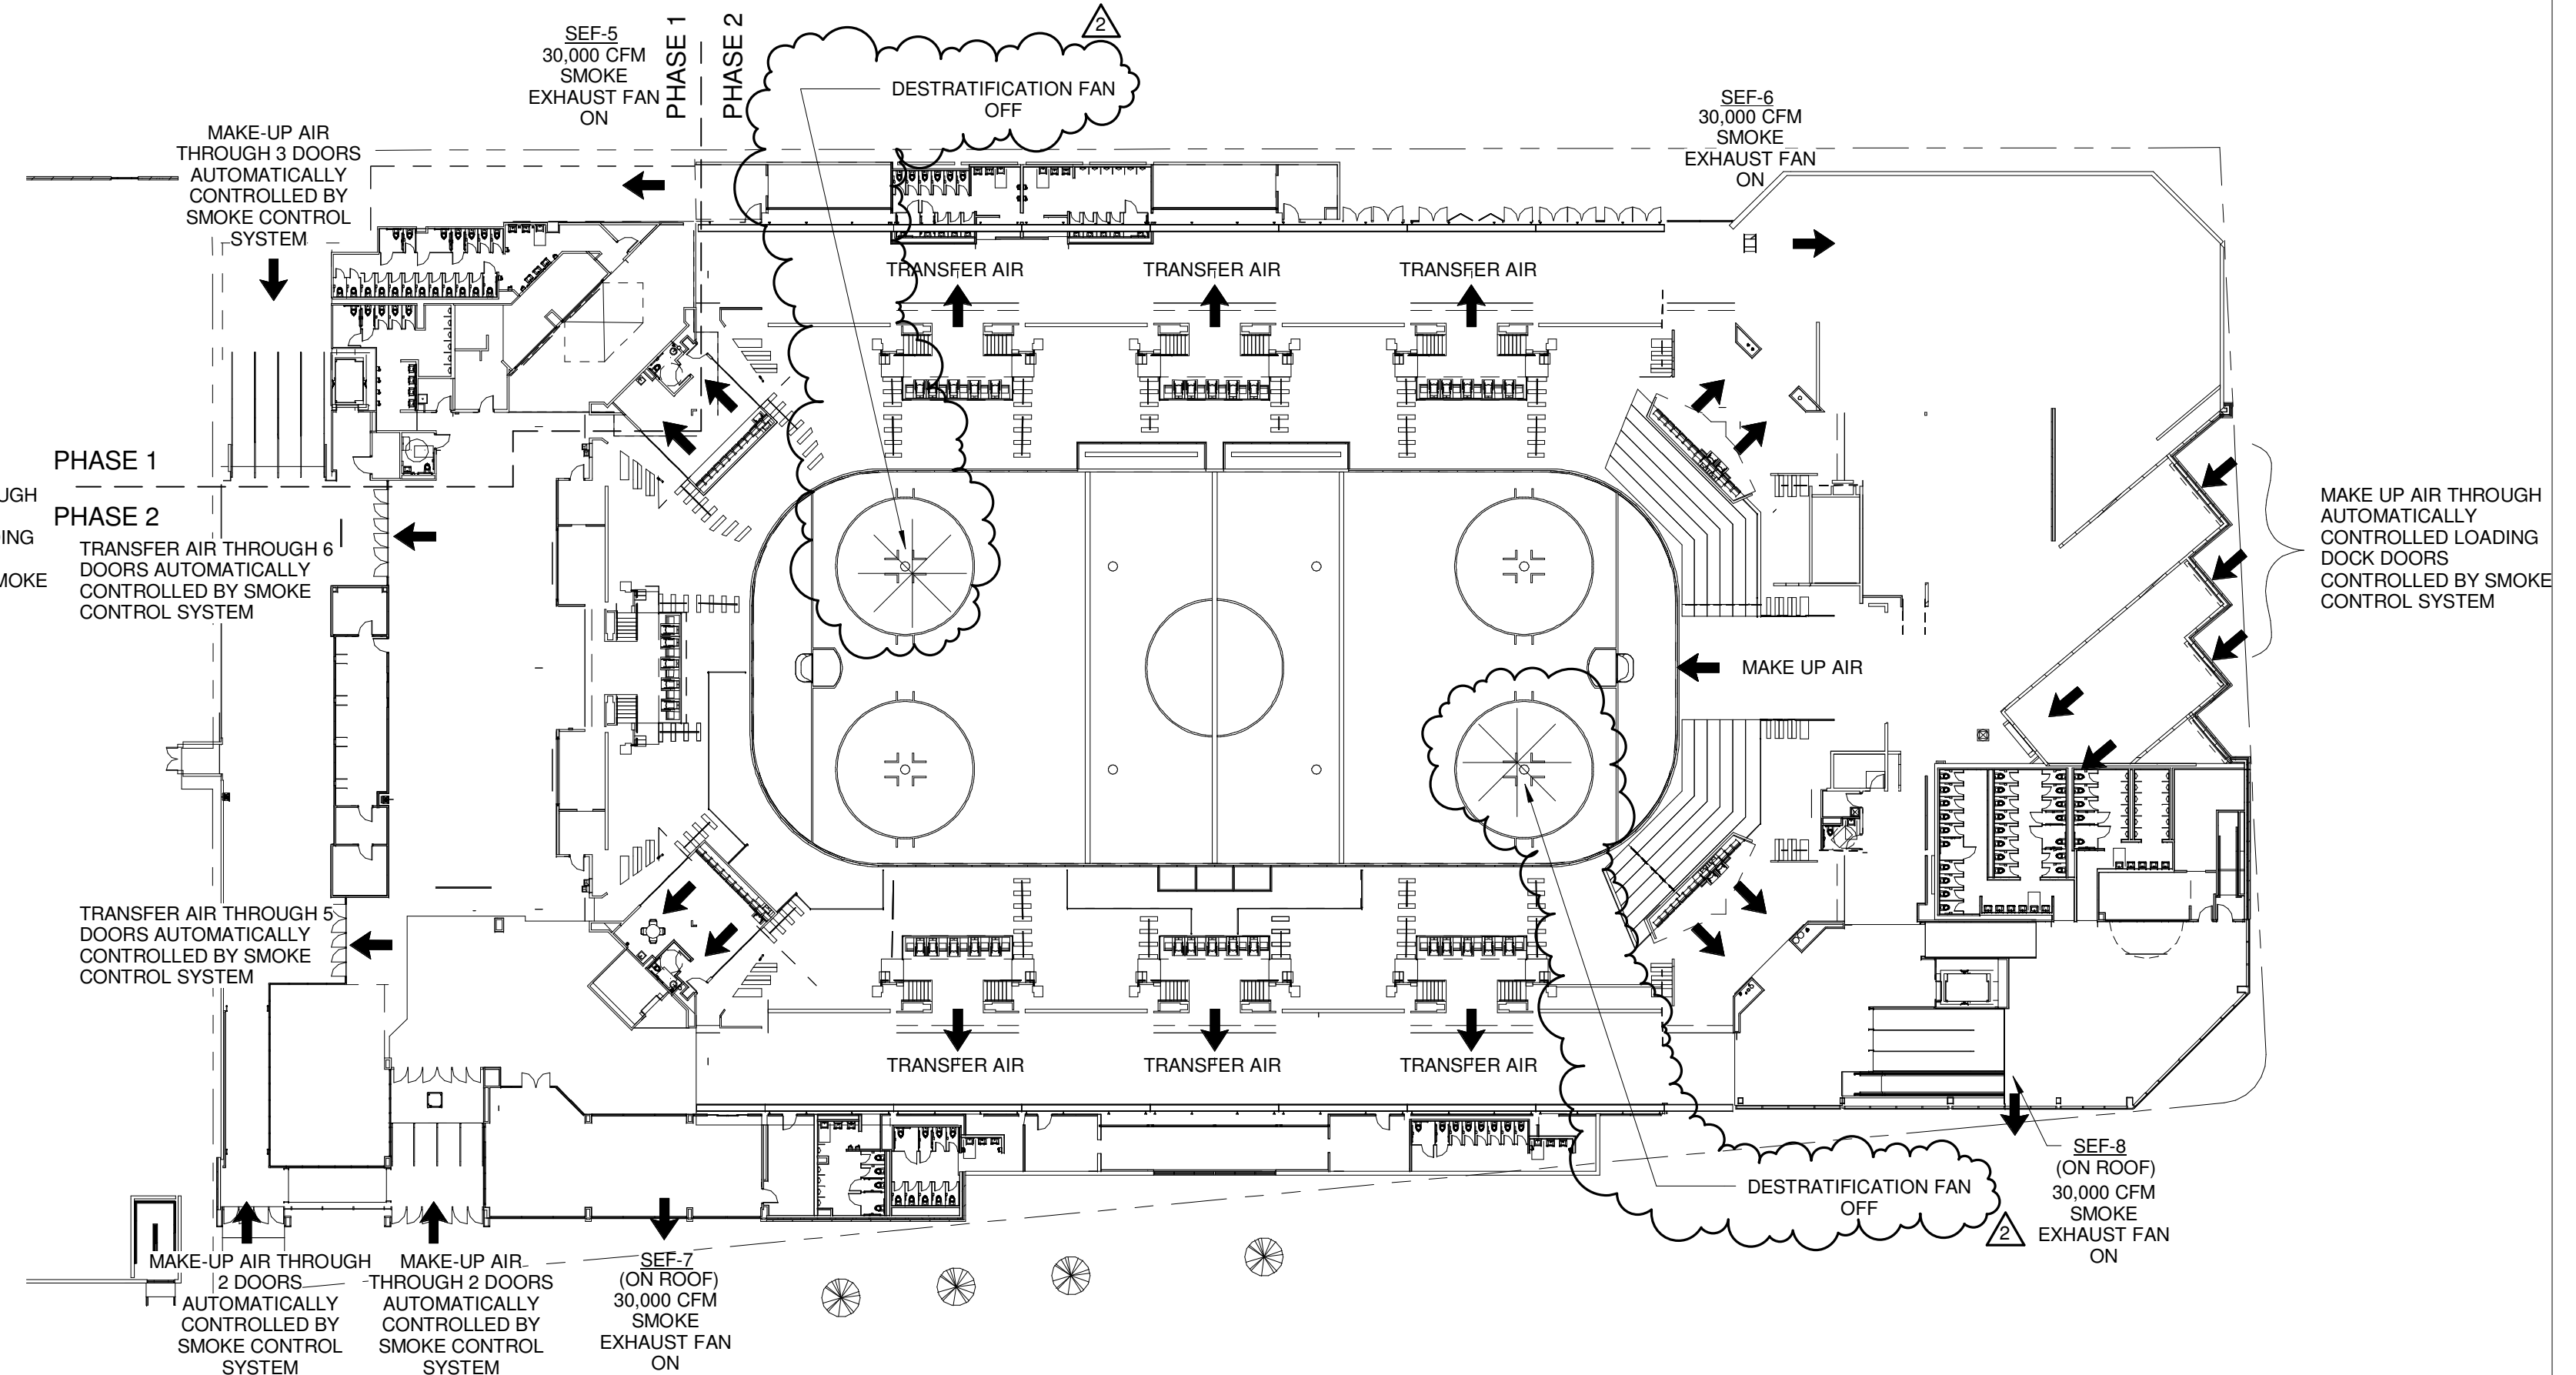

2 CONCOURSE SMOKE CONTROL - CONCOURSE LEVEL AIRFLOWS
1/32" = 1'-0"

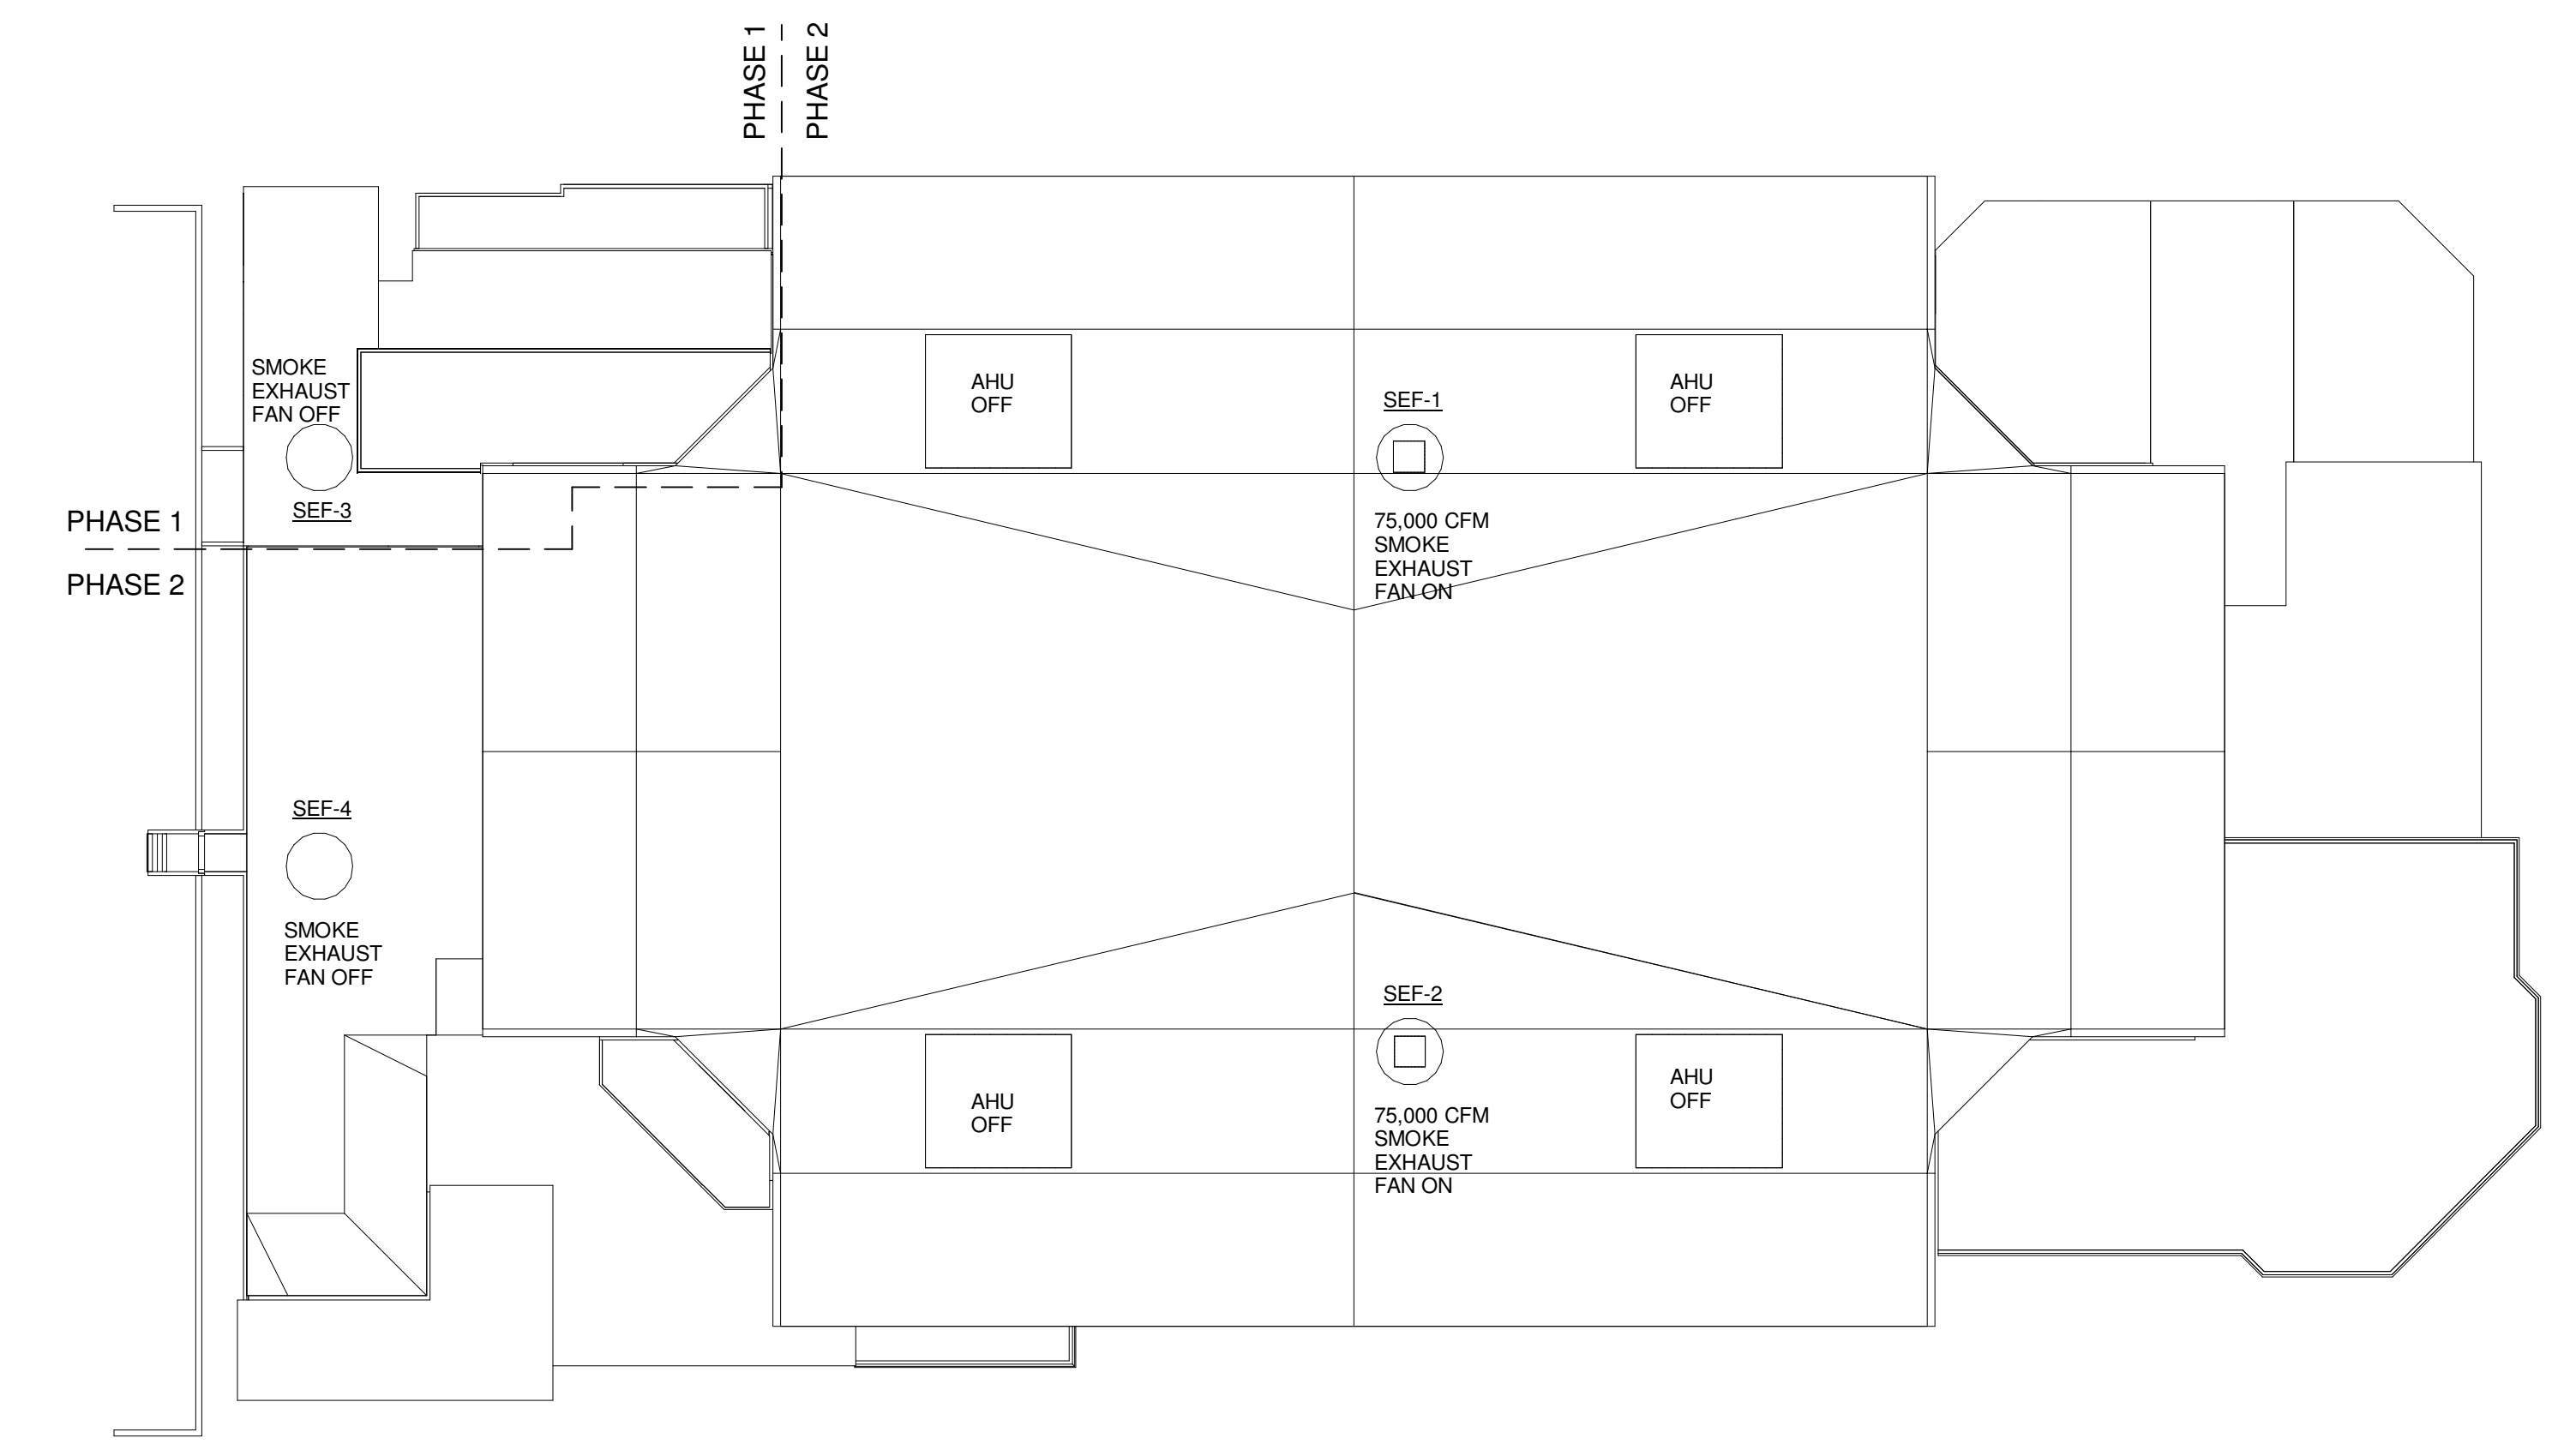

3 BOWL SMOKE CONTROL - ROOF LEVEL AIRFLOWS
1/32" = 1'-0"

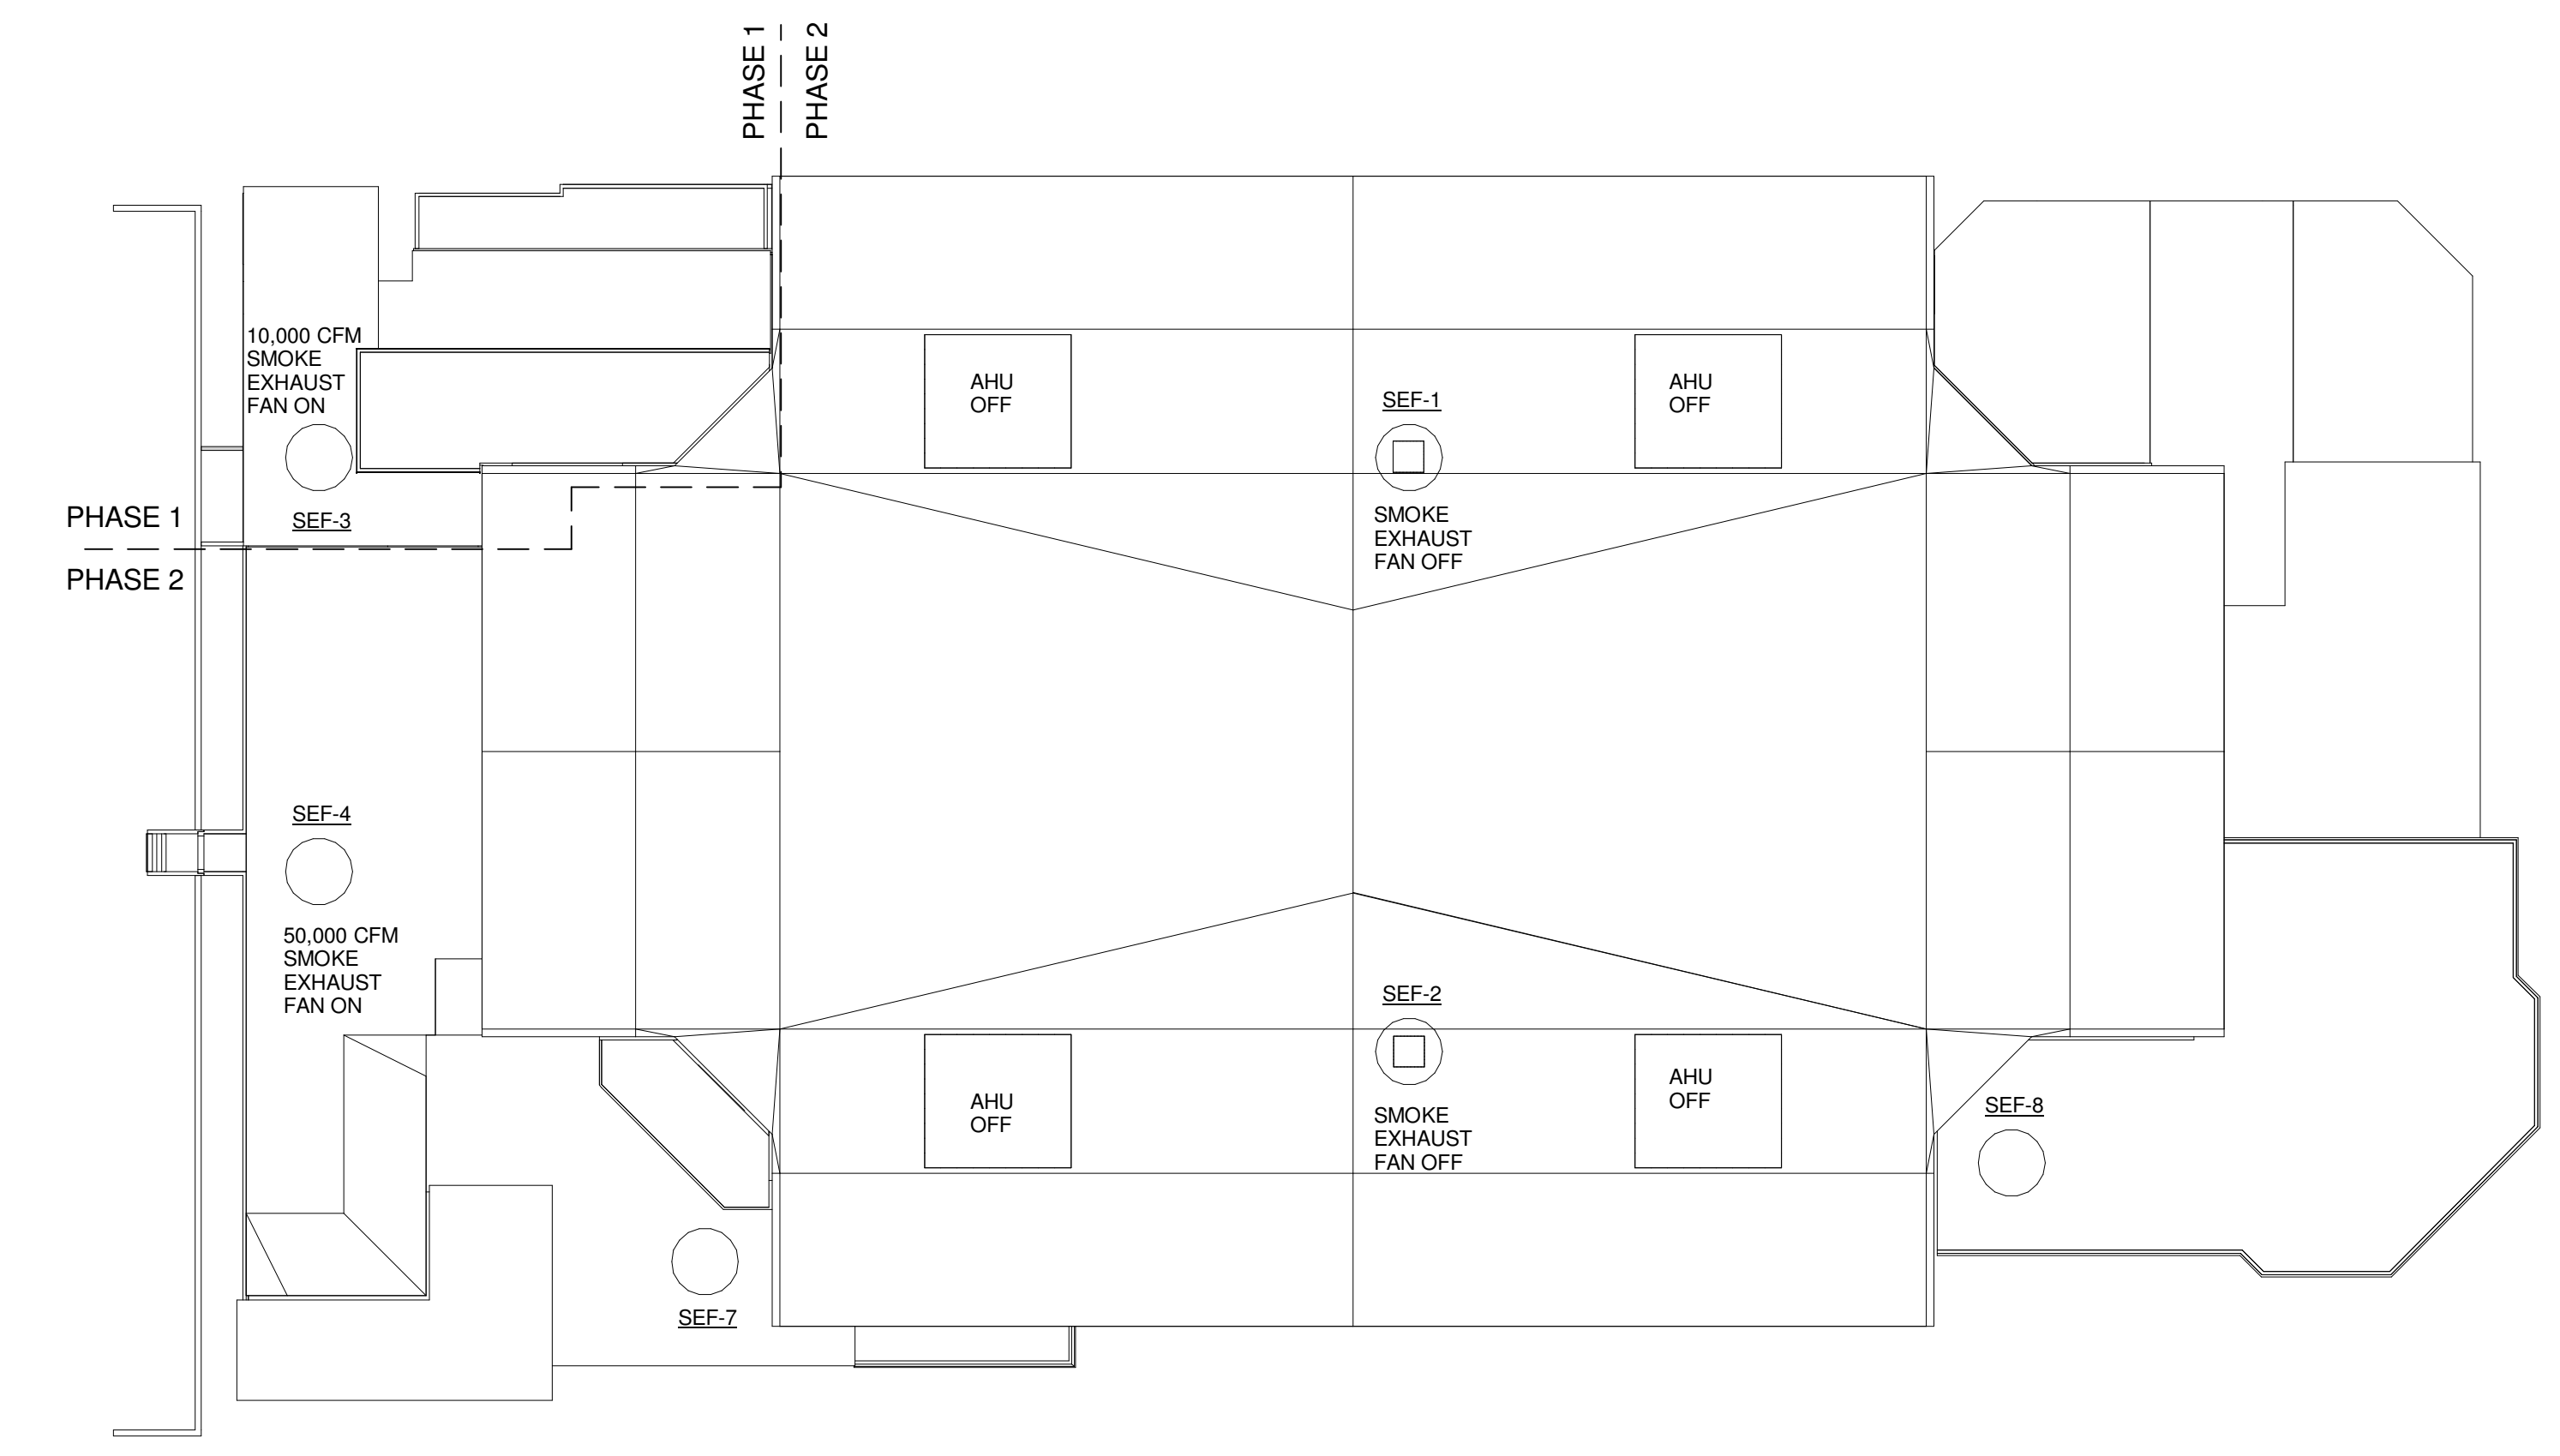

4 CONCOURSE SMOKE CONTROL - ROOF LEVEL AIRFLOWS
1/32" = 1'-0"

	A	B
	D	C

2	SI #073	04-02-2013
1	CONSTRUCTION DOCUMENTS	01-21-2013
0	NW ENTRY CONSTRUCTION DOCS	10-31-2012

REV. DESCRIPTION DATE

SI #073
04-02-2013

CURRENT ISSUE STATUS:



WBRC
ARCHITECTS • ENGINEERS
WWW.WBRCAL.COM
BANGOR, MAINE 207-947-4511
PORTLAND, MAINE 207-838-4511
SARASOTA, FLORIDA 941-556-0757

CUMBERLAND COUNTY CIVIC CENTER RENOVATION

PROJECT: PORTLAND, ME

MECHANICAL SMOKE CONTROL SCHEMATICS

SHEET TITLE	MECHANICAL SMOKE CONTROL SCHEMATICS
WBRC CAD FILE	375700 - 0002 Mechanical.rvt
PROJECT No.	3757.00
SCALE	1/32" = 1'-0"
PROJECT MANAGER	JRB
DRAWN BY	COB
CHECKED BY	DMON
SHEET No.	M8.01