
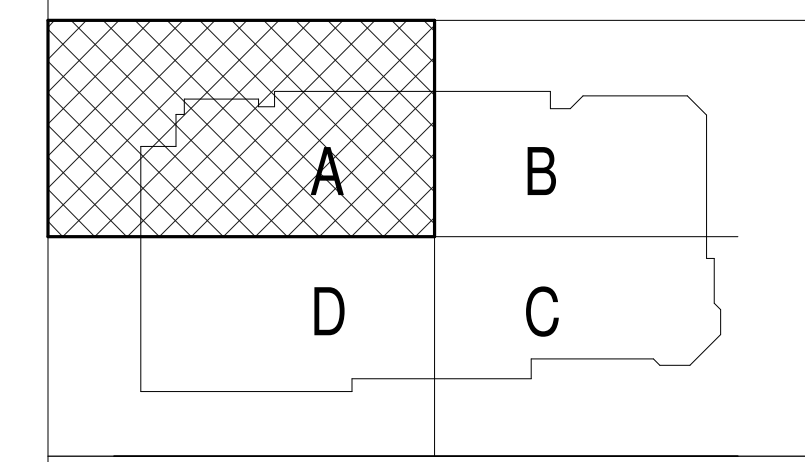




SINK COMBS DETHLEFS

Copyright by
Sink Combs
Dethlefs, P.C.
475 Lincoln Street,
Suite 100
Denver, Colorado 80202
303.398.0200
FAX 303.398.0222

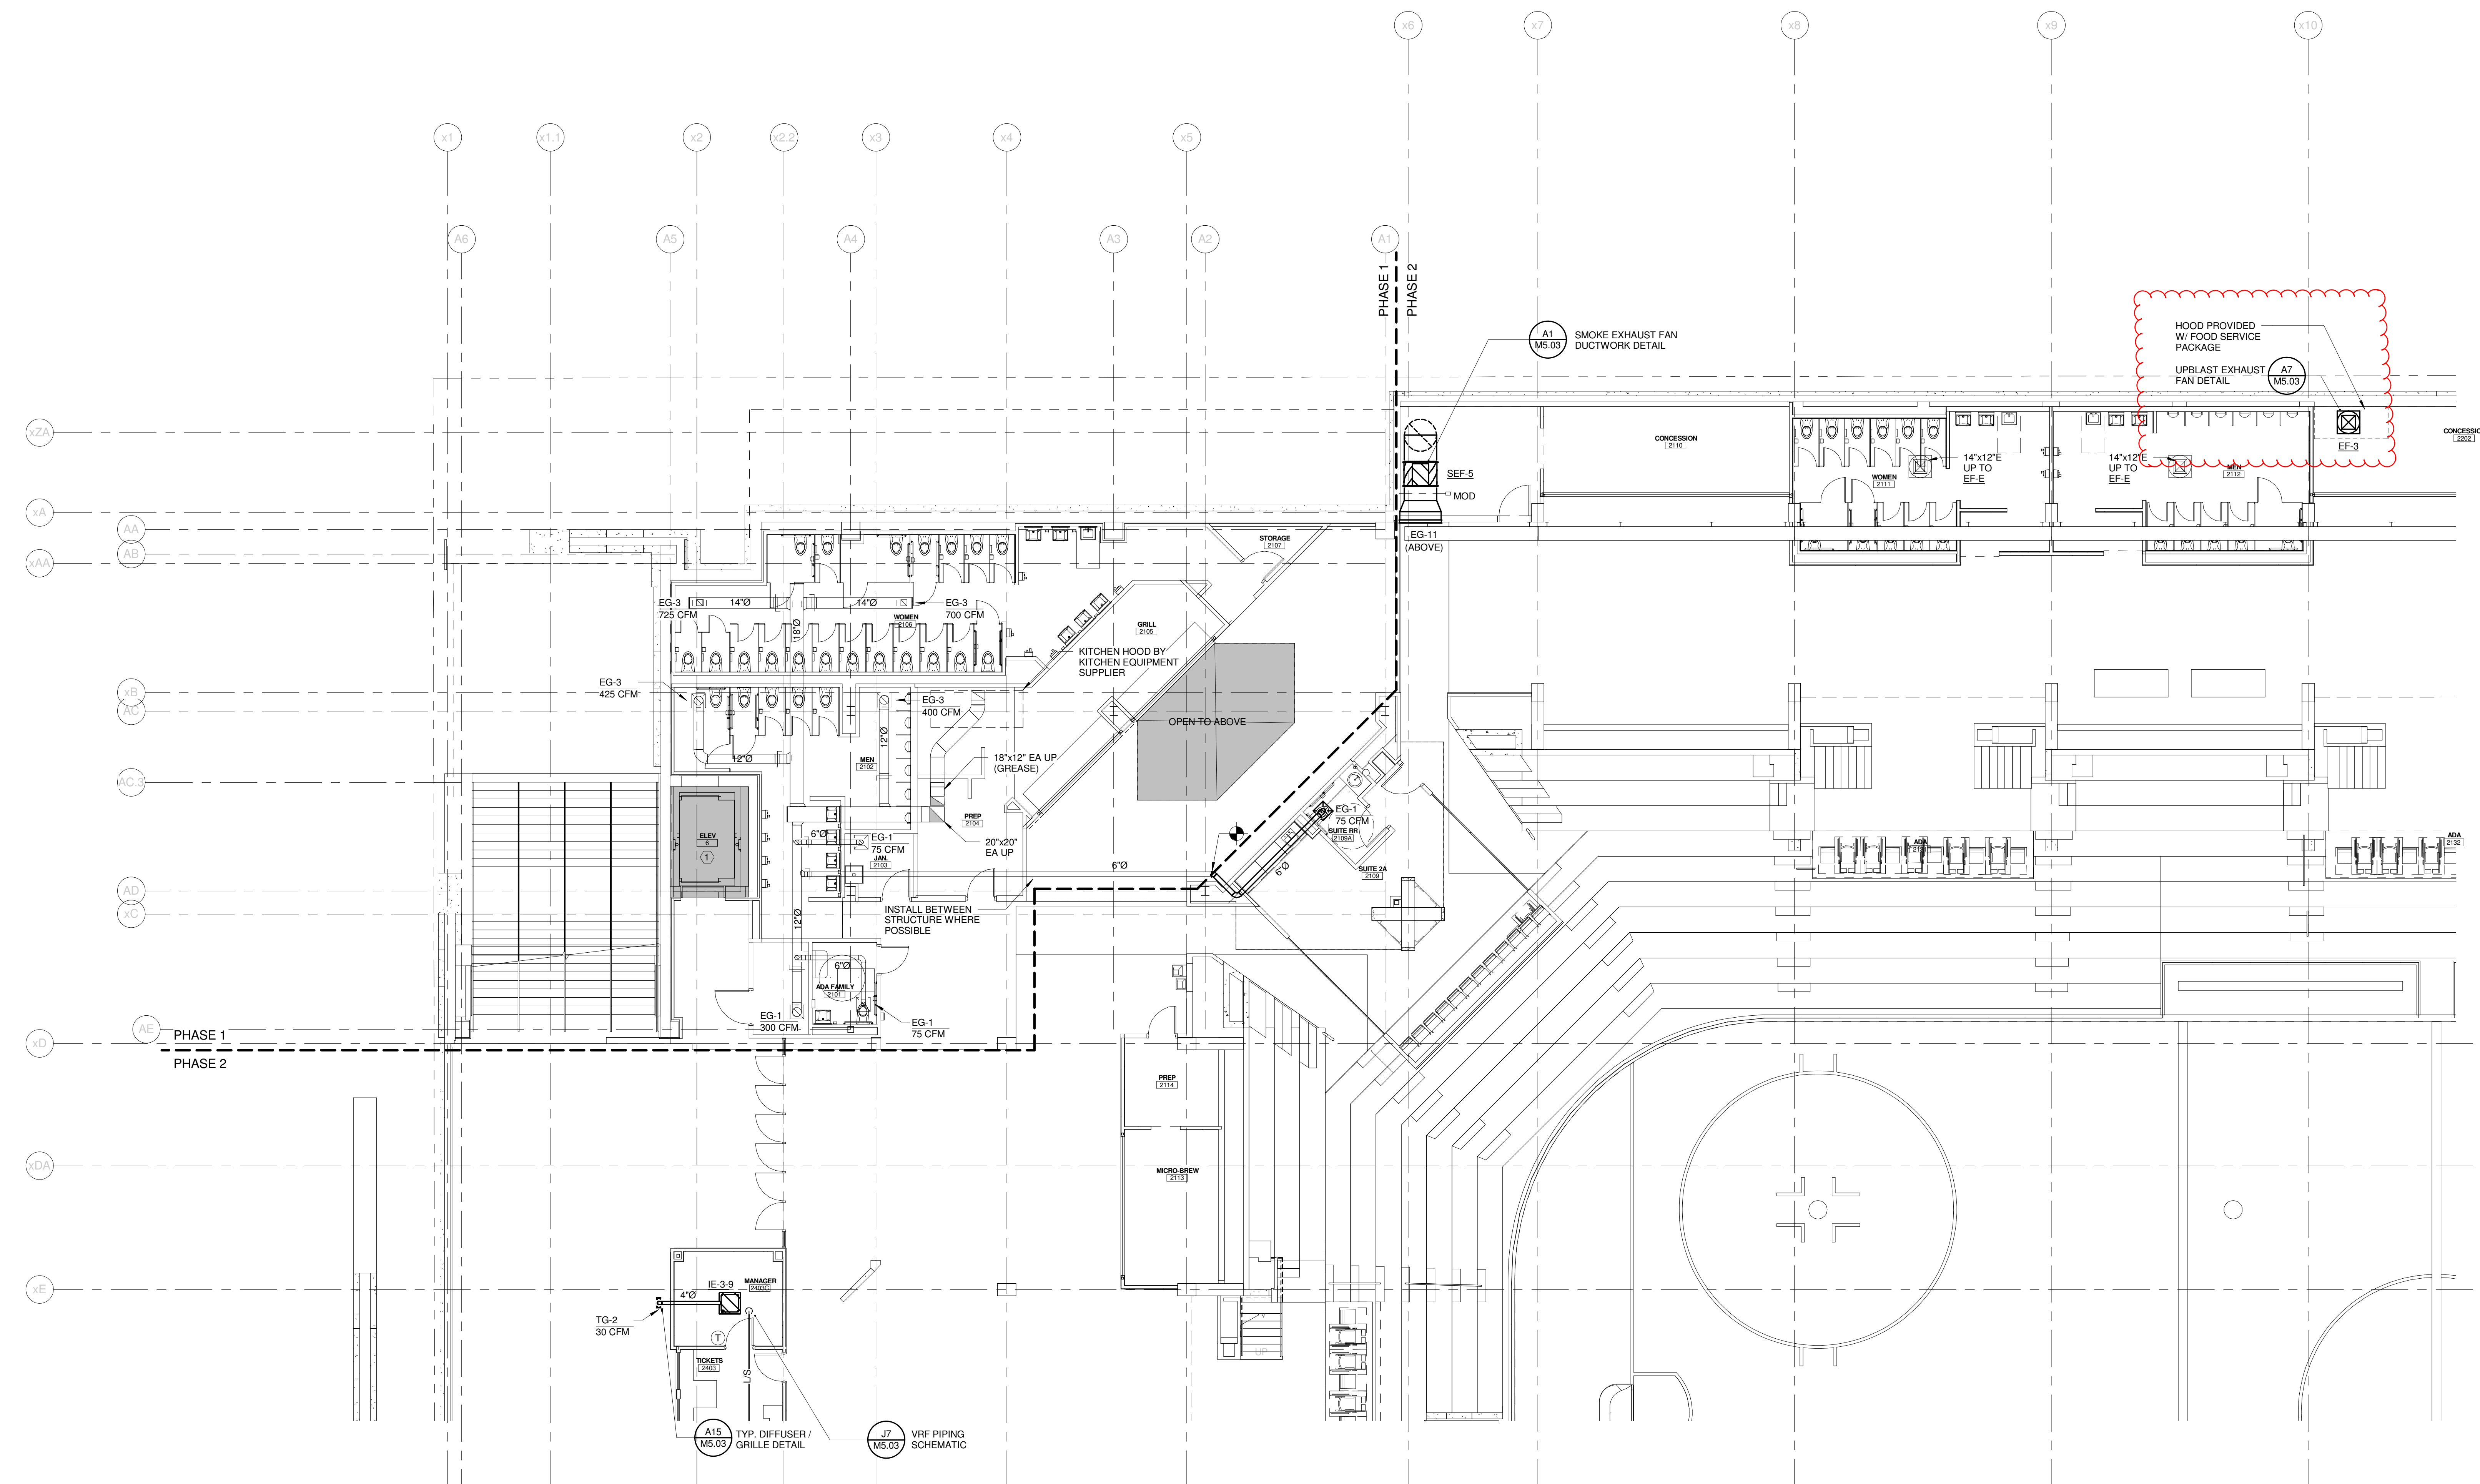

REV.	DESCRIPTION	DATE
0	CONSTRUCTION DOCUMENTS	01-21-2013
CONSTRUCTION DOCUMENTS		
01-21-2013		

CURRENT ISSUE STATUS:

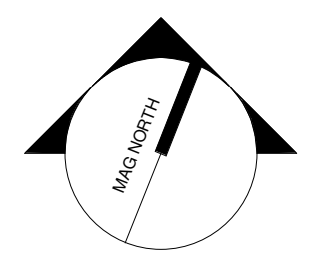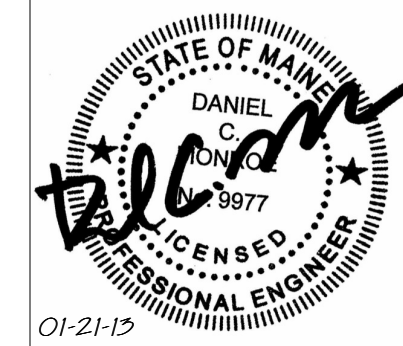PROJECT NORTH
01-21-13

WBRC
ARCHITECTS • ENGINEERS
WWW.WBRCAL.COM
BANGOR, MAINE 207-947-4511
PORTLAND, MAINE 207-838-4511
SARASOTA, FLORIDA 941-556-0727

CUMBERLAND COUNTY CIVIC CENTER RENOVATION

PROJECT: PORTLAND, ME

**CONCOURSE LEVEL
MECHANICAL PLAN - QUAD A**

SHEET TITLE

WBRC CAD FILE: 375700 - CCCC Mechanical - M2.21B.rvt

PROJECT No. **3757.00** GRAPHIC SCALE: 1" = 1'-0"

SCALE: 1/8" = 1'-0"

PROJECT MANAGER: JRB
DRAWN BY: CGB
CHECKED BY: DMON

SHEET No. **M2.21B**

1/21/2013 10:05:51 AM
C:\Users\andrew.rudnik\Documents\375700 - CCCC Mechanical - M2.21B.rvt