


SINK COMBS DETHLEFS

Copyright by Sink Combs Dethlefs
 475 Lincoln Street, Suite 100
 Durham, Colorado 80202



REV.	DESCRIPTION	DATE
0	SD ADDENDUM #3	
	05/17/2012	
	CURRENT ISSUE STATUS: 100% SD	

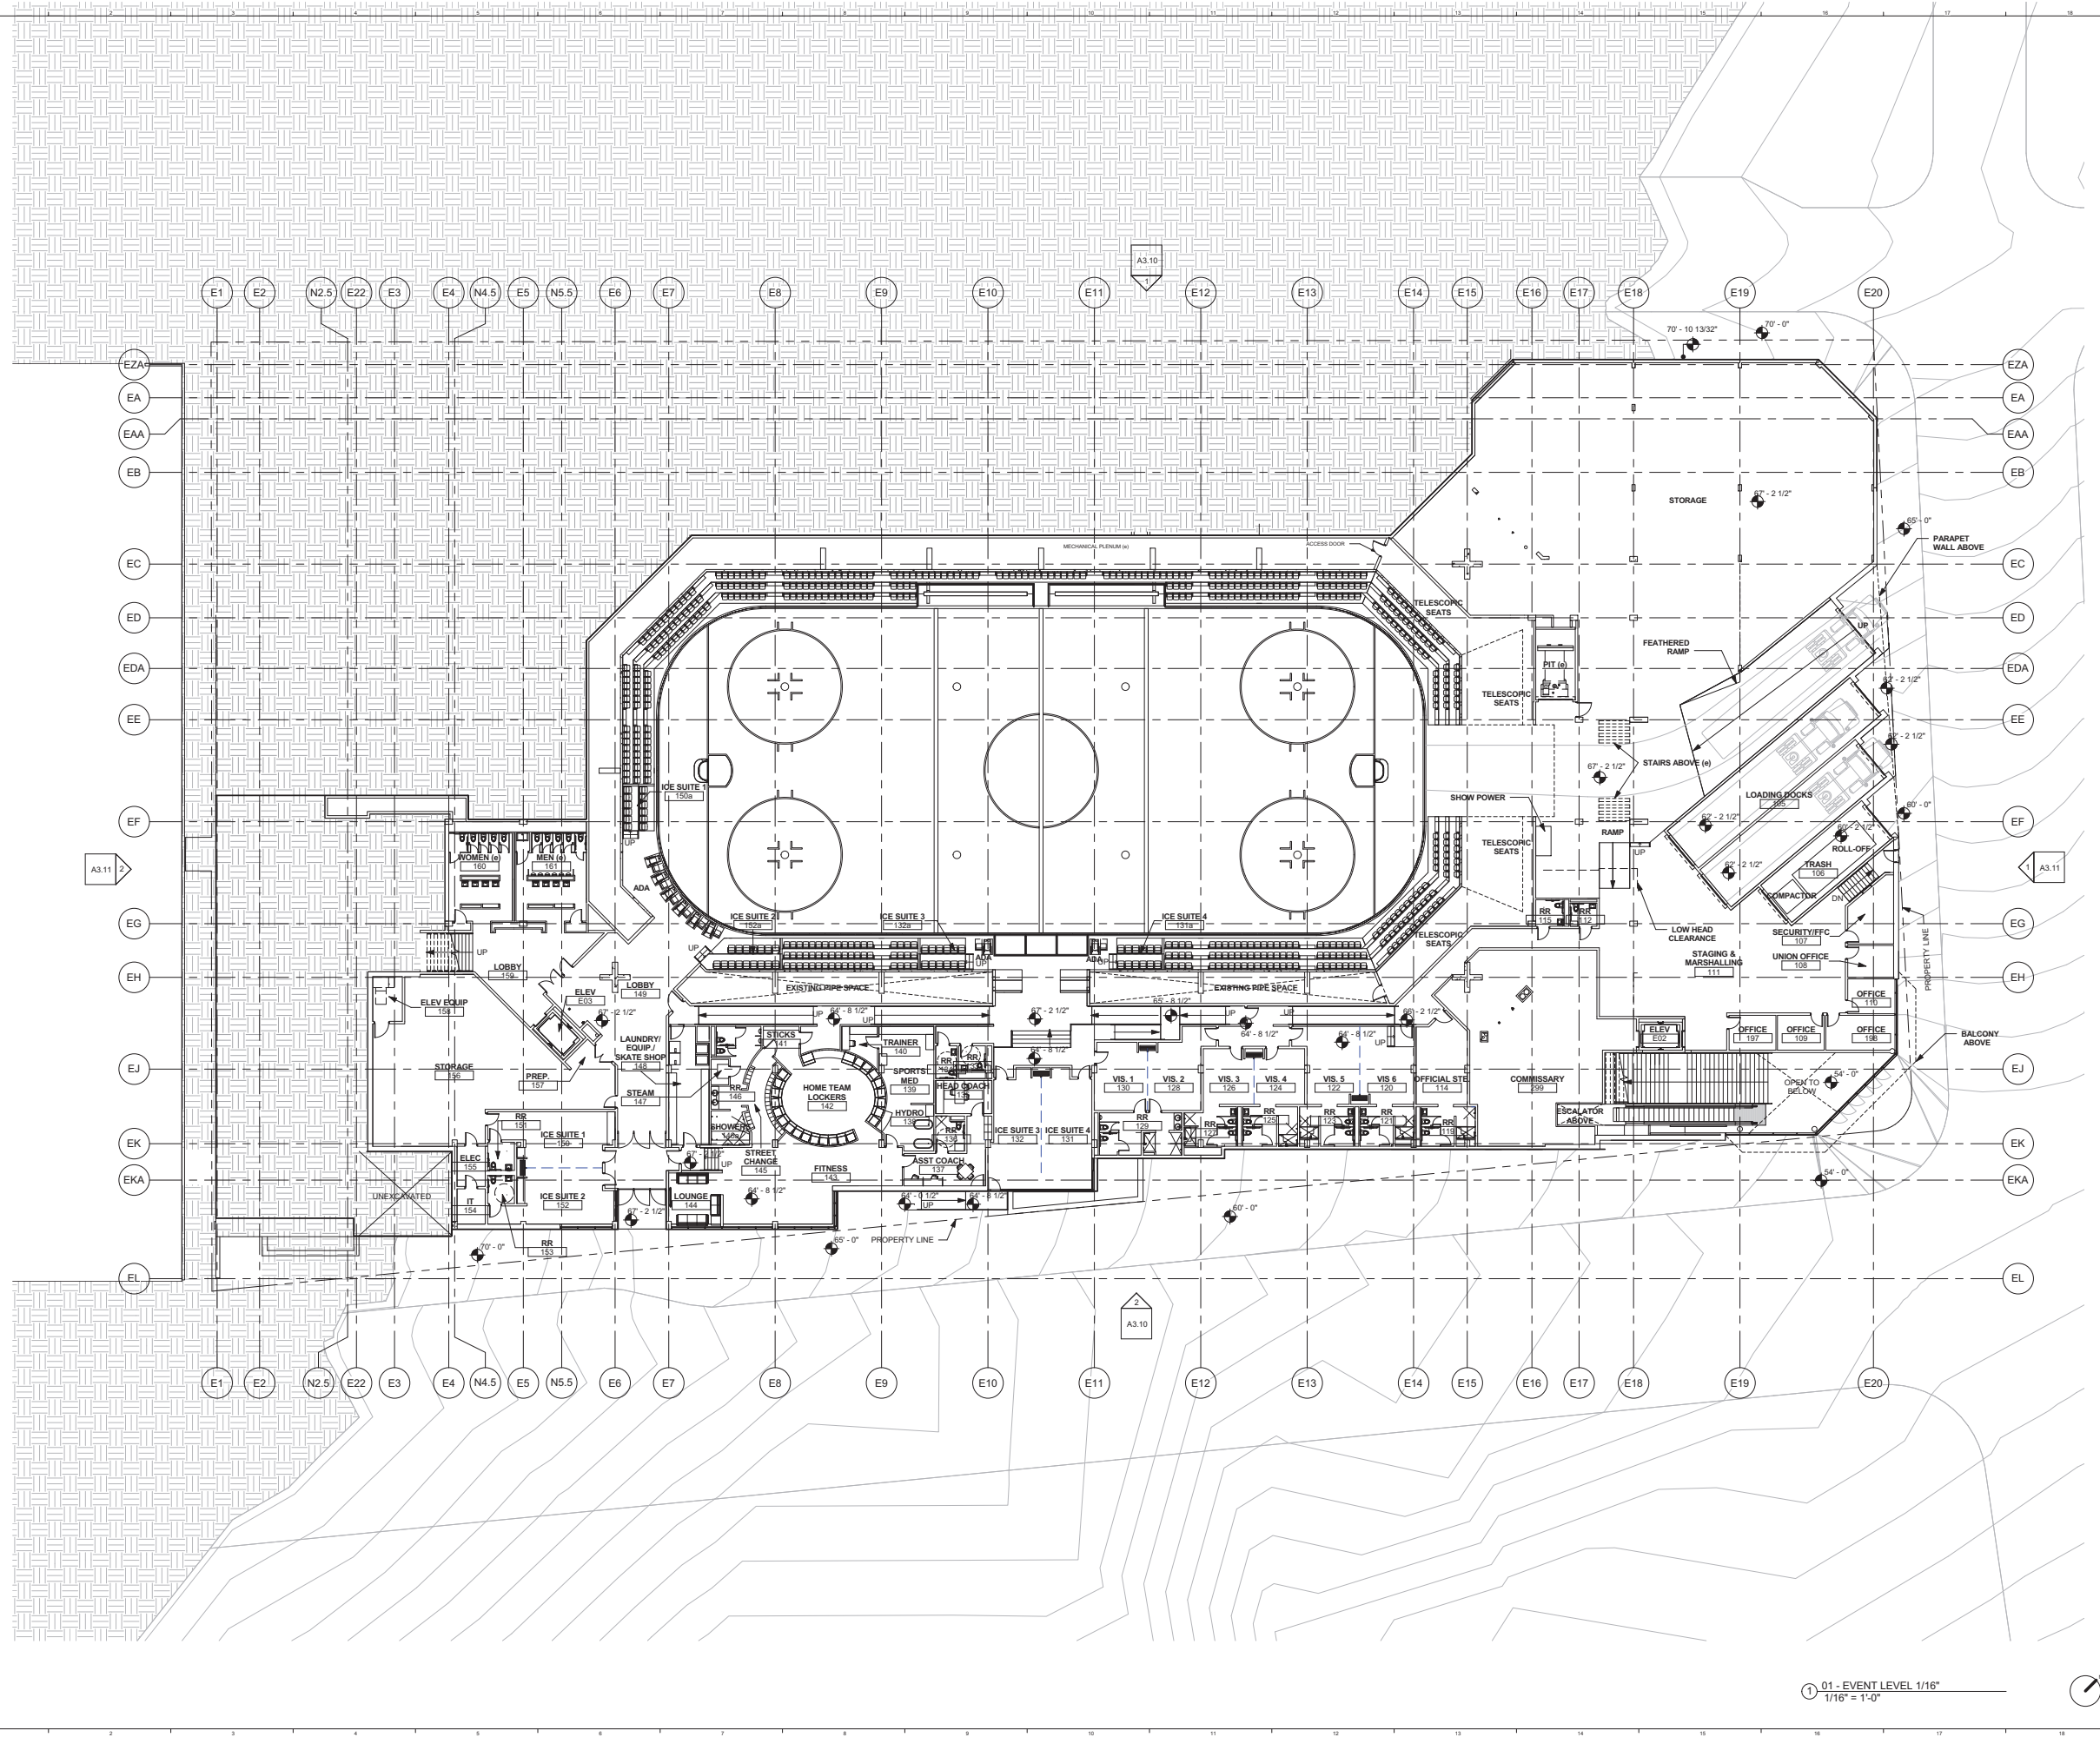

Cumberland County Civic Center
 Portland, ME



EVENT LEVEL PLAN

SHEET TITLE:	WBRC CAD FILE:	PROJECT No:	01202.00	GRAPHIC SCALE:	0" = 1'-0"
		SCALE:	1/16" = 1'-0"		
		PROJECT MANAGER:	Approver	CHECKED BY:	Checker
		DRAWN BY:	Author		
					A2.10

1 - EVENT LEVEL 1/16" = 1'-0"

SINK COMBS DETHLEFS

Copyright by Sink Combs Dethlefs
 475 Lincoln Street, Suite 100
 Durham, Colorado 80202
 303.538.0300
 FAX 303.538.0222

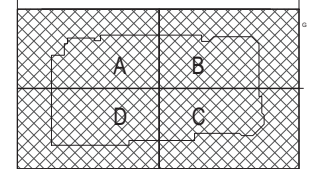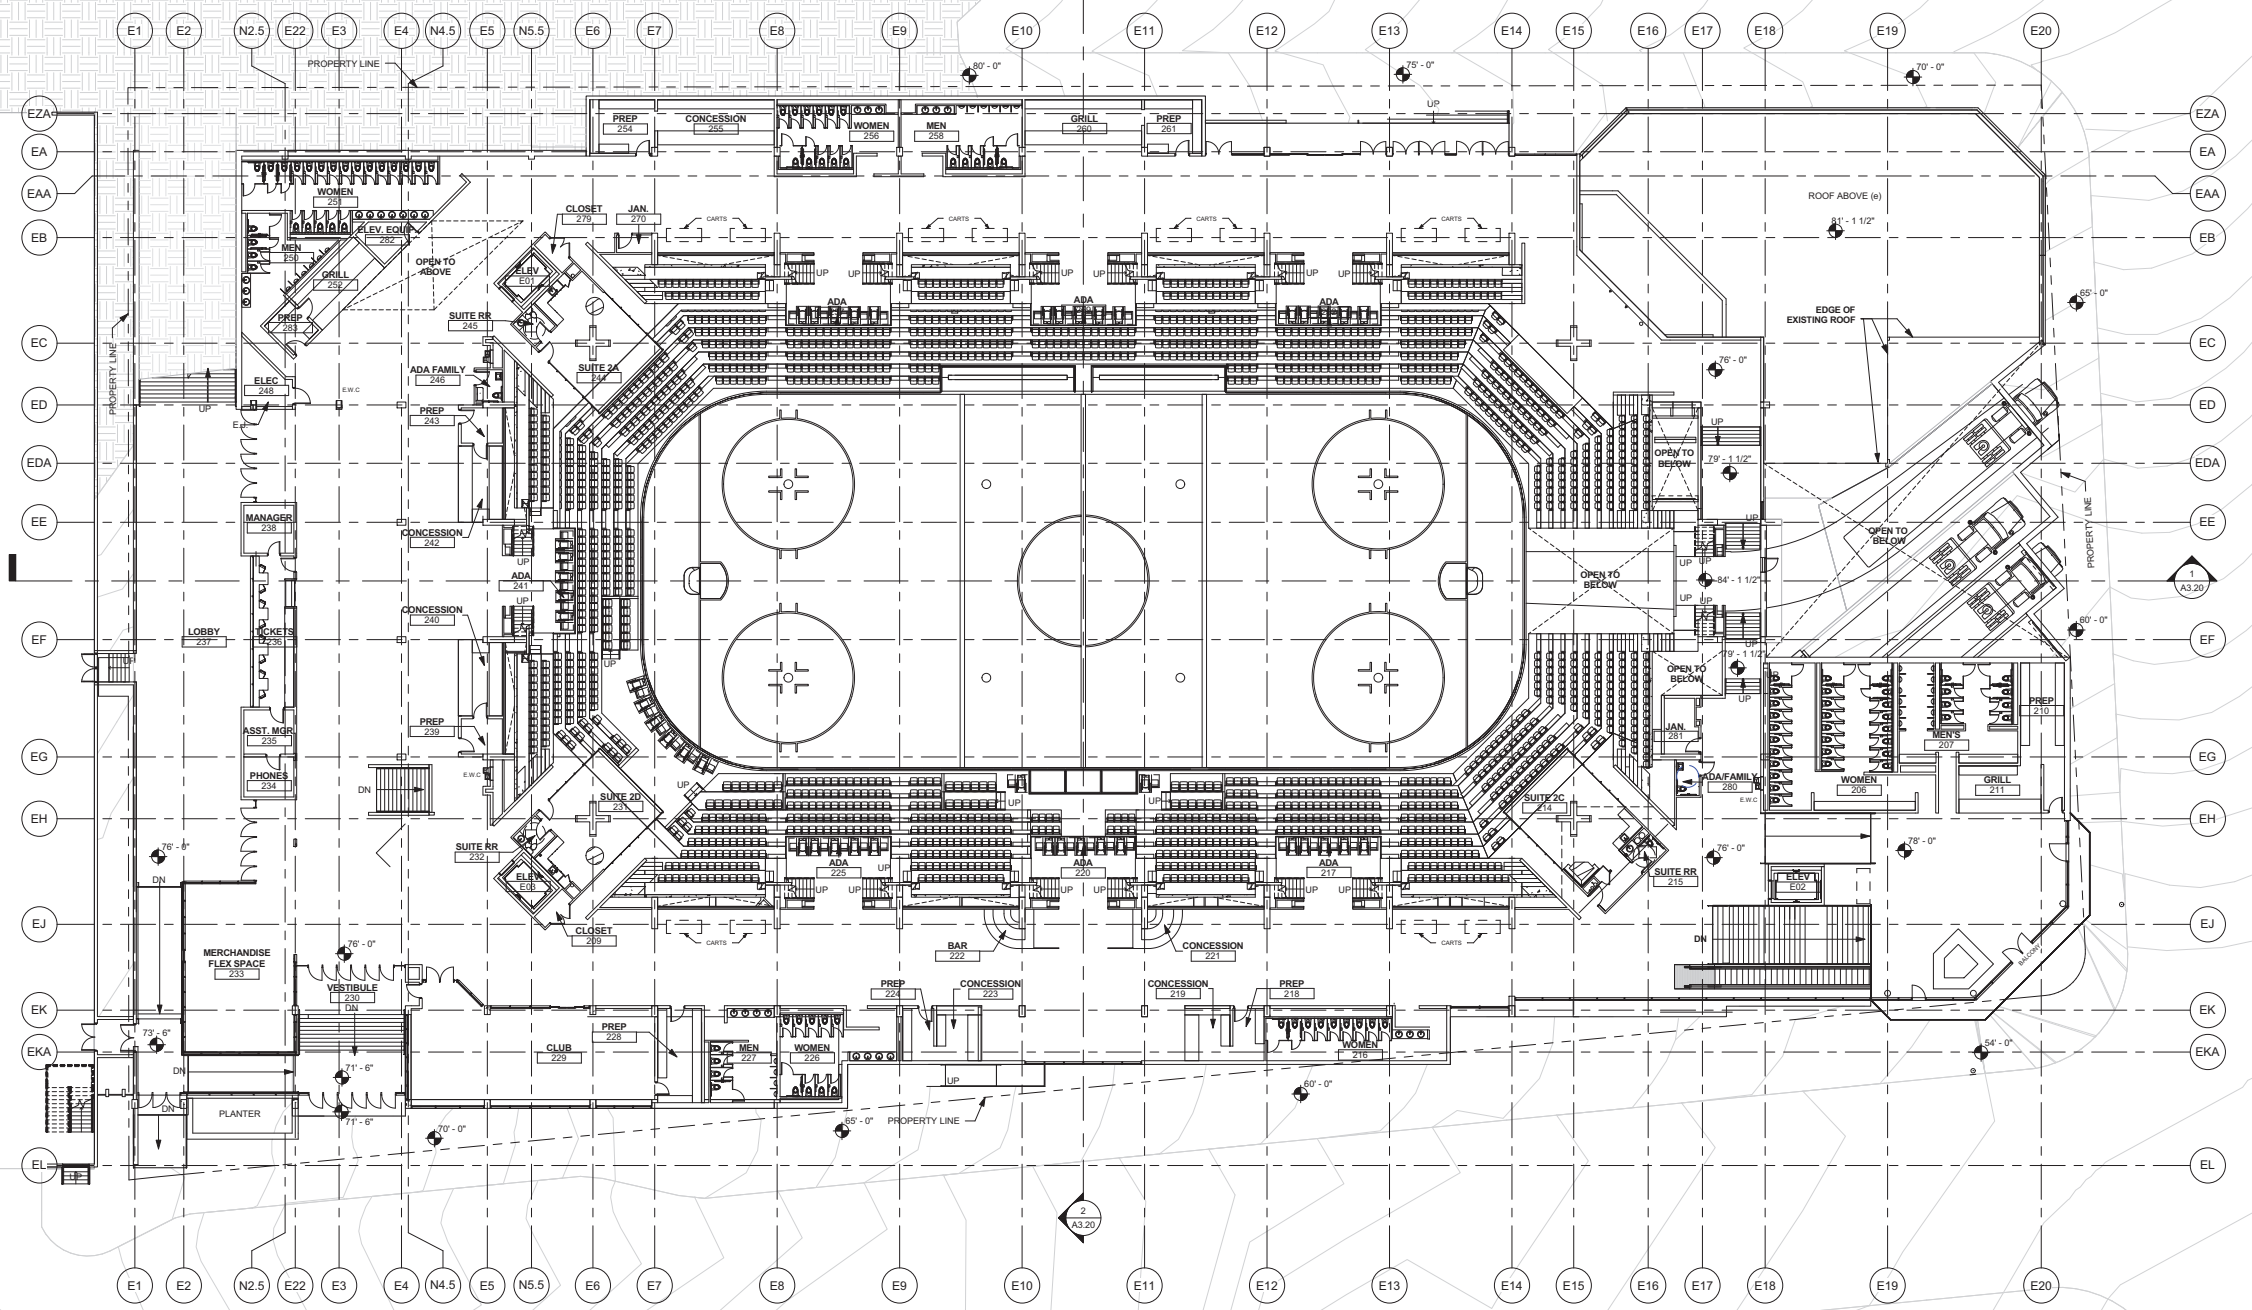

REV.	DESCRIPTION	DATE
0	SD ADDENDUM #3	
	05/17/2012	
	CURRENT ISSUE STATUS: 100% SD	



WBRC
 ARCHITECTS ENGINEERS
 WWW.WBRC.AE.COM
 BANGOR, MAINE 207.447.4511
 PORTLAND, MAINE 207.423.4511
 SUWANEEVILLE, FLORIDA 351.556.9707

Cumberland County Civic Center
 Portland, ME



CONCOURSE PLAN

PROJECT NO:	01202.00	DRAWING SCALE:	1" = 1'-0"
SCALE:	1/16" = 1'-0"	SHEET NO.:	A2.20
PROJECT MANAGER:	Approver		
DRAWN BY:	Author		
CHECKED BY:	Checker		

1 02 - CONCOURSE LEVEL 1/16"
 1/16" = 1'-0"

SINK COMBS DETHLEFS

Copyright by Sink Combs Dethlefs, P.C. 475 Lincoln Street, Suite 100, Durham, Colorado 80202 303.538.0200, 303.538.0222

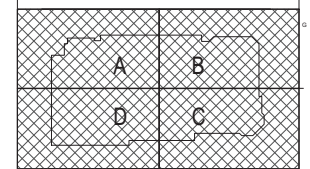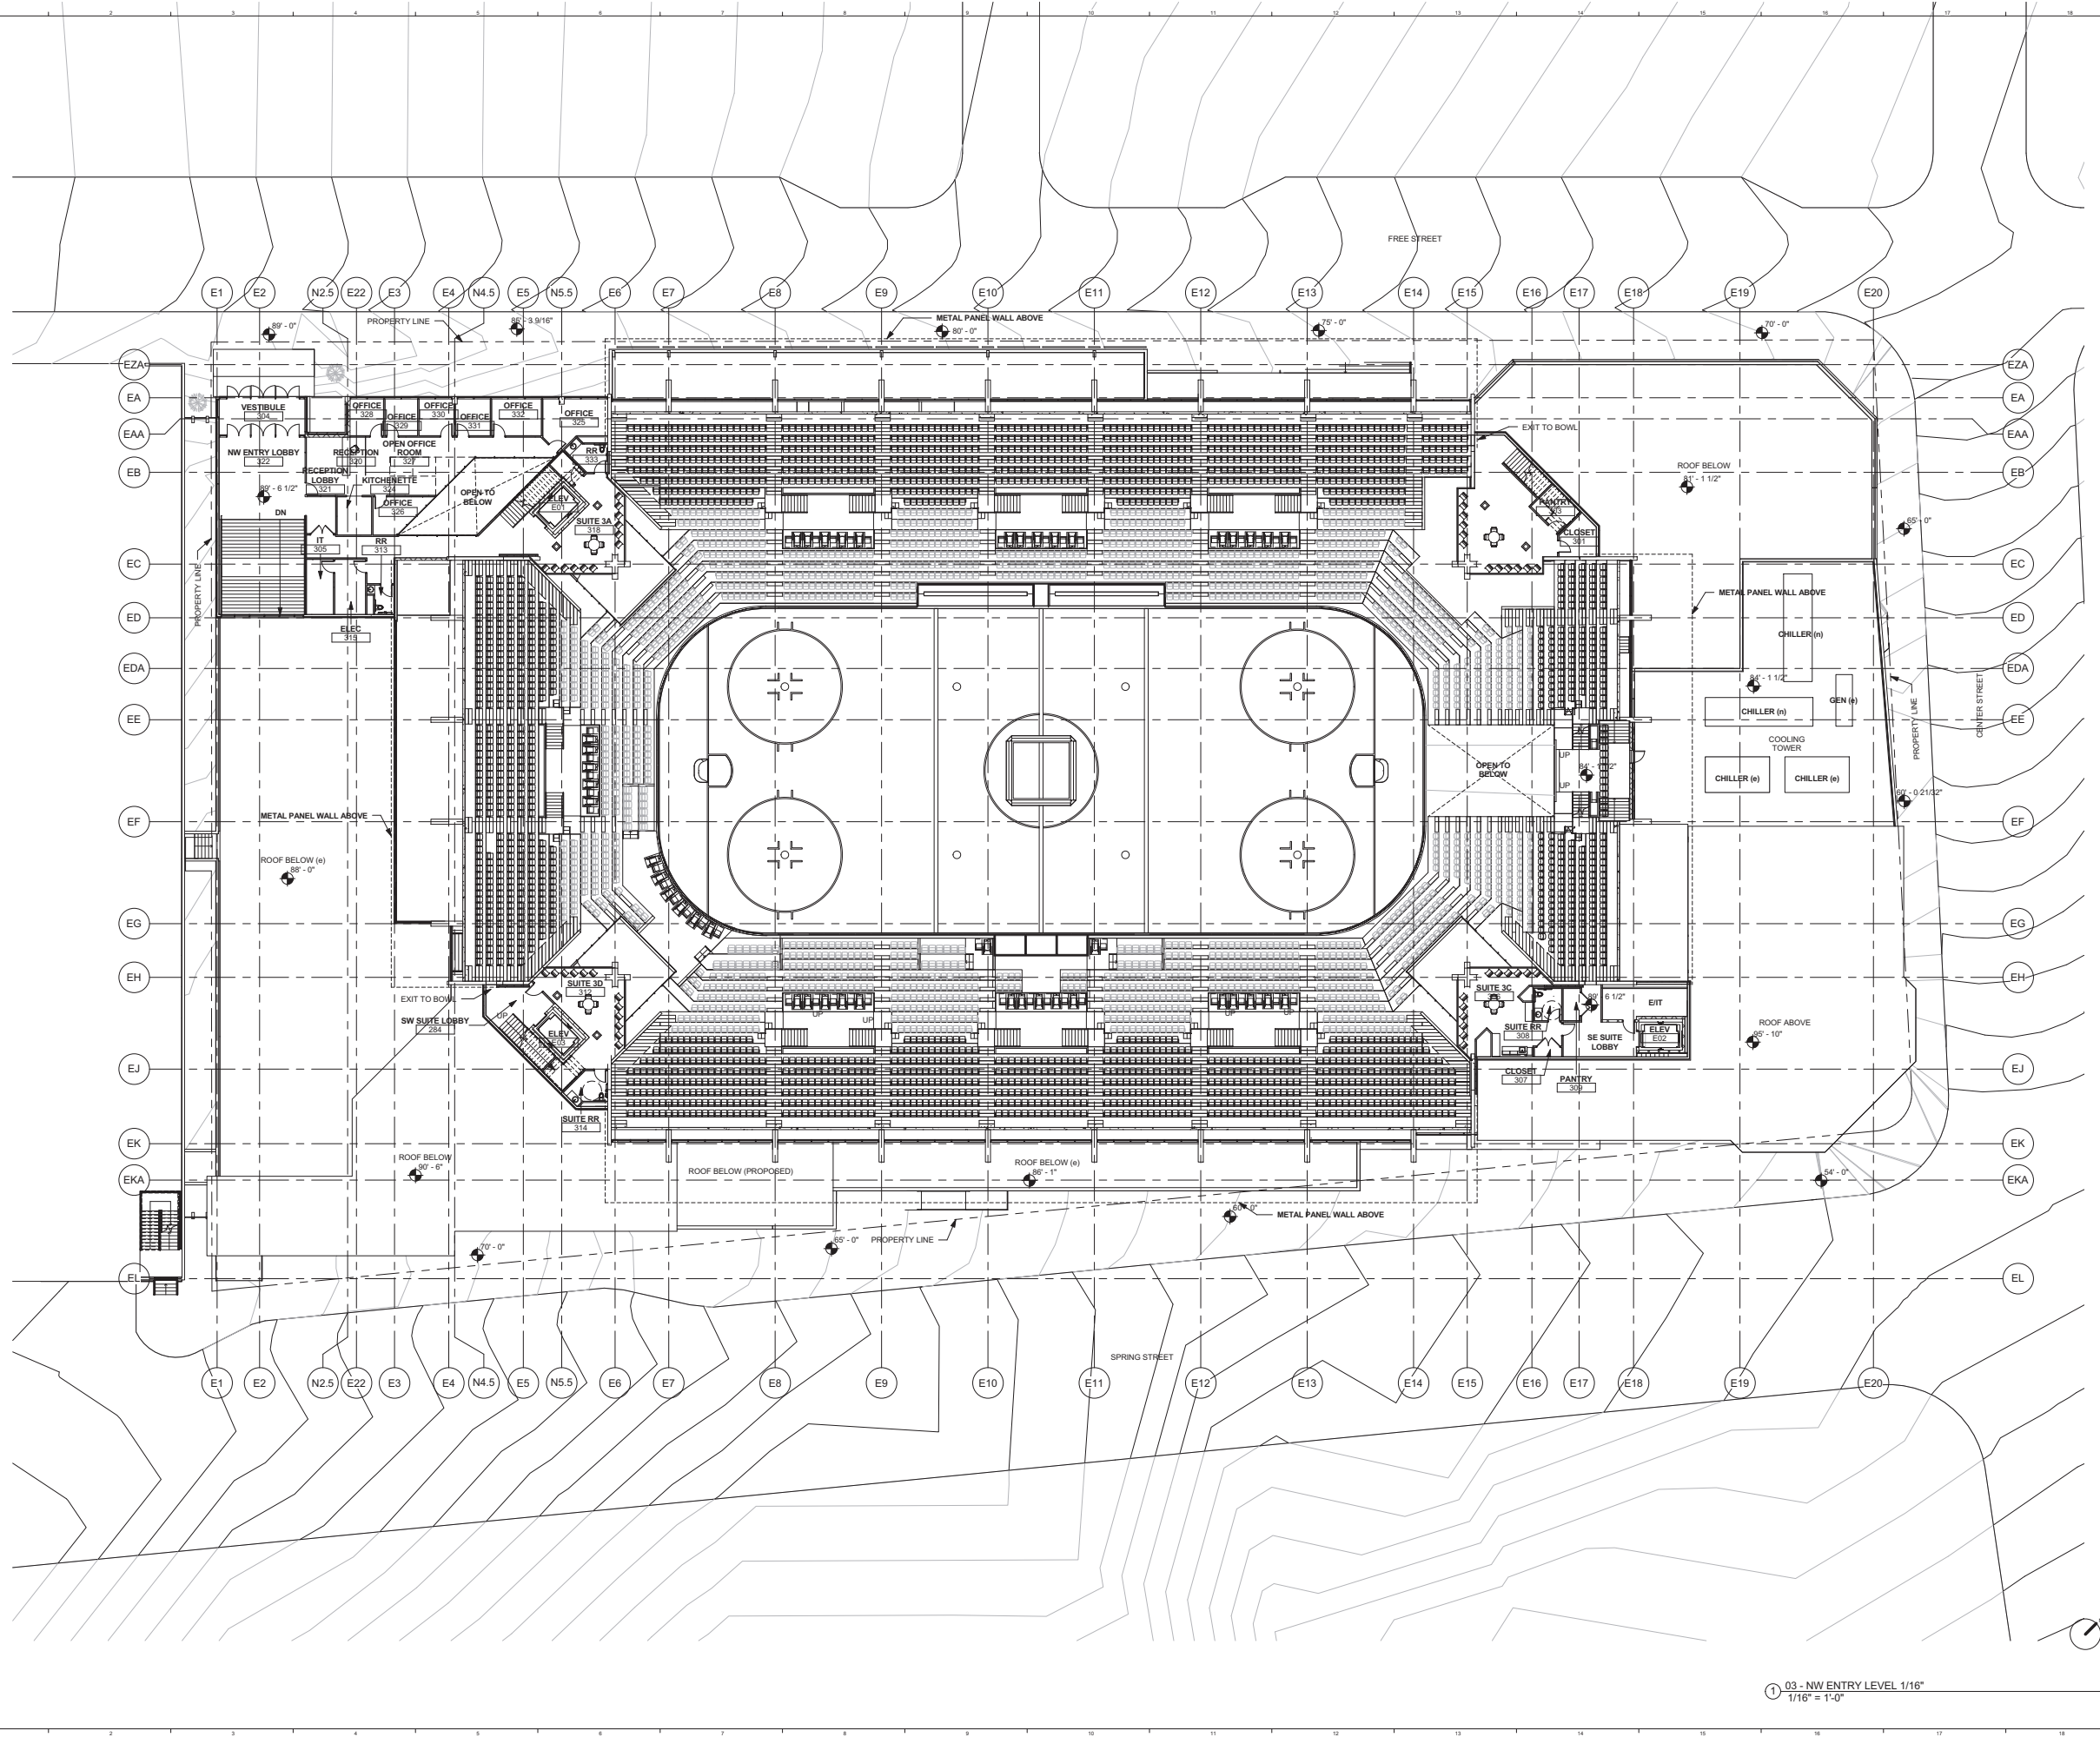

REV.	DESCRIPTION	DATE
0	SD ADDENDUM #3	
	05/17/2012	
	CURRENT ISSUE STATUS: 100% SD	



WBRC
ARCHITECTS ENGINEERS
WWW.WBRC.AE.COM
BANGOR, MAINE 207.447.4511
PORTLAND, MAINE 207.423.4511
SARASOTA, FLORIDA 941.556.9707

Cumberland County Civic Center
Portland, ME



NW ENTRY LEVEL

PROJECT No:	01202.00	DRAWING SCALE:	1" = 1'-0"
SCALE:	1/16" = 1'-0"		
PROJECT MANAGER:	Approver	CHECKED BY:	Checker
DRAWN BY:	Author		
			A2.30

03 - NW ENTRY LEVEL 1/16"
1/16" = 1'-0"

SINK COMBS DETHLEFS

Copyright by Sink Combs Dethlefs, P.C. 475 Lincoln Street, Suite 100, Denver, Colorado 80203 303.558.0300 303.558.0322

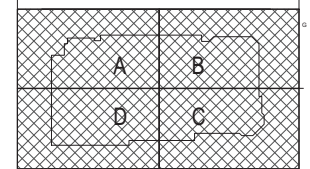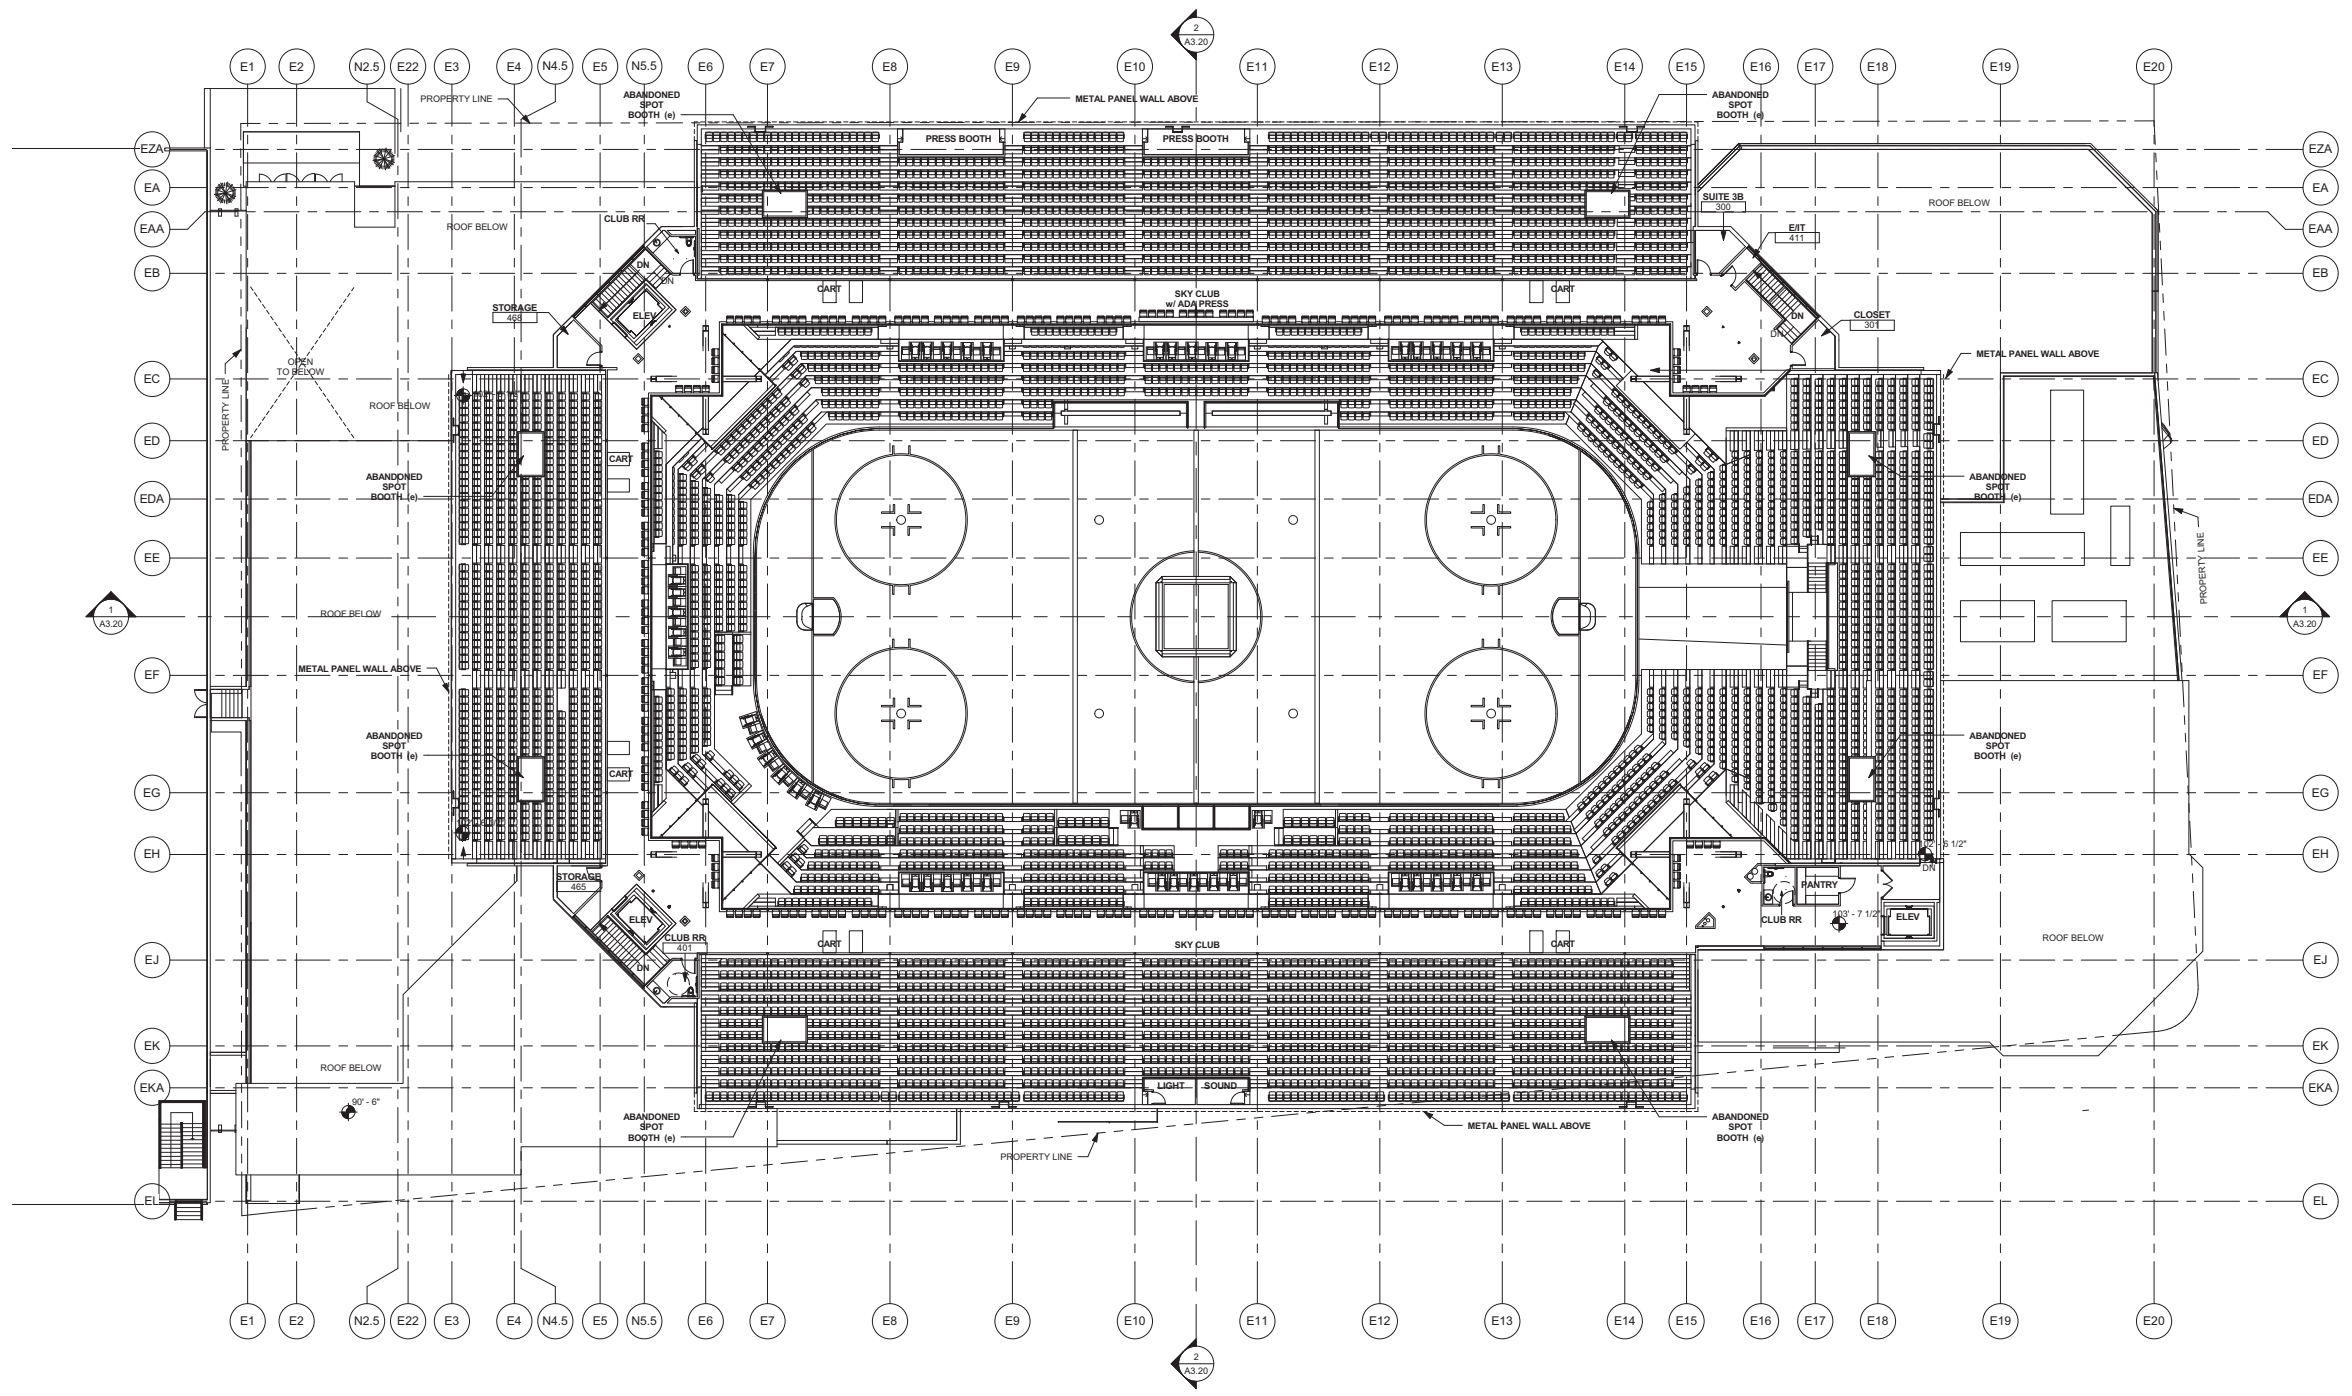

REV.	DESCRIPTION	DATE
0	SD ADDENDUM #3	
	05/17/2012	
	CURRENT ISSUE STATUS: 100% SD	



WBRC
ARCHITECTS ENGINEERS
WWW.WBRC.AE.COM
BANGOR, MAINE 207.647.4511
PORTLAND, MAINE 207.623.4511
SARASOTA, FLORIDA 941.556.9707

Cumberland County Civic Center
Portland, ME



SKYCLUB PLAN

PROJECT No:	01202.00	DATE:	05/17/2012
SCALE:	1/16" = 1'-0"	DRAWING SCALE:	1" = 1'-0"
PROJECT MANAGER:	Approver	CHECKED BY:	Checker
DRAWN BY:	Author	SHEET No.:	A2.40

04 - SKY CLUB 1/16"
1/16" = 1'-0"

SINK COMBS DETHLEFS

Copyright by Sink Combs Dethlefs, P.C. 475 Lincoln Street, Suite 100, Durham, Colorado 80202 303.558.0200, 303.558.0222

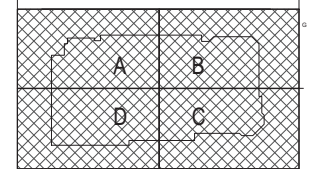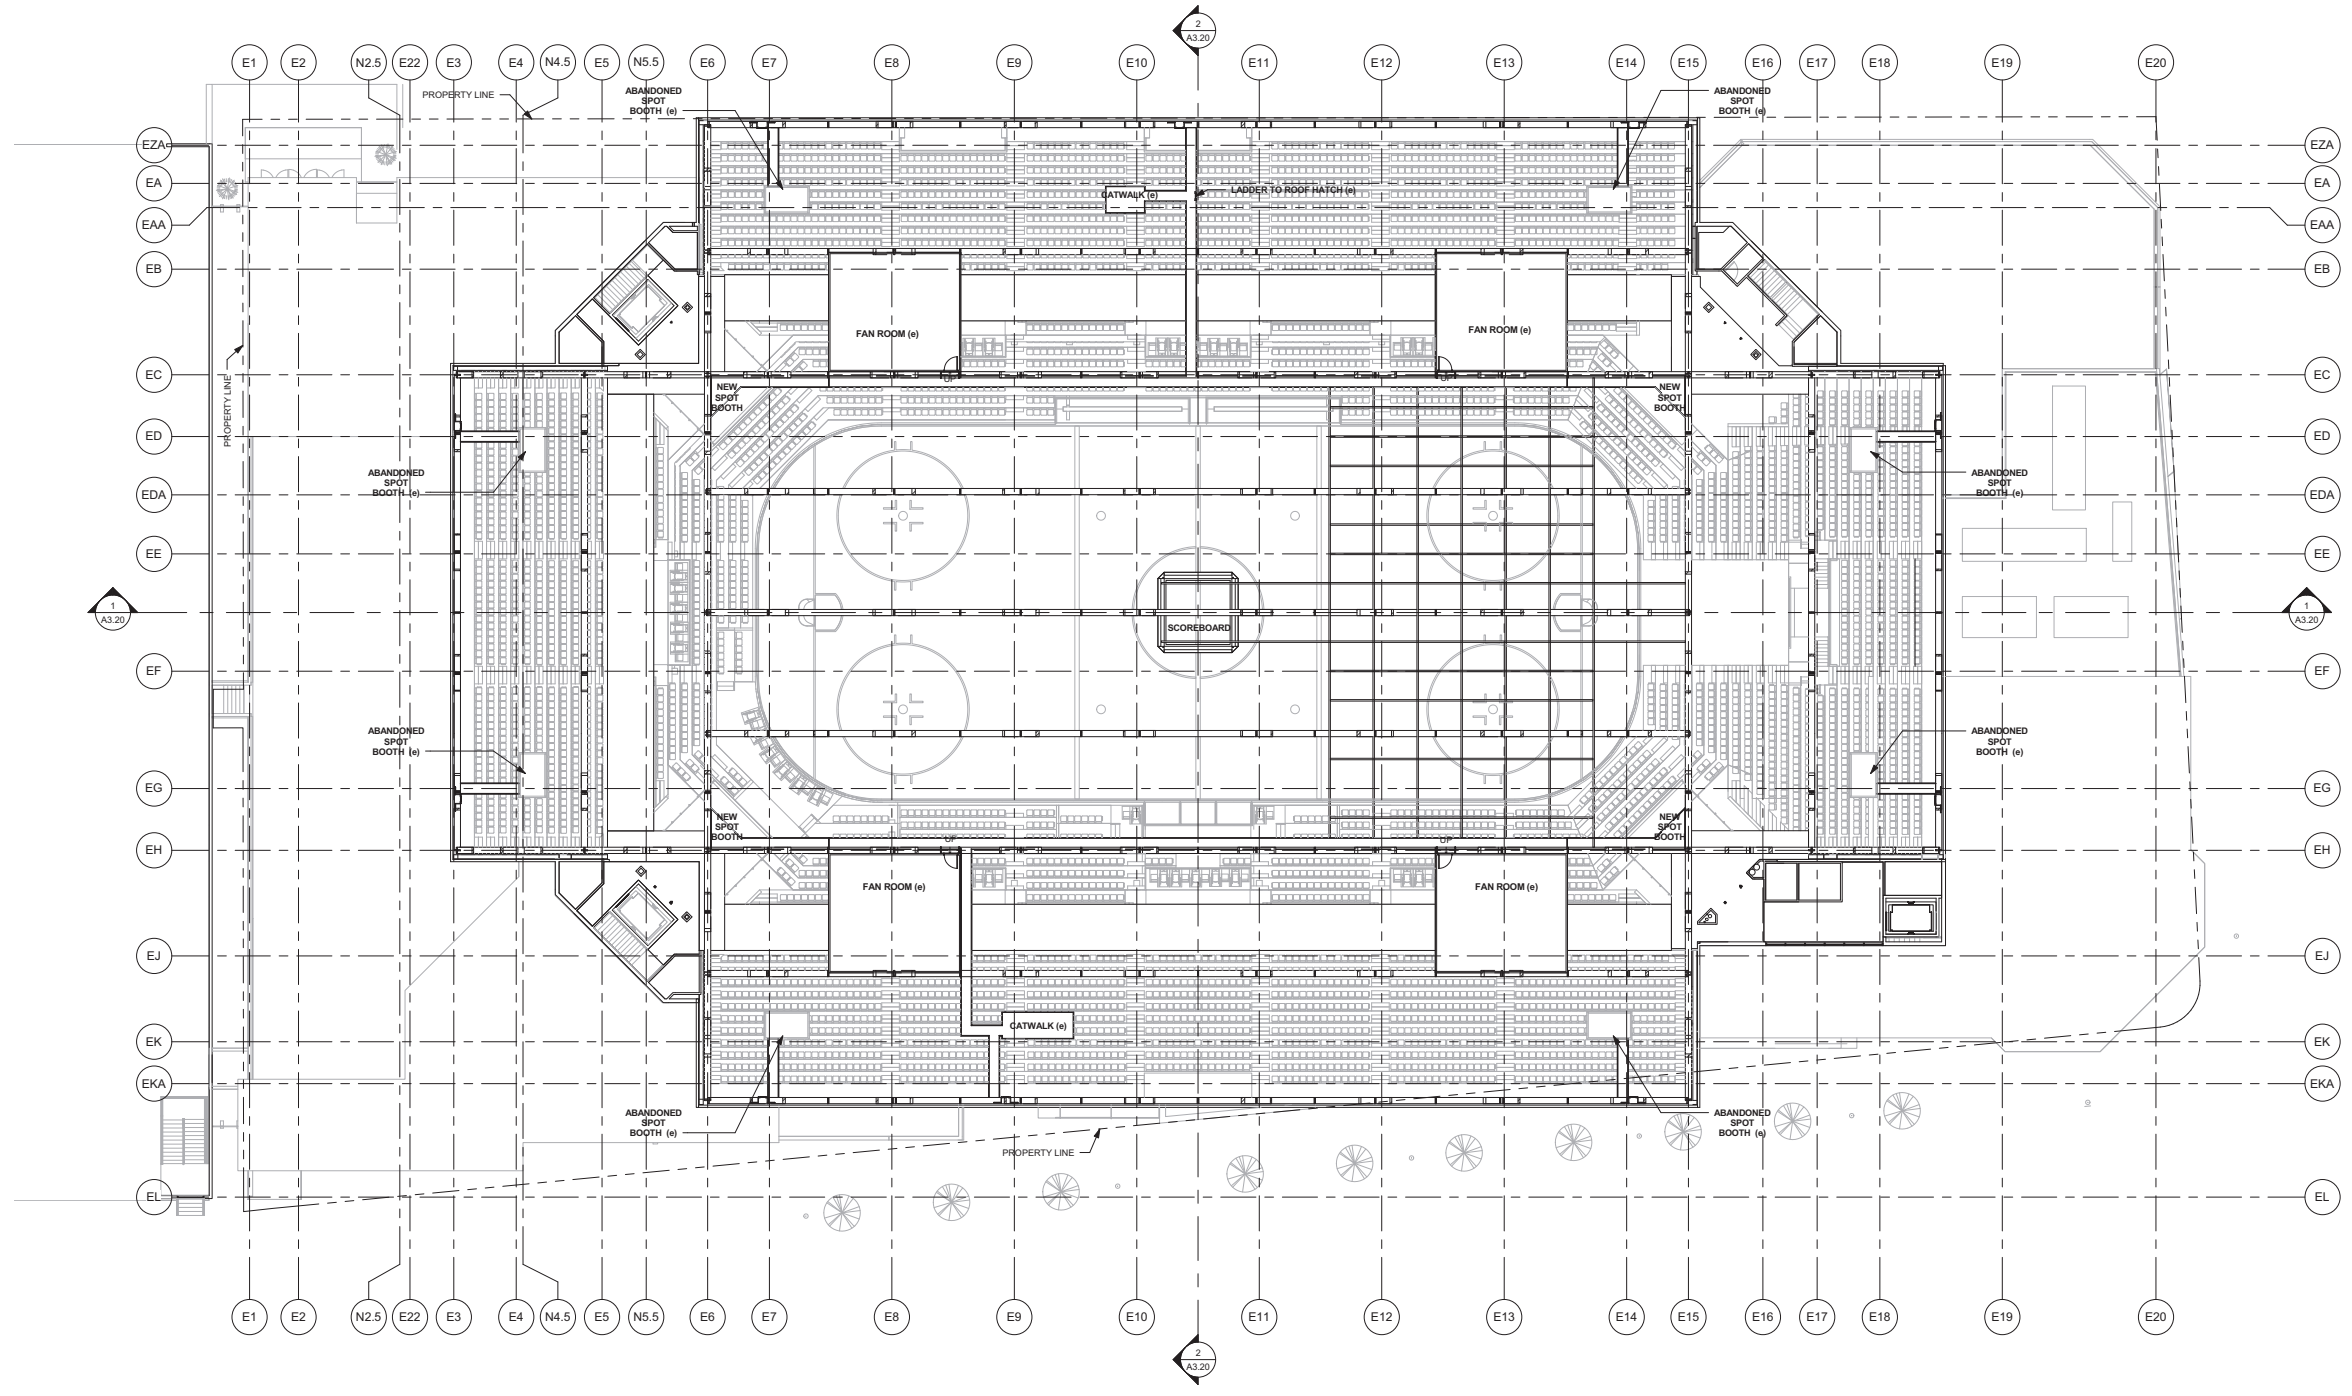

REV.	DESCRIPTION	DATE
0	SD ADDENDUM #3	
	05/17/2012	
	CURRENT ISSUE STATUS: 100% SD	



Cumberland County Civic Center
Portland, ME

CATWALK PLAN

PROJECT No:	01202.00	GRAPHIC SCALE:	0" = 1'
SCALE:	1/16" = 1'-0"	SHEET No.:	A2.50
PROJECT MANAGER:	Approver	DRAWN BY:	Author
CHECKED BY:	Checker		

05 - CATWALK 1/16" = 1'-0"



5/17/2012 10:57:05 PM C:\Users\dominic\Documents\Revit\CCCC_Central_dominic\Recovery.rvt

SINK COMBS DETHLEFS

Copyright by
Sink Combs
Dethlefs, P.C.

475 Lincoln Street
Suite 100
Dorset, Colorado 80201

303.588.0200
FAX 303.5222

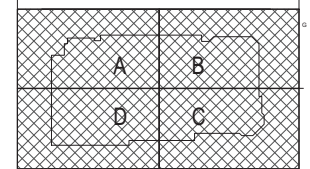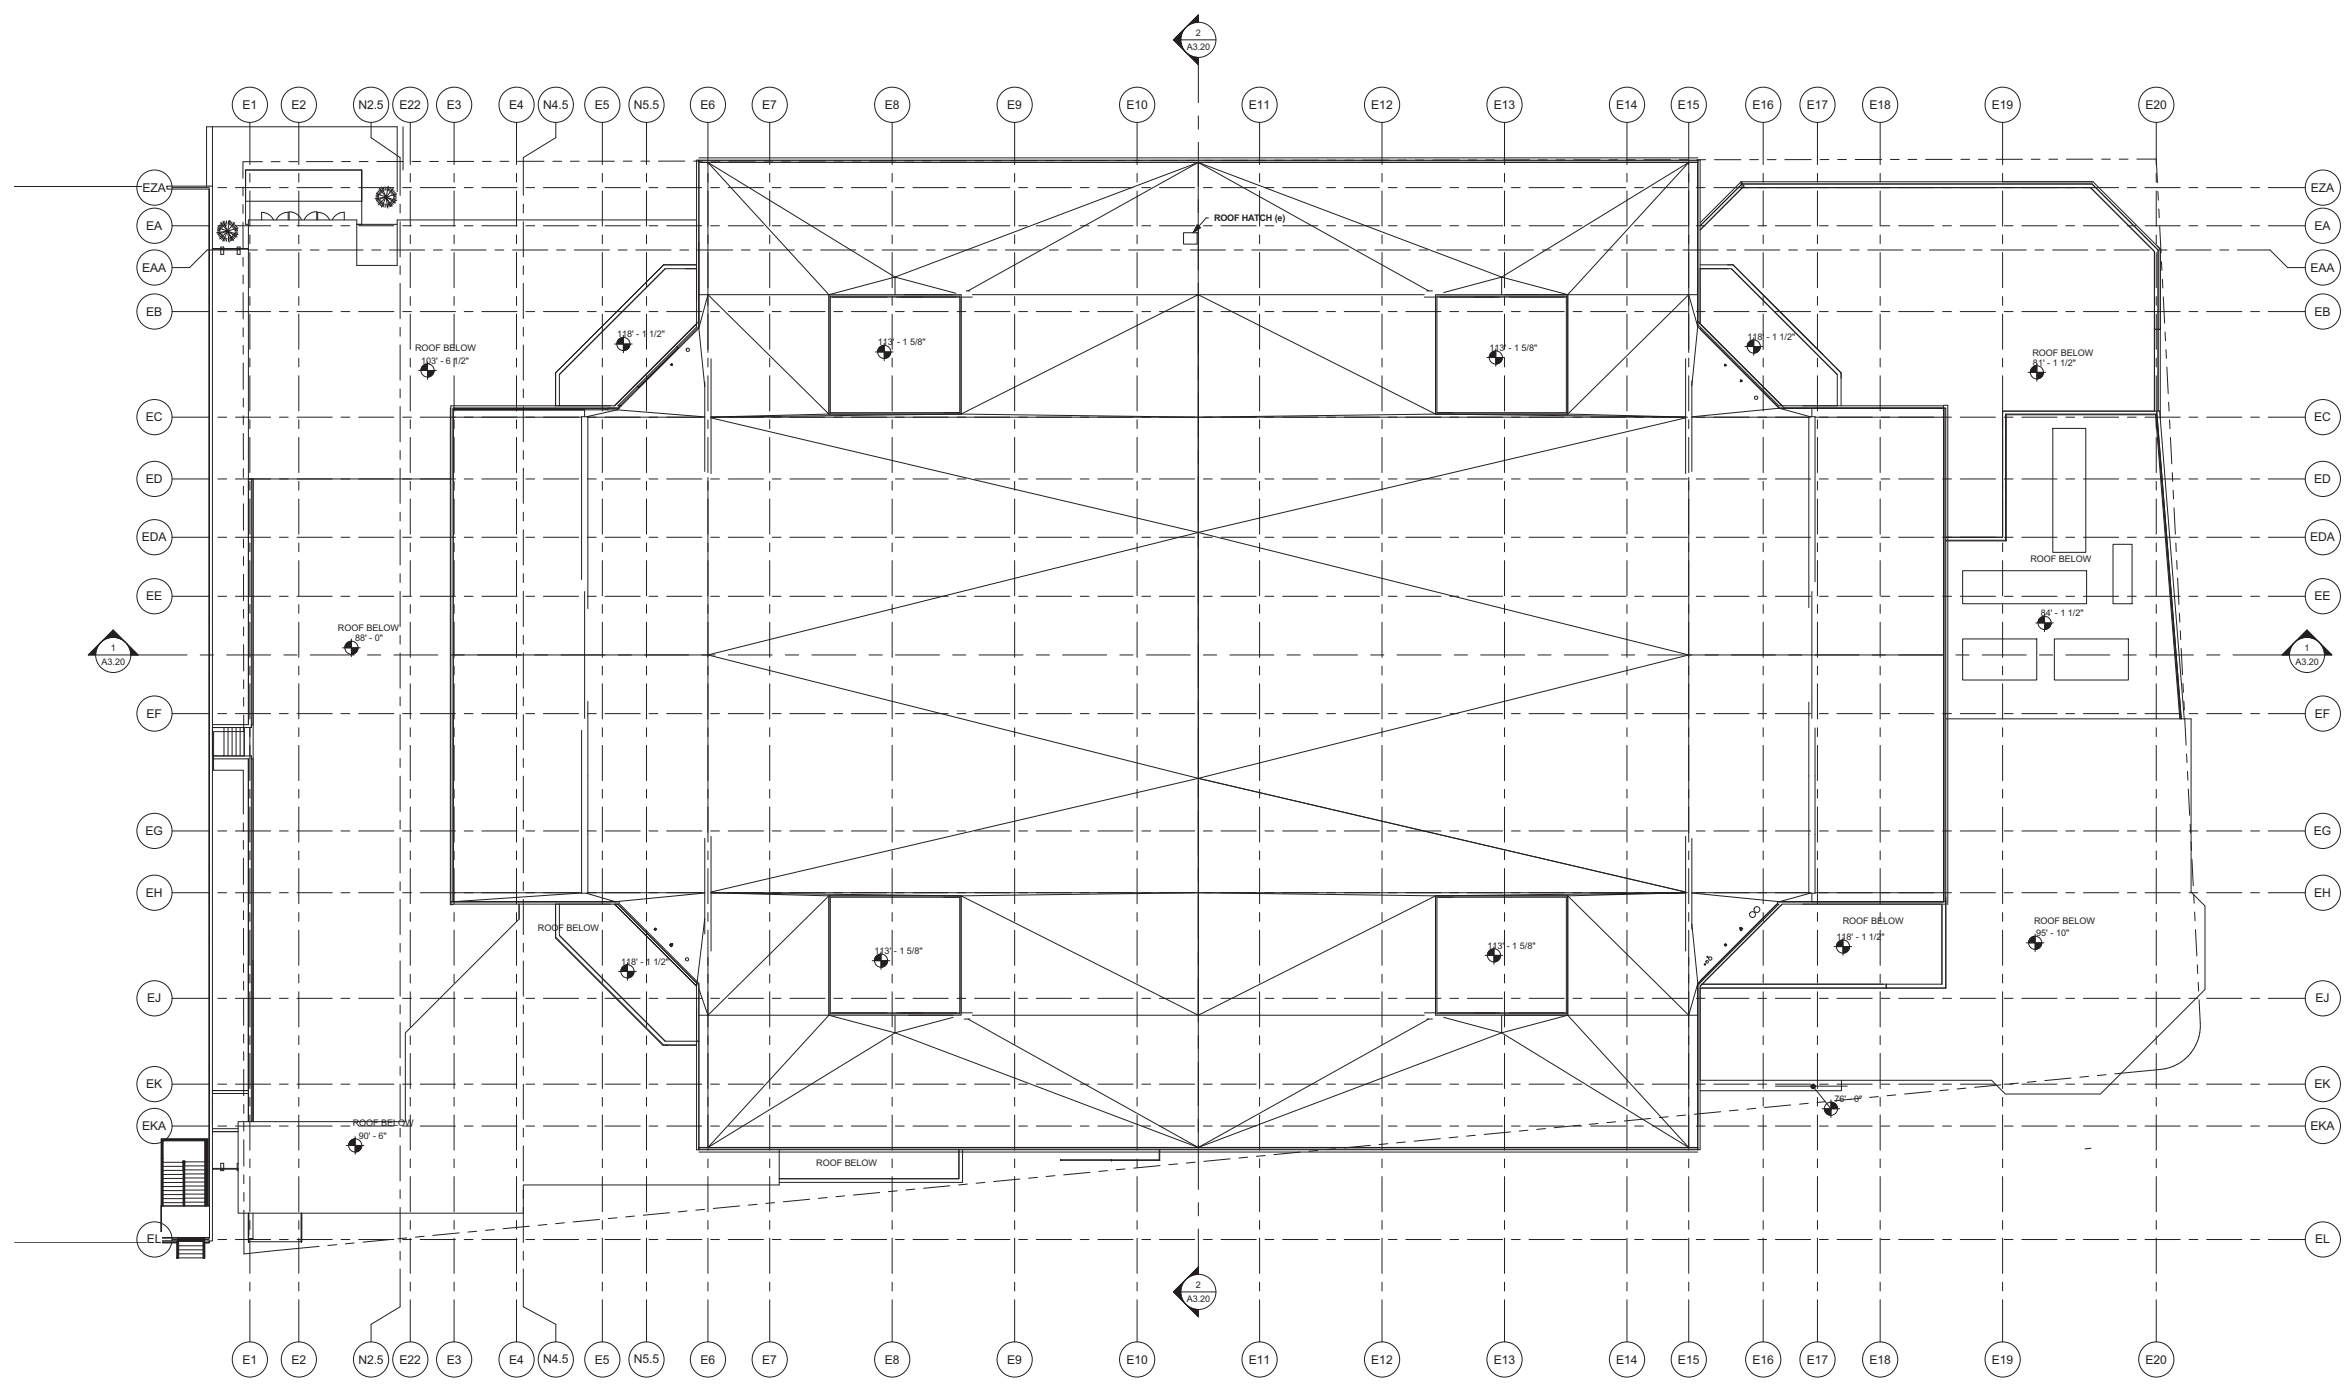

REV.	DESCRIPTION	DATE
0		
SD ADDENDUM #3		
05/17/2012		
CURRENT ISSUE STATUS: 100% SD		



WBRC
ARCHITECTS ENGINEERS

WWW.WBRC.COM
BANGOR, MAINE 207.467.4511
PORTLAND, MAINE 207.423.4511
SARASOTA, FLORIDA 941.554.9707

Cumberland County Civic Center
Portland, ME

ROOF PLAN

PROJECT No:	01202.00	DRAWING SCALE:	1" = 1'-0"
SCALE:	1/16" = 1'-0"	SHEET No.:	A2.60
PROJECT MANAGER:	Approver	DRAWN BY:	Author
CHECKED BY:	Checker		

1 - 06 - ROOF 1/16"
1/16" = 1'-0"

