




4 BUILDING SECTION
 A4 SCALE: 1/4" = 1'-0"

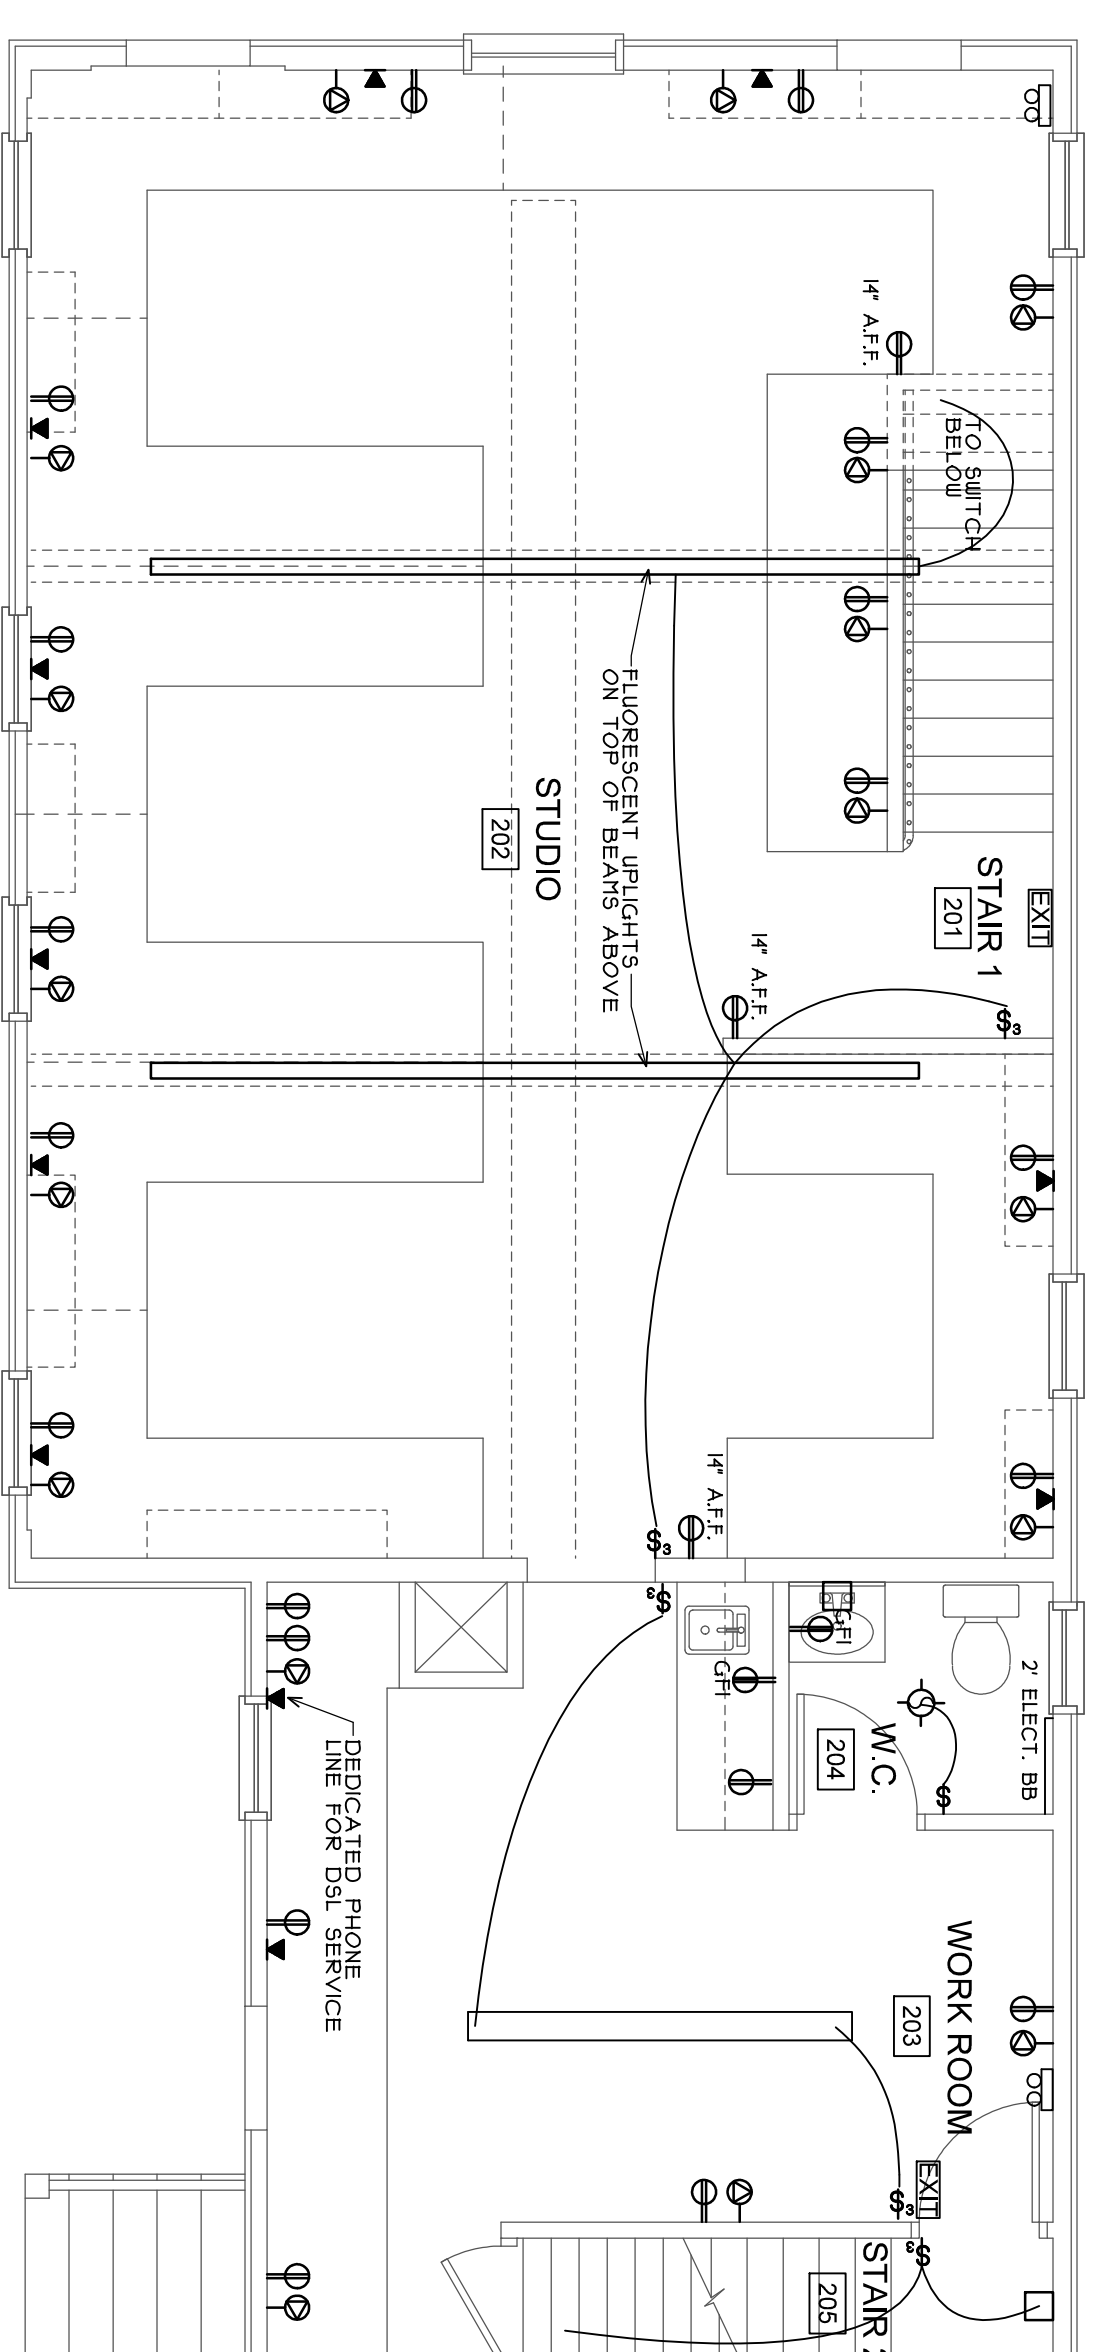

2 SECOND FLOOR ELECTRICAL PLAN
 A4 SCALE: 1/4" = 1'-0"

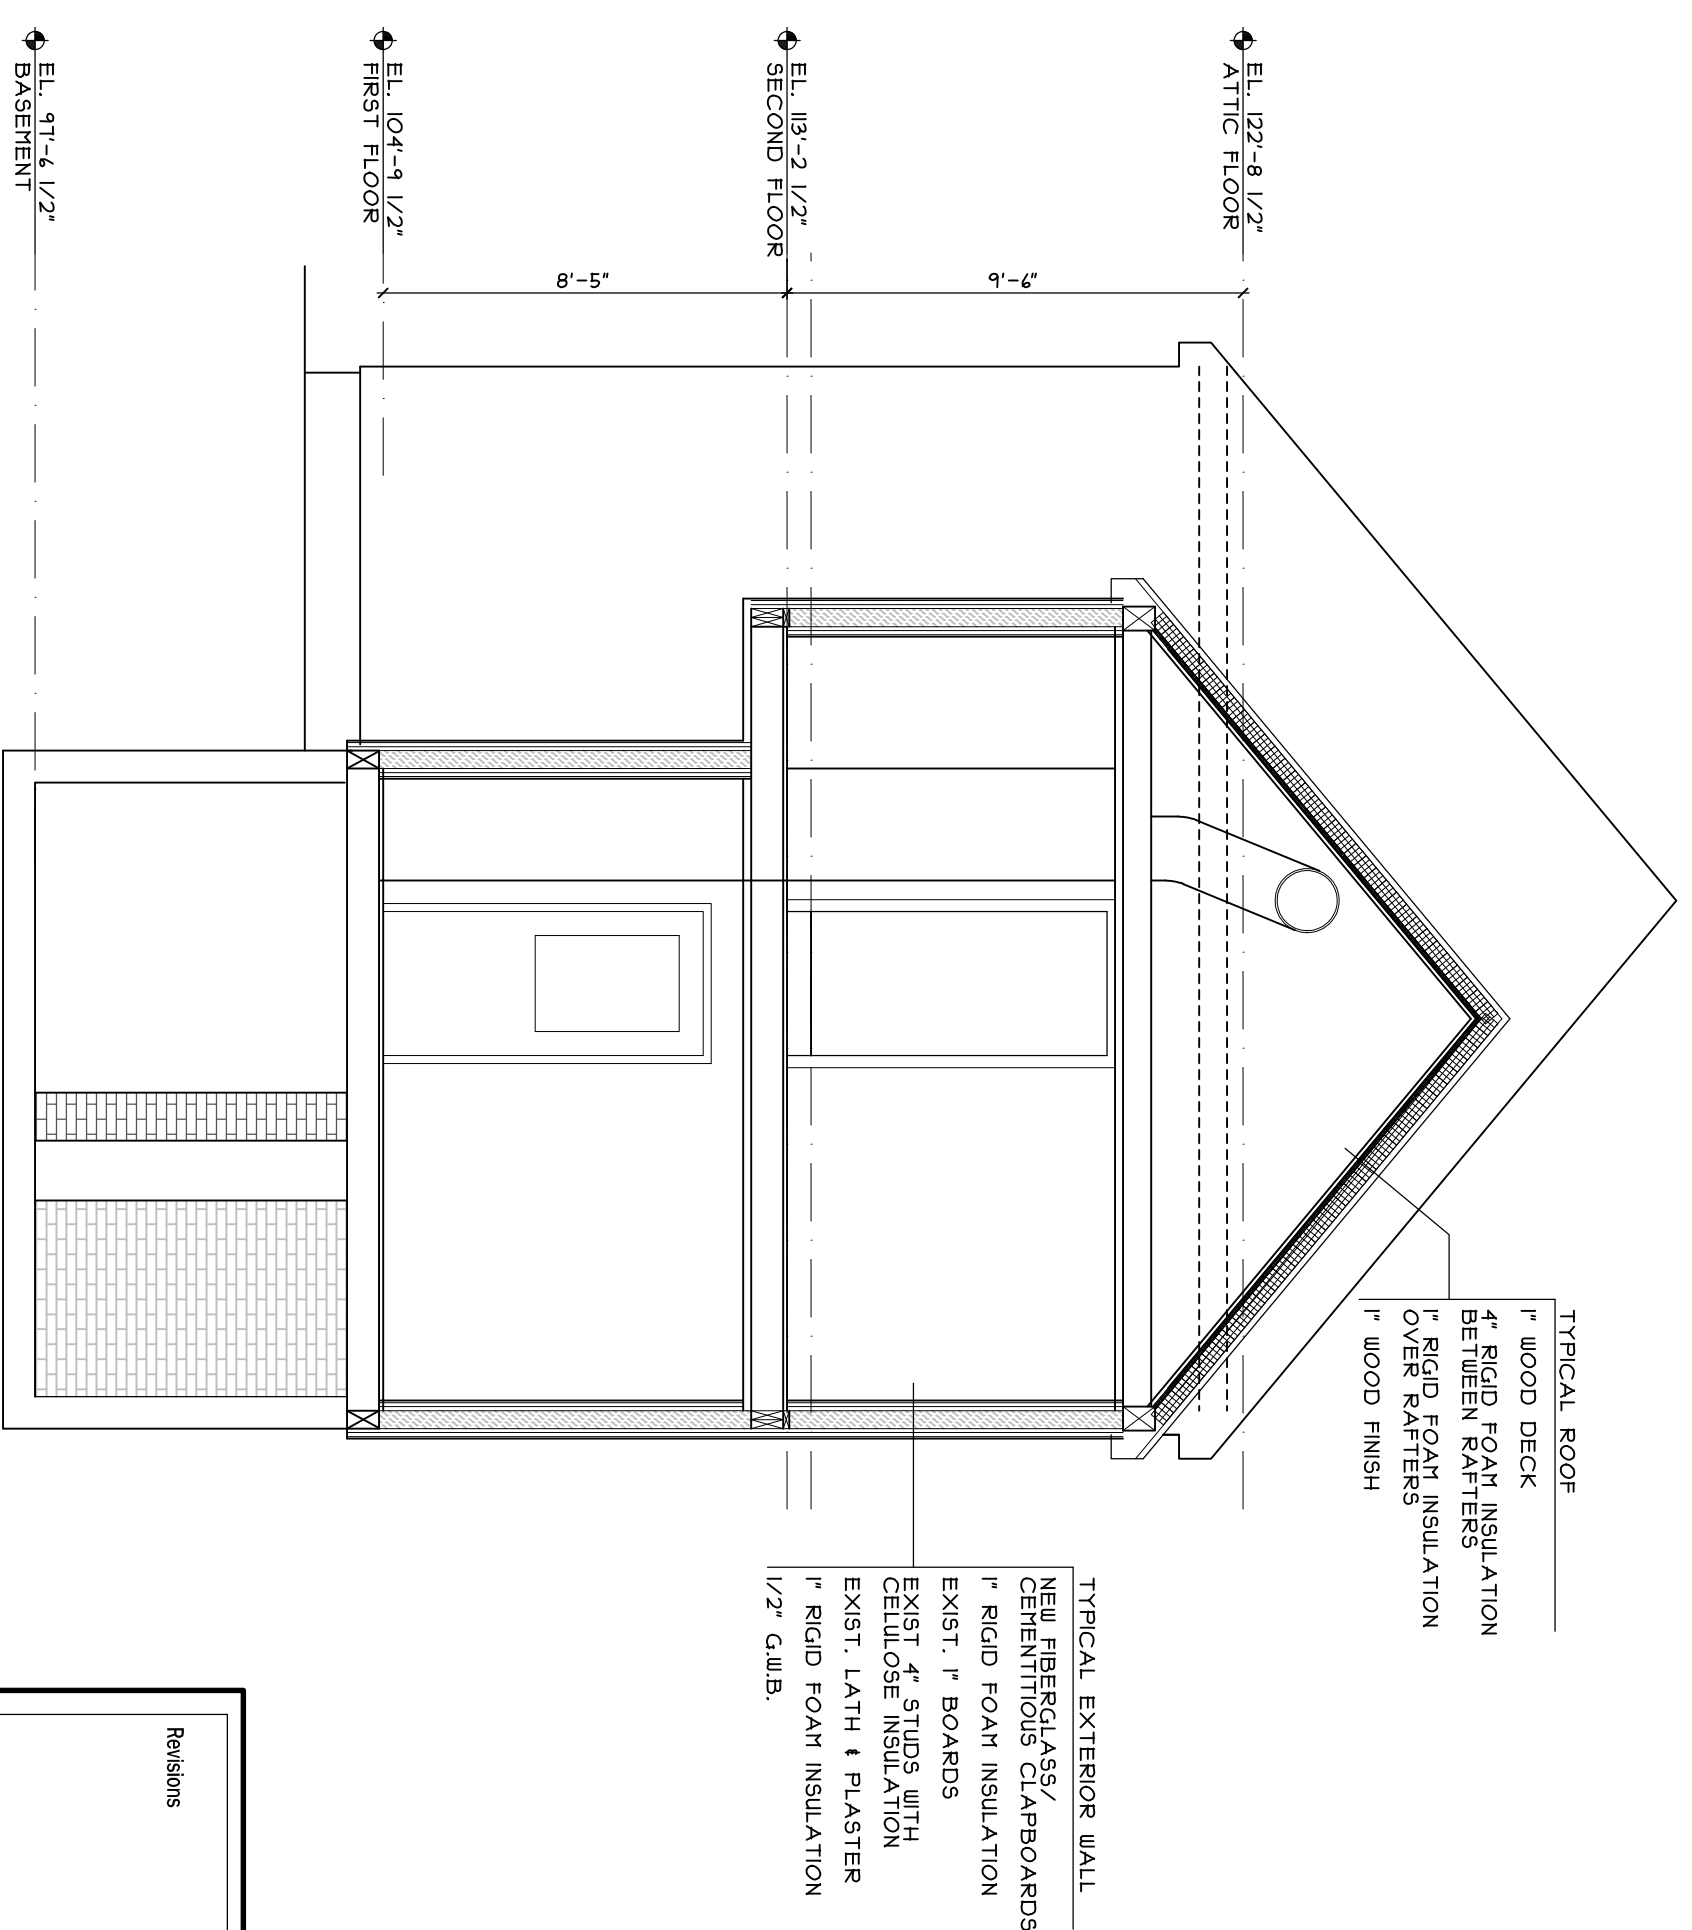

3 BUILDING SECTION
 A4 SCALE: 1/4" = 1'-0"

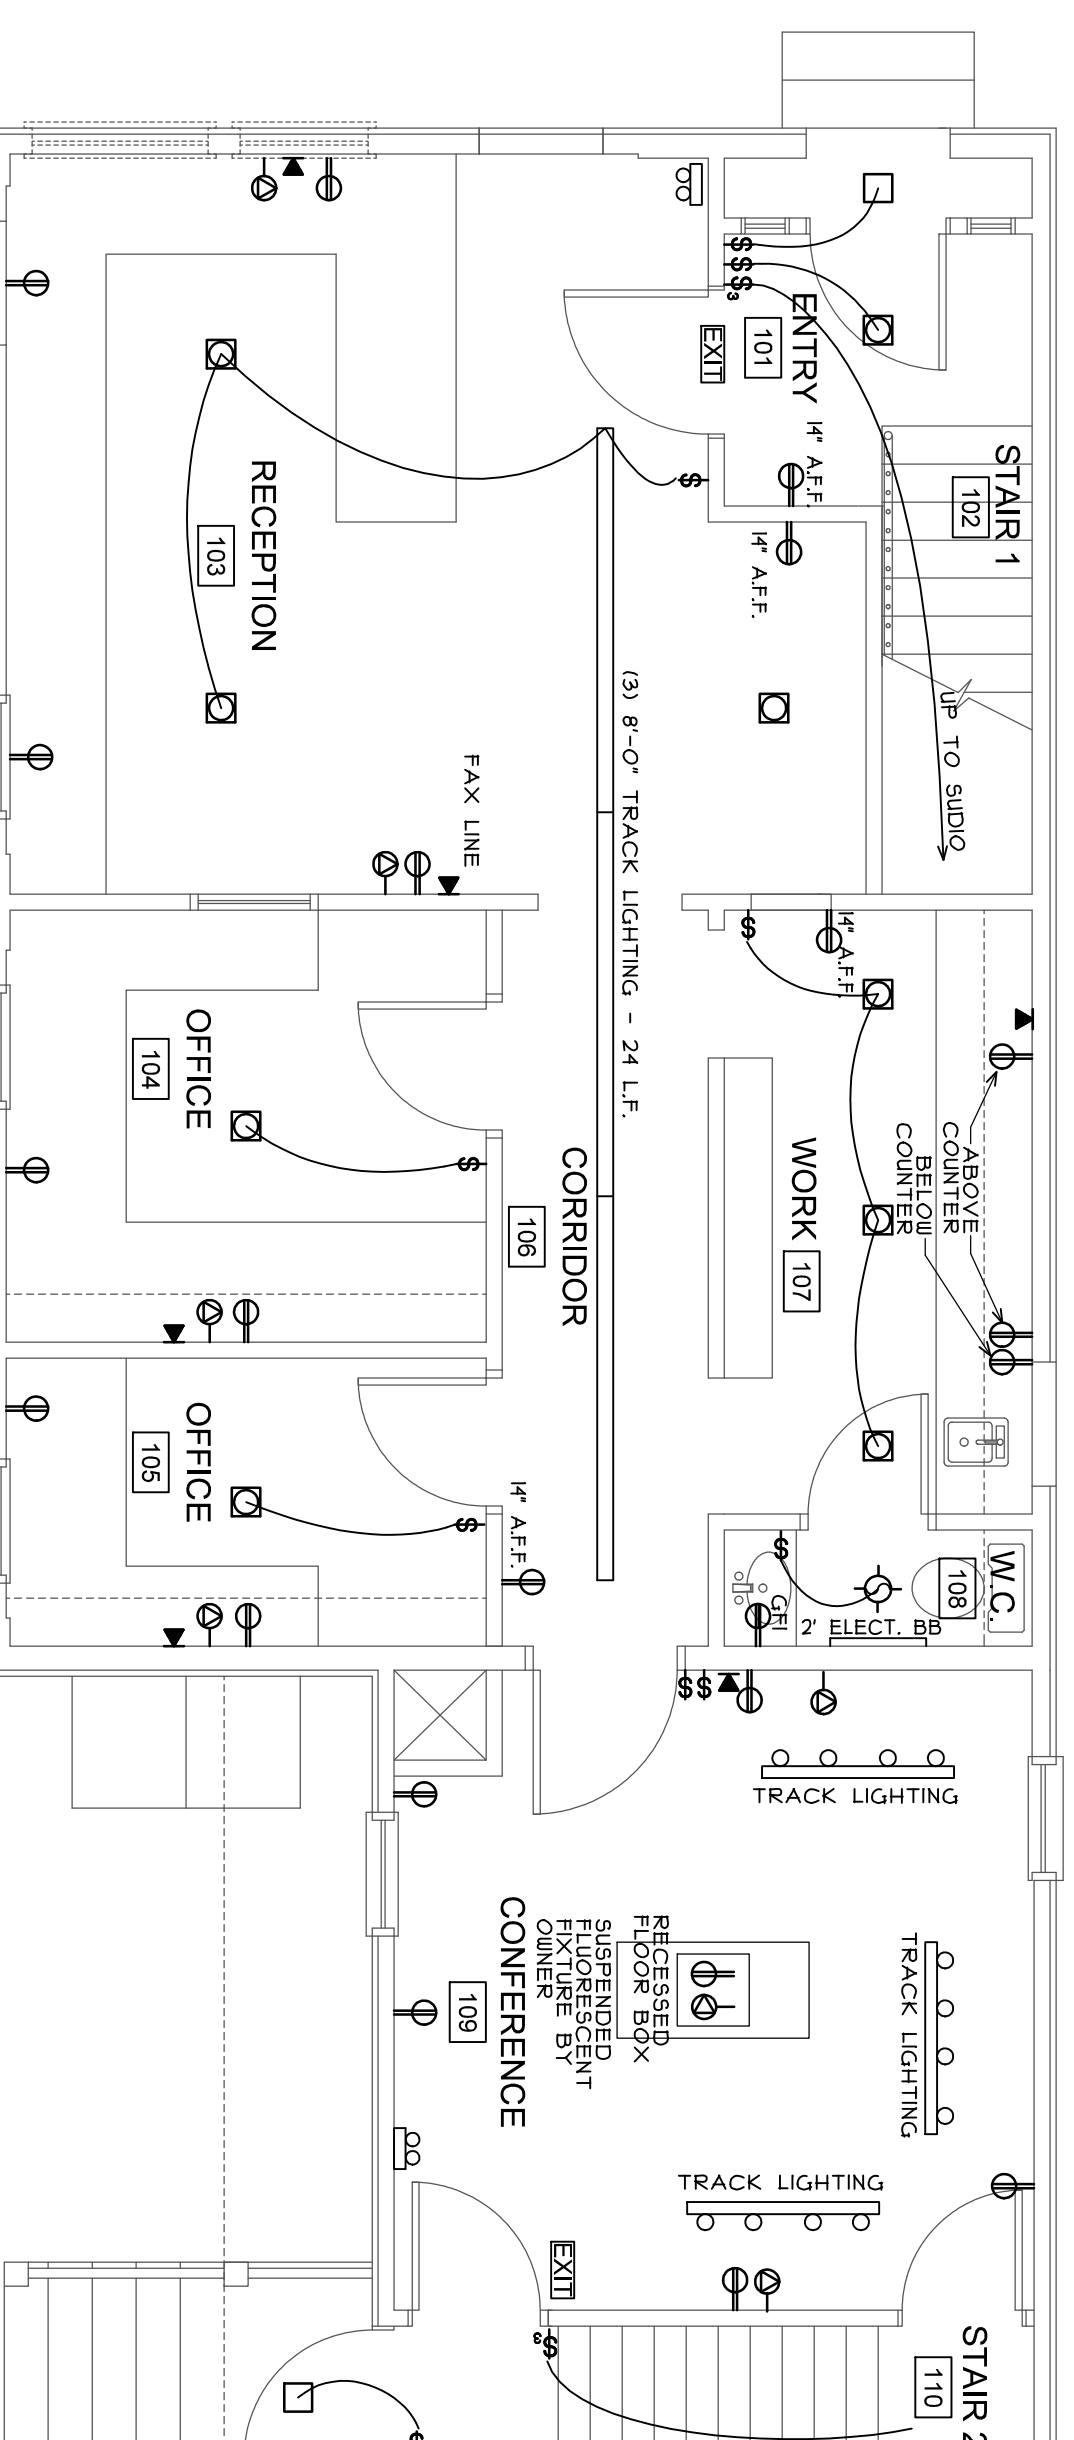

1 GROUND FLOOR ELECTRICAL PLAN
 A4 SCALE: 1/4" = 1'-0"

ELECTRICAL KEY	
	DUPLEX OUTLET
	TELEPHONE
	DATA
	SWITCH
	RECESSED CEILING FIXTURE
	SURFACE MOUNTED EXTERIOR FIXTURE
	COMBINATION FAN/LIGHT
	EXIT SIGN
	EMERGENCY LIGHT

Revisions

Consultants
 Mechanical Engineer
 Whitney Engineering

Stephen Blatt
 Architects

10 Dandens Street
 Post Office Box
 383 935
 Portland, Maine
 207.763.1911
 207.763.2105
 Email: stephen@whitney.com

5 South St.
 Portland, Maine
 Additions & Renovations



Job No.: 0711
 Date: June 26, 2009
 Scale: 1/4" = 1'-0"
 Drawn By: pen
 Checked By: sb
 99

Drawing Title
 Building Sections
 Electrical Plans

A4

Issued for Building Permit