


FLOOR 2

COMMERCIAL STREET

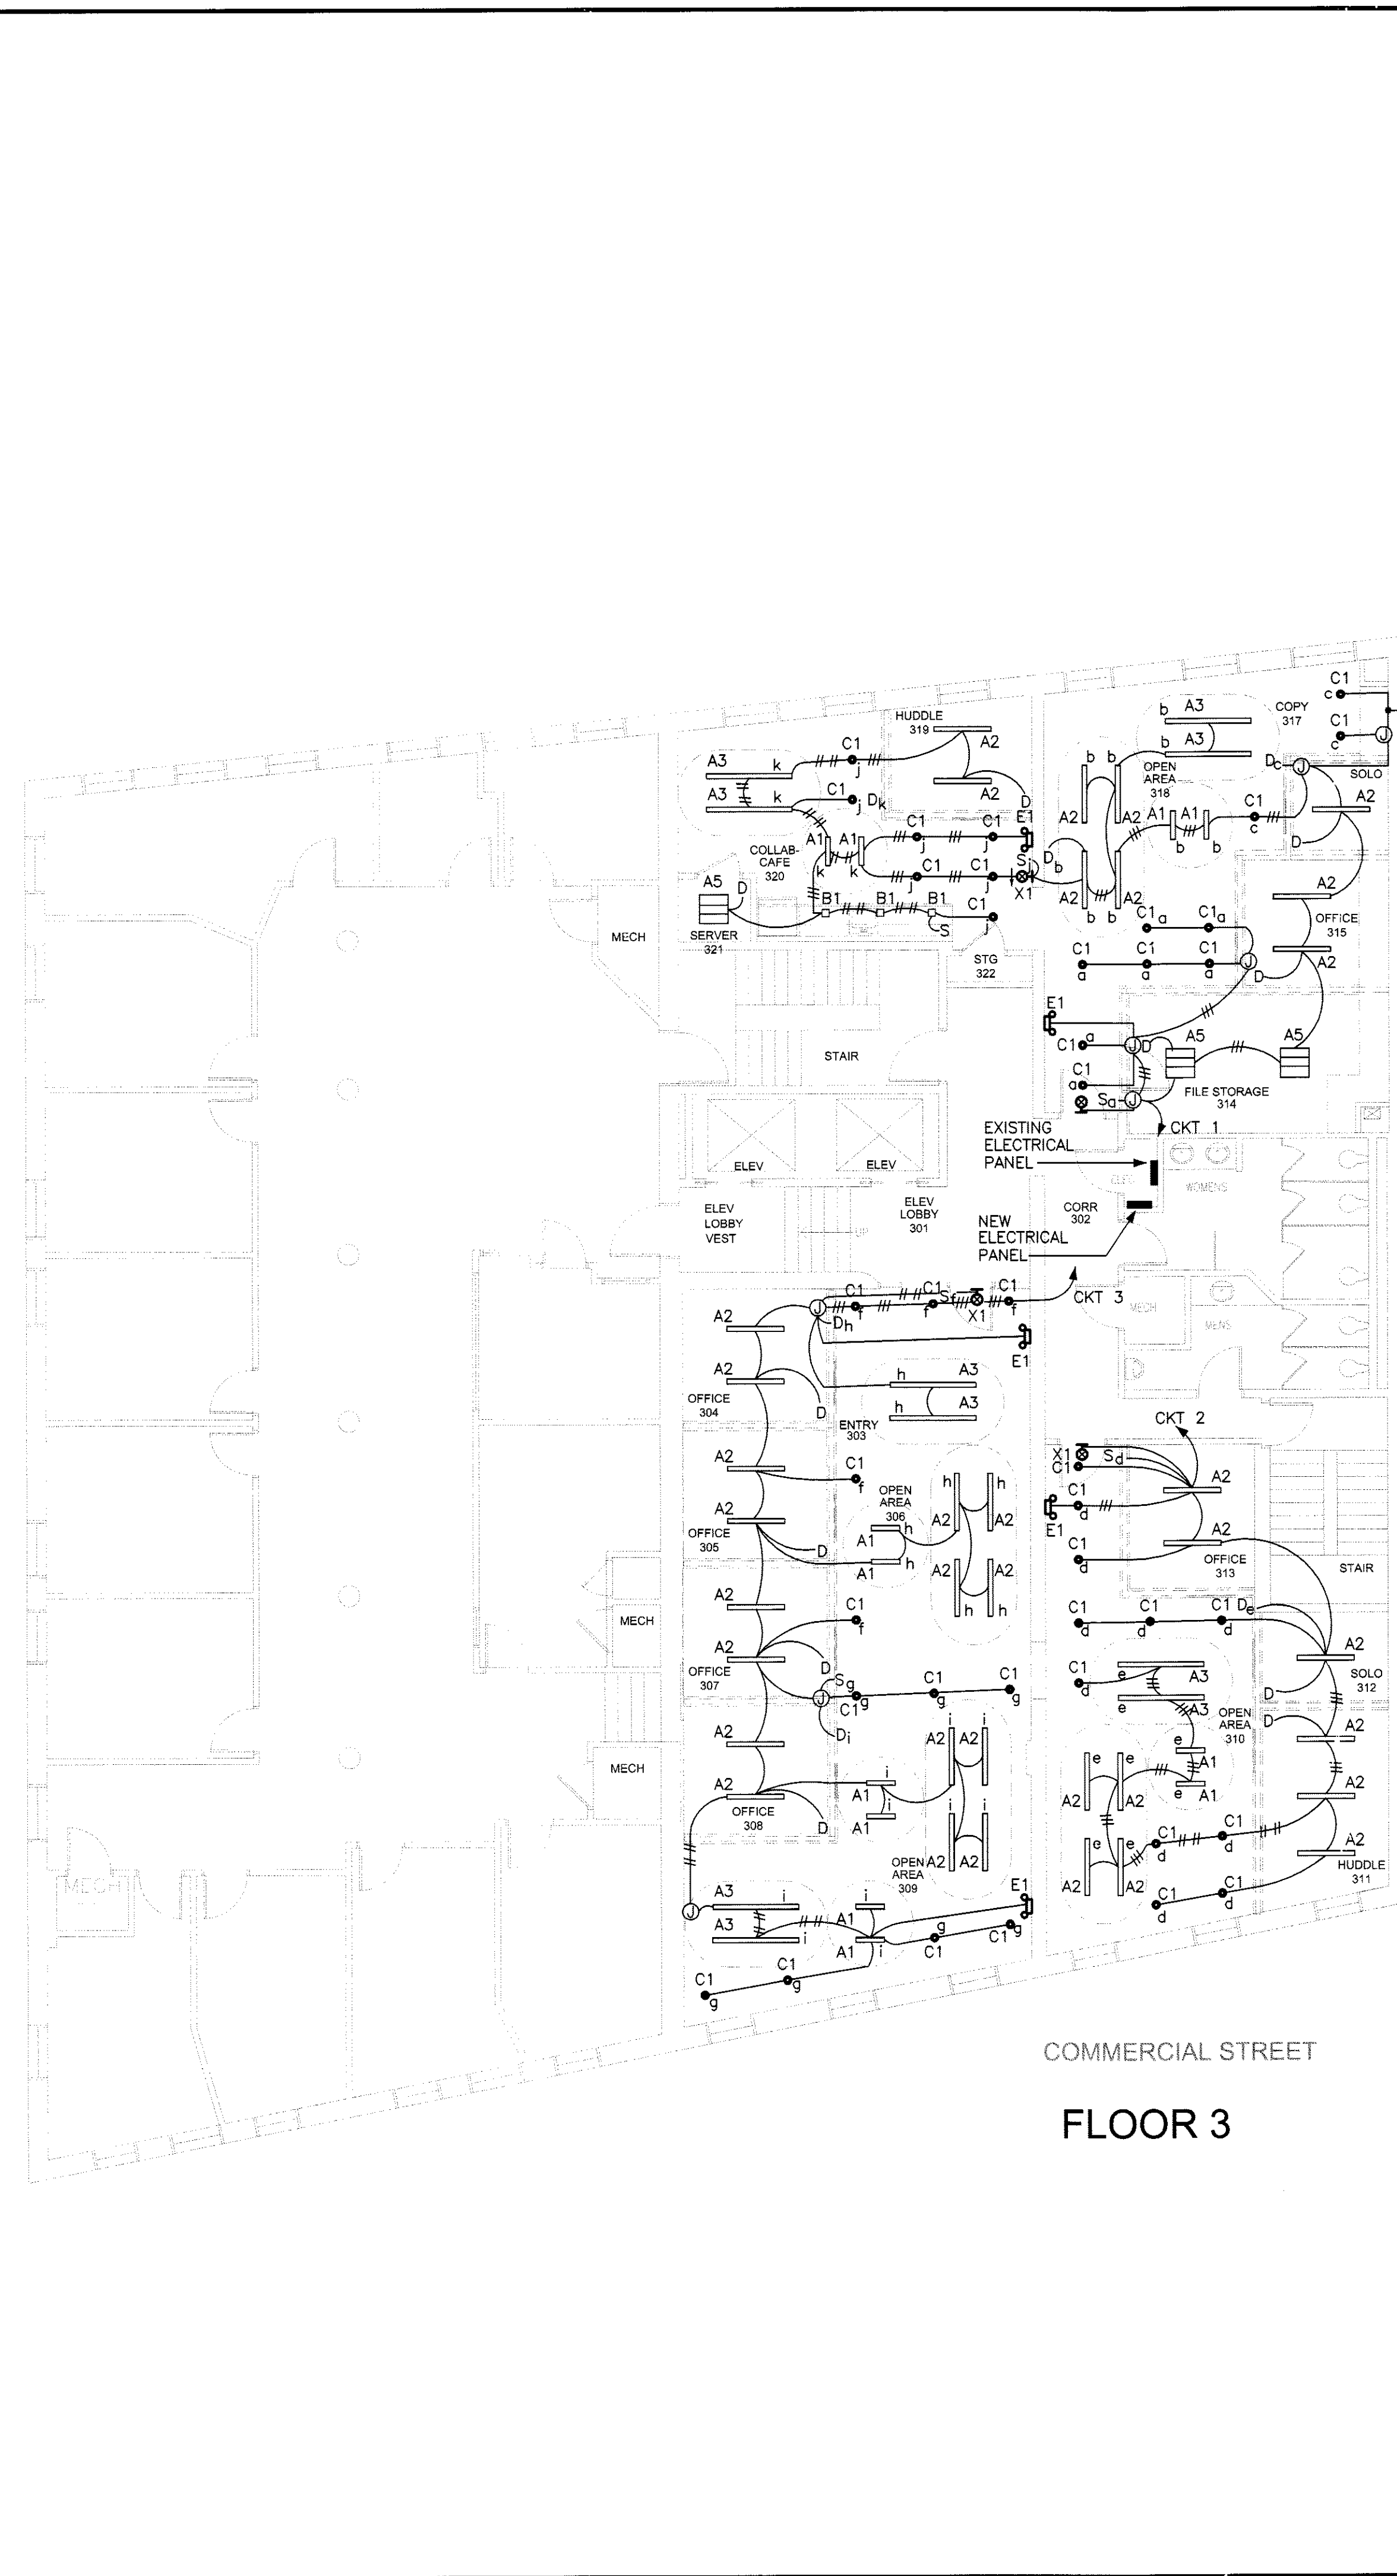


FLOOR 3

COMMERCIAL STREET

- LIGHTING NOTES:**
- COORDINATE THE EXACT LOCATION OF ALL LIGHTING FIXTURES WITH THE ARCHITECTURAL REFLECTED CEILING PLANS.
 - REVIEW ROUTING OF ALL SURFACE WIRING WITH ARCHITECT PRIOR TO ROUGH-IN.
 - COORDINATE THE INSTALLATION OF LIGHTING SWITCHES AND DIMMER CONTROLS TO BE INSTALLED IN NEW PARTITION WALLS WITH PARTITION FABRICATOR.
 - CIRCUIT NUMBERS REFER TO EXISTING ELECTRICAL PANELBOARDS ON THE SECOND AND THIRD FLOORS. CONNECT CIRCUITS TO UNUSED 20A/1P CIRCUIT BREAKERS.

- LIGHTING LEGEND:**
- WIRING TO BE INSTALLED IN SURFACE METAL RACEWAY.
 - WIRING TO BE CONCEALED ABOVE NEW SUSPENDED CEILING OR WITHIN PARTITIONS.
 - RECESSED 2X2 LIGHT FIXTURE.
 - A5 fixture designation
 - c fixture switch/dimmer control designation
 - ⊙ SURFACE CEILING CYLINDER LIGHT FIXTURE.
 - C1 fixture designation
 - a fixture switch/dimmer control designation
 - RECESSED LINEAR LIGHT FIXTURE.
 - A3 fixture designation
 - g fixture switch/dimmer control designation
 - ⊕ SURFACE WALL MOUNTED EMERGENCY LIGHT.
 - E1 fixture designation
 - ⊗ SURFACE WALL MOUNTED EXIT SIGN.
 - X1 fixture designation
 - ⊙ WIRING JUNCTION BOX.

Bartlett Design
 LIGHTING & ELECTRICAL ENGINEERING
 142 WASHINGTON STREET, SUITE 100 BOSTON
 TEL (617) 442-5447 FAX (617) 442-5000

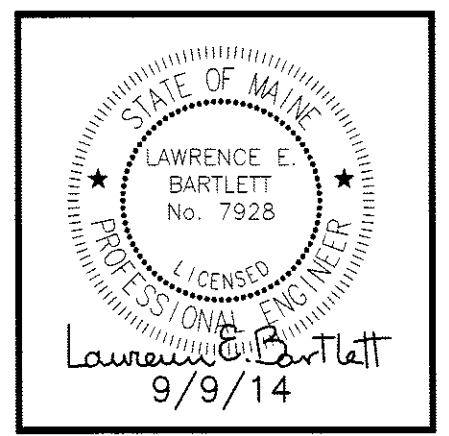

MEMIC
 245 COMMERCIAL STREET
 FLOOR 2 & FLOOR 3
 PORTLAND, ME 04101

REVISION NO.	DATE

LIGHTING PLANS

TITLE

SCALE: 1/8"=1'-0"

DATE: 9.8.2012

DRWN: JC

CHK: LEB

DRAWING NO.

E-2