



SECOND FLOOR HVAC PLAN  
SCALE: 1/8" = 1'-0"

HEAT PUMP SYSTEM									
TAG	MFG	MODEL	TONS	HEATING BTU/H	COOLING BTU/H	V/Hz/PH	MAX FUSE	MCA	NOTES
2-A	DAIKIN	REYQ72TATJU	16	216,000	192,000	208-230/60/3	35	30.2	SERVES 2-1 THROUGH 2-6
2-B	DAIKIN	REYQ120TATJU				208-230/60/3	50	43.0	
2-1	DAIKIN	FXMQ48PBVJU	4	54,000	48,000	208-230/60/1	15	3.4	
2-2	DAIKIN	FXMQ48PBVJU	4	54,000	48,000	208-230/60/1	15	3.4	
2-3	DAIKIN	FXMQ48PBVJU	4	54,000	48,000	208-230/60/1	15	3.4	
2-4	DAIKIN	FXMQ24PBVJU	2	27,000	24,000	208-230/60/1	15	1.4	
2-5	DAIKIN	FXMQ24PBVJU	2	27,000	24,000	208-230/60/1	15	1.4	
2-6	DAIKIN	FXMQ24PBVJU	2	27,000	24,000	208-230/60/1	15	1.4	
BS-1	DAIKIN	B56Q54TVJ	-	-	-	208-230/60/1	15	0.6	SERVES 2-1 THROUGH 2-6

ENERGY RECOVERY VENTILATORS							
TAG	MFG	MODEL #	V/Hz/PH	MCA	MAX FUSE	CFM @ IN WG	NOTES
ERV-2A	RENEW AIRE	HE1XNH	208-230/60/1	10.1	15.0	860 @ 0.5	SERVES HP 2-1 THROUGH HP 2-6

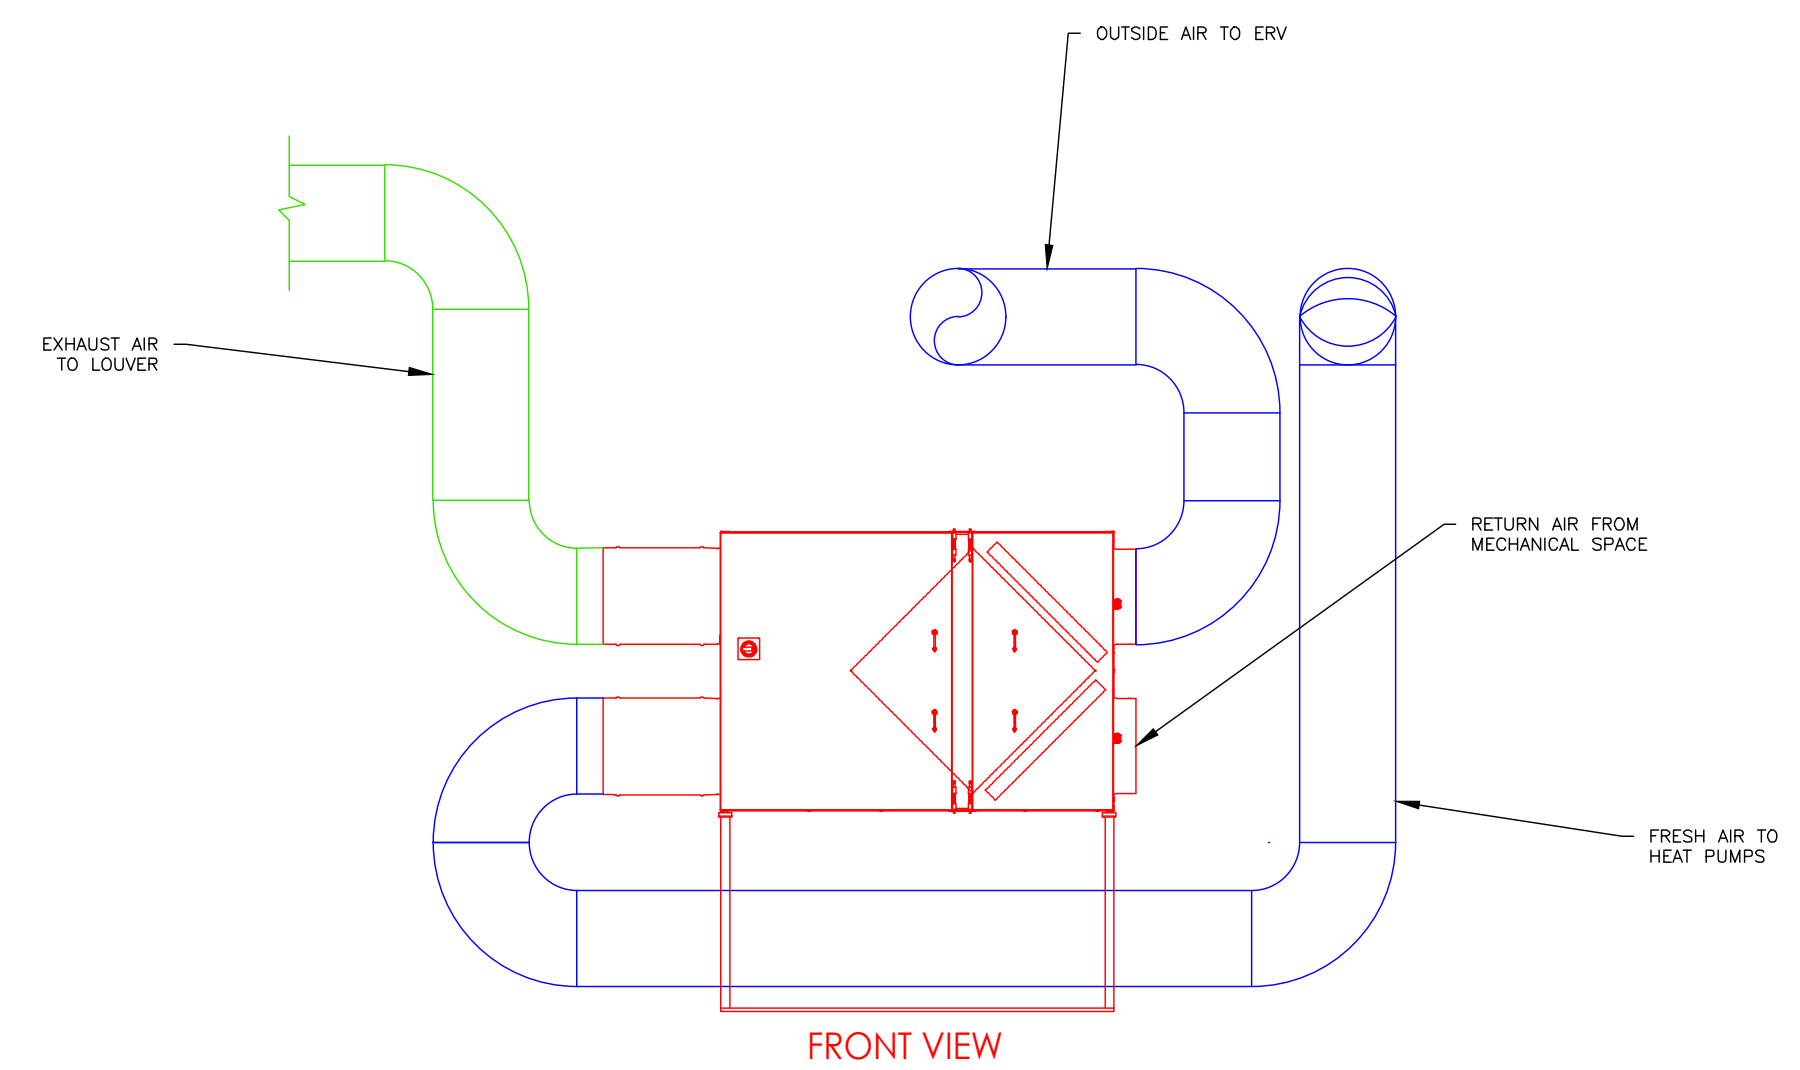

ERV DETAIL FRONT VIEW  
SCALE: NOT TO SCALE

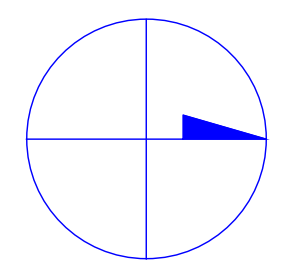

PLAN NORTH

Design • Build • Install • Service

**HVAC SERVICES, INC.**

73 BRADLEY DRIVE  
WESTBROOK, MAINE 04092  
(207) 854-HVAC (4822)

REVISIONS		MEMIC	
NO.	NOTES	PROJECT:	245 COMMERCIAL ST. PORTLAND, MAINE
		SECOND FLOOR HVAC	
		SHEET TITLE:	
		SCALE: SEE CAPTIONS	DATE: 2-6-2018
		DRAWN BY: TJF	SHEET No.
		CHECKED BY:	M-1
		PRINT TO SCALE: 36x24	