


1 Second Floor Reflected Ceiling Plan
 Scale: 1/4" = 1'-0"
 NOTE: Third Floor Similar

LIGHTING LEGEND								
TAG	PRODUCT	MANUFACTURER	ITEM NUMBER	DESCRIPTION	COLOR / FINISH	WATTAGE	SIZE	NOTES
L-1	RECESSED DOWNLIGHT				WHITE TRIM			
L-2	WALL WASHER				WHITE TRIM			
L-3	WALL WASHER				WHITE TRIM			
L-4	VANITY PINLIGHT							LOCATED WITHIN BAR MILLWORK
L-5	RECESSED DOWNLIGHT, WOOD CEILING							
L-6	RECESSED DOWNLIGHT, WOOD CEILING							
L-7	RECESSED DOWNLIGHT							
L-8	SHOWER LIGHT							
L-9	RECESSED DOWNLIGHT, WOOD CEILING							
L-10	PINLIGHT							
L-11	RECESSED DOWNLIGHT							
L-12	WALL WASHER							

DECORATIVE LIGHTING LEGEND								
TAG	PRODUCT	MANUFACTURER	ITEM NUMBER	DESCRIPTION	COLOR / FINISH	WATTAGE	SIZE	NOTES
DLT1	PENDANT							
DLT2	WALL SCONCE							
DLT3	(NOT USED)							
DLT4	WALL SCONCE							
DLT5	WALL SCONCE							
DLT6	PENDANT							
DLT7	FLUSH MOUNT							
DLT8	FLUSH MOUNT							
DLT9	FLUSH MOUNT							
DLT10	WALL SCONCE							
DLT11	WALL SCONCE							
DLT12	ART LIGHT							
DLT13	VESTIBULE PENDANT							
DLT14	DINING PENDANT							
DLT15	BEDSIDE WALL SCONCE							
DLT16	VANITY WALL SCONCE							
DLT20	TABLE LAMP							
DLT21	TABLE LAMP							
DLT22	TABLE LAMP							
DLT23	TABLE LAMP							
DLT24	TABLE LAMP							

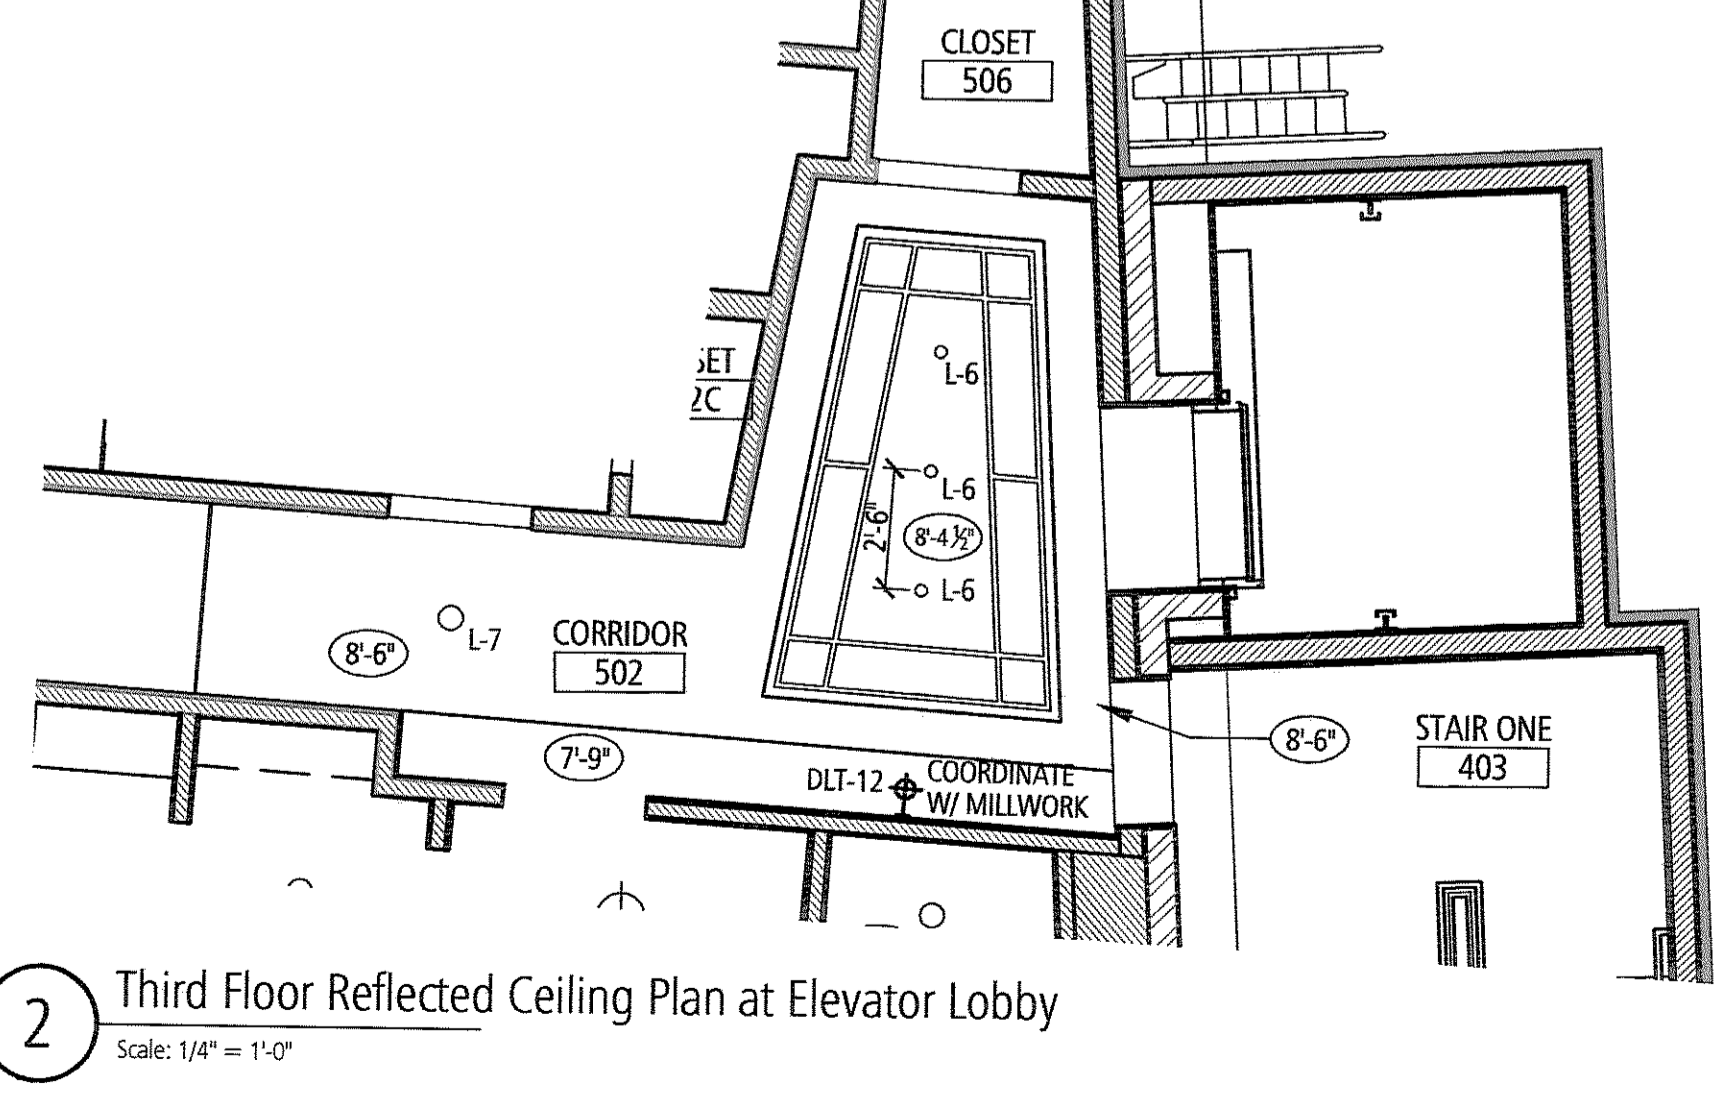

2 Third Floor Reflected Ceiling Plan at Elevator Lobby
 Scale: 1/4" = 1'-0"

truexcellins
 INTERIORS
 209 BATTERY STREET BURLINGTON, VERMONT 05401 USA
 Phone 802.658.2775 800.227.1076
 ARCHITECTURE | INTERIOR DESIGN | TRUEXCELLINS.COM

Drawing Submission
 Description: 95% CD SET
 Date: 05 Feb, 2008

Portland Harbor Hotel
Renovation & Addition, Phase II
 Reflected Ceiling Plans and Lighting Legend
 Project number: 1730.00
 Date: 05 February, 2008
 Drawn by: MB
 Checked by: -
 Project Phase: -
I105
 Scale: 1/4" = 1'-0"

