
 

 
 
 
 
 
 
 
 
 

 
 
 
 
 

 
 
 
 




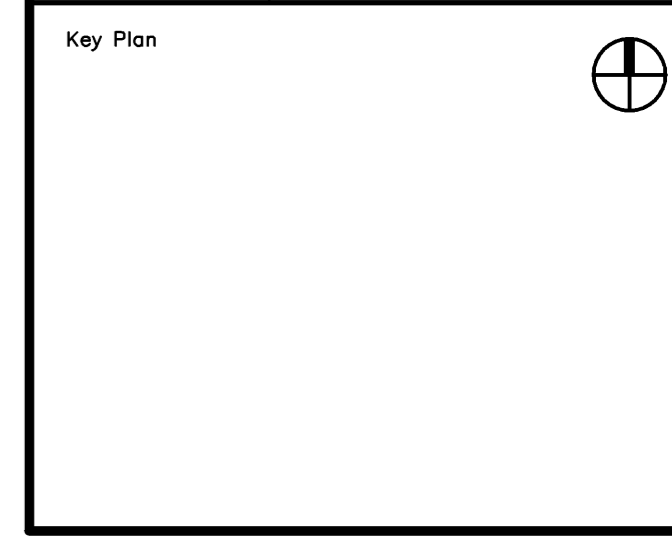



Project Title
**MEMIC
 COMPUTER ROOM
 RELOCATION**
 PORTLAND, MAINE

HA Project No. **04150**

 


 
LEGEND

-  EXISTING PIPING TO BE REMOVED
-  EXISTING PIPING TO REMAIN UNDER SLAB ON GRADE
-  EXISTING PIPING TO REMAIN
-  SANITARY PIPING BELOW GROUND
-  SANITARY PIPING ABOVE GROUND
-  VENT PIPING BELOW GROUND
-  VENT PIPING ABOVE GROUND
-  COLD WATER PIPING BELOW GROUND
-  COLD WATER PIPING ABOVE GROUND
-  HOT WATER PIPING ABOVE GROUND
-  HOT WATER RETURN PIPING
-  SHUT-OFF VALVE
-  FLOOR DRAIN
-  FLOOR CLEANOUT
-  WALL CLEANOUT
-  CLEANOUT
-  WATER CLOSET (REFER TO INSTALLATION DATA SCHEDULE)
-  LAVATORY (REFER TO INSTALLATION DATA SCHEDULE)
-  STAINLESS STEEL SINK (REFER TO INSTALLATION DATA SCHEDULE)
-  MOP RECEPTOR
-  SHOCK ARRESTOR OF P.D.I. RATING
-  VENT PIPING
-  VENT THROUGH ROOF
-  WASTE PIPING
-  ABOVE CEILING BELOW
-  CONNECT NEW TO EXISTING
-  CONNECT NEW TO EXISTING

LEGEND		REF: NA	B1
1/8" = 1'-0"			

1. PERFORM WORK IN PHASES AS DESCRIBED IN SECTION 01010 - SUMMARY OF WORK.
2. COORDINATE WORK WITH THE WORK OF ALL OTHER TRADES.
3. ALL VALVES SHALL BE LOCATED WITHIN 18" OF THE CEILING PLANE WHERE CEILINGS OCCUR.
5. ALL SPRINKLER PIPING SHALL BE RUN LEVEL WITH LOW POINT DRAIN VALVES FOR ANY TRAPPED PIPE SECTIONS.
6. ALL PIPING SHALL BE CONCEALED EXCEPT IN SPACES WHERE NO CEILINGS OCCUR.
7. PROVIDE SPRINKLER PROTECTION BELOW ANY OBSTRUCTION 48" OR WIDER, FOR EXAMPLE DUCTS AND SHELVING.
8. ENTIRE BUILDING SHALL BE SPRINKLERED IN ACCORDANCE WITH NFPA 13 THE STATE FIRE MARSHALL'S OFFICE AND THE PORTLAND FIRE DEPARTMENT.

GENERAL NOTES		REF: NA	A1
1/8" = 1'-0"			



Mark	Date	Description
–	11-03-04	ISSUED FOR CONSTRUCTION
–	10-18-04	90% REVIEW
–	10-01-04	DD REVIEW
Issue Dates		

Drawing Status

Drawing Title
**LEGEND
 GENERAL NOTES**

PA / PE: **ROM** Drawn By: **ROM**

Drawing Number
P00.1