
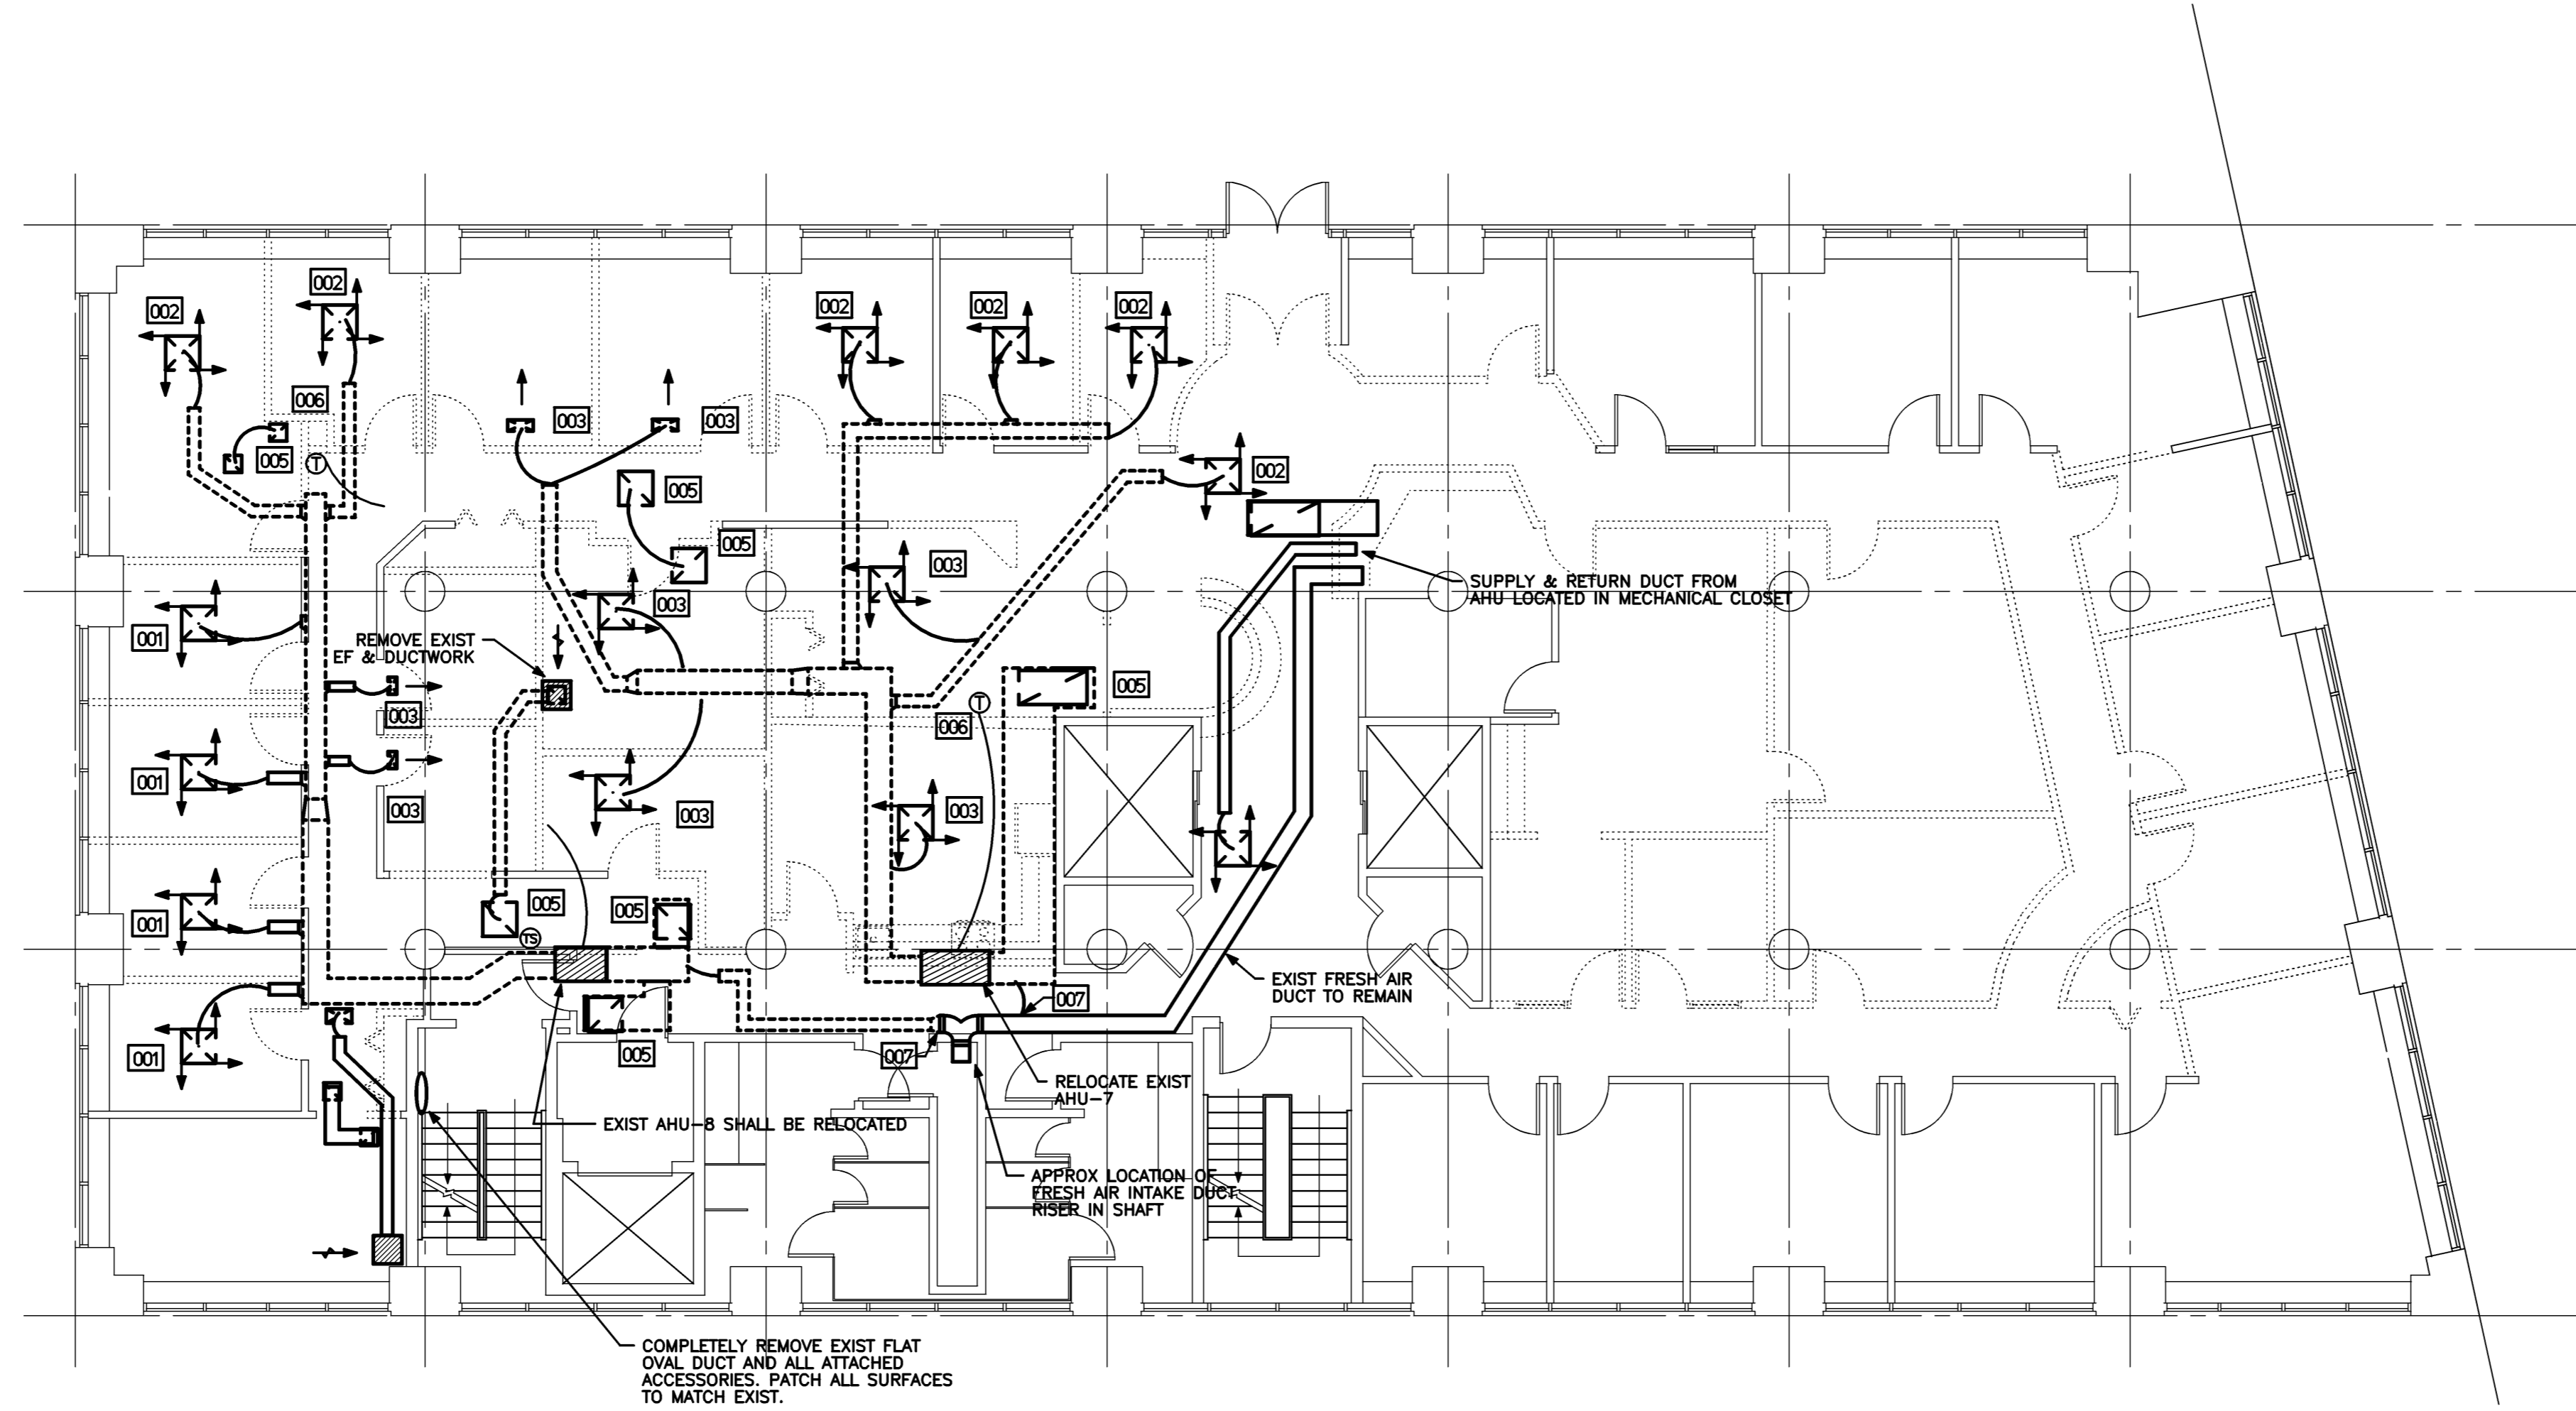


Project Title
**MEMIC
 COMPUTER ROOM
 RELOCATION**
 PORTLAND, MAINE

HA Project No. **04150**

Key Plan 



KEY NOTES

- 001 EXIST SUPPLY AIR DIFFUSER SHALL REMAIN.
- 002 EXIST SUPPLY AIR DIFFUSER SHALL BE RELOCATED.
- 003 EXIST SUPPLY AIR DIFFUSER SHALL BE REMOVED
- 004 EXIST RETURN AIR GRILLE SHALL REMAIN.
- 005 EXIST RETURN AIR GRILLE SHALL BE REMOVED.
- 006 EXIST THERMOSTAT SHALL BE RELOCATED.
- 007 CAP EXIST FRESH AIR DUCT THAT FEEDS AHU-7 AND AHU-8. FRESH AIR DUCT THAT FEEDS TWO REMAINING AHU'S ON THIS FLOOR SHALL REMAIN.

Mark	Date	Description
-	11-03-04	ISSUED FOR CONSTRUCTION
-	10-19-04	90% REVIEW
-	10-01-04	DD REVIEW

Drawing Status

Drawing Title
**SECOND FLOOR PLAN
 DEMOLITION**

PA / PE: **RDM** Drawn By: **RDM**

Drawing Number
M05.1