 

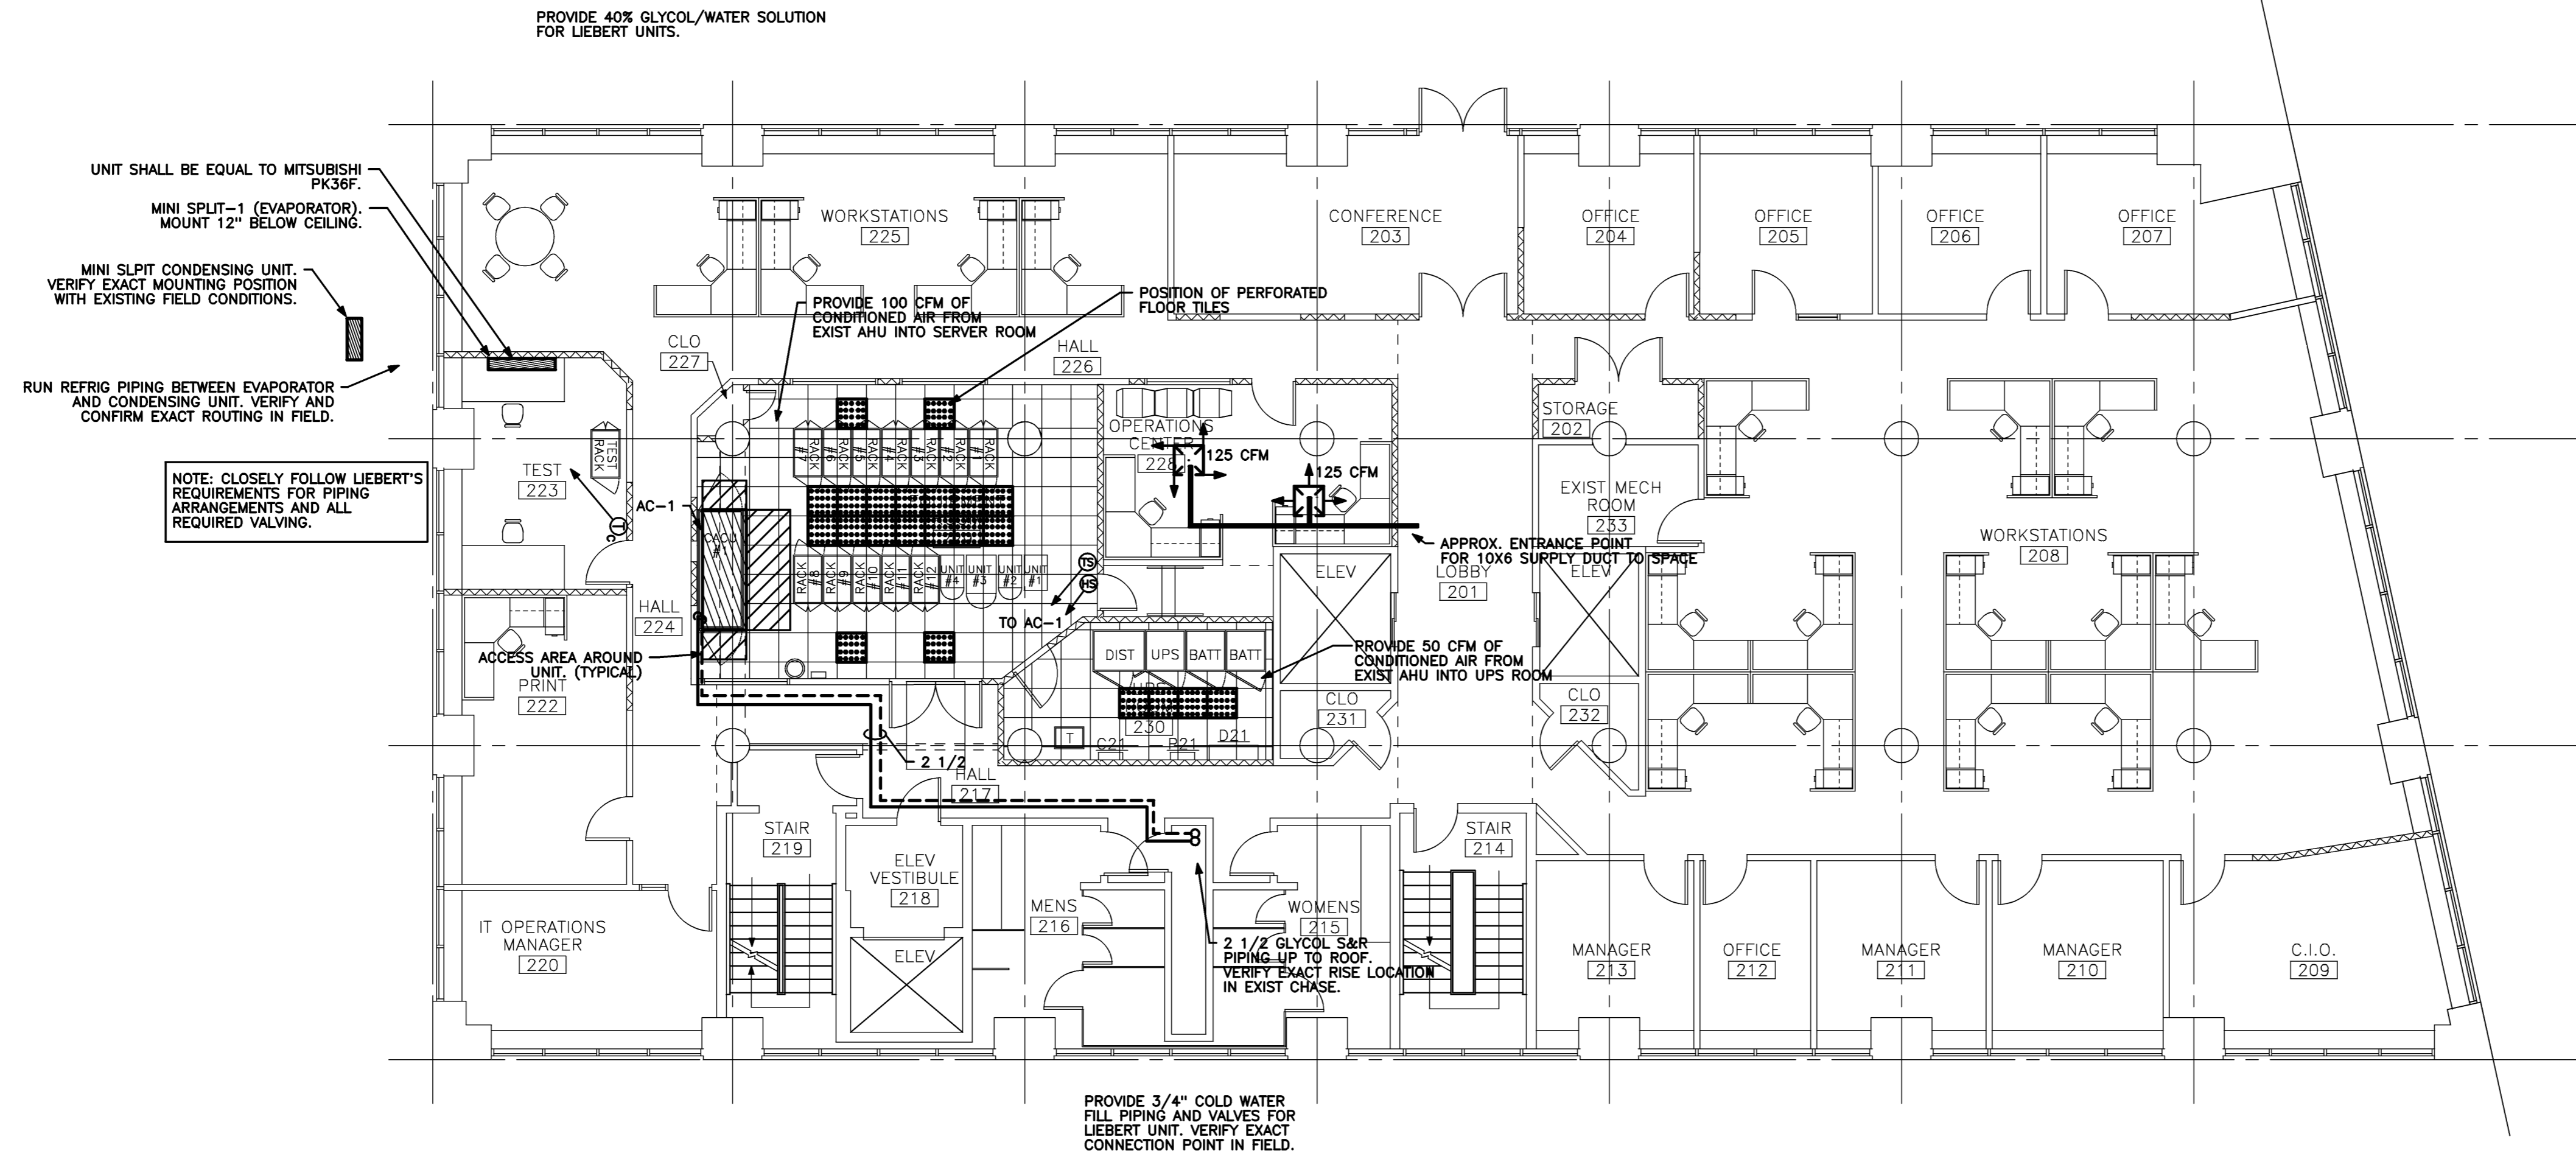


Project Title
**MEMIC
 COMPUTER ROOM
 RELOCATION**
 PORTLAND, MAINE

HA Project No. **04150**

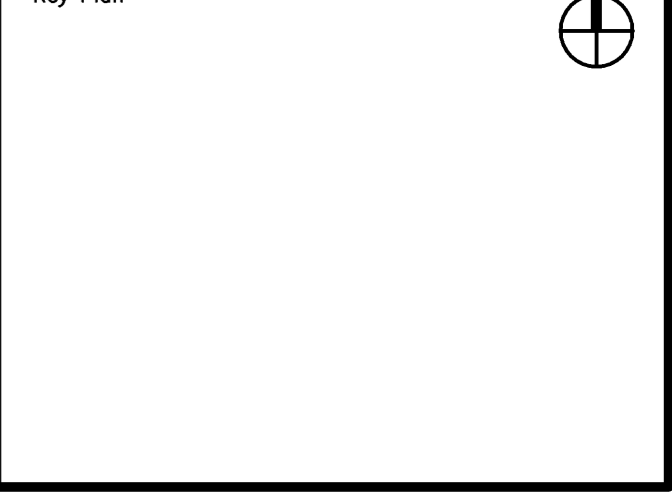

Mark	Date	Description
-	11-03-04	ISSUED FOR CONSTRUCTION
-	10-19-04	90% REVIEW
-	10-01-04	DD REVIEW

Issue Dates

SERVER ROOM LIEBERT UNIT SCHEDULE

UNIT NO.	MFR. & MODEL	SERVICE	COOLING CAPACITY, MBH		INDOOR UNIT				DRYCOOLER					COMPRESSORS		NOTES			
			TOTAL	SENSIBLE	CFM	VOLTS	PHASE	FLA	MAX FUSE SIZE	MODEL	PUMP HP	GPM	VOLTS	PHASE	WEIGHT		EXPANSION TANK SIZE	NUMBER	NUMBER OF STAGES PER COMPRESSOR
AC-1	DE192G-CAE1	SERVER ROOM	172.2	161.3	8400	208	3	114.3	125 AMPS	DDO260Y	3	54	208	3	1200 LBS	8.8 GALLONS	2	2	SEE SPECIFICATIONS FOR ADDITIONAL REQUIREMENTS

Drawing Status

Drawing Title
**SECOND FLOOR PLAN
 MECHANICAL**

PA / PE: **RDM** Drawn By: **RDM**

Drawing Number
M10.2