
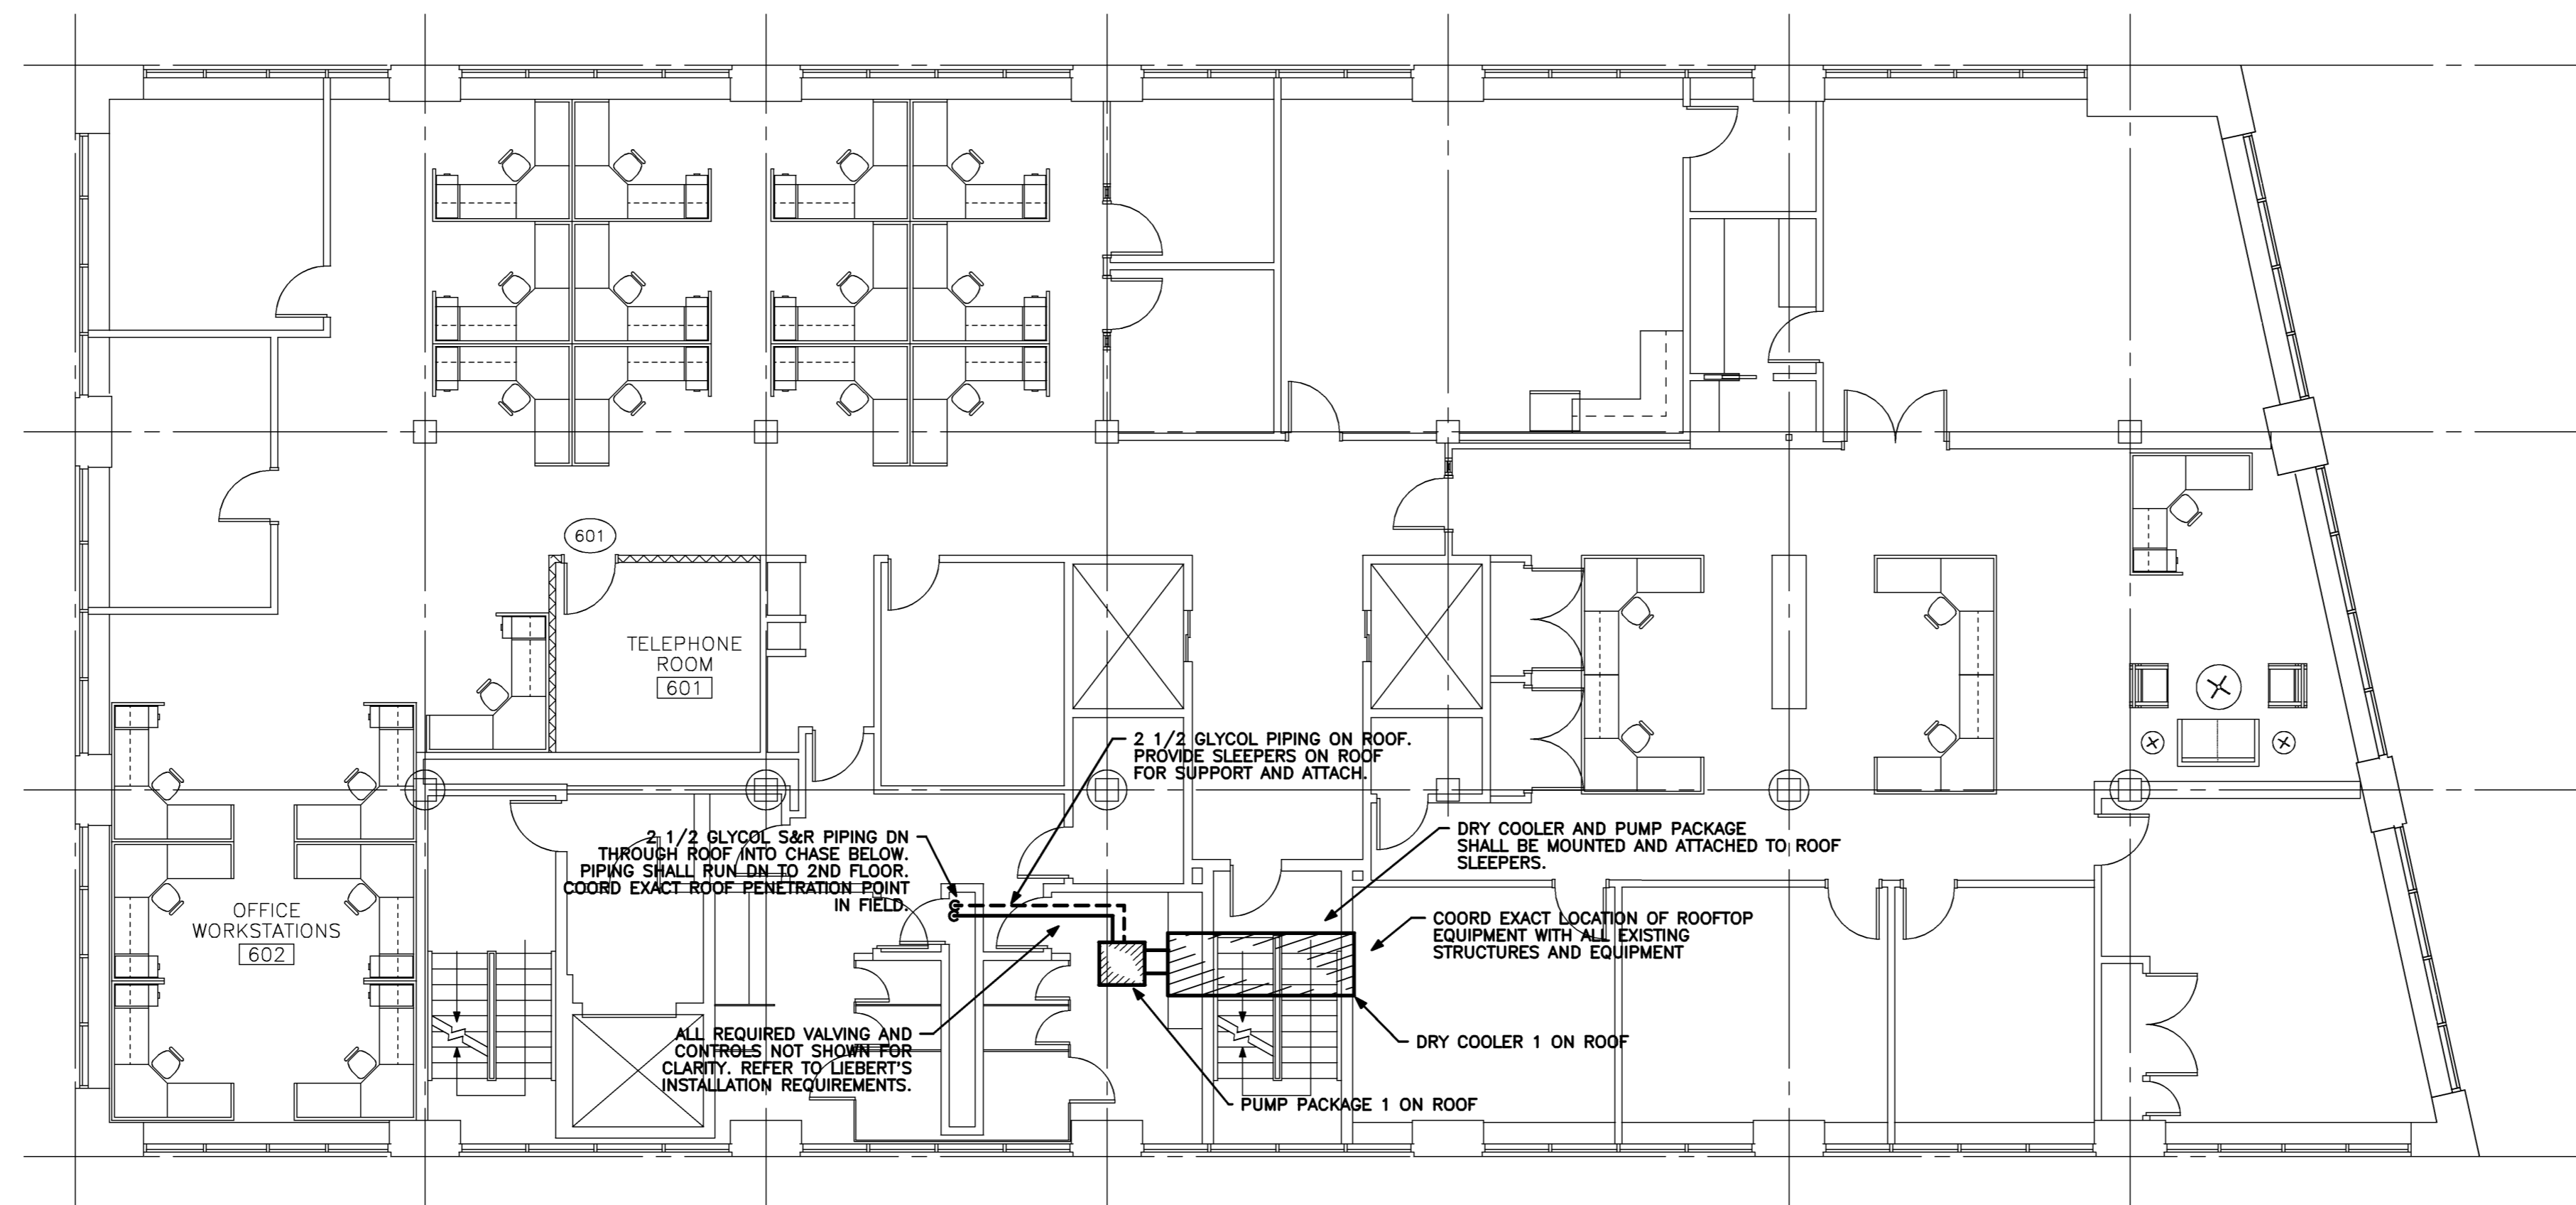


Project Title
**MEMIC
 COMPUTER ROOM
 RELOCATION**
 PORTLAND, MAINE

HA Project No. **04150**

Key Plan 



Mark	Date	Description
-	11-03-04	ISSUED FOR CONSTRUCTION
-	10-18-04	90% REVIEW
-	10-01-04	DD REVIEW

Issue Dates

Drawing Status

Drawing Title
**SIXTH FLOOR PLAN
 PIPING & DUCTWORK**

PA / PE: **RDM** Drawn By: **RDM**

Drawing Number
M10.6