


**MEMIC**  
261 COMMERCIAL STREET  
FLOOR 2 & FLOOR 6  
PORTLAND, ME 04101

REVISION NO.	DATE

TITLE	<b>2nd FLOOR LIGHTING PLAN</b>		
SCALE	AS NOTED	DRWN	CAT
DATE	01.07.2015	CHK	SAJ

DRAWING NO.  
**E-1**

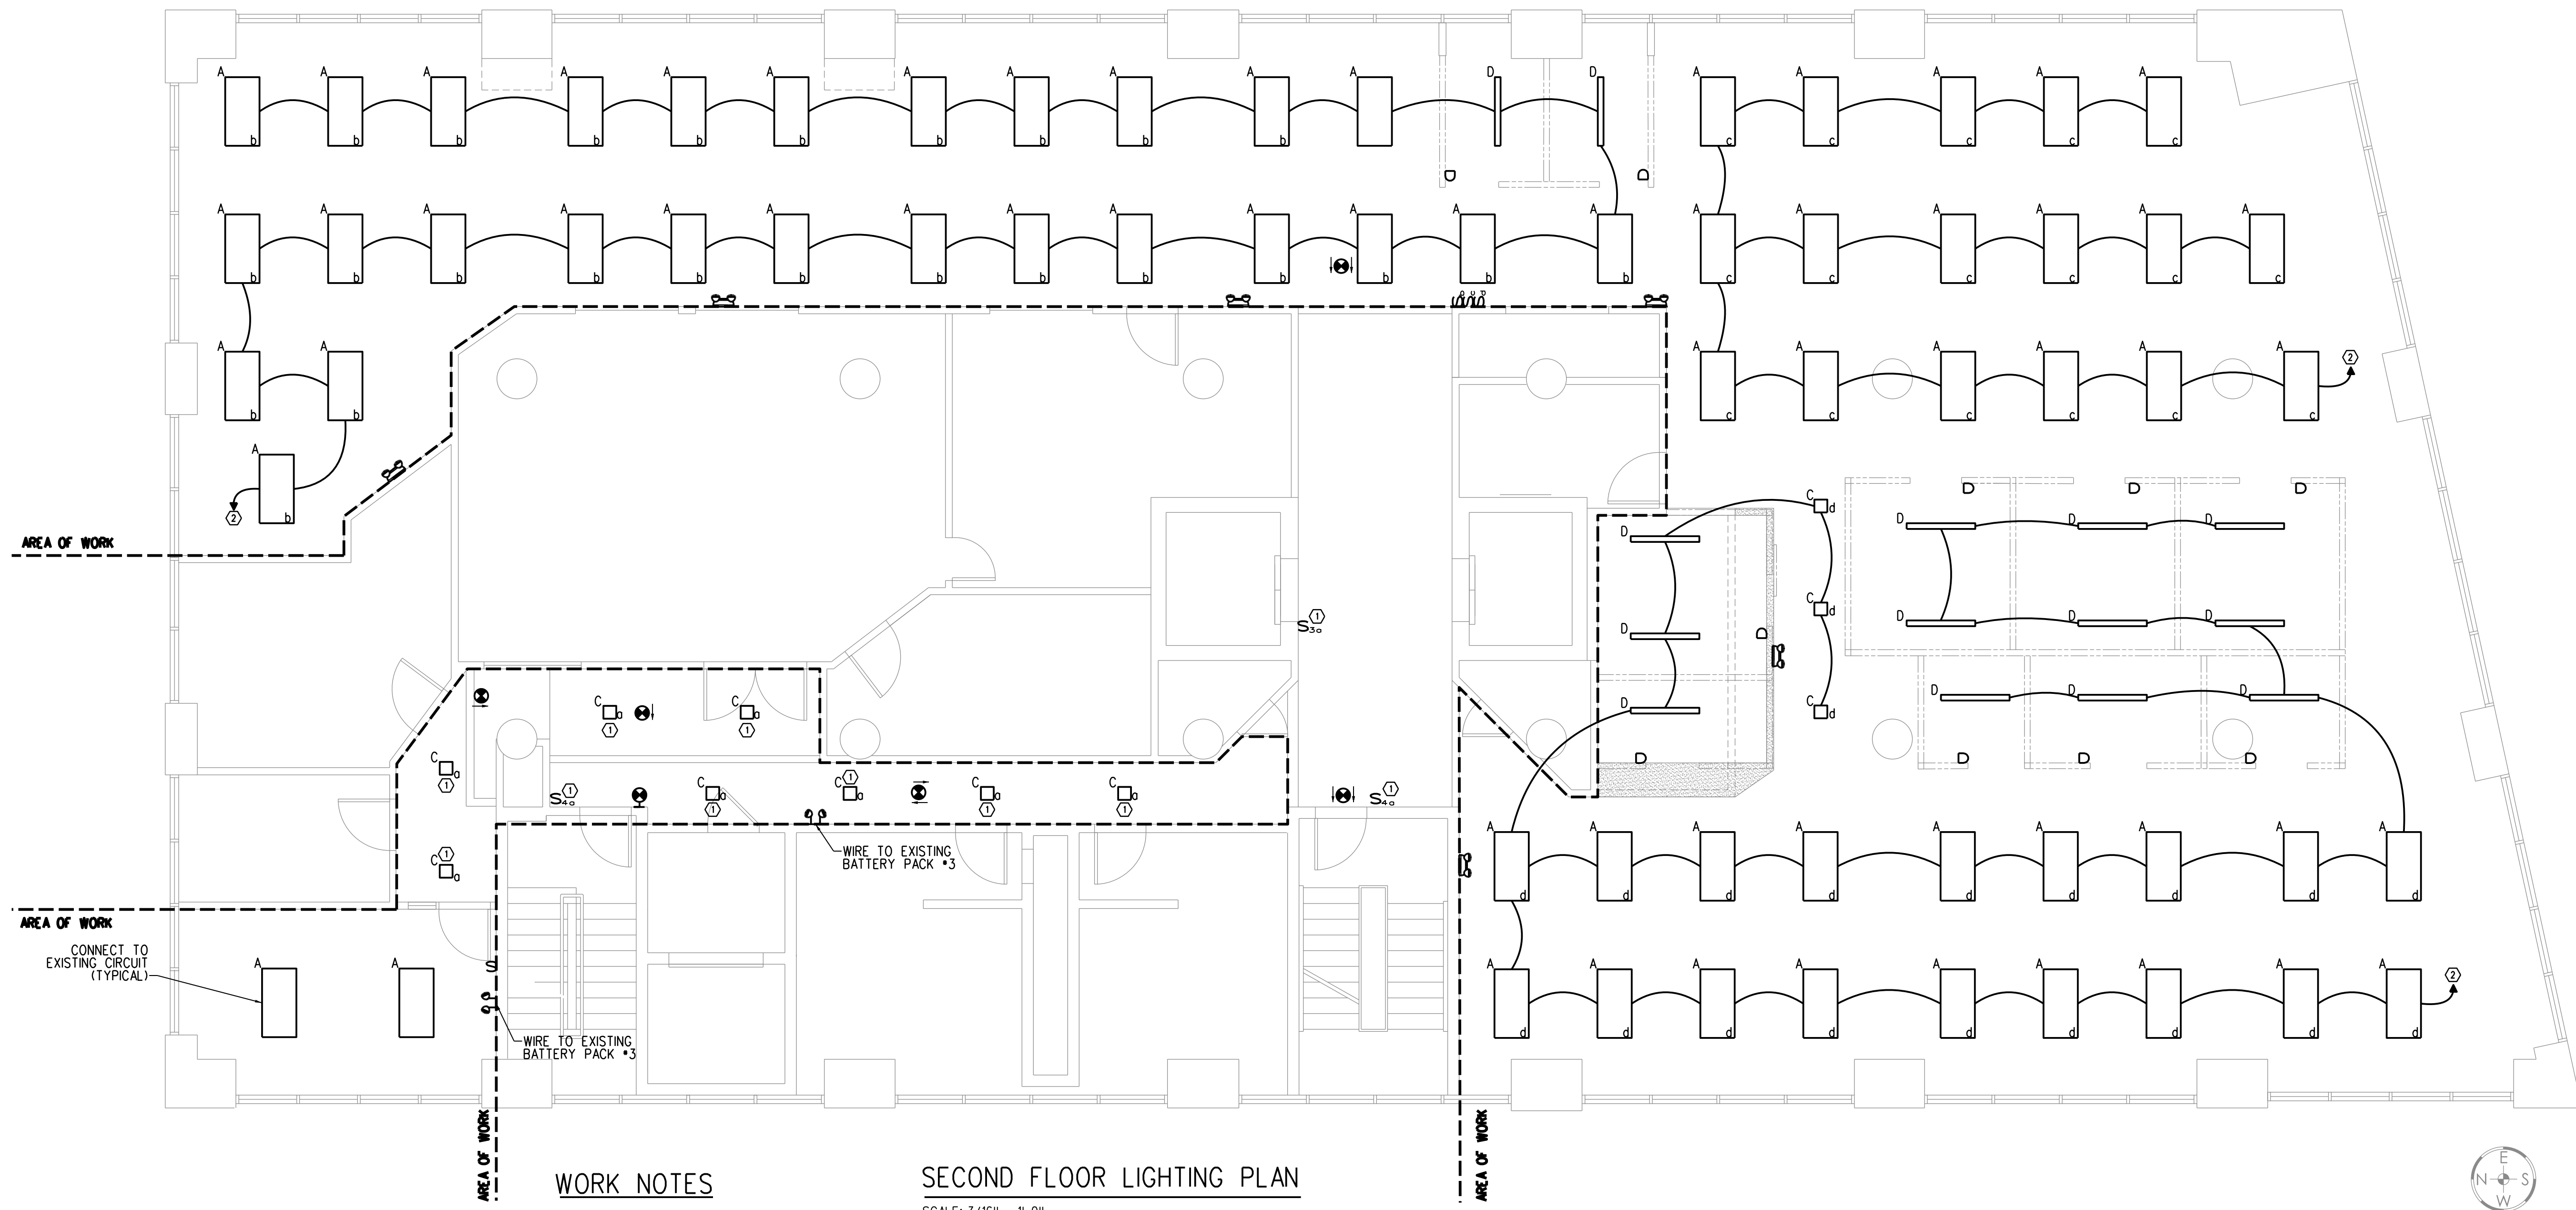

**WORK NOTES**

- ① CONTRACTOR SHALL CONNECT NEW LIGHTING FIXTURE TO EXISTING CIRCUIT AND SWITCH.
- ② CONTRACTOR SHALL CONNECT LIGHTING TO NEW 20A, 1-POLE CIRCUIT BREAKER WITHIN EXISTING POWER PANEL P21 AS INDICATED. NO CIRCUIT SHALL BE LOADED BEYOND 14 AMPERES AT 120V.

**SECOND FLOOR LIGHTING PLAN**

SCALE: 3/16" = 1'-0"