


PROGRESS PRINT
NOT FOR CONSTRUCTION



7 BENNETT RD
PO BOX 297
FREEPORT, ME

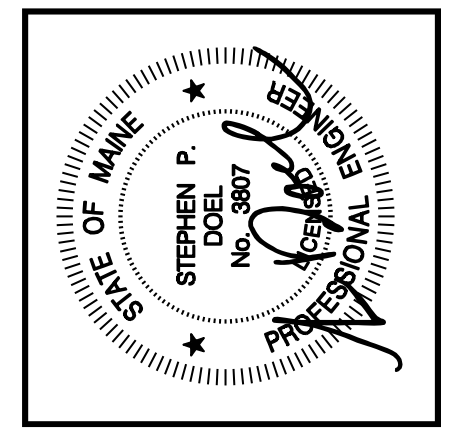


MEMIC
261 COMMERCIAL STREET
FLOOR 2 & FLOOR 6
PORTLAND, ME 04101

REVISION NO.	DATE

6TH FLOOR MECHANICAL PLAN	
TITLE	
SCALE	AS NOTED
DATE	01.07.2015
DRWN	SMR
CHK	SPD

DRAWING NO.
M-2

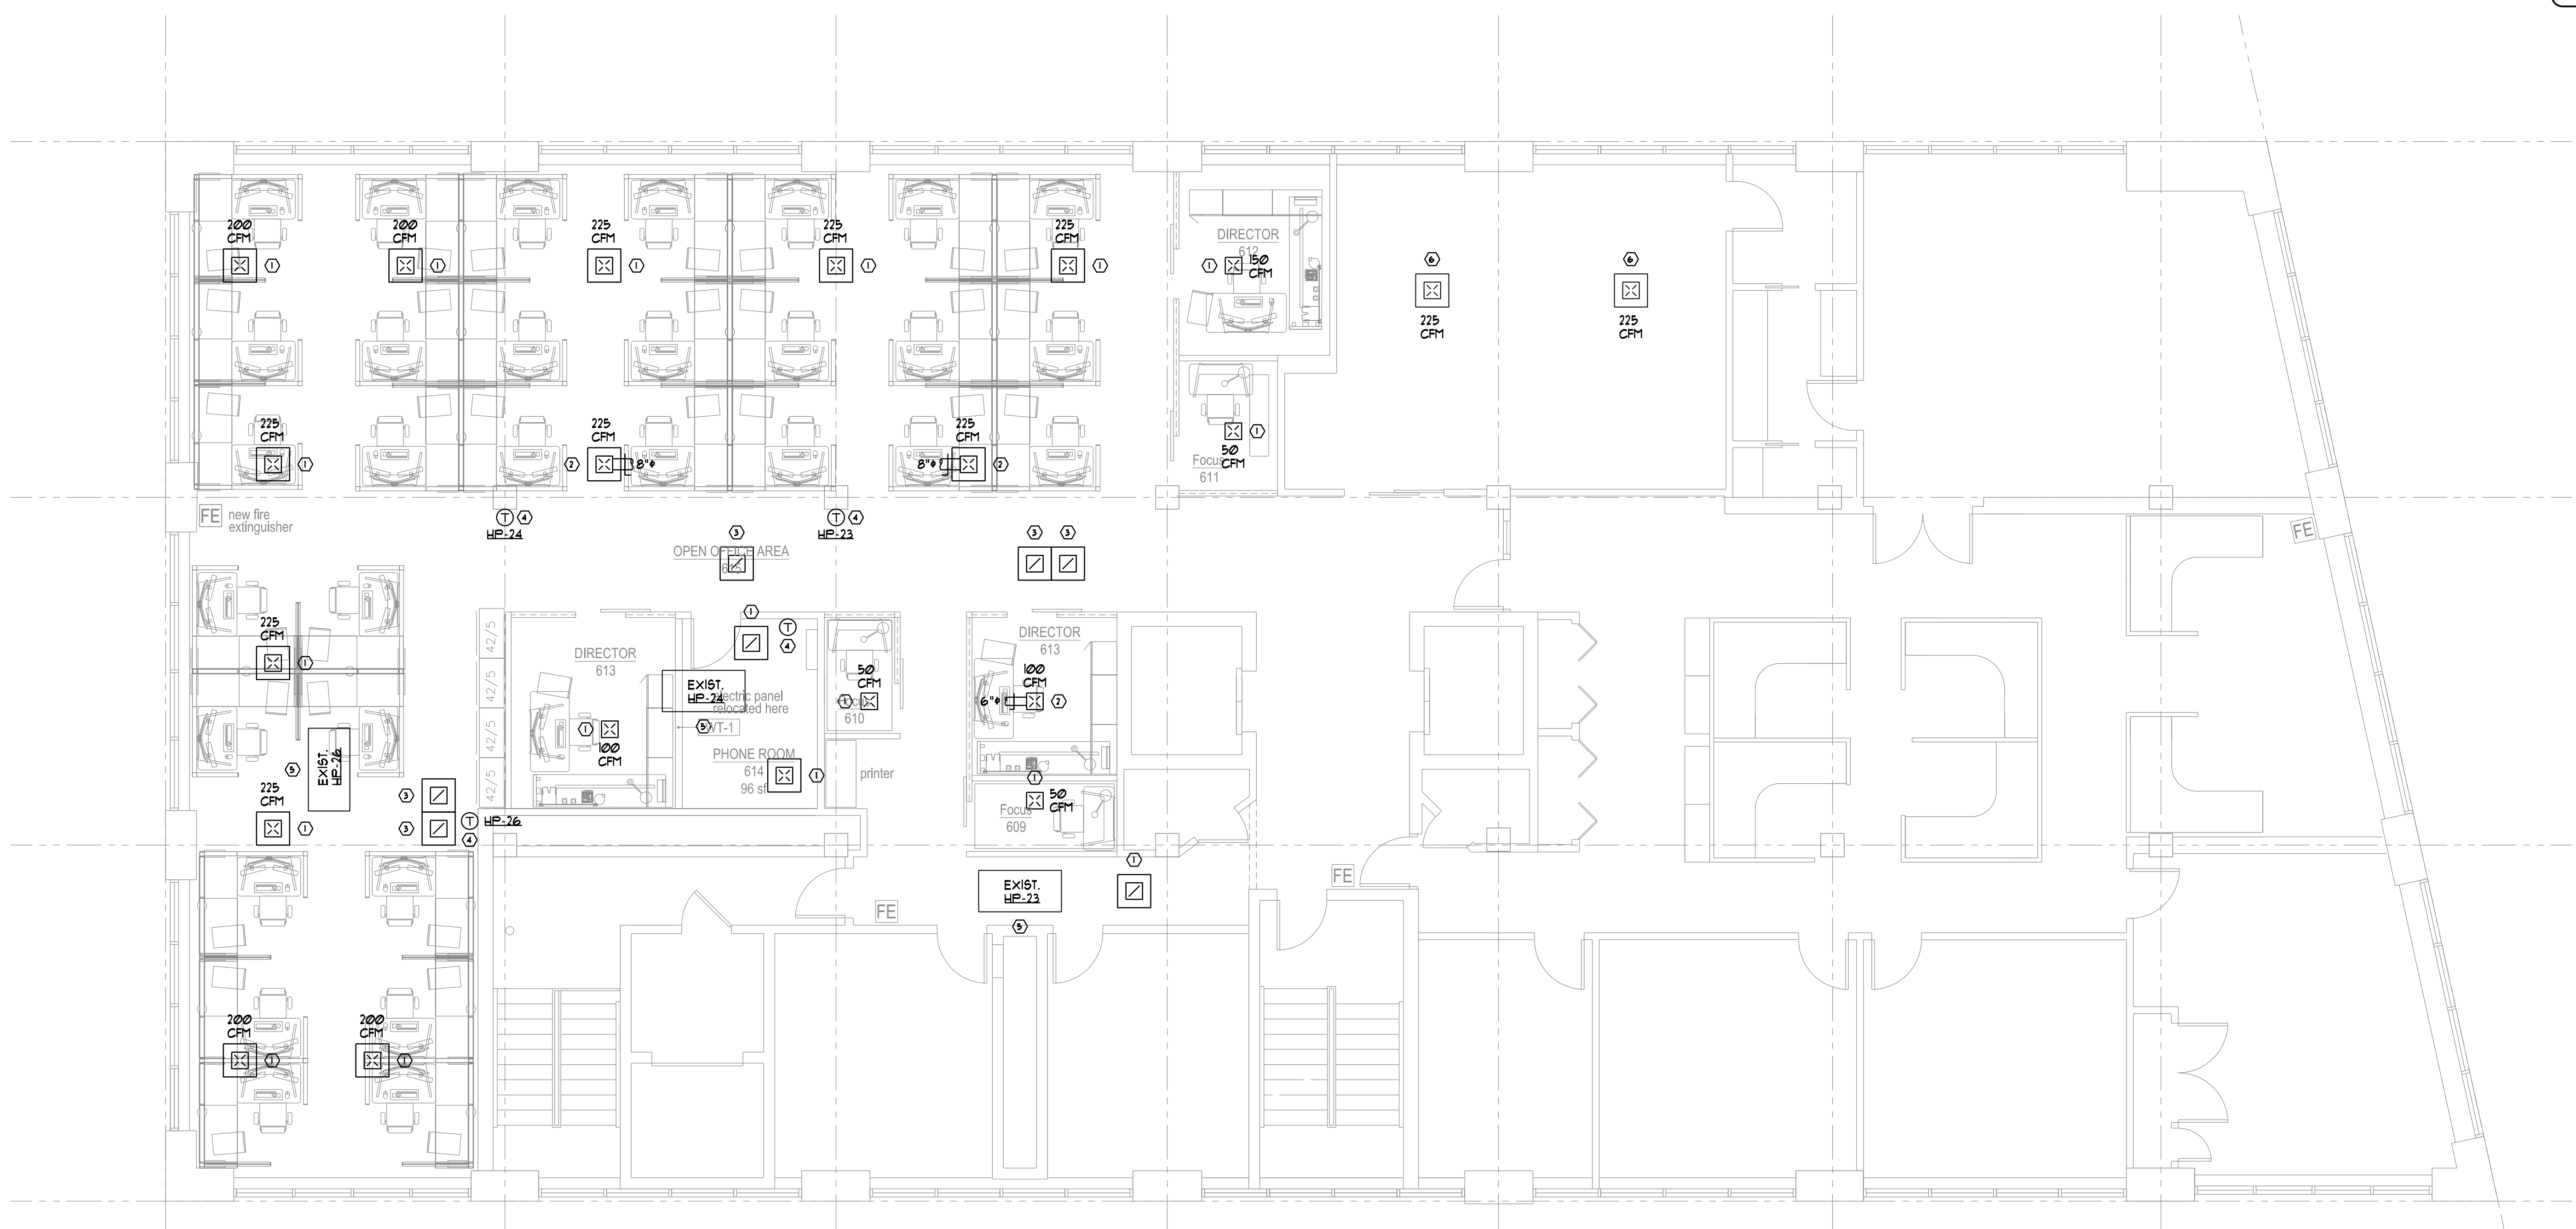

SIXTH FLOOR MECHANICAL PLAN
SCALE 3/16" = 1'-0"

MECHANICAL NOTES

- ① CONNECT TO EXISTING SUPPLY AIR BRANCH DUCT.
- ② CONNECT PROPOSED SUPPLY AIR DIFFUSER/DUCT TO EXISTING MAIN DUCT.
- ③ CONNECT TO EXISTING RETURN AIR DUCTWORK.
- ④ RELOCATE EXISTING THERMOSTAT, FIELD COORDINATE WITH OWNER.
- ⑤ EXISTING AIR HANDLING SYSTEM TO REMAIN, REBALANCE AS REQ'D.
- ⑥ EXISTING DIFFUSER/GRILLE TO REMAIN.

FOR PERMITTING