


Lisa Whited
 Chief Transformation Officer
 207. 323. 2189 lisa@workplaceff.com

Michael Barton
 Value and Constructability Analyst
 207. 939. 5432 michael@workplaceff.com

Josef Chalot
 Maine Licensed Architect
 207. 318. 3234 AzimuthBlu@gmail.com

Mechanical and Electrical Engineering:
 Bennett Engineering
 contact: Scott Rhesault/Cal Tranberg
 ph (207) 865-9475
 Scott@bennettengineering.net
 Cal@bennettengineering.net

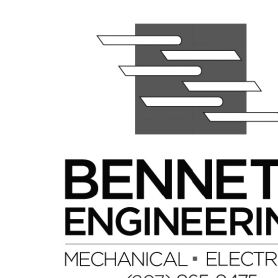

Project:
 MEMIC
 Tenant Improvement to 3rd, 4th, and 5th floors
 261 Commercial Street, Portland Maine
 CBL 038 F019

Tenant: MEMIC
 261 Commercial Street
 Portland Maine, 04101

Tenant Contact
 Catherine Lamson,
 Senior Vice President
 Chief Administrative Officer
 (207) 791 3304


Building Owner:
 Casco View Holdings II, LLC
 PO Box 1137
 Portland, ME 04104

General Contractor:
 Zachau Construction
 1185 U.S. Route One
 Freeport, ME 04032
 ph (207) 865-9925 (office)
 contact: Jon
 207.807.8980 (mobile)
 Jon@zachauconstruction.com


| Date | Purpose |
|------------|--|
| 08/14/2015 | Issued for Permit Only not for construction |

Sheet Title
 5th FLOOR LIGHTING PLAN

Sheet Number
 E-3

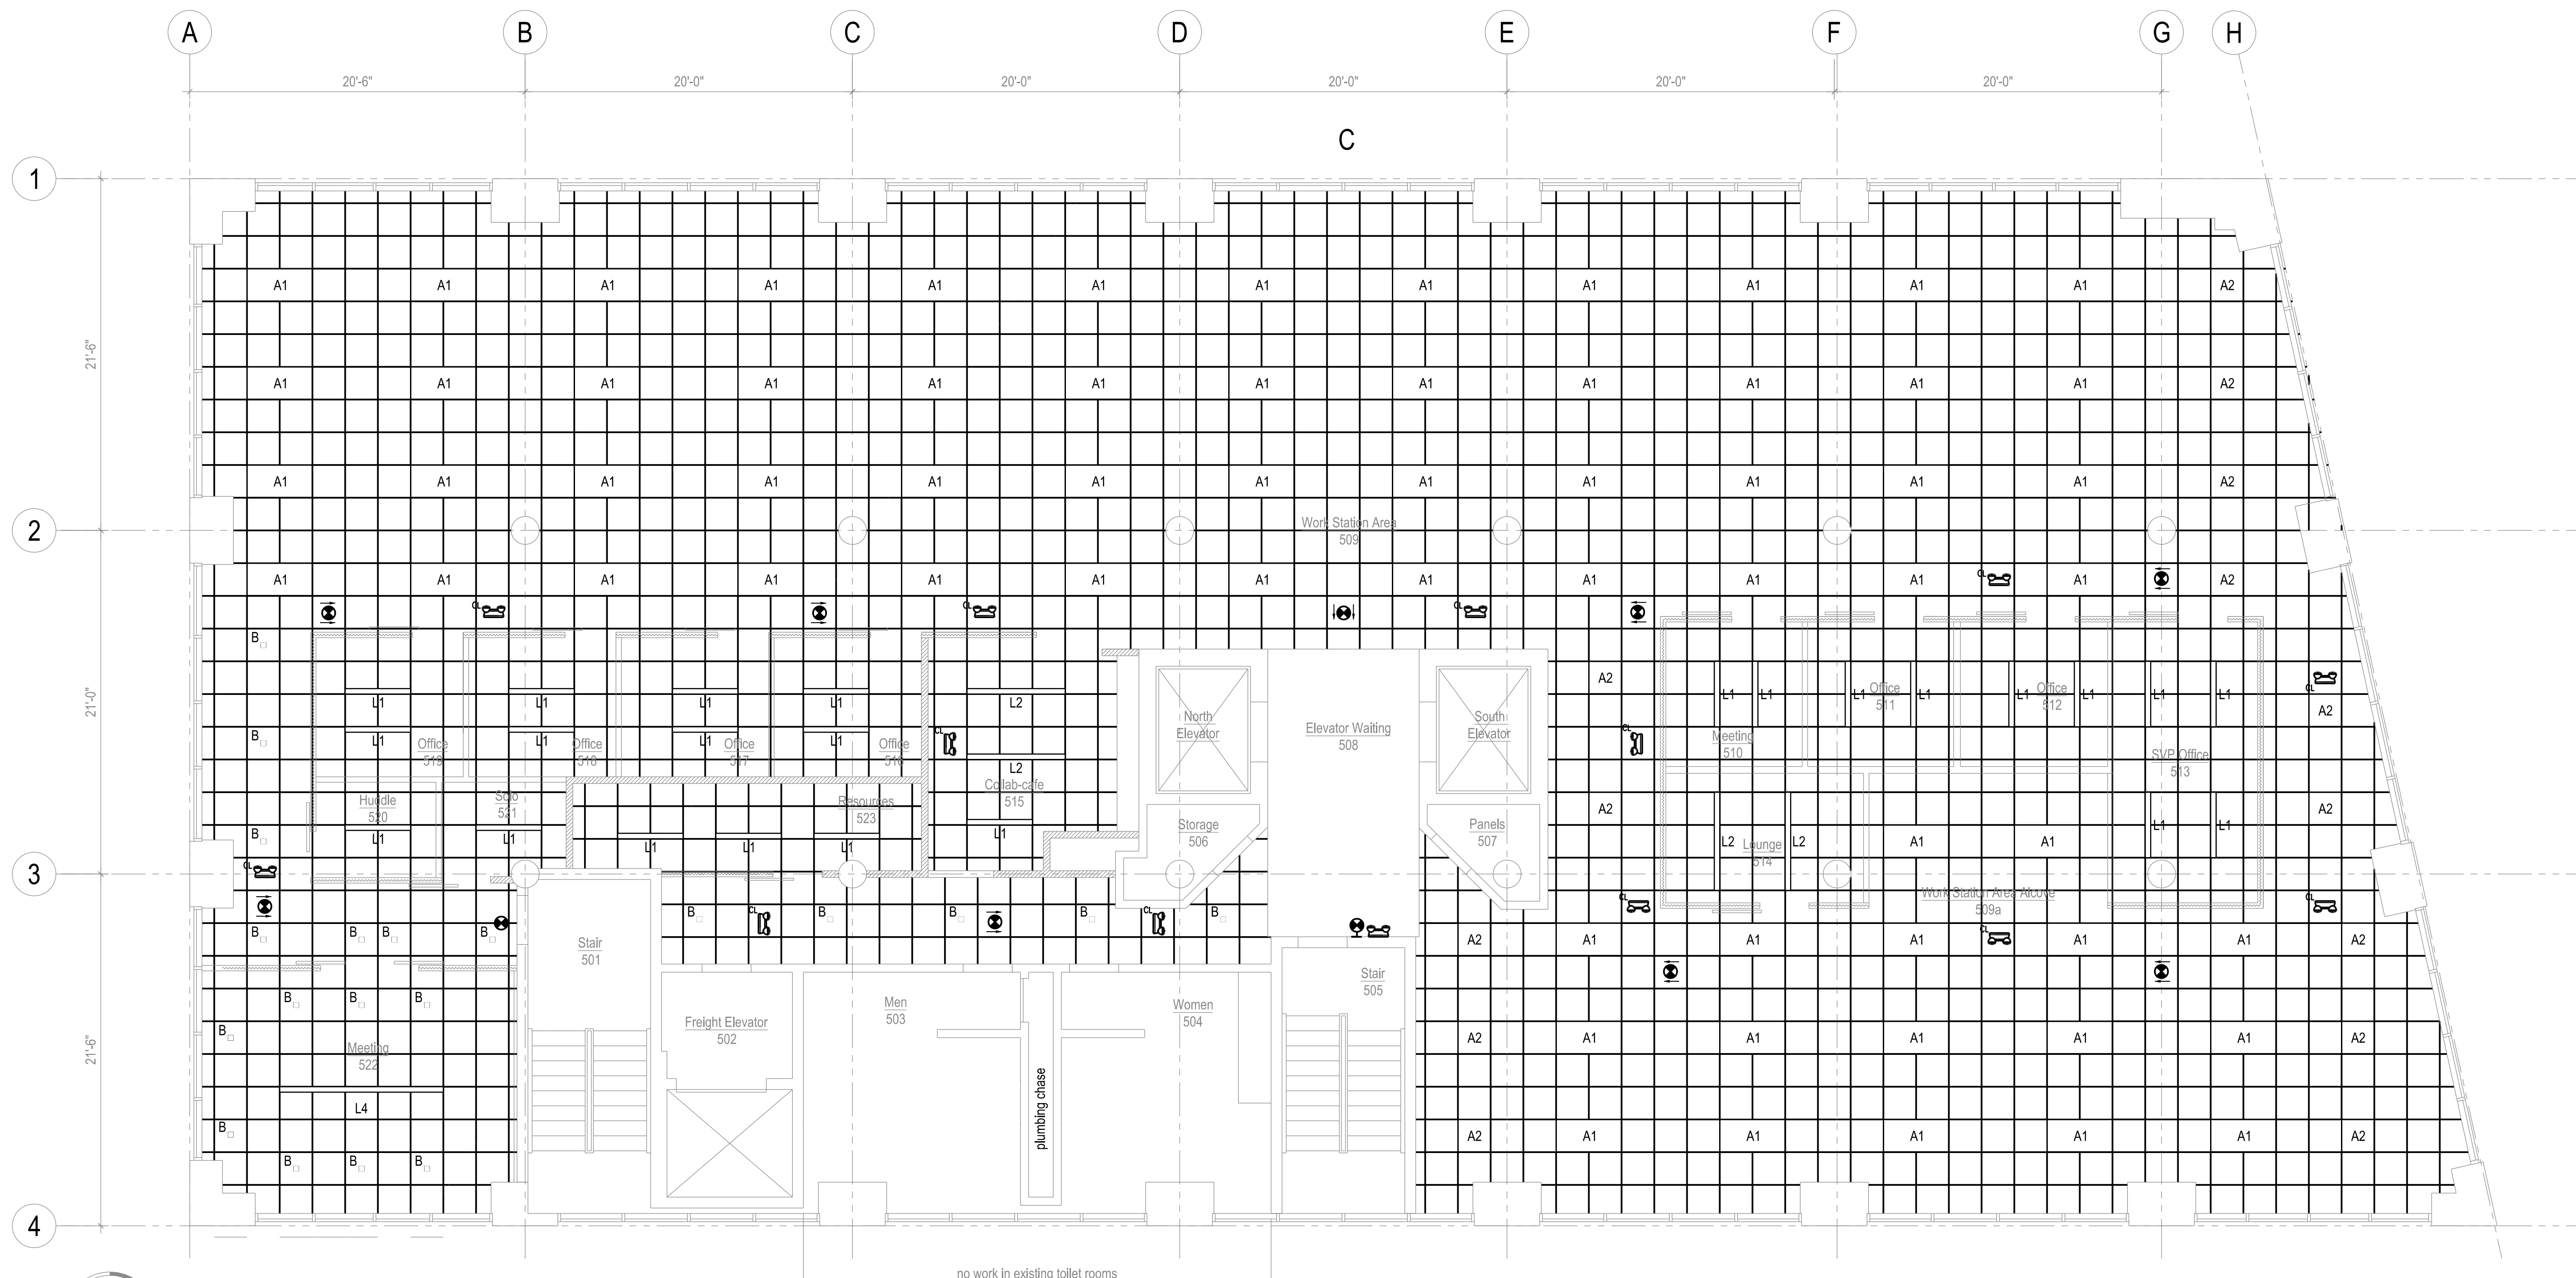

FIFTH FLOOR LIGHTING PLAN
 SCALE: 3/16" = 1'-0"

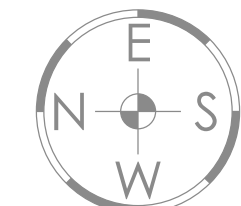

no work in existing toilet rooms