


Lisa Whited
 Chief Transformation Officer
 207.323.2189 lisa@workplaceff.com

Michael Barton
 Value and Constructability Analyst
 207.939.5432 michael@workplaceff.com

Josef Chalat
 Maine Licensed Architect
 207.318.3234 AzimuthBlu@gmail.com

Mechanical and Electrical Engineering:
Bennett Engineering
 contact: Scott Pheasant/Cal Tranberg
 ph (207) 865-9475
 Scott@bennettengineering.net
 Cal@bennettengineering.net

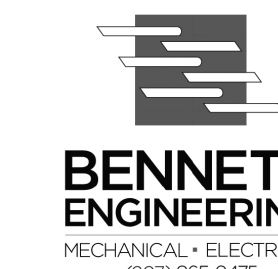

Project:
MEMIC
 Tenant Improvement to 3rd, 4th, and 5th floors
 261 Commercial Street, Portland Maine
 CBL 038 F019

Tenant: MEMIC
 261 Commercial Street
 Portland Maine, 04101

Tenant Contact:
 Catherine Lamson,
 Senior Vice President
 Chief Administrative Officer
 (207) 791 3304

Building Owner:
 Casco View Holdings II, LLC
 PO Box 1137
 Portland, ME 04104


General Contractor:
Zachau Construction
 1185 U.S. Route One
 Freeport, ME 04032
 ph (207) 865-9925 (office)
 contact: Jon
 207.807.8980 (mobile)
 Jon@zachauconstruction.com

Date	Purpose
08/14/2015	Issued for Permit Only not for construction

Sheet Title
 3rd FLOOR POWER PLAN

Sheet Number

E-4

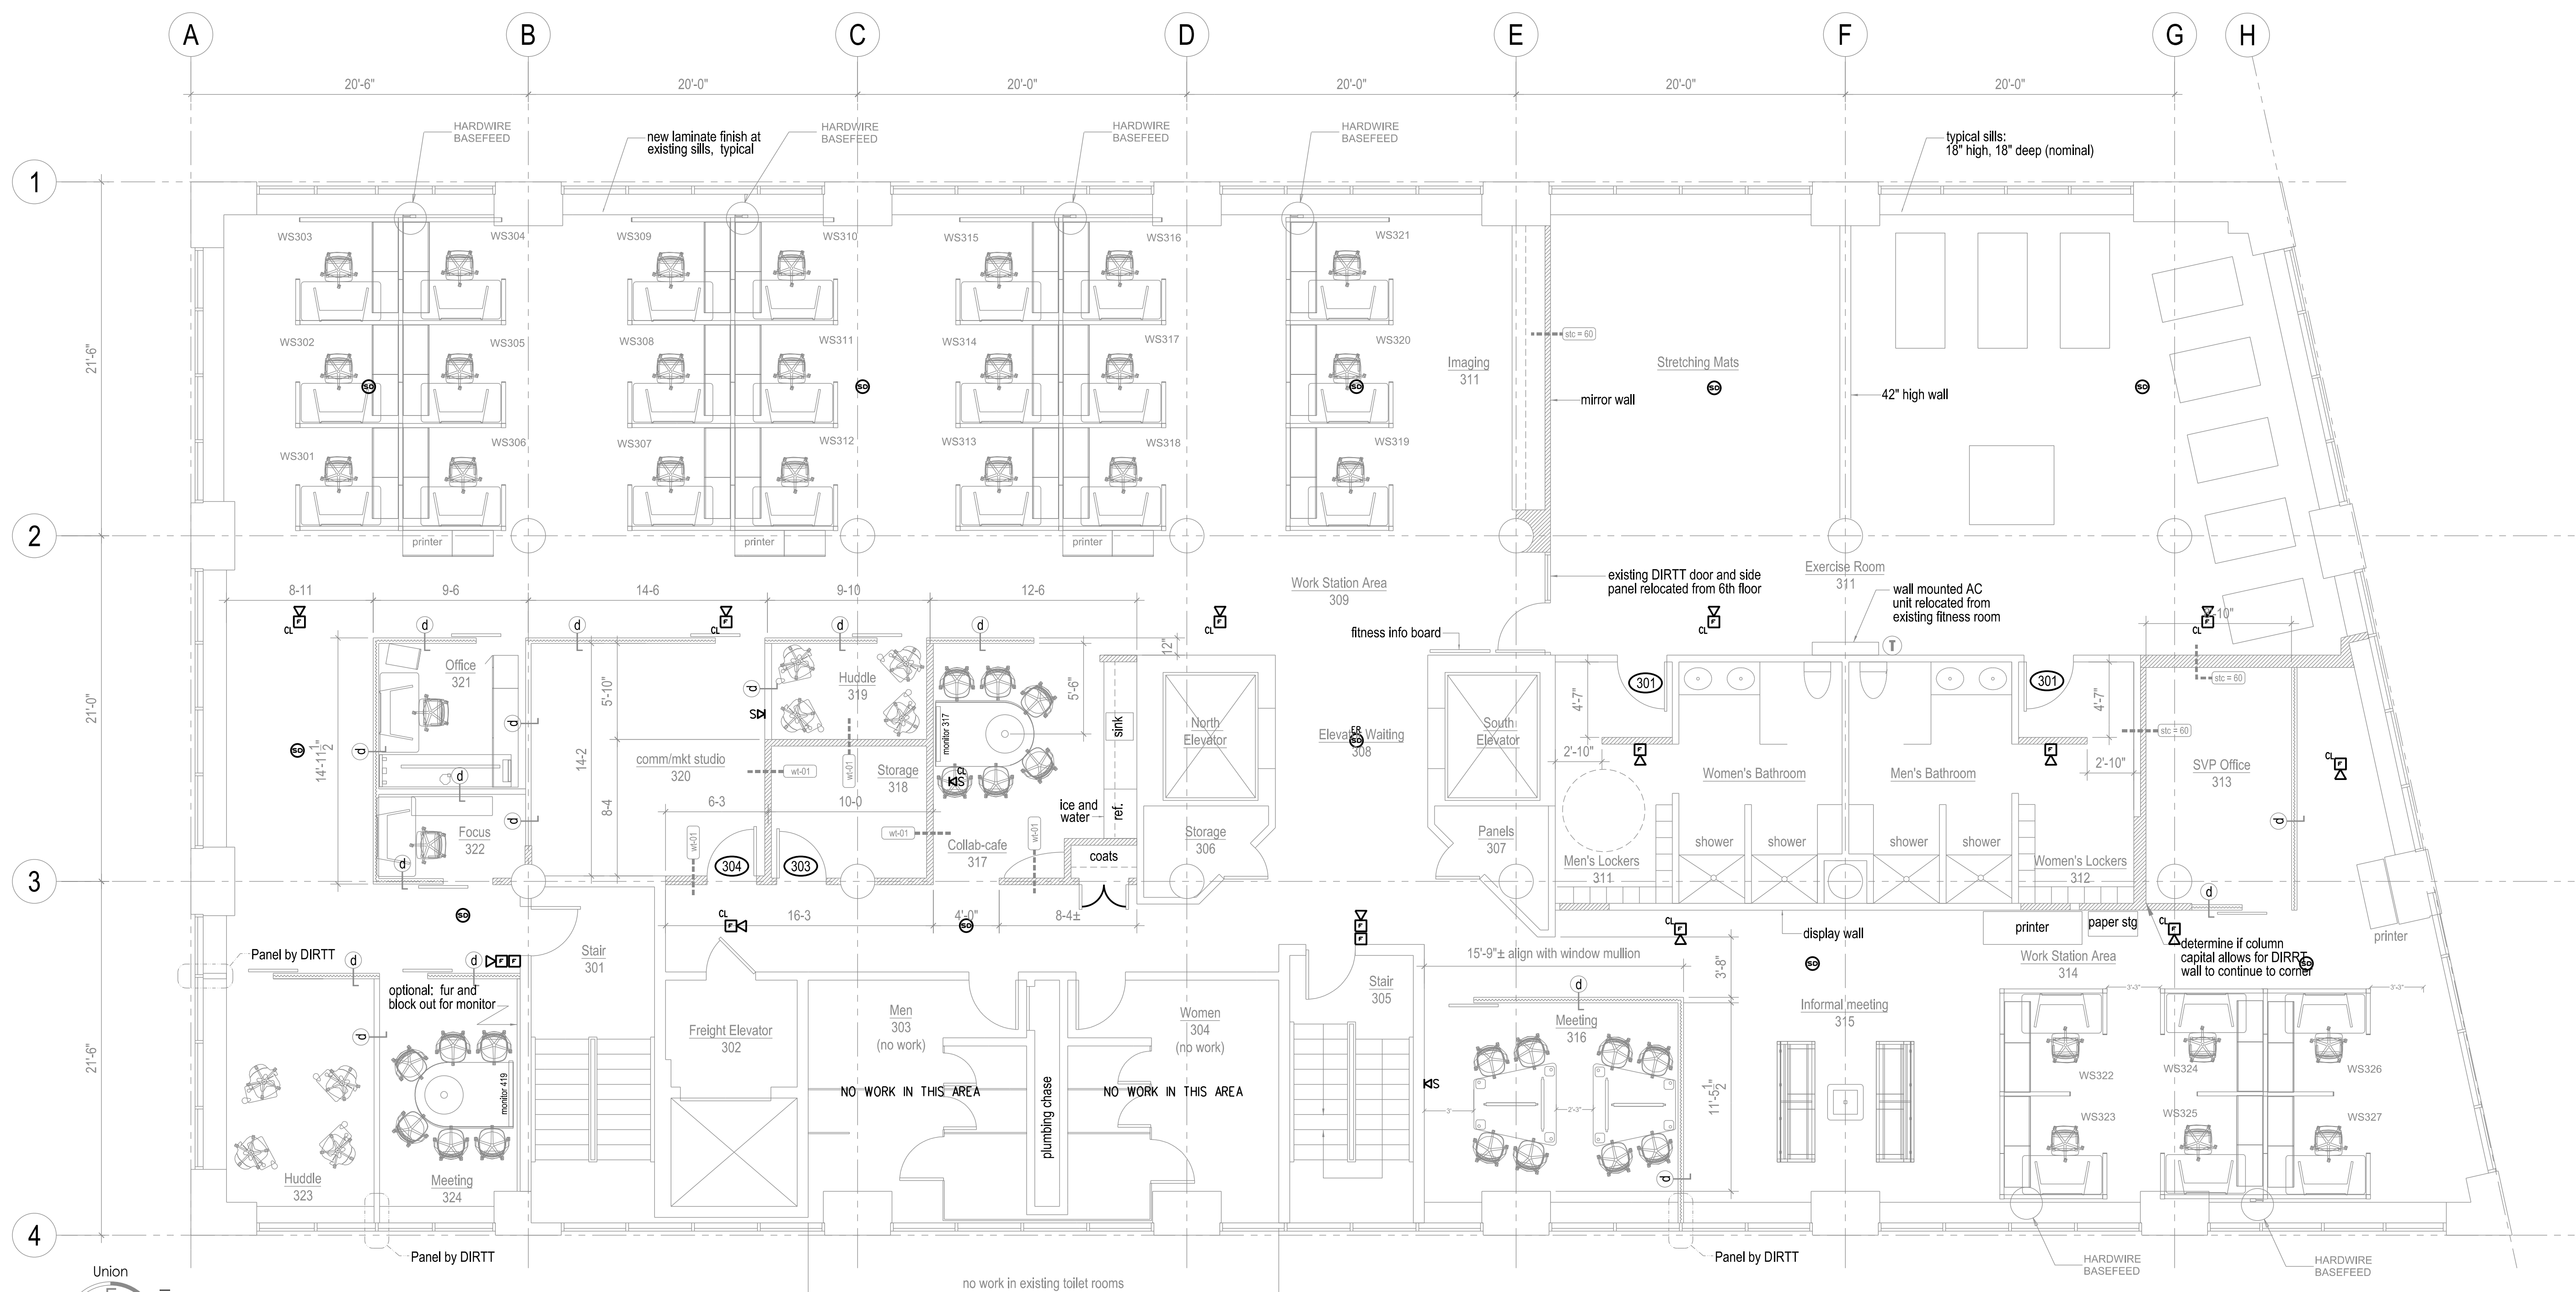


WORK NOTES

① CONTRACTOR SHALL CONNECT NEW FIRE ALARM DEVICES TO EXISTING SIMPLEX SYSTEM PER MANUFACTURER'S SPECIFICATIONS.

THIRD FLOOR POWER PLAN

SCALE: 3/16" = 1'-0"

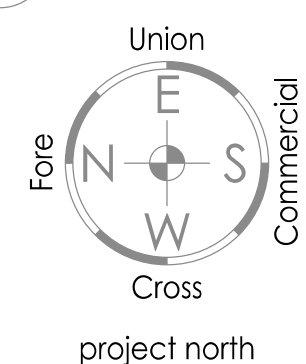

project north