


GRANT HAYS
ASSOCIATES

ARCHITECTURE & INTERIOR DESIGN
P.O. BOX 6179 FALMOUTH MAINE 04105
207.871.5900 www.granthays.com

SCALE

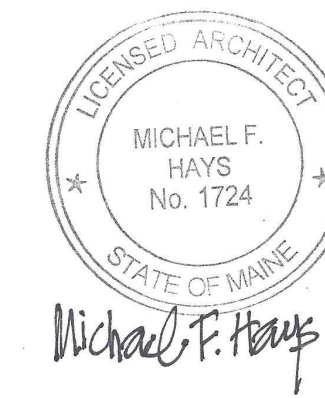

REVISIONS

DRAWING NAME

MEMIC
RENOVATION TO
HUMAN RESOURCES AT
261 COMMERCIAL ST.
PORTLAND, MAINE 04101

SHEET

REFLECTED
CEILING
PLAN

DATE
23 FEB 2017

SCALE
AS NOTED

DRAWN BY
MFH/mgk

JOB NO.
170203

SHEET


A-2

COPYRIGHT
REPRODUCTION OR REV. OF THIS
DOCUMENT WITHOUT WRITTEN
PERM. FROM GRANT HAYS
ASSOCIATES IS PROHIBITED.


CEILING LEGEND	
	2x4 LIGHT FIXTURE (FINELINE) (15 EXISTING / 2 NEW)
	2x2 LIGHT FIXTURE (FINELINE) (2 EXISTING / 4 NEW)
	4x4 RECESSED LIGHT (2 EXISTING)
	2x2 HVAC SUPPLY (19 EXISTING / 2 NEW - TBD)
	2x2 HVAC RETURN (3 EXISTING)
	1x1 HVAC RETURN (2 EXISTING)
	EMERGENCY SERVICES FLASHER (BLUE LIGHT) (1 EXISTING)
	WHITE NOISE EMITTER (19 EXISTING)
	WiFi MODEM (1 EXISTING)

FINISH MATERIALS LIST	
(E) EXISTING	(E/R) EXISTING RELOCATED
	EMERGENCY LIGHT
	HORN / STROBE UNIT
	CEILING MOUNTED HORN / STROBE UNIT
	SPRINKLER HEAD
	SMOKE DETECTOR
	DETECTOR
	EXIT LIGHT
	EXIT LIGHT WITH EMERGENCY LIGHTS


LIFE SAFETY NOTES	
1.	MODIFY EXISTING NFPA 13 FIRE SUPPRESSION SPRINKLER SYSTEM AS REQUIRED. SPRINKLER SYSTEM MODIFICATIONS SHALL BE REVIEWED AND APPROVED BY THE STATE OF MAINE FIRE MARSHAL AS WELL AS THE LOCAL AUTHORITY HAVING JURISDICTION. THE SPRINKLER CONTRACTOR SHALL BEAR SOLE RESPONSIBILITY FOR THE DESIGN AND INSTALLATION OF THE SYSTEM FOR OCCUPANCY.
2.	MODIFY THE EXISTING FIRE ALARM SYSTEM AS REQUIRED FOR COMPLIANCE WITH NFPA 101 LIFE SAFETY CODE. COORDINATE WITH SPRINKLER SYSTEM. VERIFY LOCATION OF ALARM AND DETECTORS WITH THE AUTHORITY HAVING JURISDICTION.
3.	SEE ACCESSIBILITY DETAILS FOR MOUNTING HEIGHTS OF LIFE SAFETY DEVICES.

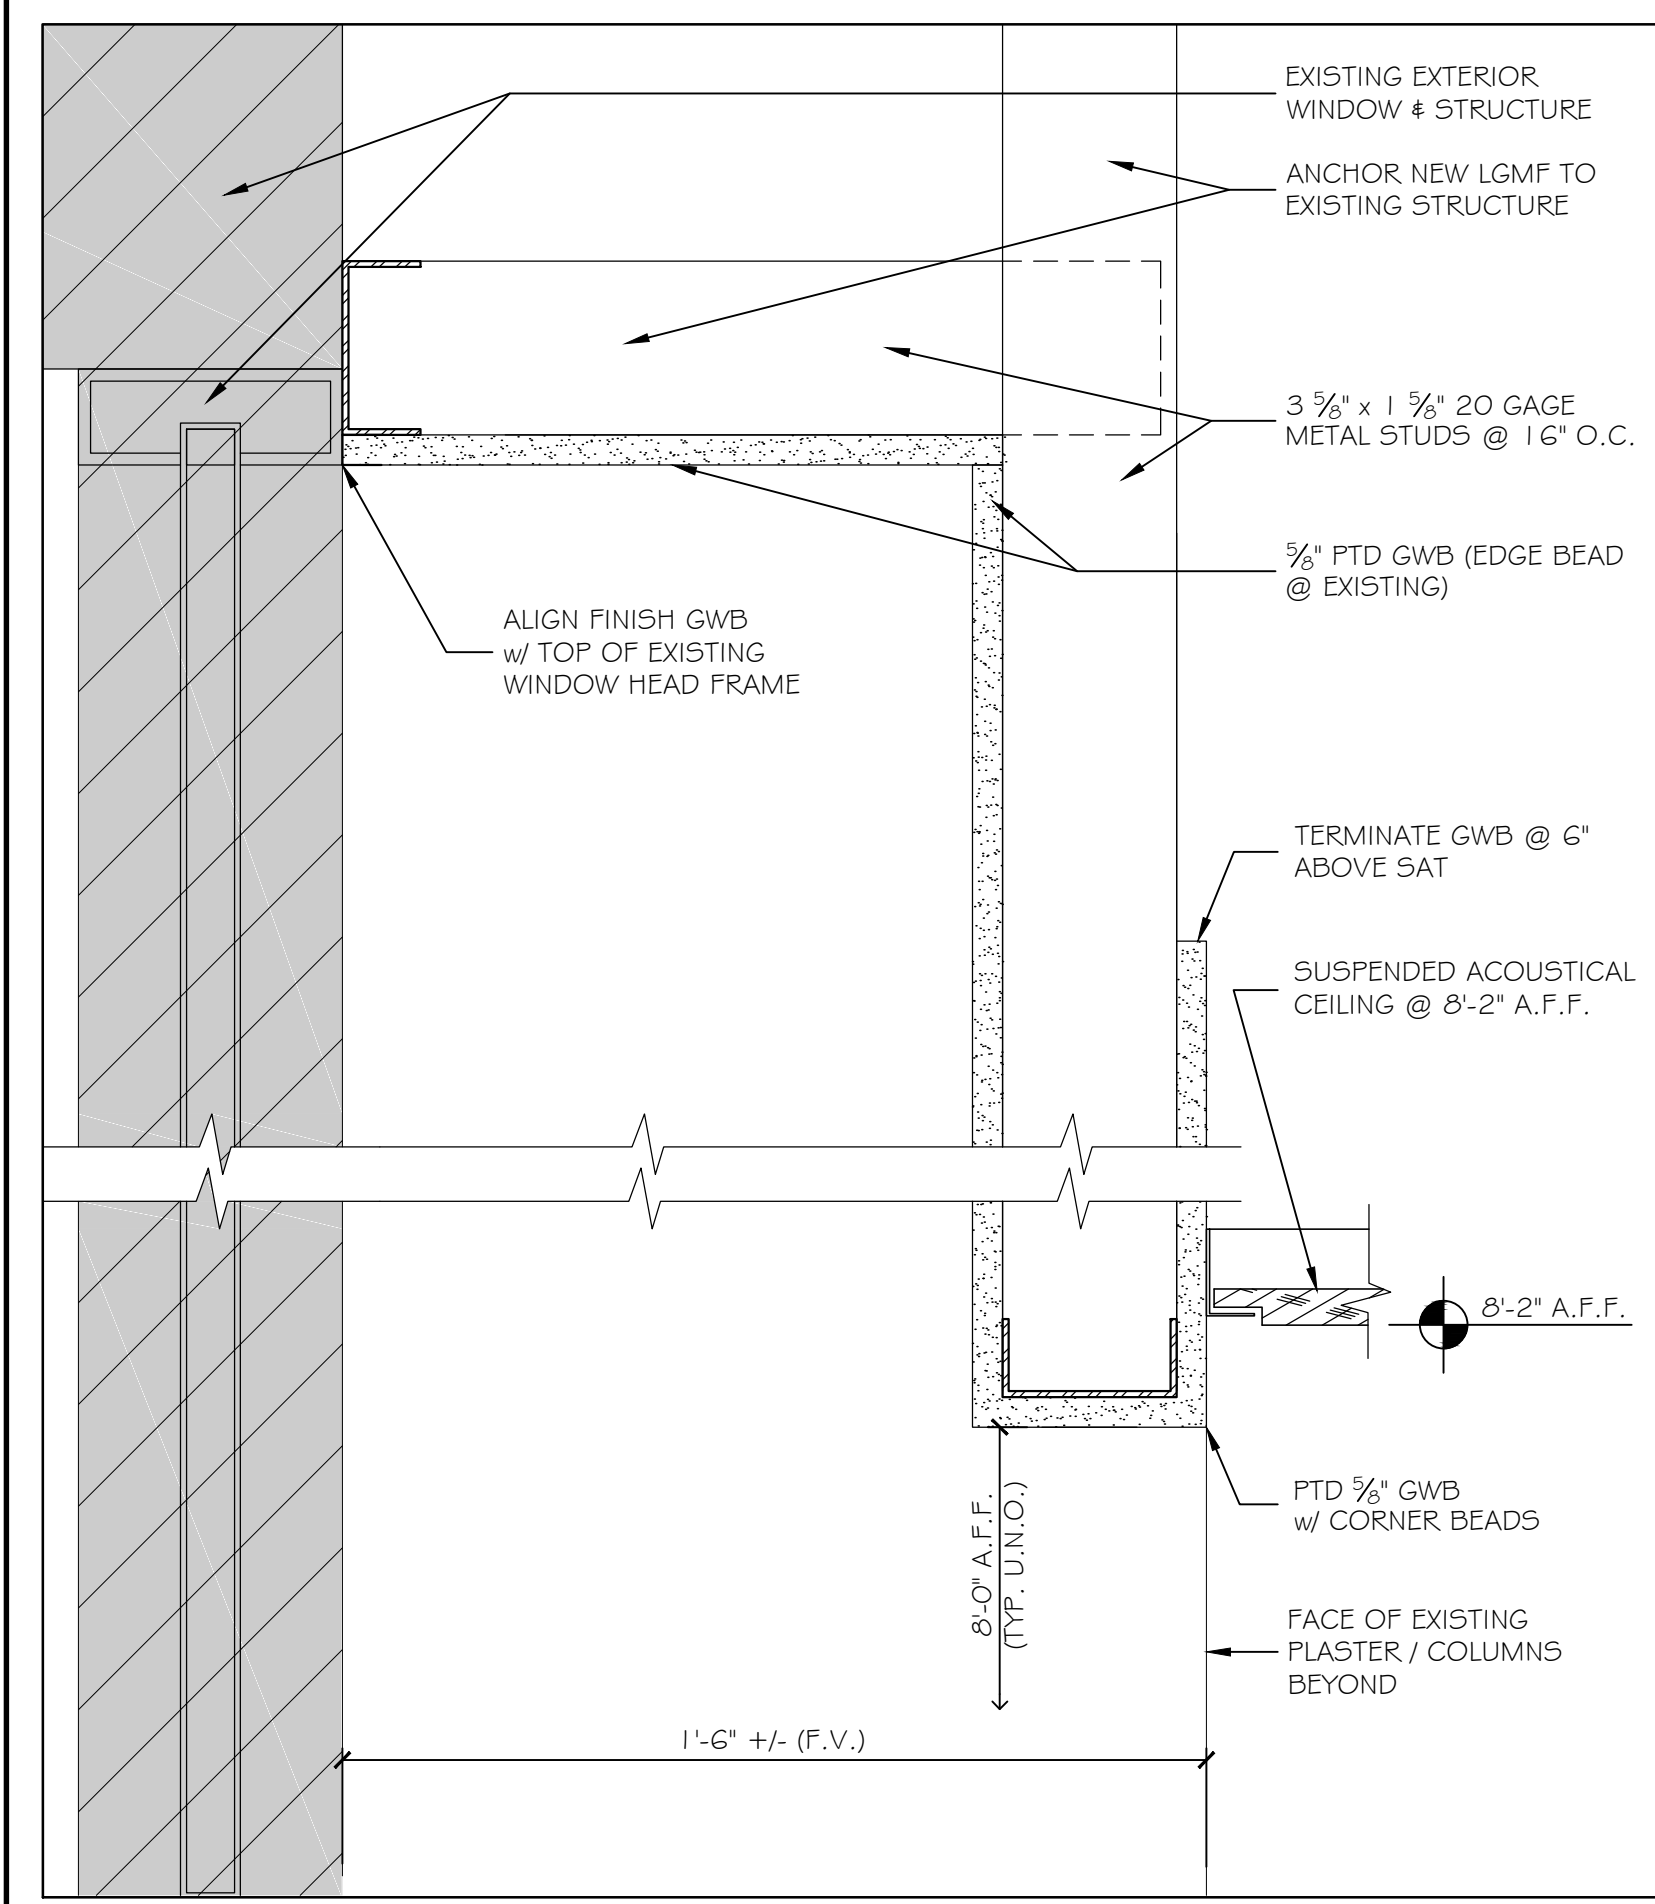

1 NEW WINDOW SOFFIT DETAIL 3" = 1'-0"

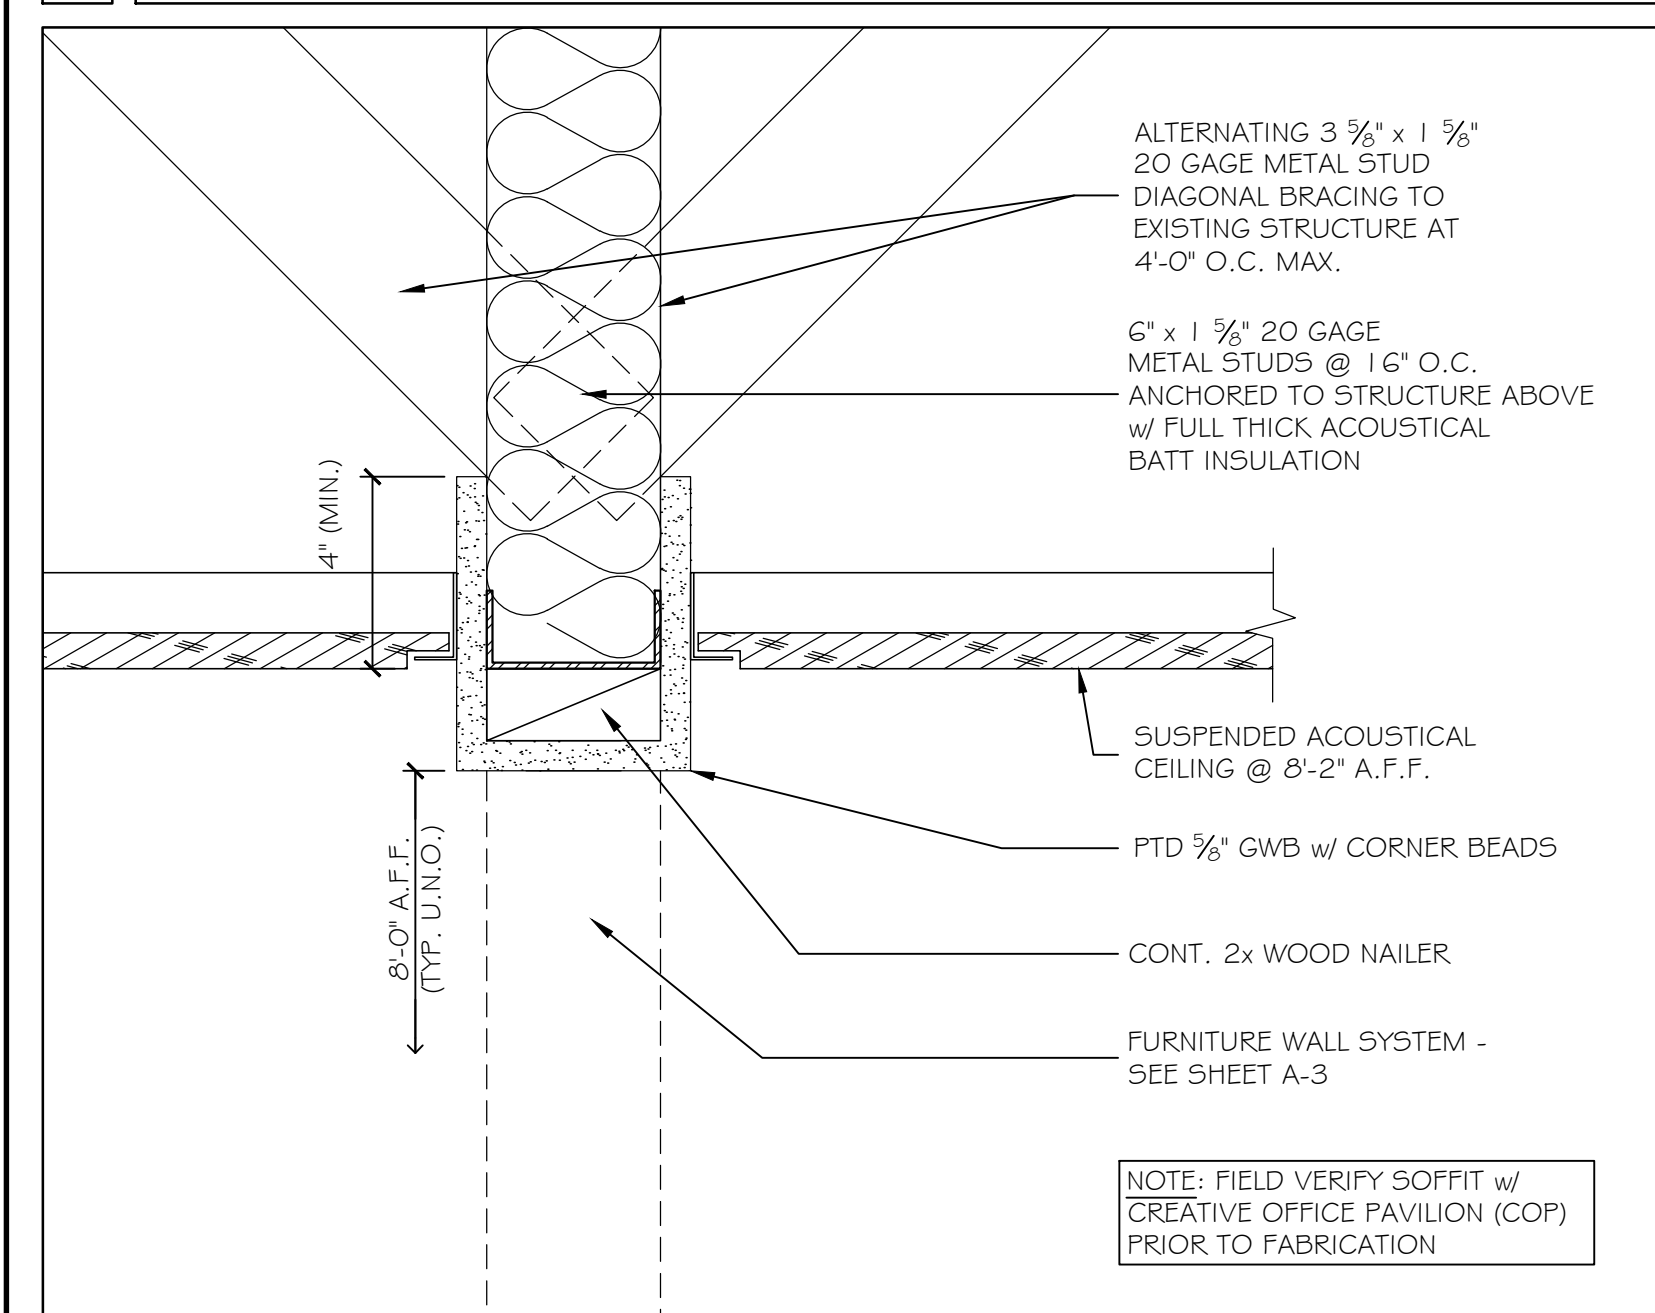

1 NEW FURNITURE PARTITION SOFFIT 3" = 1'-0"

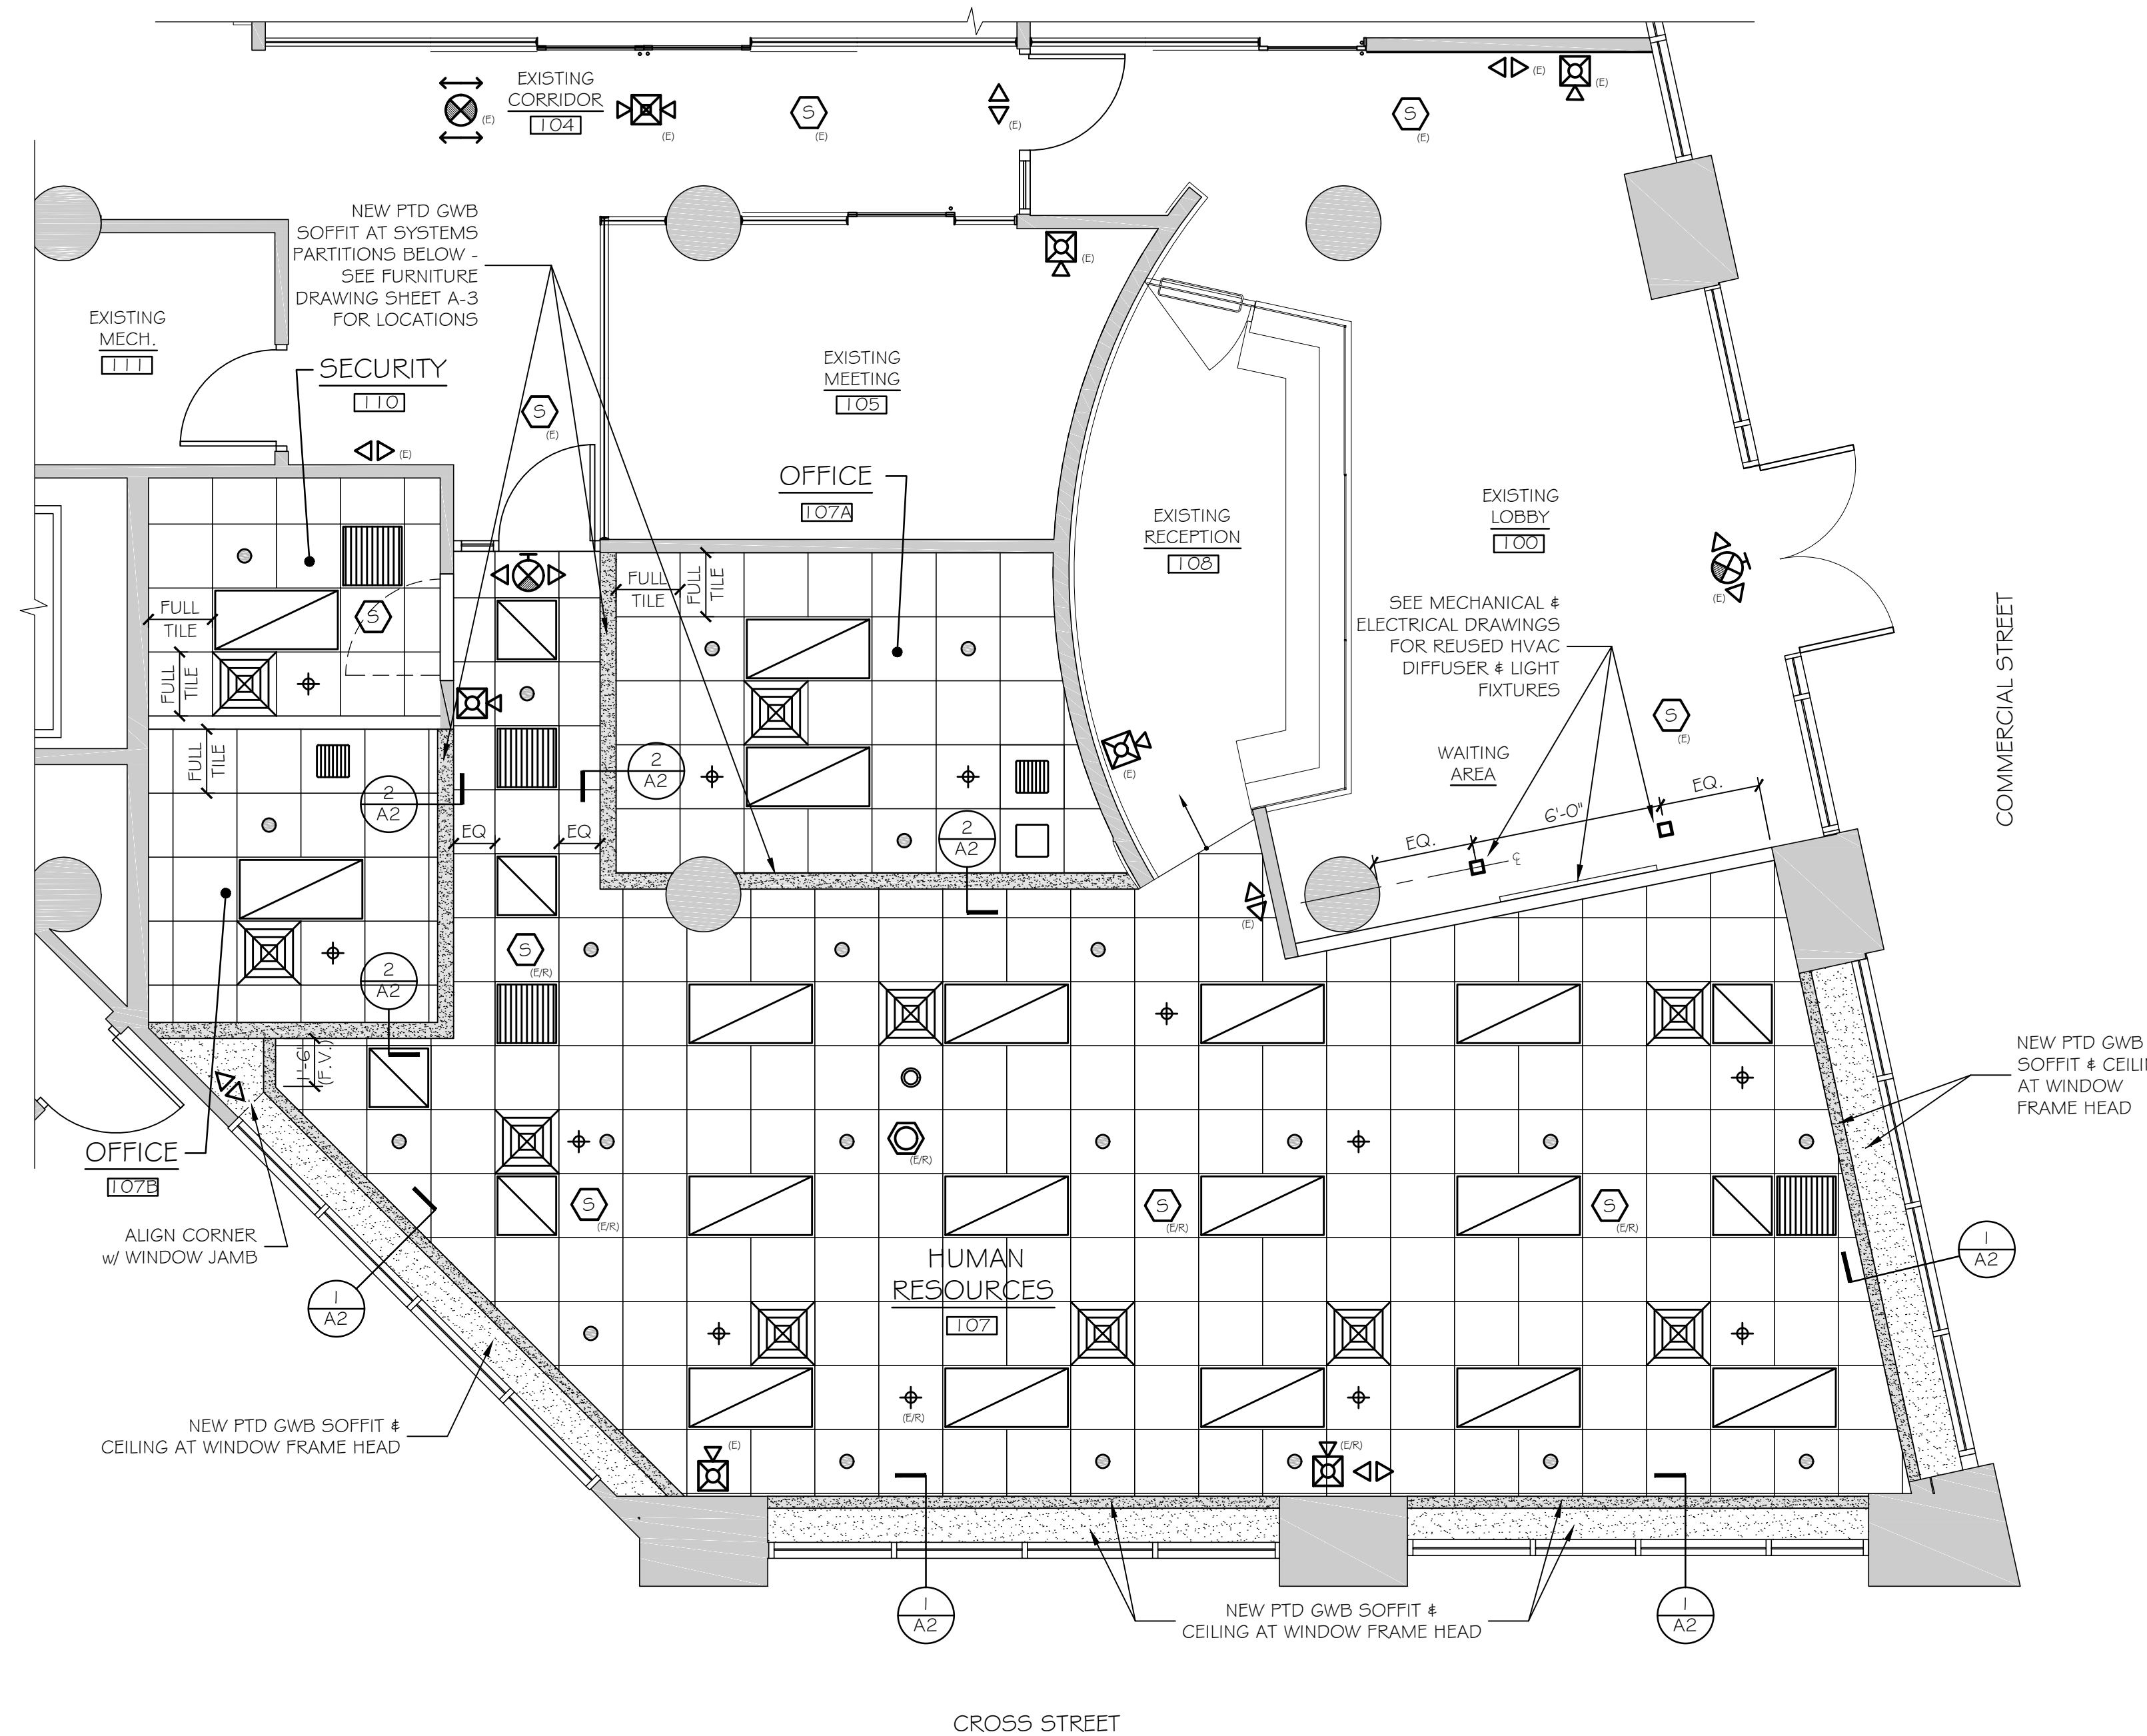

REFLECTED CEILING PLAN

SCALE: 1/4" = 1'-0"