


DRAWN	JPB UNICAD JOB #17820
CHECKED	BRADY B. HAWES NICET III 138751
DATE	12/19/2017
REVISION	0
SCALE	1/4"=1'-0"

608 & 610 CONGRESS STREET
 PORTLAND, MAINE 04101
 THIRD FLOOR FIRE ALARM PLAN

SEACOAST SECURITY
 4 Summer Street - Freeport, Maine 04032
 Office: (207) 706-3369 • Fax: (207) 865-0852

REVISION	DESCRIPTION	DATE
0	ISSUED FOR REVIEW & APPROVAL	12/19/2017

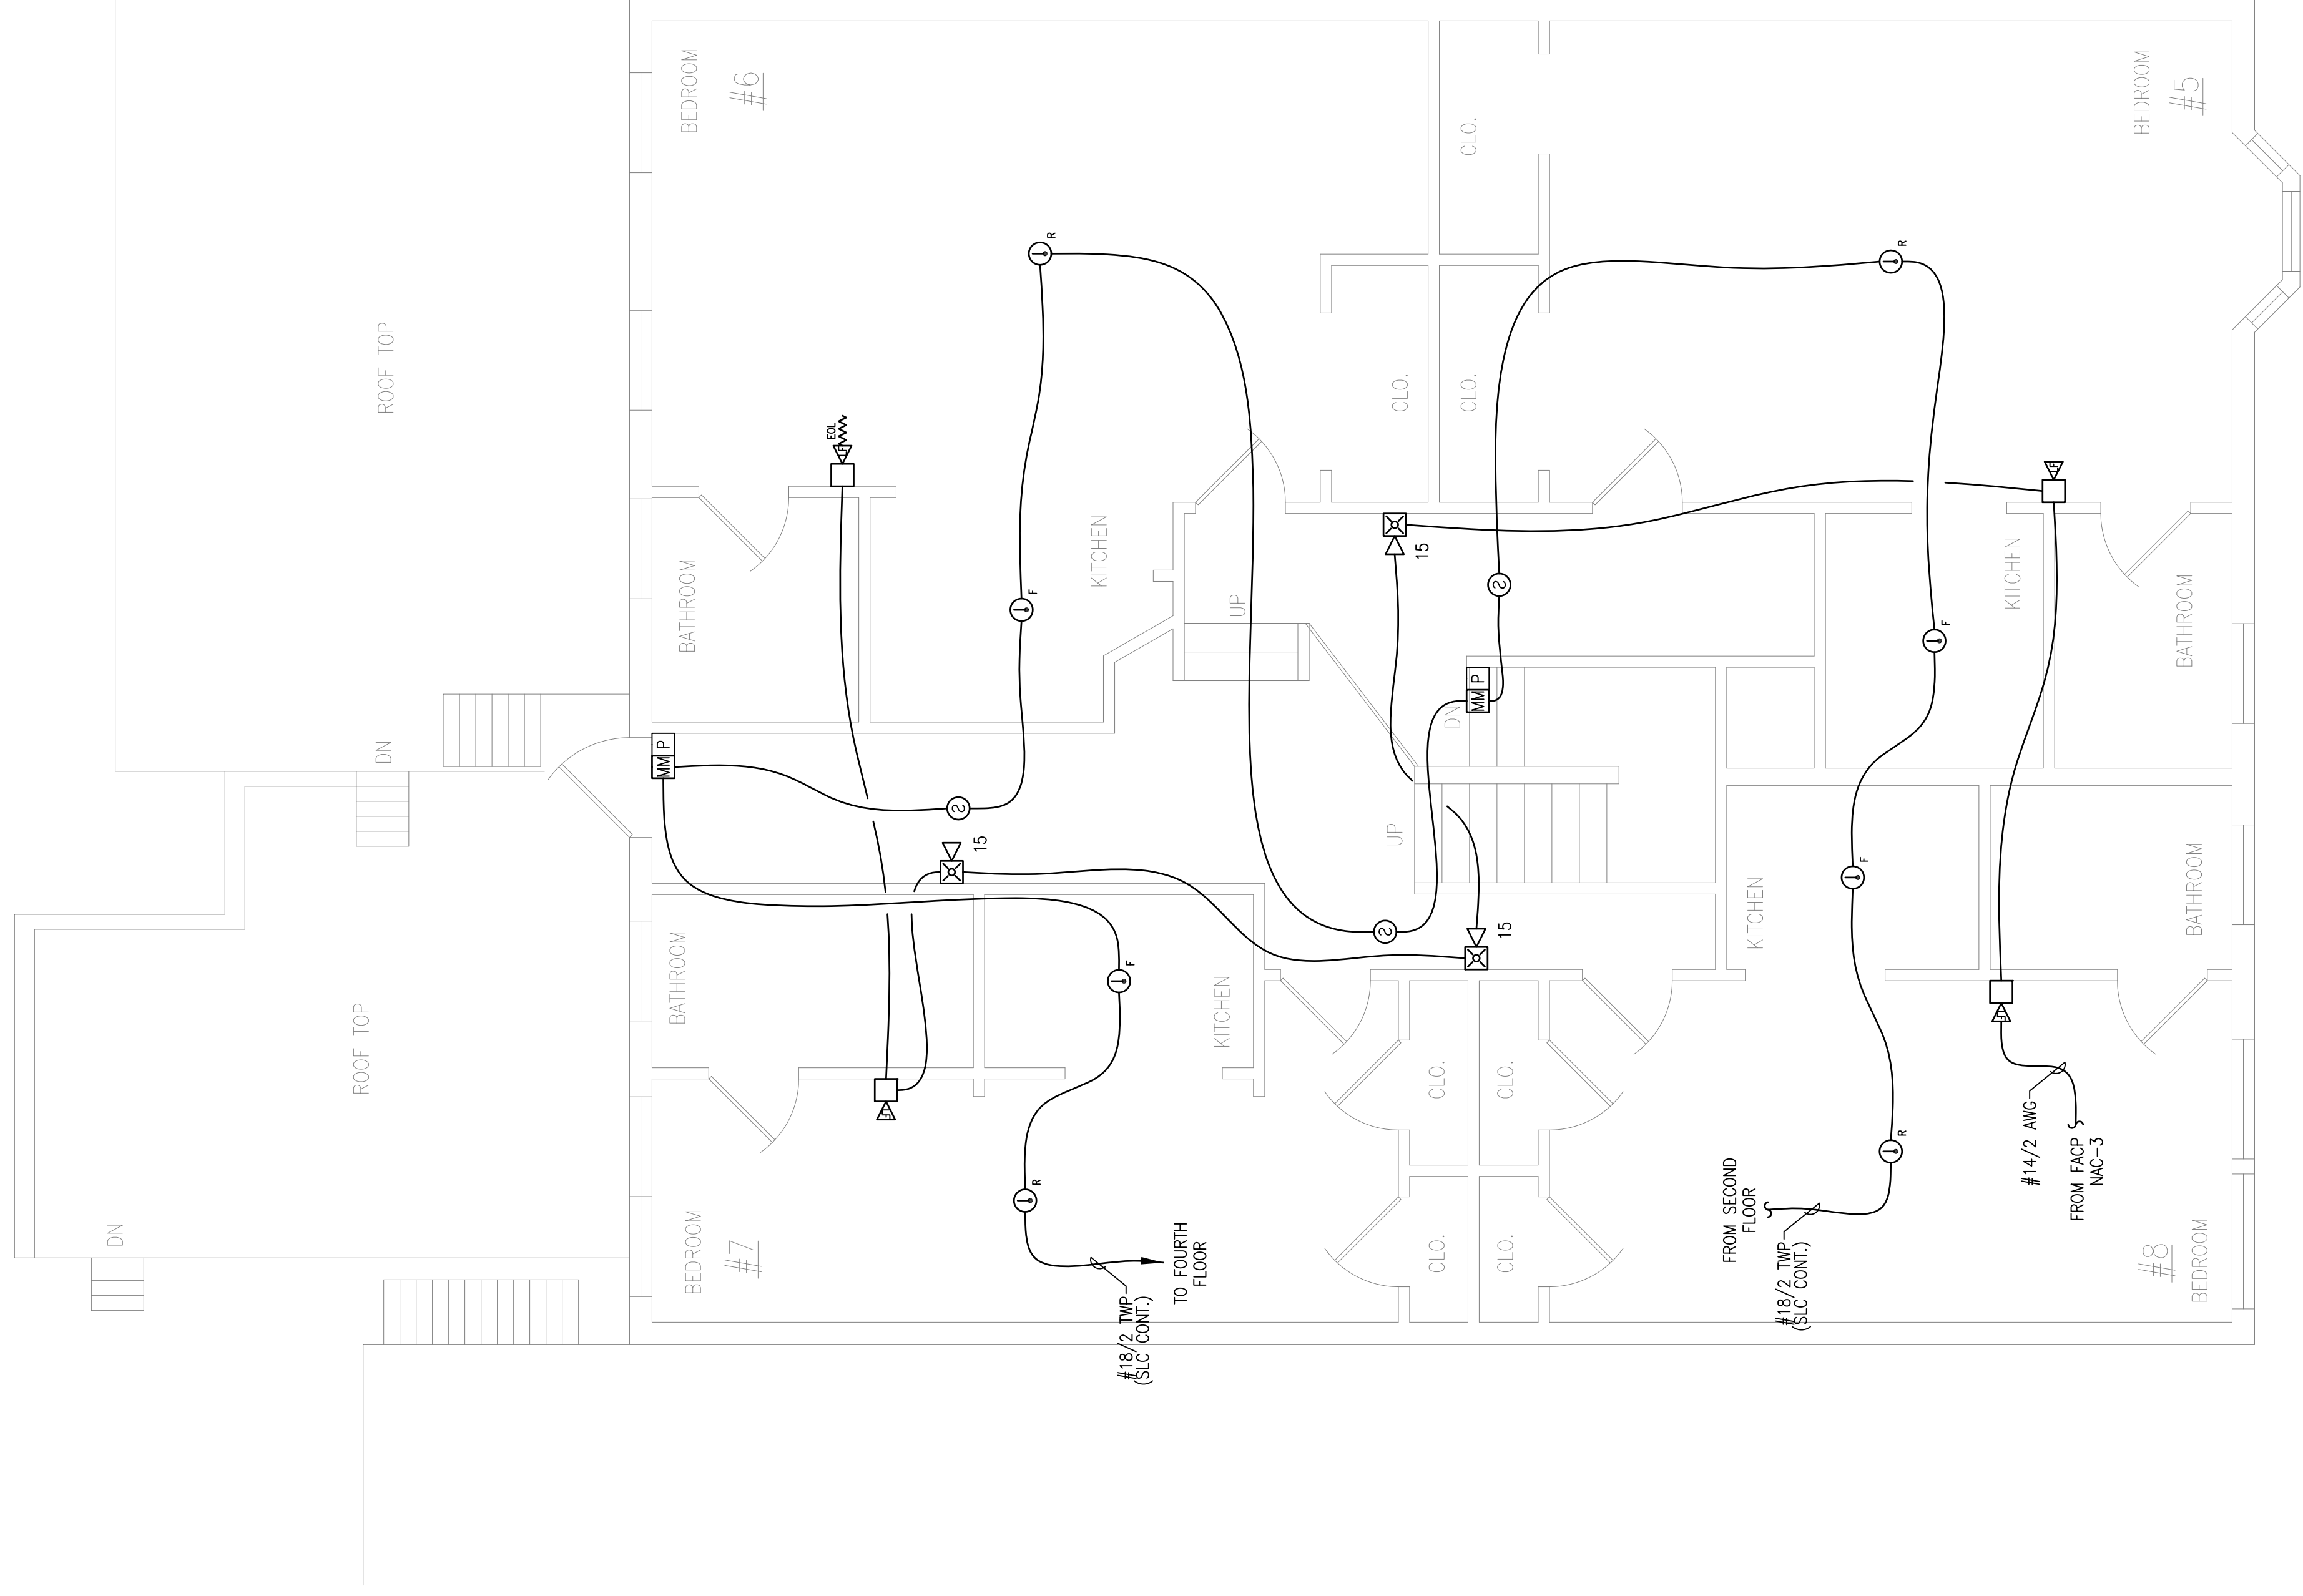

PLAN NORTH
 THIRD FLOOR FIRE ALARM PLAN
 SCALE: 1/4"=1'-0"

RESERVED FOR CITY STAMP