


REVISION	DESCRIPTION	DATE
0	ISSUED FOR REVIEW & APPROVAL	12/19/2017

RESERVED FOR CITY STAMP

SEACOAST SECURITY
 4 Summer Street • Freeport, Maine 04032
 Office: (207) 706-3369 • Fax: (207) 865-0852




**608 & 610 CONGRESS STREET
 PORTLAND, MAINE 04101
 FOURTH FLOOR FIRE ALARM PLAN**

DRAWN	JPB UNICAD JOB #17820
CHECKED	BRADY B. HAWES NICET III 138751
DATE	12/19/2017
REVISION	0
SCALE	1/4"=1'-0"

FA-6

UNICAD Inc.
 Fire Alarm Design & Drafting Services
 579 W. 40th St.
 Portland, ME 04102
 Office: 601.865.6410
 www.unicad.net

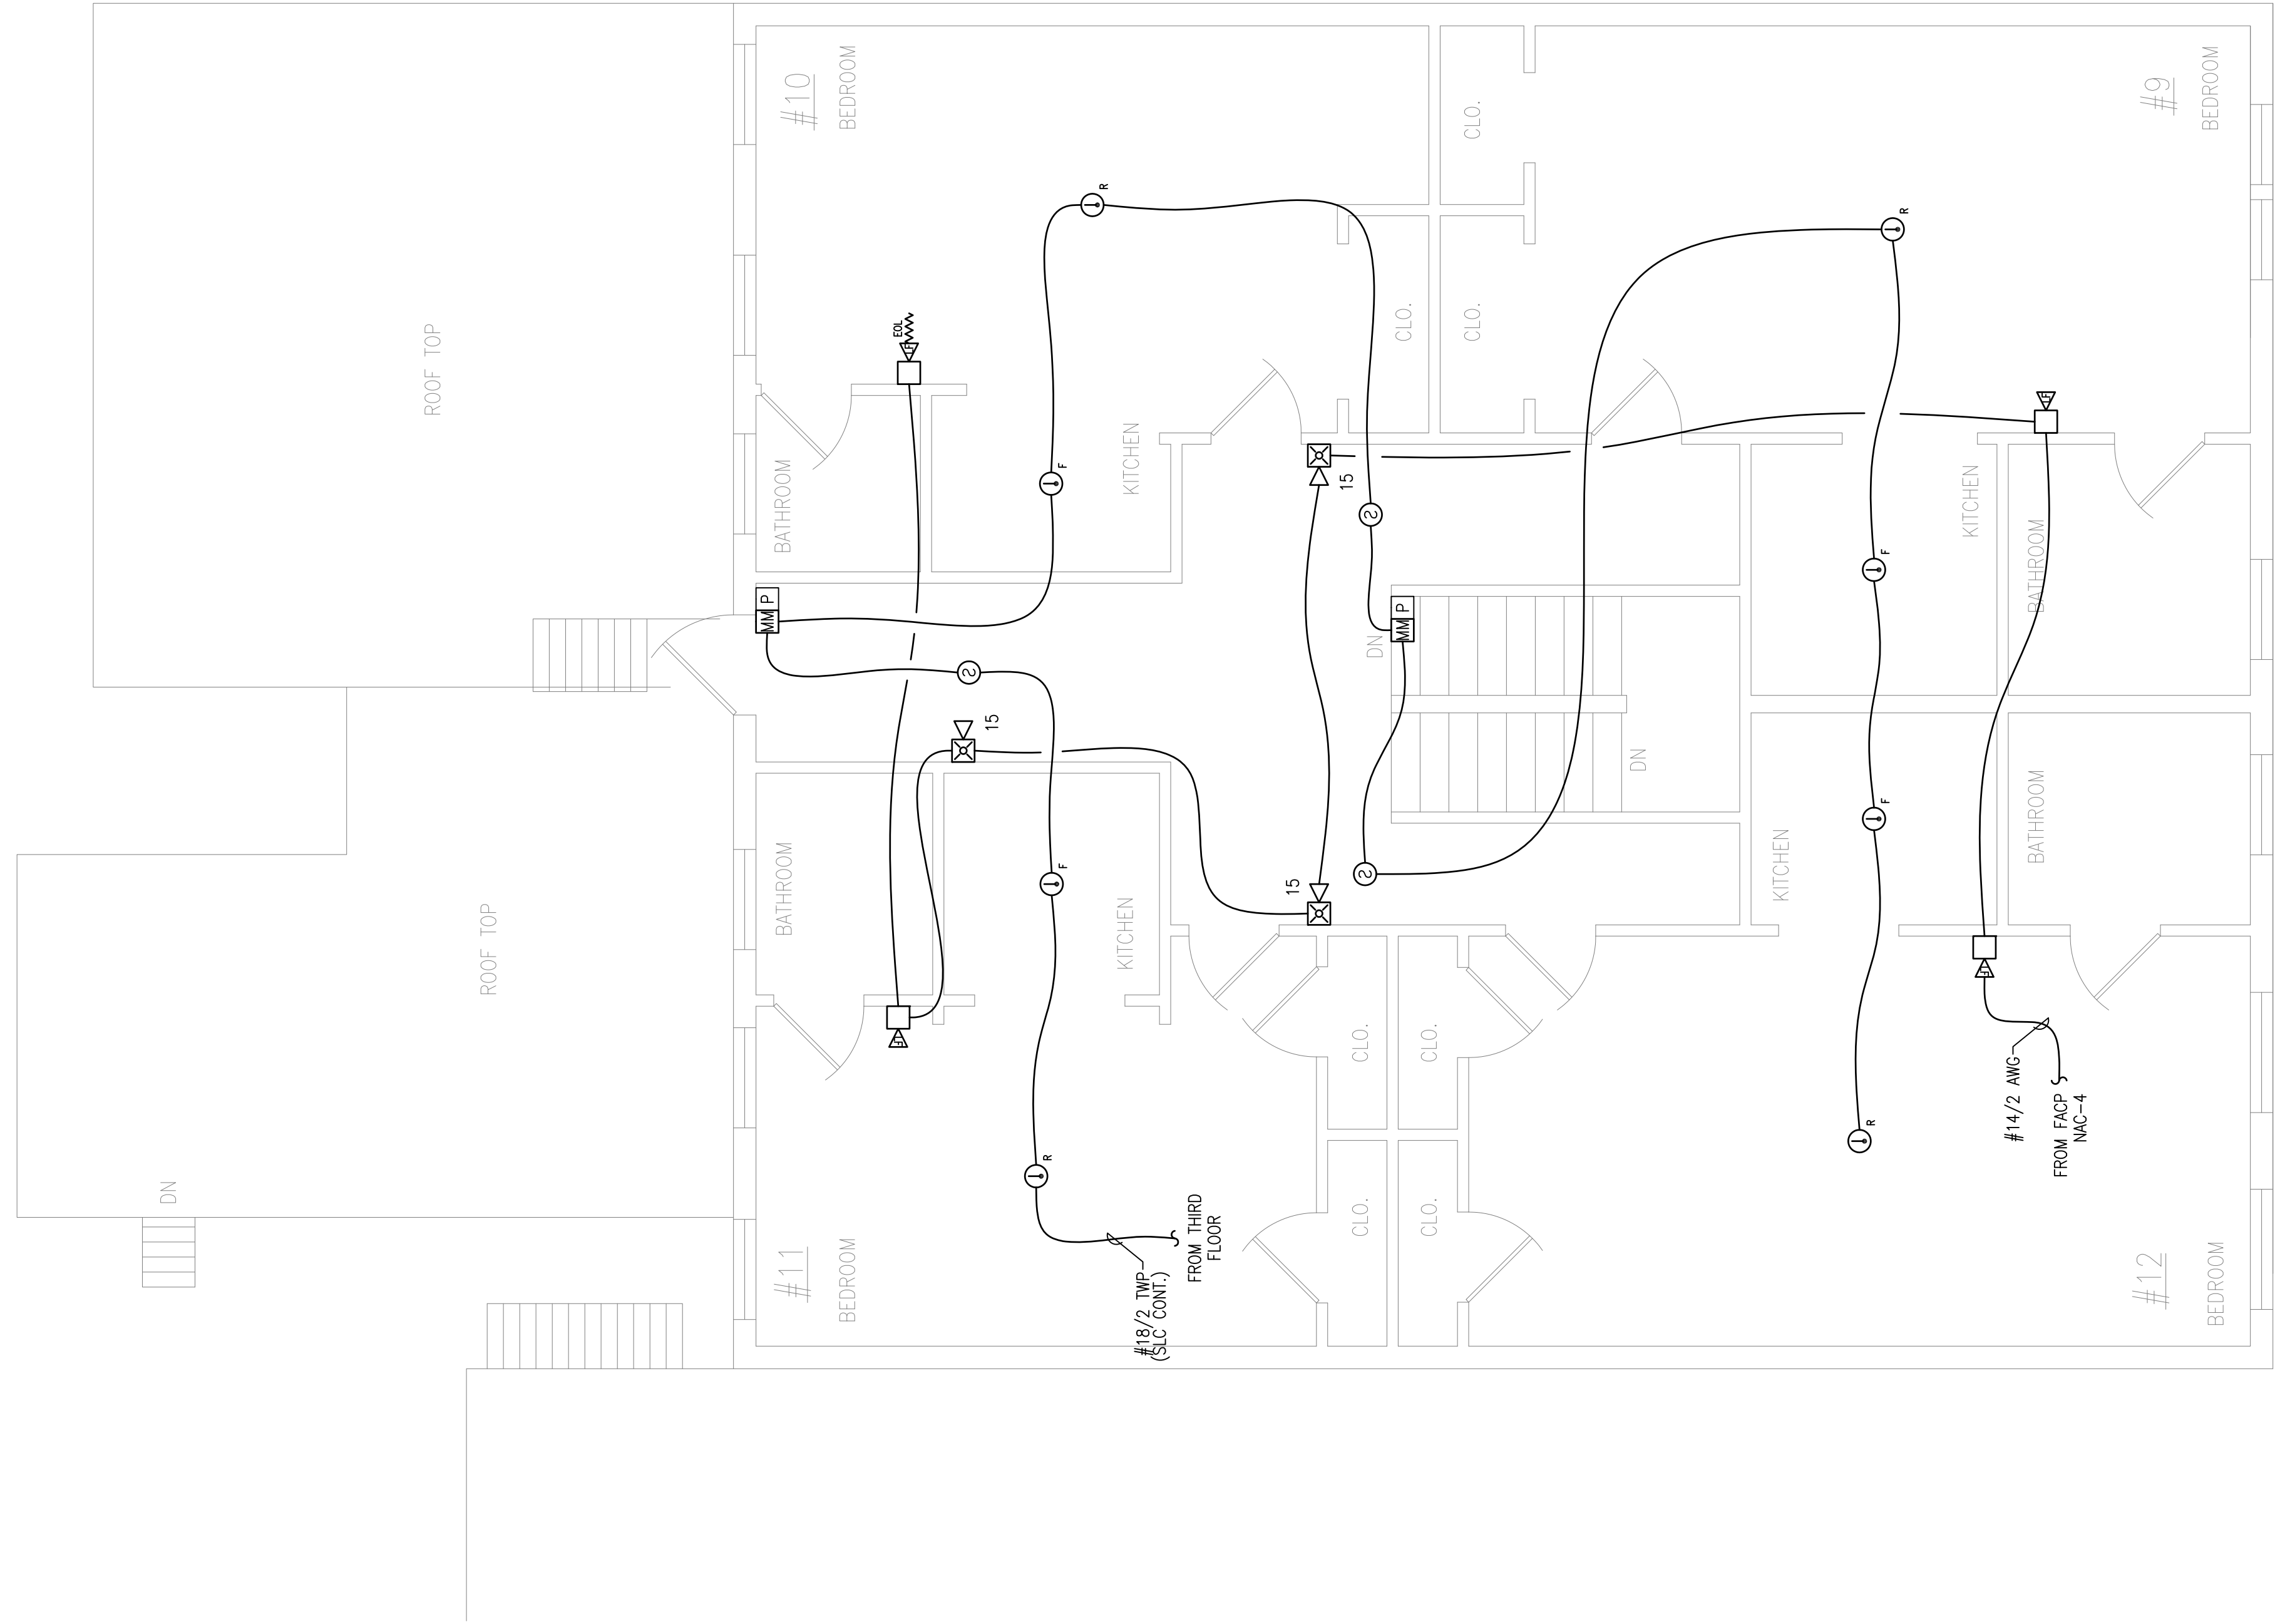

P.M.A. NORTH
FOURTH FLOOR FIRE ALARM PLAN
 SCALE: 1/4"=1'-0"