

project name

Frye bldg.
44 Oak st.

goduti/thomas architects

44 oak st.

portland, maine 04101


ph. 207-775-3184

fax 207-774-0846

notes

1. building is equipped with a 13 monitored sprinkler system
2. building is equipped with a fire alarm system
3. the space has a HVAC system gas fired installed 2006
4. There is no Asbestos, removed 1985
5. There are no dropped ceilings in basement. There are soffited areas to cover HVAC on 1st floor, otherwise ceiling is open to be tin ceiling attached to 2nd floor structure which will remain.

FREE ST.

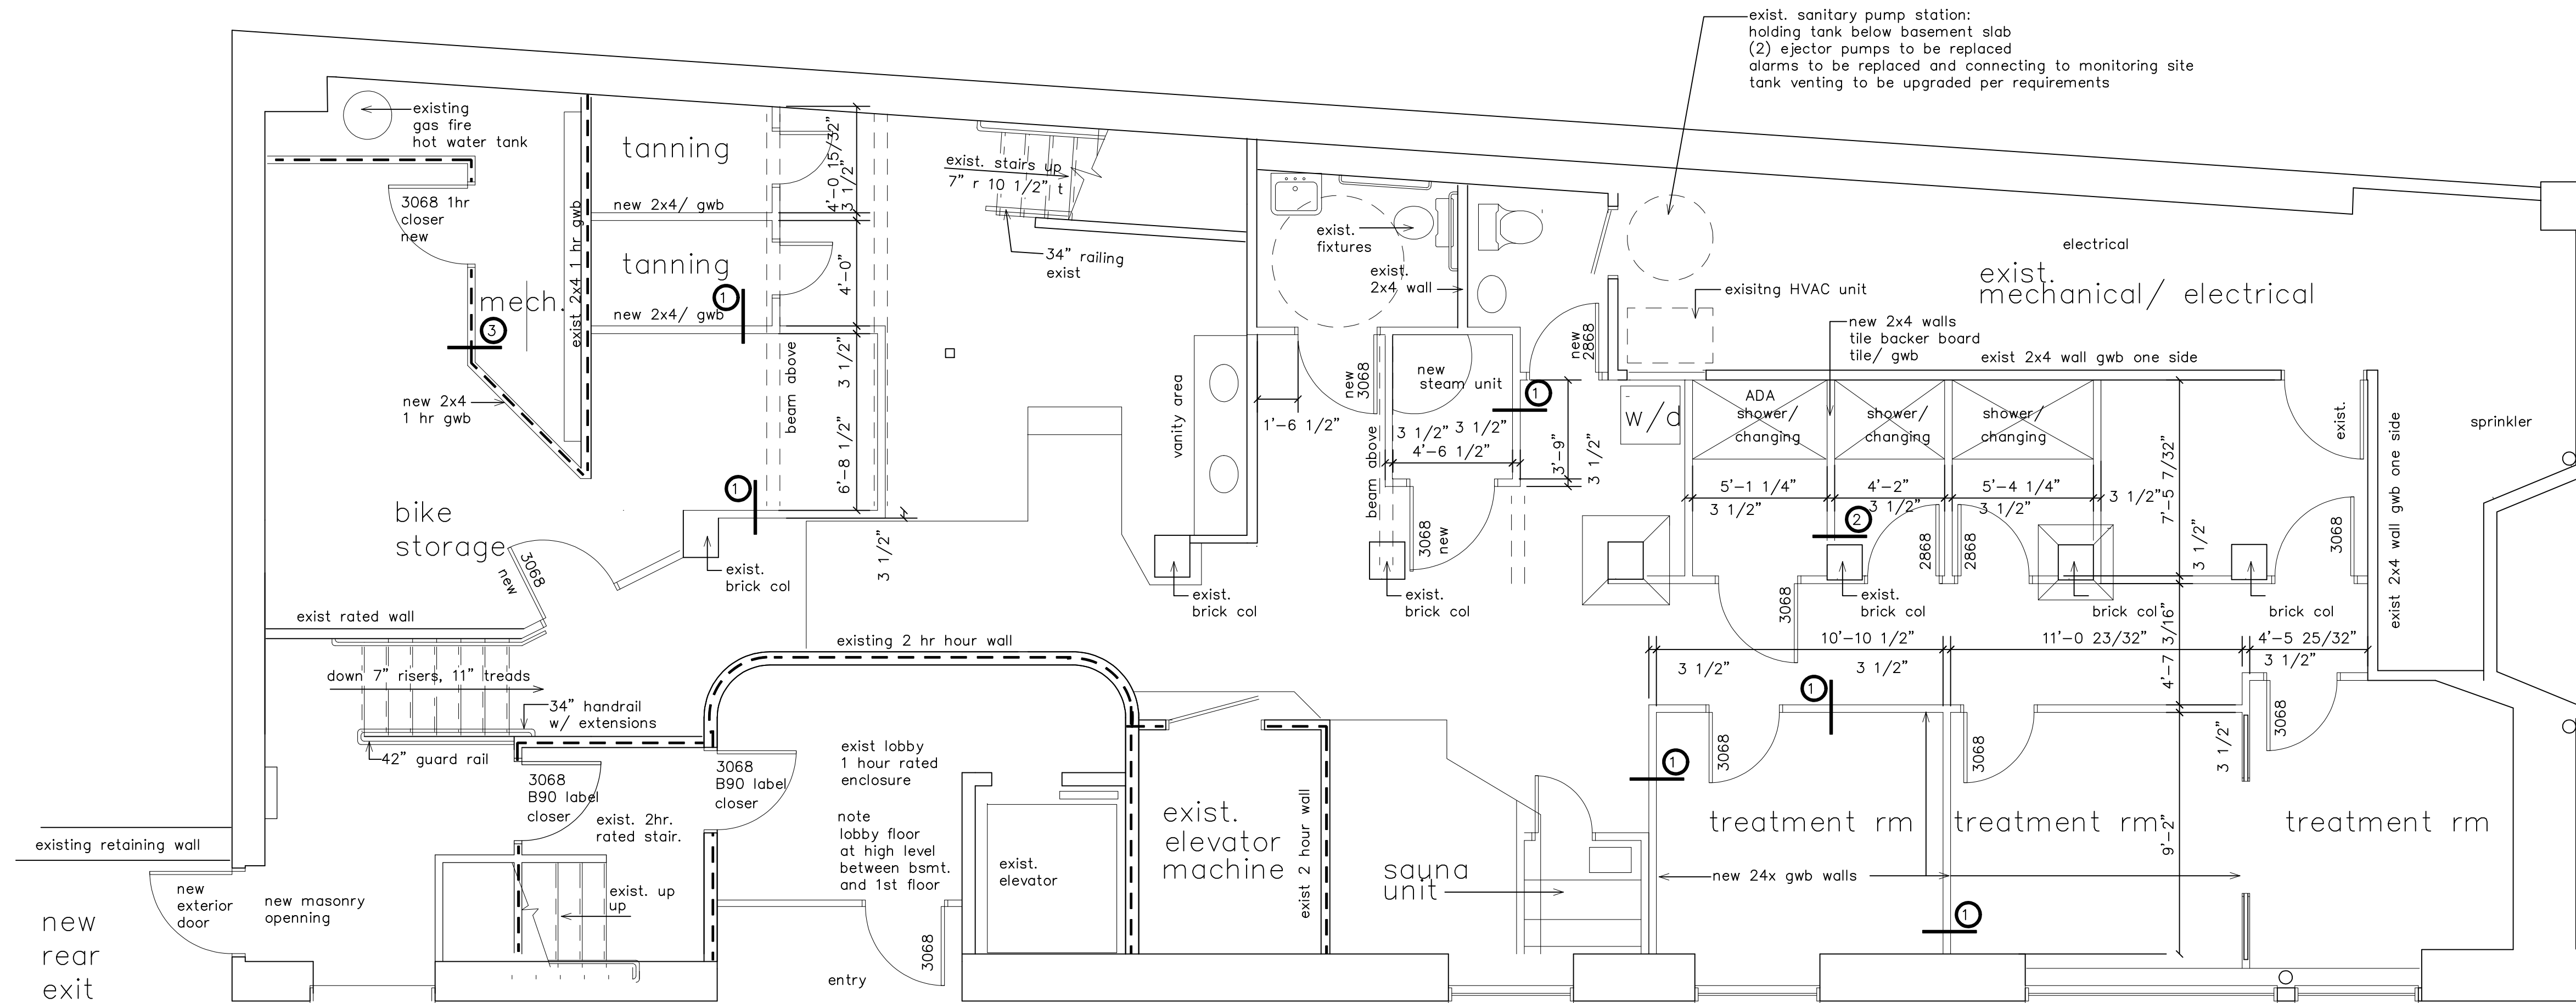

OAK ST.

9/10/08

 
revisions

date

August 4, 2008

sheet title

basement floor plan



scale

1/8"=1'-0"

drawn by

RG

project number

frye

sheet number

A1.2