

project name

Frye bldg.
44 Oak st.

goduti/thomas architects

44 oak st.

portland, maine 04101

ph. 207-775-3184

fax 207-774-0846

notes

1. building is equipped with a 13 monitored sprinkler system

2. building is equipped with a fire alarm system

exit sign w/ battery back-up

emergency lighting w/ battery back-up

PS fire alarm pull station

ceiling mount

pendant light

wall light

fluorescent strip

track

revisions

date
August 4, 2008

sheet title

bsmt. floor electrical plan

0' 1' 4' 8' 16'


scale
1/8"=1'-0"

drawn by
RG

project number
frye

sheet number

E1.2

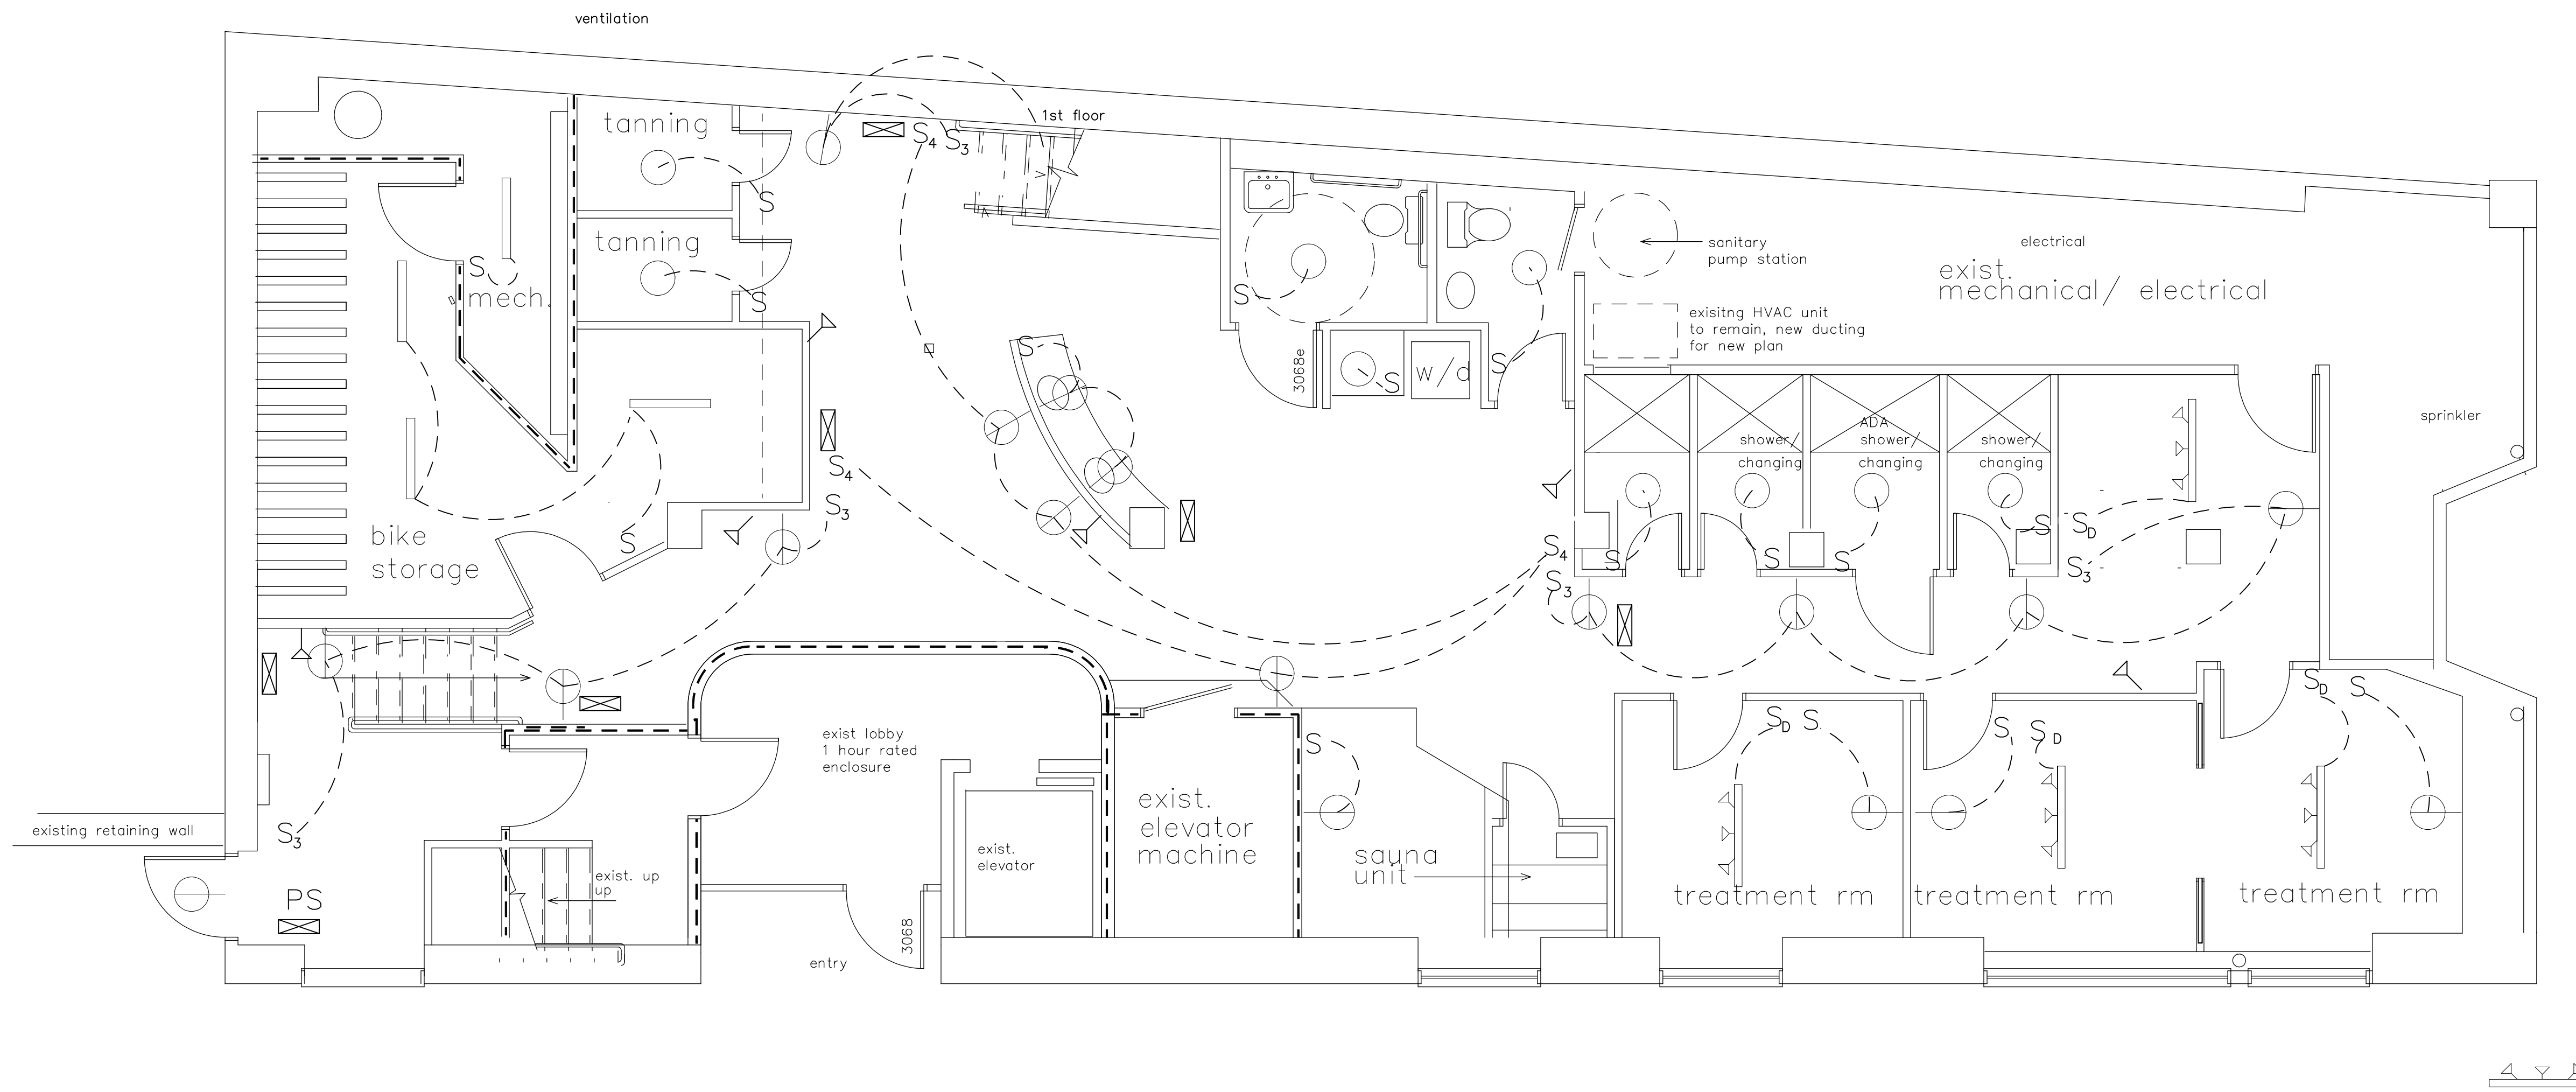

FREE ST.

OAK ST.