

project name

Frye bldg.
44 Oak st.

goduti/thomas architects

44 oak st.

portland, maine 04101

ph. 207-775-3184

fax 207-774-0846

notes

1. building is equipped with a 13 monitored sprinkler system
2. building is equipped with a fire alarm system
3. receptacles per code by electrician/ tenant system

exit sign w/
battery back-up

emergency lighting
w/ battery back-up

PS fire alarm pull station

ceiling mount

pendant light

wall light

flourescent
strip

track

indirect up and down light

revisions

date
August 4, 2008

sheet title

1st floor electrical plan

0' 1' 4' 8' 16'


scale
1/8"=1'-0"

drawn by
RG

project number
frye

sheet number

E1.1

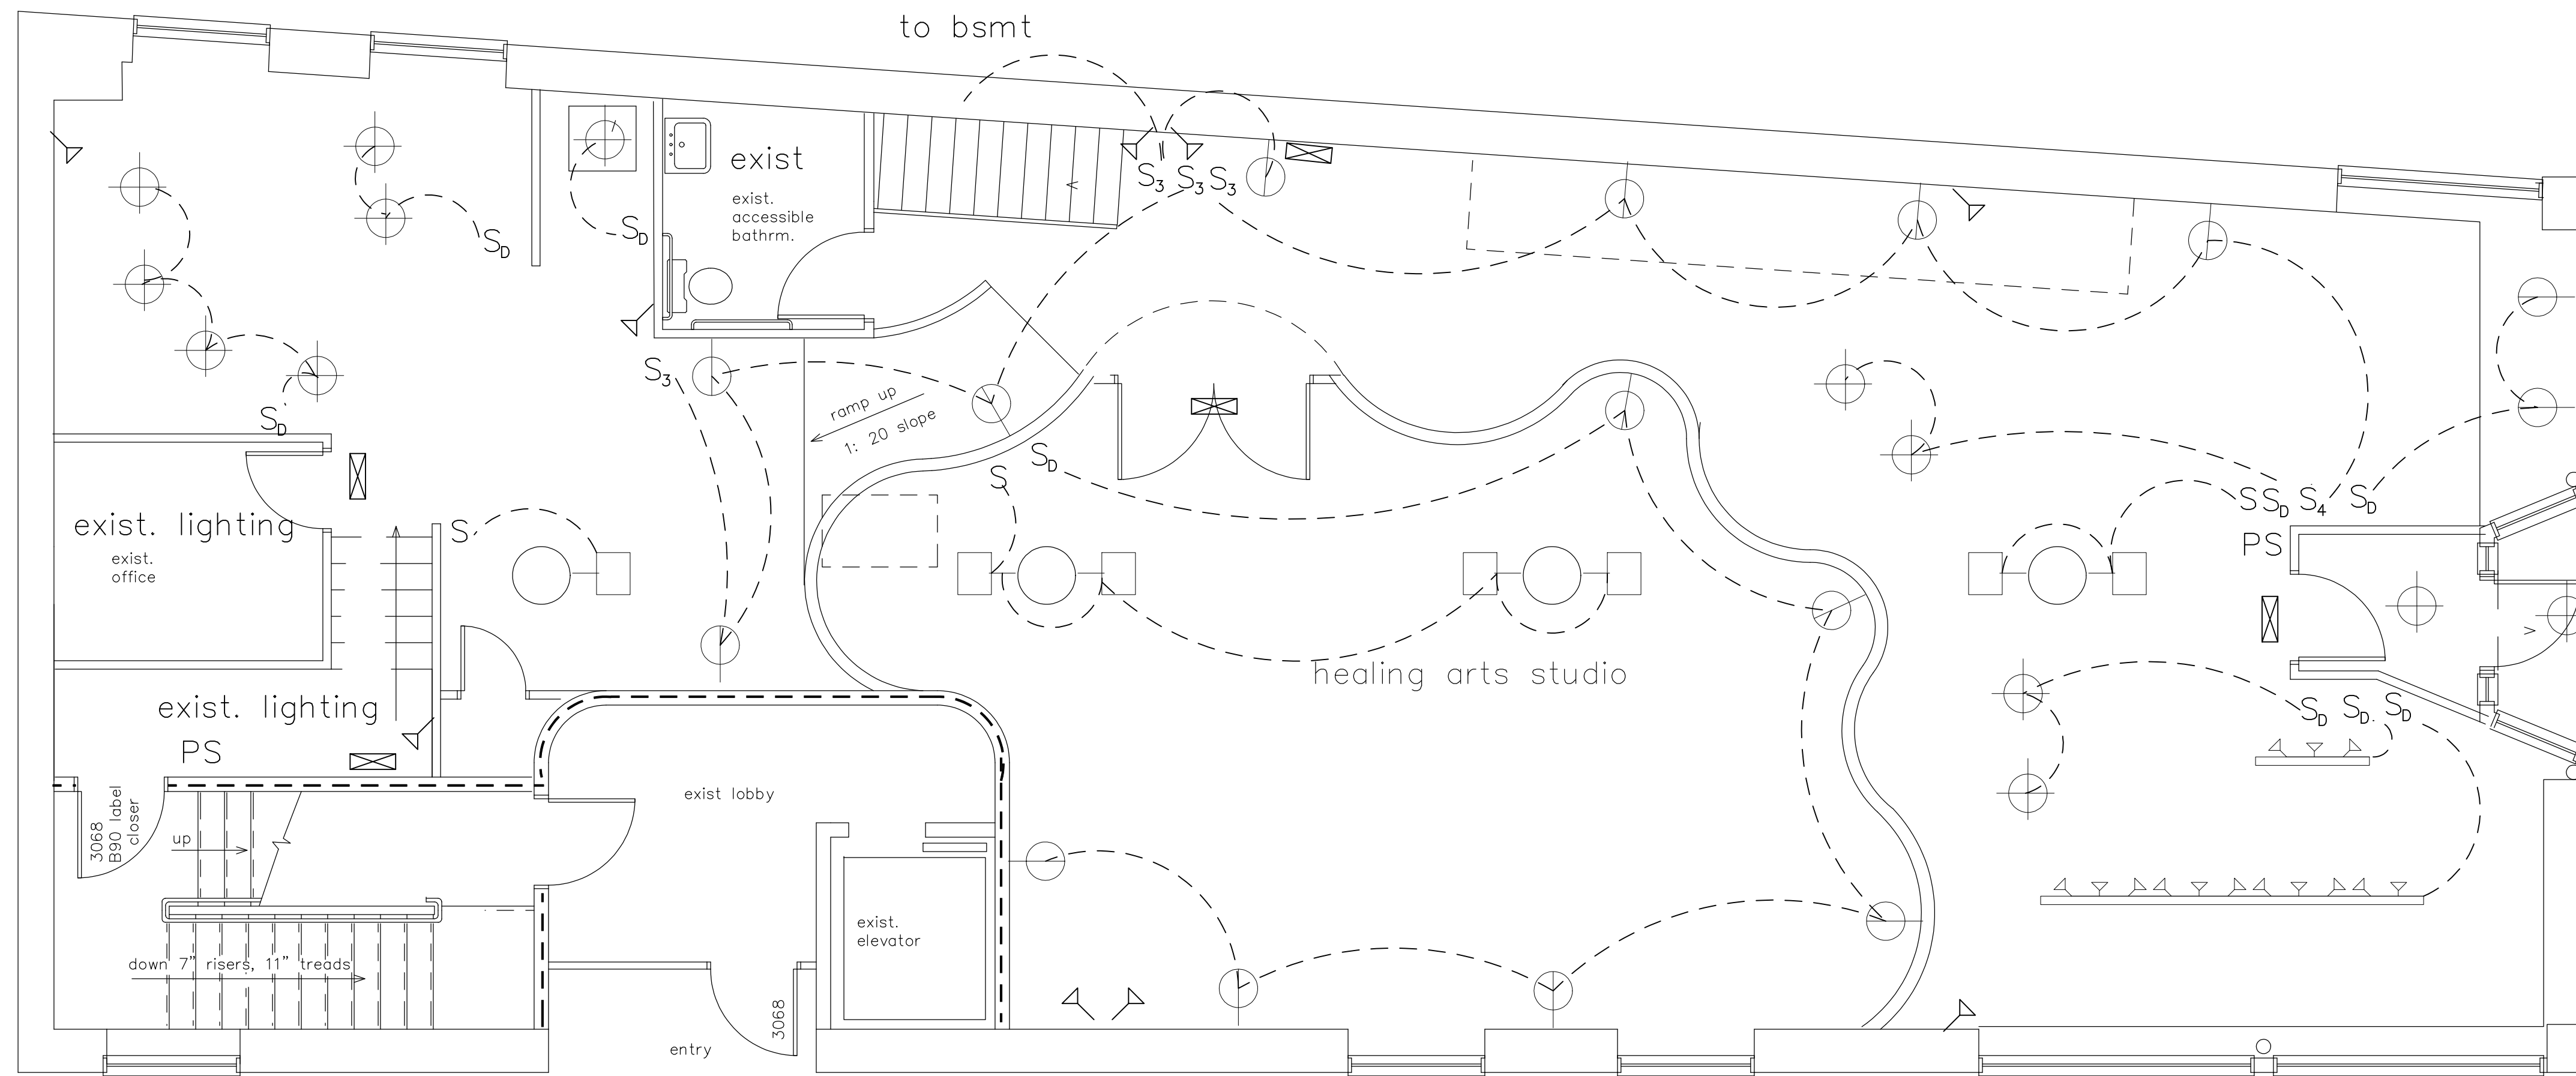

OAK ST.

FREE ST.