



**FOURTH FLOOR FIRE PROTECTION**  
 SCALE 1/4"=1'-0"  
 QUANTITY ○ = 32

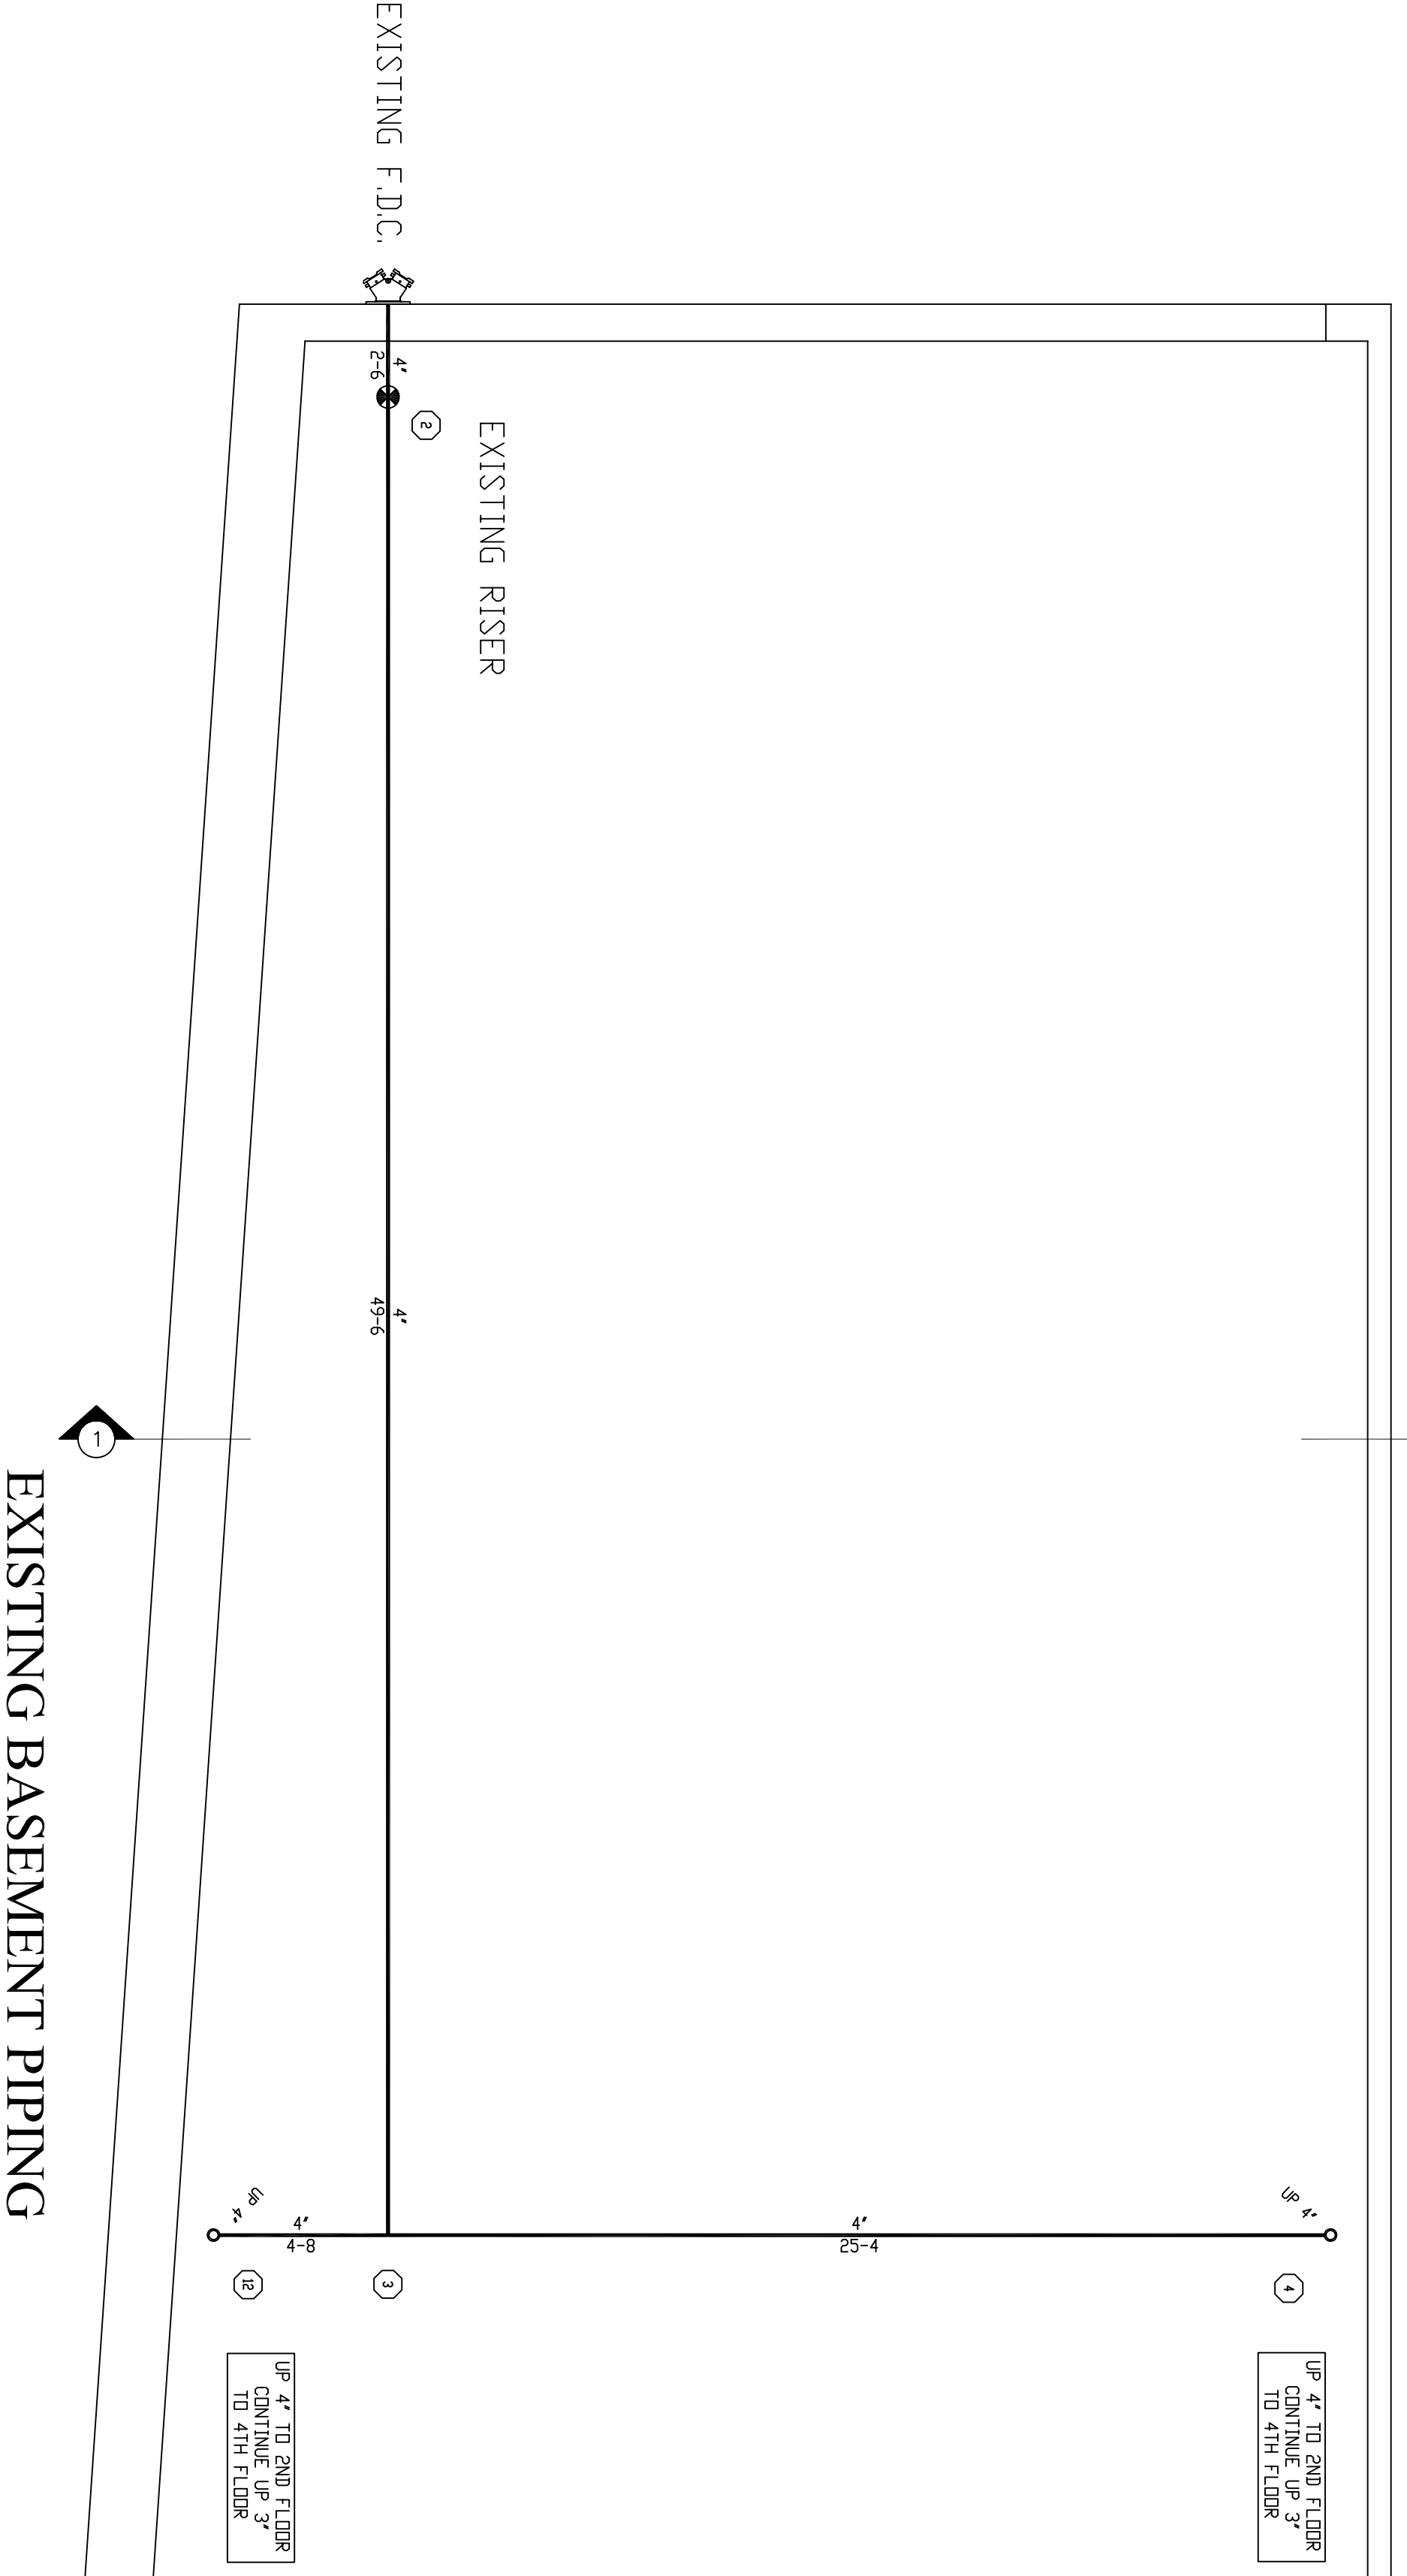

**EXISTING BASEMENT PIPING**  
 SCALE 1/4"=1'-0"

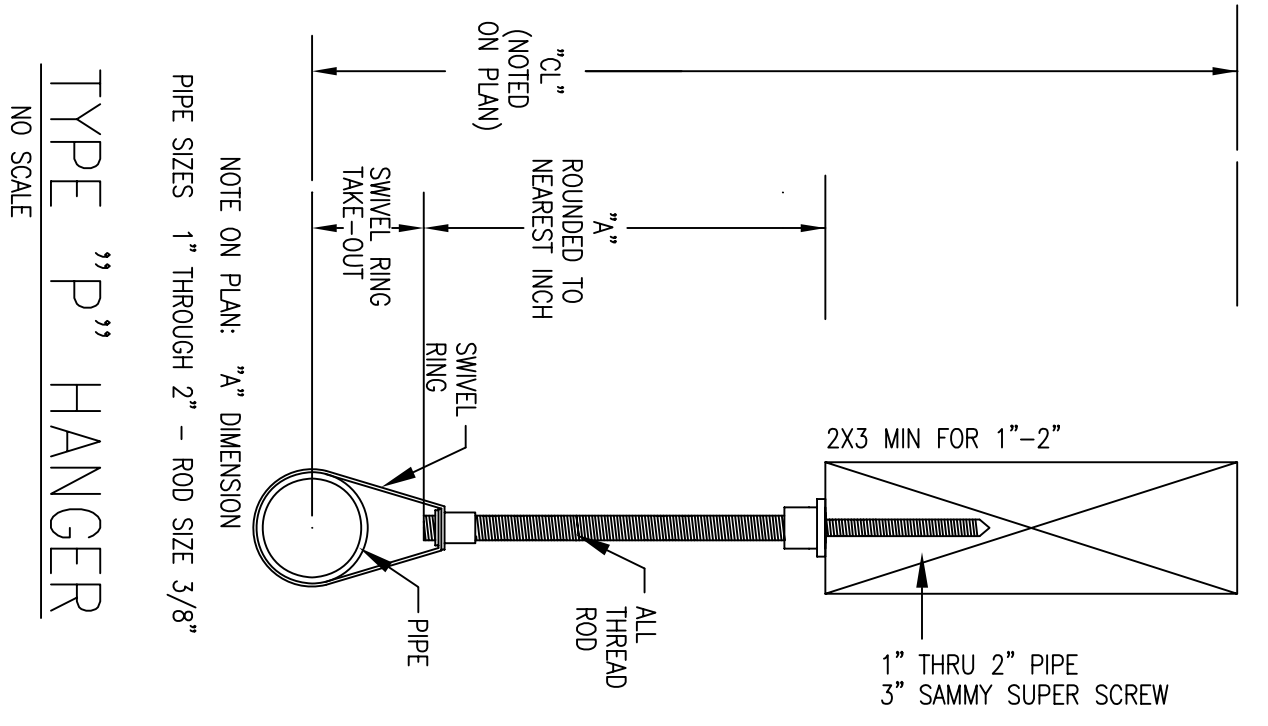

NOTE ON PLAN: "X" DIMENSION  
 PIPE SIZES: 1" THROUGH 2" - ROD SIZE 3/8"  
**TYPE "P" HANGER**  
 NO SCALE

REVISIONS	NOTES	SPRINKLER TYPE	IDENTIFICATION NO.	MFG.	ESC.	MODEL	FINISH	ORIFICE	TEMP.	SYMBOL	QUANT.
	KES6 UPRIGHT SPRINKLER COVERED 15719	QUICK RESP. UPRIGHT K-56	TT321	TRD	1/4"	TT-783	BRMS	1/2"	157	○	32

STANDARD SYMBOLS	STANDARD SYMBOLS
<ul style="list-style-type: none"> <li>POST INDICATOR VALVE</li> <li>KEY VALVE</li> <li>FIRE HYDRANT</li> <li>FIRE DEPT. CONNECTION</li> <li>O.S. &amp; G. GATE VALVE</li> <li>NEW UNDERGROUND</li> <li>EXIST UNDERGROUND</li> </ul>	<ul style="list-style-type: none"> <li>ALARM CHECK VALVE</li> <li>RISER W/ALARM VALVE</li> <li>RISER W/DRY VALVE</li> <li>RISER W/ELEC. FLOW SWITCH</li> <li>RISER W/ELEC. FLOW VALVE</li> <li>ELECTRIC BELL</li> <li>FLUSH FIRE DEPT. CONNECTION</li> </ul>

INSPECTIONS
1.
2.
3.
4.
5.

**KEON RESIDENCE**  
 44 OAK STREET  
 PORTLAND, MAINE 04101

**FIRE PROTECTION PLAN**

**FREEDOM FIRE PROTECTION, INC.**  
 209 QUAKER RIDGE ROAD  
 CASCO, MAINE 04015

JOB No.	W0222
DATE	5/7/15
DRAWN BY	MAN
SCALE	AS NOTED
SHEET No.	FP-2of3