


BASEMENT HVAC PLAN
SCALE: 1/4" = 1'-0"

This document is owned by and the
 information contained herein is the property
 of Titan Mechanical, Inc. It is to be used
 only for the project and site for which it
 was prepared. No part of this document
 may be reproduced, stored in a retrieval
 system, or transmitted in any form or
 by any means, electronic, mechanical,
 photocopying, recording, or otherwise,
 without the prior written consent of Titan
 Mechanical, Inc. and approval to reprint the
 document for other than the project.

REVISIONS	DATE


Titan Mechanical, Inc.
 Design/Build Engineering - Mechanical Contracting
 P.O. Box 39277 / 232 Riverside Industrial Parkway
 Portland, Maine 04104
 Ph. (207) 878-5223 Fax. (207) 878-5235

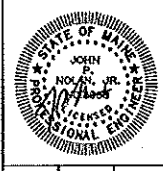

GREATER PORTLAND LANDMARKS
 CLIENT
418 HIGH STREET - PORTLAND, ME
 PROJECT
BASEMENT HVAC PLAN
 DRAWING TITLE

DATE: 12/20/2011
 SCALE: 1/4" = 1'-0"
 DRAWN BY: CJM
 CHECKED BY: JFN
 JOB NUMBER: XXXX
 CAD FILE: XXXX
 SHEET NUMBER

M1.0

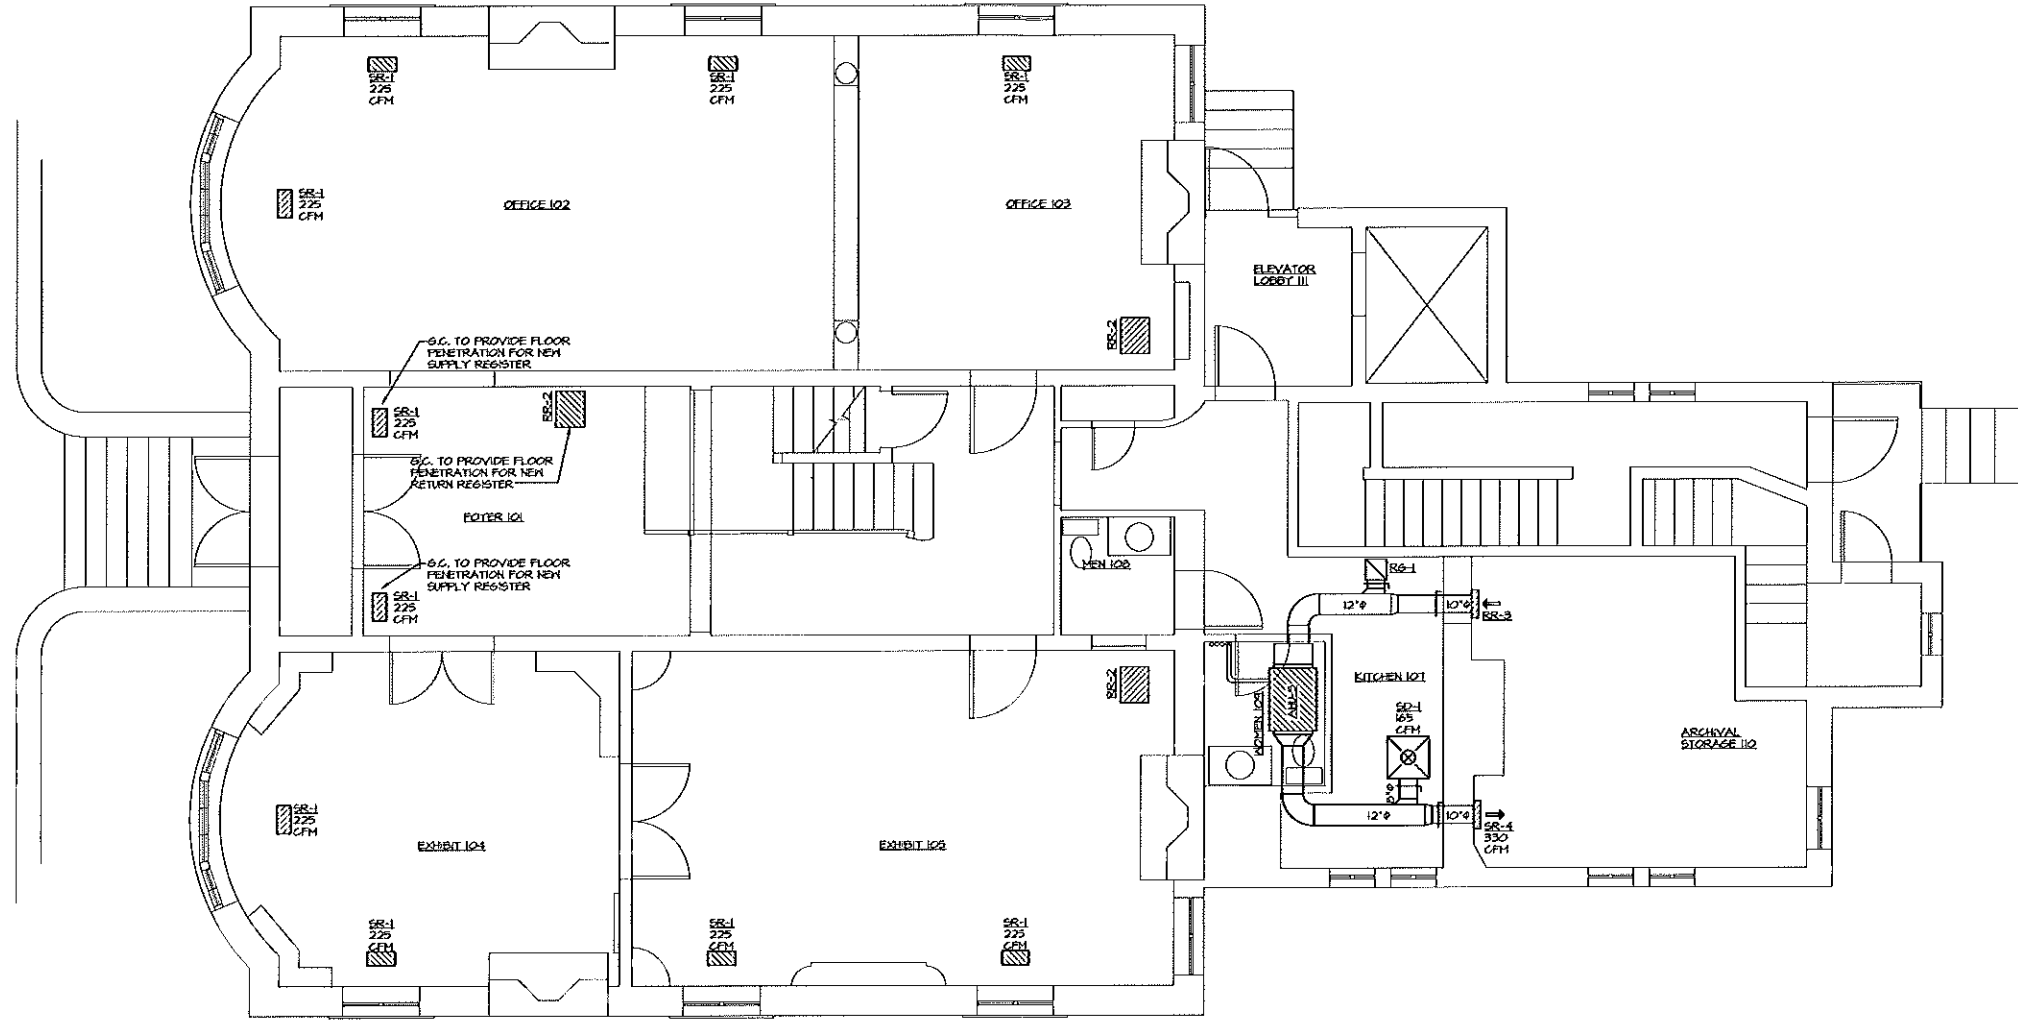


FIRST FLOOR HVAC PLAN
SCALE: 1/4" = 1'-0"

The document is owned by, and the information contained in it is proprietary to, Titan Mechanical, Inc. No part of this document may be reproduced, stored in a retrieval system, or transmitted in any form or by any means, electronic, mechanical, photocopying, recording, or by any information storage and retrieval system, without the prior written consent of Titan Mechanical, Inc. and agrees to return this document forthwith upon request.

REVISIONS	DATE

Titan Mechanical, Inc.
Design-Build Engineering - Mechanical Contracting
P.O. Box 3927 / 232 Riverside Industrial Parkway
Portland, Maine 04104
Ph. (207) 878-5223 Fax. (207) 878-5235

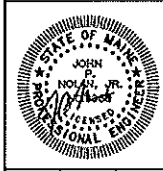

GREATER PORTLAND LANDMARKS
CLIENT
95 HIGH STREET - PORTLAND, ME
PROJECT
FIRST FLOOR HVAC PLAN
DRAWING TITLE

DATE: 12/20/2011
SCALE: 1/4" = 1'-0"
DRAWN BY: C.J.H.
CHECKED BY: J.F.N.
JOB NUMBER: XXXX
CAD FILE: XXXX
SHEET NUMBER

M1.1
SHEET 2 OF 5

VRF AIR CONDITIONER SCHEDULE (INDOOR UNITS)																	
TAG	AREA SERVED	V/F/Hz	WATTS	STYLE	NOM. COOLING (TONS)	COOLING CAPACITY (BTU/HR)	HEATING CAPACITY (BTU/HR)	AIRFLOW (CFM)	PIPE CONNECTIONS			DIMENSIONS			ASSOCIATED OUTDOOR UNITS	MODEL	REMARKS
									RL	RS	G	W	H	D			
AHU-1	STORAGE B01	208/1/60	40	WALL MOUNTED	1/2	1,500	8,500	200	1/4"	1/2"	-	-	-	-	L6 ARNU0735EL2	-	
AHU-2	FOYER 101	208/1/60	150	CEILING CONCEALED	2	24,200	21,300	670	3/8"	5/8"	-	-	-	-	L6 ARNU243BHA2	-	
AHU-3	EXHIBIT 104, EXHIBIT 105	208/1/60	450	CEILING CONCEALED	2 1/2	28,000	31,500	900	3/8"	5/8"	-	-	-	-	L6 ARNU283BGA2	-	
AHU-4	OFFICE 102, OFFICE 103	208/1/60	450	CEILING CONCEALED	2 1/2	28,000	31,500	900	3/8"	5/8"	-	-	-	-	L6 ARNU283BGA2	-	
AHU-5	STORAGE 110	208/1/60	150	CEILING CONCEALED	1 1/2	19,100	21,500	500	1/4"	1/2"	-	-	-	-	L6 ARNU183BGA2	-	
AHU-6	OFFICE 201, CONF. 204	208/1/60	450	CEILING CONCEALED	2	24,200	21,300	670	3/8"	5/8"	-	-	-	-	L6 ARNU243NJA2	-	
AHU-7	OFFICES 202, 203, 206	208/1/60	450	CEILING CONCEALED	2 1/2	28,000	31,500	900	1/4"	1/2"	-	-	-	-	L6 ARNU283BGA2	-	
AHU-8	OFFICES 201, 208	208/1/60	150	CEILING CONCEALED	1 1/2	19,100	21,500	500	1/4"	1/2"	-	-	-	-	L6 ARNU183BGA2	-	
AHU-9	STORAGE 214	208/1/60	150	CEILING CONCEALED	1 1/2	19,100	21,500	500	1/4"	1/2"	-	-	-	-	L6 ARNU183BGA2	-	
AHU-10	OFFICES 302, 304, 306	208/1/60	120	VERTICAL CONCEALED	2	24,000	21,000	710	3/8"	5/8"	-	-	-	-	L6 ARNU243NJA2	-	
AHU-11	OFFICES 305, 307	208/1/60	120	VERTICAL CONCEALED	2	24,000	21,000	710	3/8"	5/8"	-	-	-	-	L6 ARNU243NJA2	-	
AHU-12	OFFICES 311, 312	208/1/60	150	CEILING CONCEALED	1 1/2	19,100	21,500	500	1/4"	1/2"	-	-	-	-	L6 ARNU183BGA2	-	
AHU-13	BASEMENT	208/1/60	-	WALL MOUNTED	2	24,200	21,300	500	-	-	-	-	-	-	L6 ARNU24355L2	-	

GRILLES, REGISTERS, & DIFFUSER SCHEDULE						
TAG	NECK (INCHES)	FACE SIZE (INCHES)	CFM	SF (A/G)	THROW (FEET)	REMARKS
SR-1	-	16"x8"	0-225	0.05	-	FLOOR SUPPLY REGISTER REGGIO REGISTER MODEL 816
SR-2	-	24"x8"	226-350	0.05	-	FLOOR SUPPLY REGISTER REGGIO REGISTER MODEL 824
SR-3	-	12"x6"	0-250	0.05	-	HALL SUPPLY REGISTER W/ OBD DOUBLE DEFLECTION, 3/4" SPACING
SR-4	-	14"x8"	251-400	0.05	-	HALL SUPPLY REGISTER W/ OBD DOUBLE DEFLECTION, 3/4" SPACING
SD-1	8"x8"	24x24	0-250	0.05	-	ANEMOSTAT EPL, LAY-IN STYLE
SD-2	10"x8"	24x24	251-400	0.05	-	ANEMOSTAT EPL, LAY-IN STYLE
RR-1	-	22"x11"	0-500	0.05	-	REGGIO REGISTER MODEL 1122
RR-2	-	20.5"x16.5"	501-400	0.05	-	REGGIO REGISTER MODEL 1620
RR-3	-	20"x8"	0-275	0.05	-	CEILING RETURN REGISTER W/ OBD 3/4" SPACING, 45 DEFLECTION
RR-4	-	24"x10"	276-400	0.05	-	CEILING RETURN REGISTER W/ OBD 3/4" SPACING, 45 DEFLECTION
R6-1	-	12"x12"	0-300	0.05	-	3/4" SPACING, 45 DEFLECTION
R6-2	-	24"x24"	301-1000	0.05	-	3/4" SPACING, 45 DEFLECTION

WATER SOURCE VRF AIR CONDITIONER SCHEDULE														
TAG	SERVES	V/F/Hz	MCA	MOCP	COOLING CAPACITY (BTU/HR)	HEATING CAPACITY (BTU/HR)	REFRIGERANT	PIPE CONNECTIONS		DIMENSIONS			MODEL	REMARKS
								RL	RS	W	H	D		
HP-1A	BUILDING	208/3/60	45	60	144,000	137,000	R-410A	-	-	-	-	-	L6 ARNE144BA2	TWINNED W/ HP-1B
HP-1B	BUILDING	208/3/60	45	60	144,000	137,000	R-410A	-	-	-	-	-	L6 ARNE144BA2	TWINNED W/ HP-1A

FLUID COOLER SCHEDULE								
TAG	SERVES	ELECTRICAL	HP	FLOW (GPM)	PRESSURE DROP (FT H ₂ O)	MANUFACTURER	MODEL	REMARKS
FC-1	WHP-1	208/3/60	5.0	85	4.5	EVAPCO	LRNB	-

GAS BOILER SCHEDULE												
TAG	SERVES	INPUT (MBH)	OUTPUT (MBH)	EFF. (%)	FUEL	BURNER (FT ³ /MIN)	SIZE (LXWXH)	VENT SIZE (IN Ø)	HEIGHT (FOUNDS)	ELECTRIC	MOD. NO.	REMARKS
B-1	BUILDING HW/R	150	-	90+	NG	-	-	3" INTAKE 3" VENT	-	115/160	HIP ELITE 150	-


EXPANSION TANK SCHEDULE									
TAG	SERVES	REQ'D ACCEP. VOL. (GAL)	ACCEP. VOL. (GAL)	MAX TEMP (°F)	MAX PRESSURE (PSIG)	DIA. (IN)	HEIGHT (IN)	MODEL	REMARKS
ET-1	CONDENSER WATER LOOP	-	-	-	-	-	-	AMTROL	-

PUMP SCHEDULE										
TAG	SERVES	TYPE	GPM	HEAD	HP	RPM	ELECTRIC	HEIGHT (FOUNDS)	MOD. NO.	REMARKS
CP-1	BOILER B-1	INLINE	20	15'	1/8	3250	115/160	12.0	TACO 001B IFC	-
CP-2	CONDENSER WATER	INLINE	85	40'	2.0	1750	208/3/60	-	TACO KV2004	-

The document is owned by and the information contained in it is proprietary to Titan Mechanical, Inc. It is to be used only for the project for which it was prepared. No part of this document may be reproduced or transmitted in any form or by any means, electronic or mechanical, including photocopying, recording, or by any information storage and retrieval system, without the prior written consent of Titan Mechanical, Inc. and agreement to return the document forthwith upon request.

REVISIONS	DATE





Titan Mechanical, Inc.
 Design/Build Engineering - Mechanical Contracting
 P.O. Box 3927 / 232 Riverside Industrial Parkway
 Portland, Maine 04104
 Ph. (207) 878-5223 Fax. (207) 878-5235

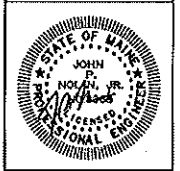

GREATER PORTLAND LANDMARKS
 CLIENT
 915 HIGH STREET - PORTLAND, ME
 PROJECT
 MECHANICAL SCHEDULES
 DRAWING TITLE

DATE: 12/20/2011
 SCALE: 1/4" = 1'-0"
 DRAWN BY: CJM
 CHECKED BY: JFN
 JOB NUMBER: XXXX
 CAD FILE: XXXX
 SHEET NUMBER

M2.0
 SHEET 4 OF 5

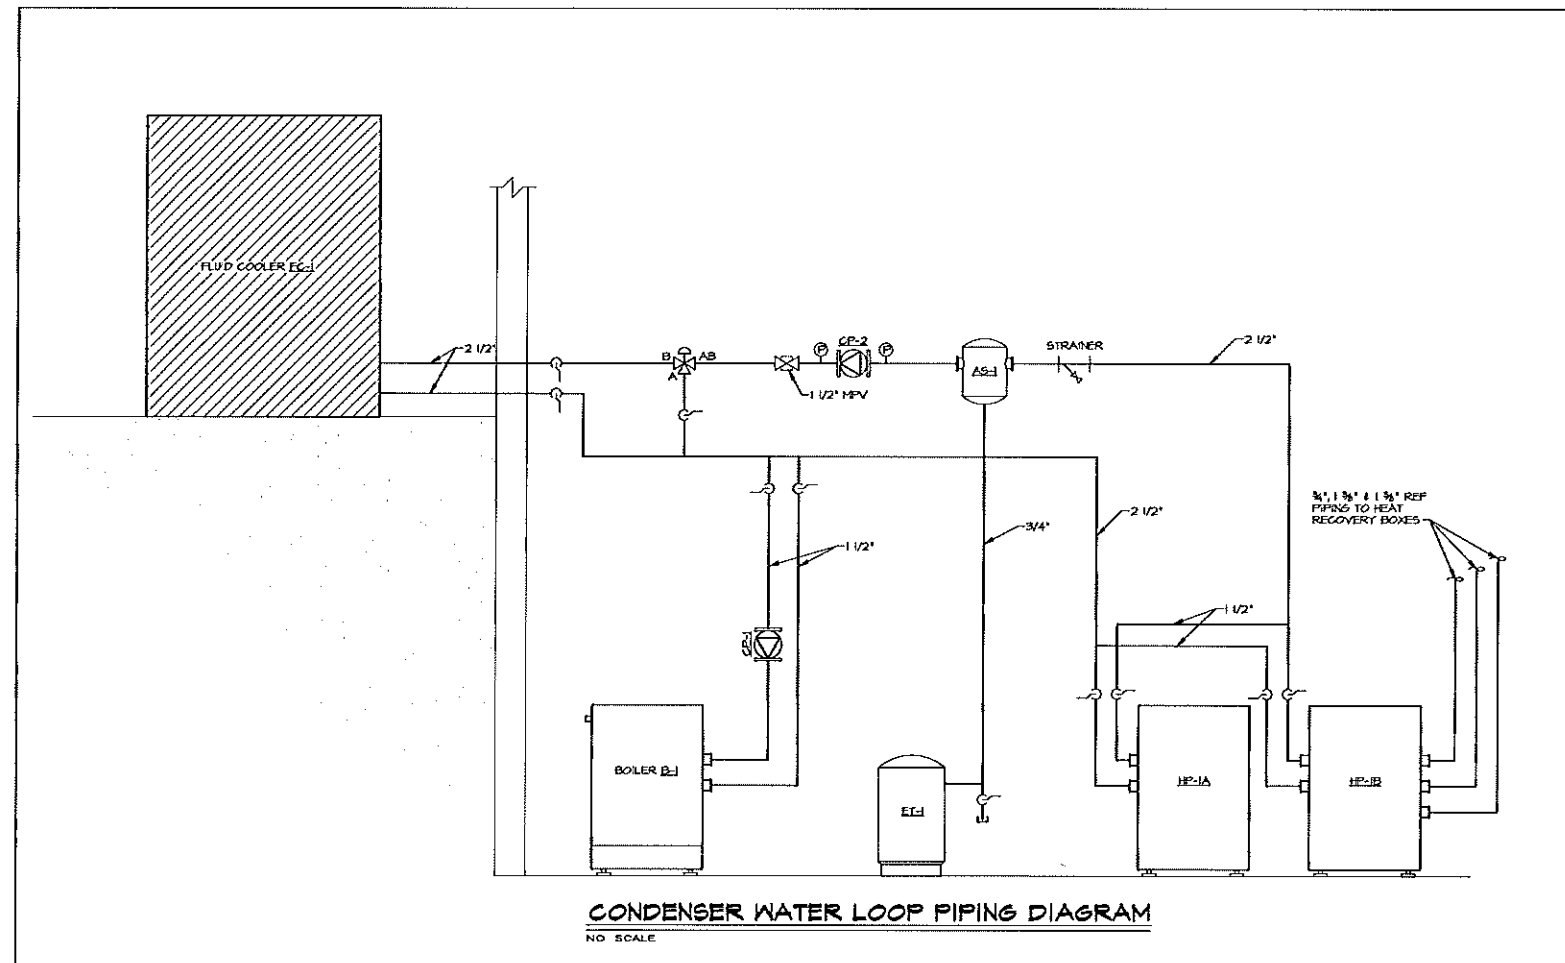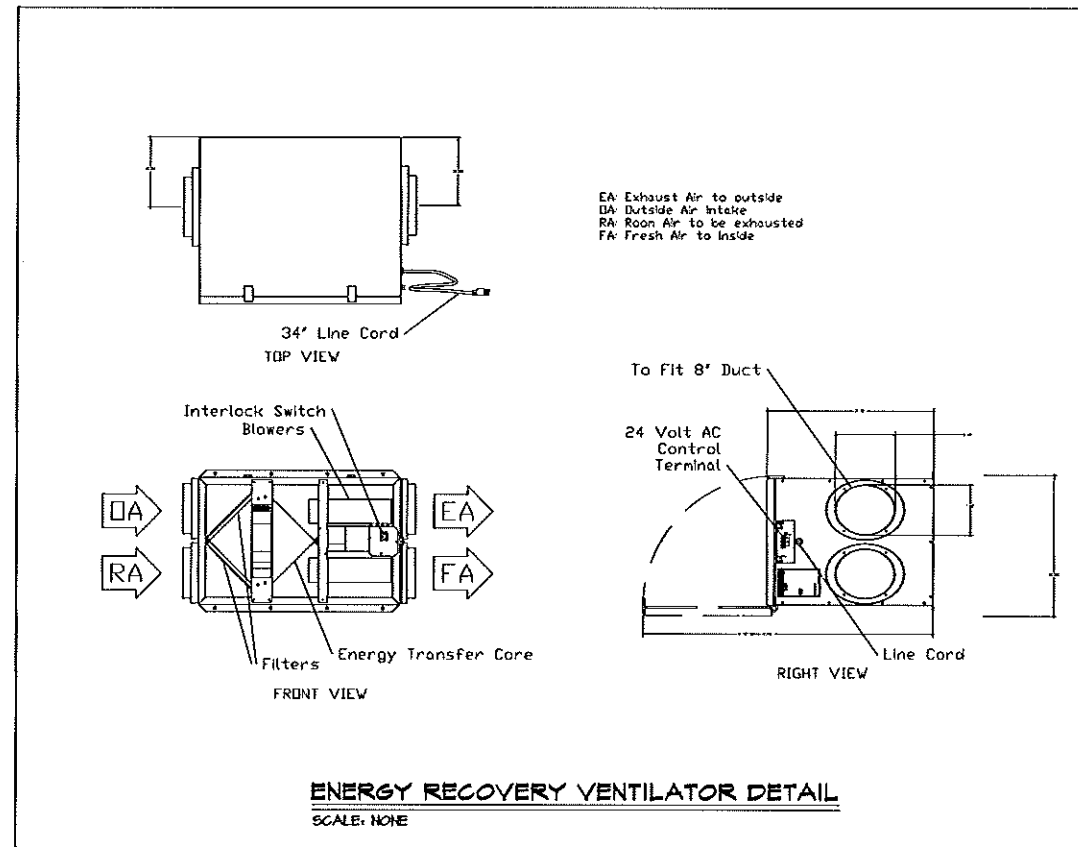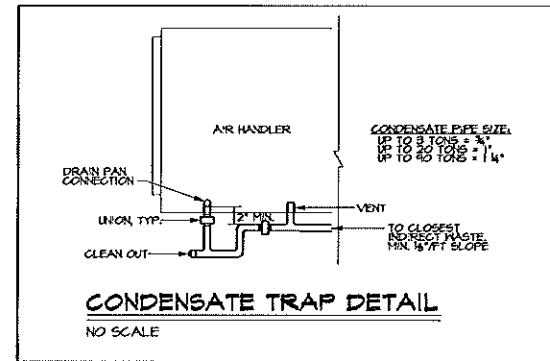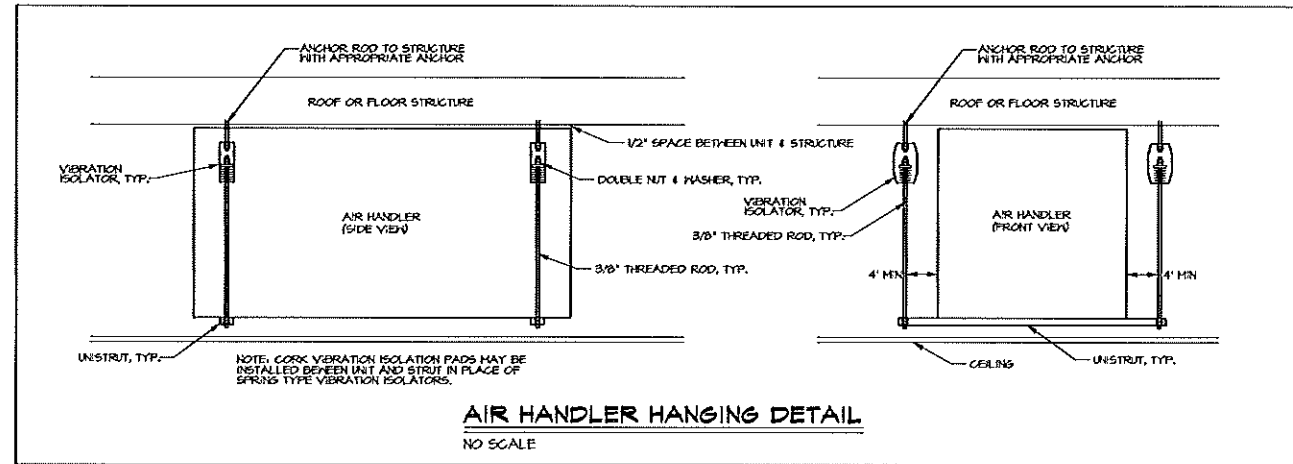

The document is issued by, and the design contained herein is a proprietary right of Titan Mechanical, Inc. No part of this document may be reproduced, stored in a retrieval system, or transmitted in any form or by any means, electronic, mechanical, photocopying, recording, or by any information storage and retrieval system, without the prior written consent of Titan Mechanical, Inc. and agrees to remain the document for which you request.

DATE	REVISIONS



Titan Mechanical, Inc.
Design Build Engineering - Mechanical Contracting
P.O. Box 3927 / 232 Riverside Industrial Parkway
Portland, Maine 04104
Ph. (207) 878-5223 Fax. (207) 878-5235

STATE OF MAINE
LICENSED PROFESSIONAL ENGINEER
NO. 10000
EXPIRES 12/31/2011

GREATER PORTLAND LANDMARKS
CLIENT
93 HIGH STREET - PORTLAND, ME
PROJECT
MECHANICAL DETAILS
DRAWING TITLE

DATE: 12/20/2011
SCALE: 1/4" = 1'-0"
DRAWN BY: CJM
CHECKED BY: JFN
JOB NUMBER: XXXX
CAD FILE: XXXX
SHEET NUMBER

M2.1
SHEET 4 OF 5

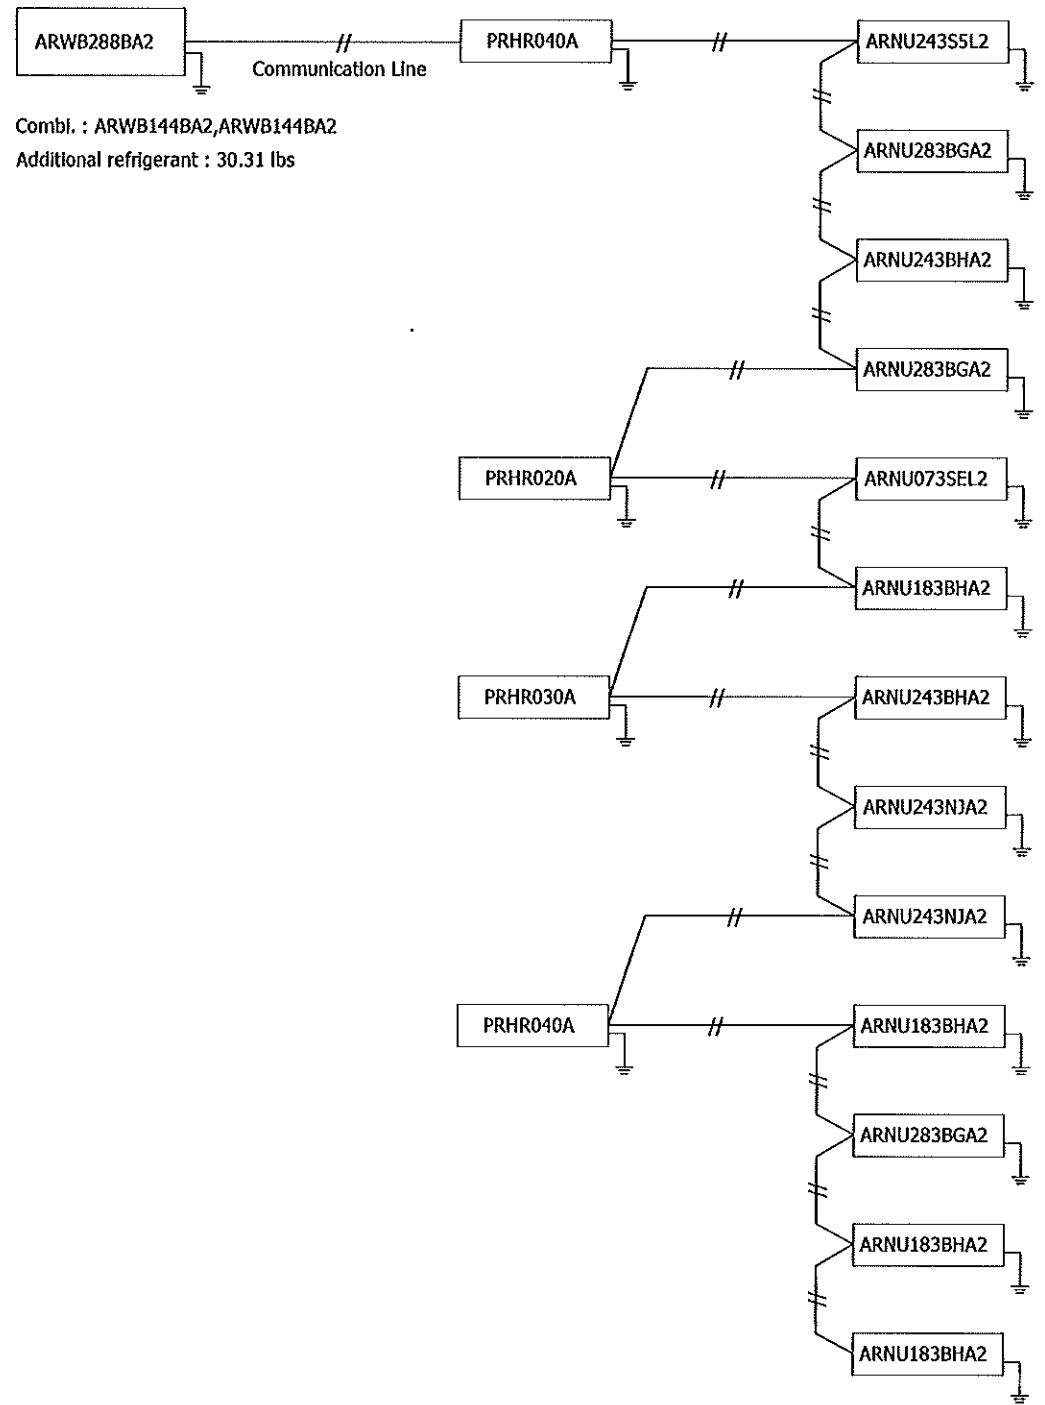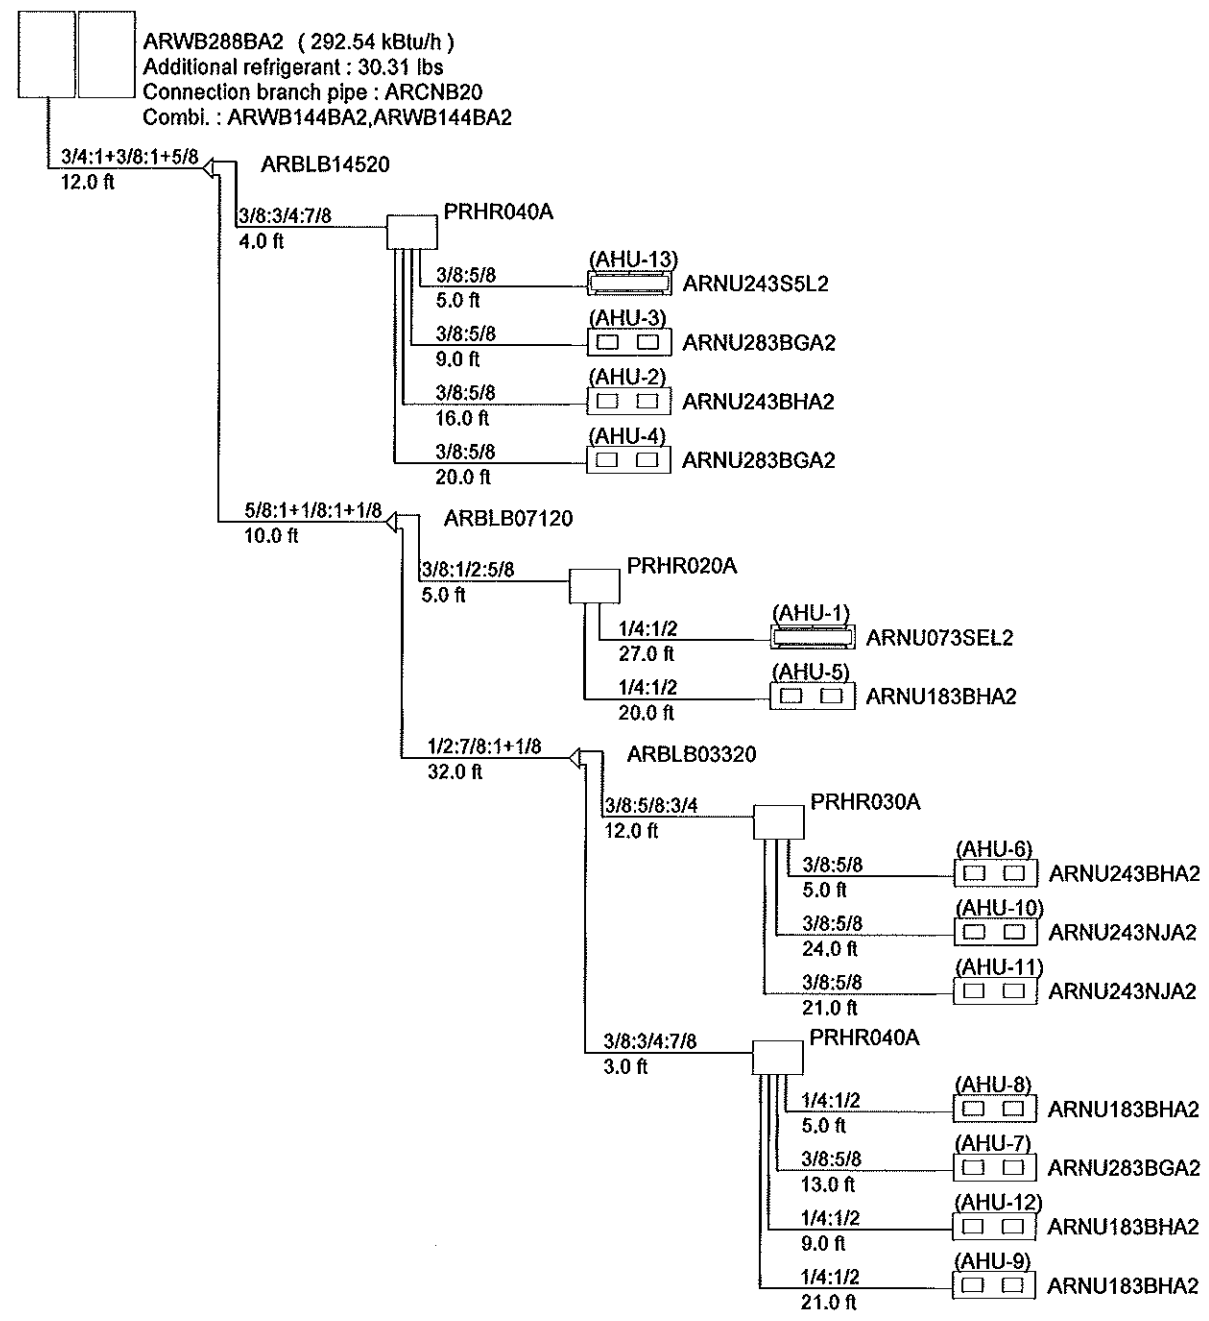

Note :
 Power wiring, breaker size, and disconnects shall follow local code or NEC
 Multi-frame outdoor unit models require a separate power connection for each frame.
 Refer to the most current submittal sheets for applicable electrical data.

The document is owned by and the information contained herein is the property of Titan Mechanical, Inc. No part of this document may be reproduced without the prior written consent of Titan Mechanical, Inc. and agrees to return this document promptly upon request.

REVISIONS	DATE

Titan Mechanical, Inc.
 Design Build Engineering - Mechanical Contracting
 P.O. Box 3927 / 232 Riverside Industrial Parkway
 Portland, Maine 04104
 Ph. (207) 878-5223 Fax. (207) 878-5235

GREATER PORTLAND LANDMARKS
 CLIENT

913 HIGH STREET - PORTLAND, ME
 PROJECT

MECHANICAL DETAILS
 DRAWING TITLE

DATE: 12/20/2011
 SCALE: 1/4" = 1'-0"
 DRAWN BY: CJM
 CHECKED BY: JFN
 JOB NUMBER: XXXX
 CAD FILE: XXXX
 SHEET NUMBER

M2.2

SHEET 4 OF 5