


Sprinkler Head Schedule

Symbol	Count	Thread	K-Factor	Description	Note
●	20	1/2"	5.6	NEW RELIABLE F1FR56 SEMI-RECESSED PENDENT	on Drop
○	19	1/2"	5.6	NEW RELIABLE F1FR56 BRASS UPRIGHT 200'	ON LINE
⊙	10	1/2"	5.6	EXISTING SR	
⊗	15	1/2"	5.6	EXISTING QR	

64 = Total Number of Heads This Floor

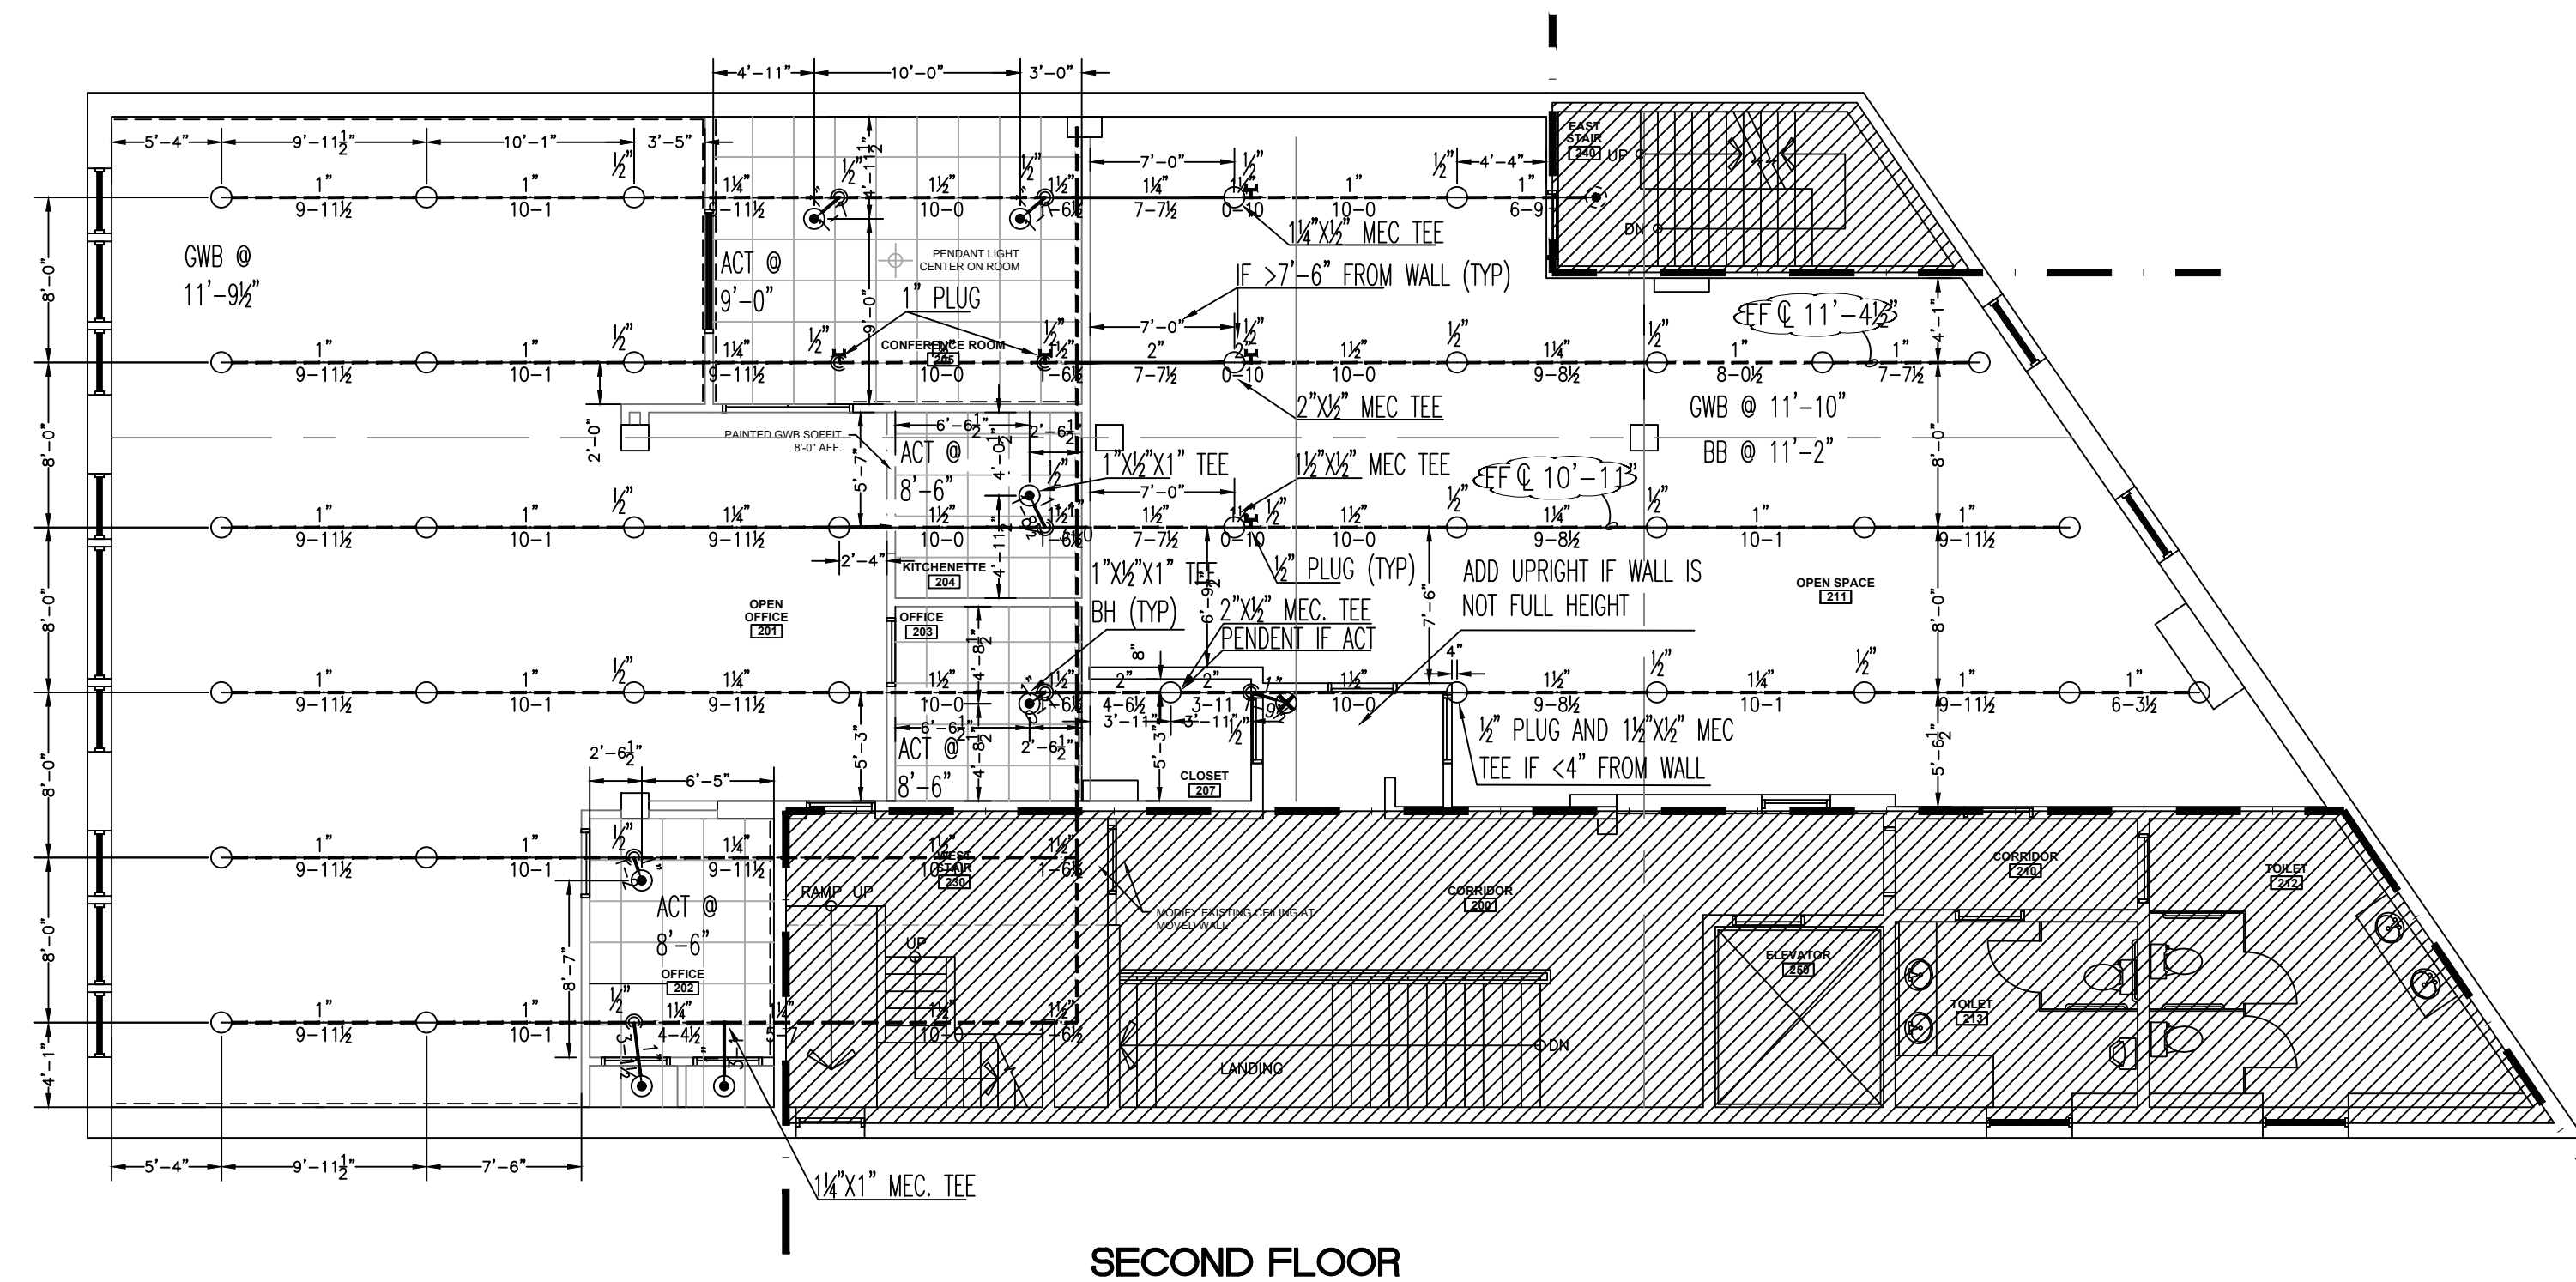

Sprinkler Head Schedule

Symbol	Count	Thread	K-Factor	Description	Note
●	7	1/2"	5.6	NEW RELIABLE F1FR56 SEMI-RECESSED PENDENT	on Drop
○	36	1/2"	5.6	NEW RELIABLE F1FR56 BRASS UPRIGHT 200'	ON LINE
⊙	1	1/2"	5.6	EXISTING SR	
⊗	1	1/2"	5.6	EXISTING QR	

45 = Total Number of Heads This Floor

DATE	REVISIONS	REQUIRED APPROVALS	<p style="text-align: center;">622 CONGRESS ST. 622 CONGRESS STREET, PORTLAND MAINE</p> <p style="text-align: center;">CONTRACT WITH: NORTHLAND MANAGEMENT CORP.</p> <p style="text-align: center;">EASTERN FIRE PROTECTION AUBURN/LEWISTON INDUSTRIAL AIRPARK, AUBURN, MAINE 04210</p>	FIRE SPRINKLER PLANS & DETAILS
				DWG. NO. 1 OF 1
				JOB NUMBER 5615
				SCALE AS NOTED
				DATE 06/22/2017
		DRAWN BY JML NICET LEVEL CERT.# CHECKED BY NICET LEVEL CERT.# CONTRACTOR LICENSE # 101 CONTRACTOR RMS # 368		