

REVISION	DESCRIPTION	DATE
0	ISSUED FOR REVIEW & APPROVAL	1/20/2014

RESERVED FOR CITY STAMP



**CUNNINGHAM**  
Security Systems

10 Princes Point Road, Yarmouth, Maine 04096  
Office: 207.846.3350 • Fax: 207.846.6080

**106 HIGH STREET**  
**PORTLAND, MAINE 04101**  
**BASEMENT FIRE ALARM PLAN**

DRAWN	JPB	UNICAD JOB #14027
CHECKED	WAYNE B. HAWES	NCET # 90496
DATE	1/17/2014	
REVISION	0	
SCALE	1/4" = 1'-0"	

**FA-2**

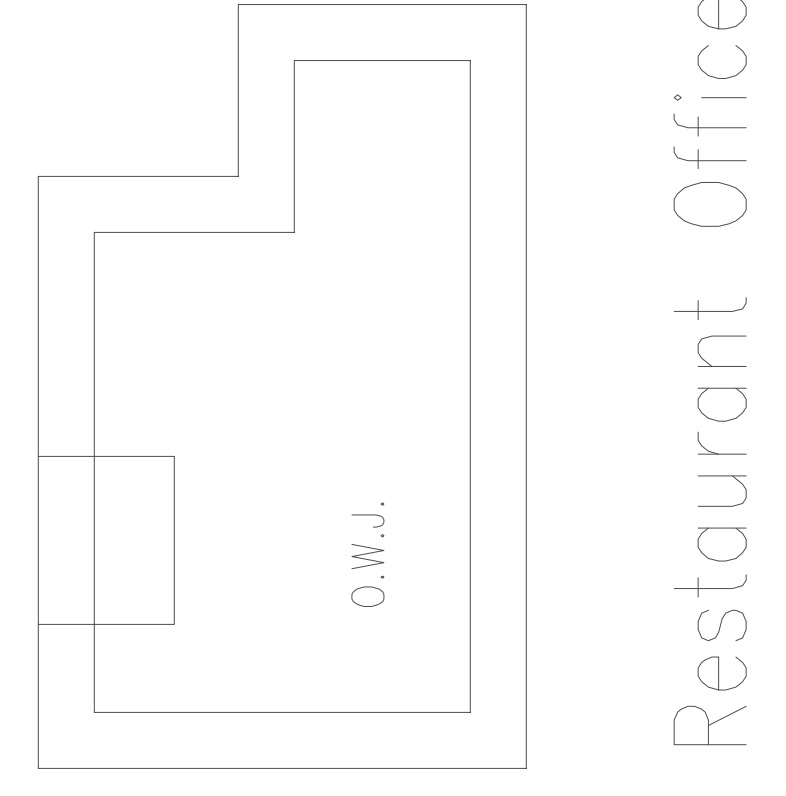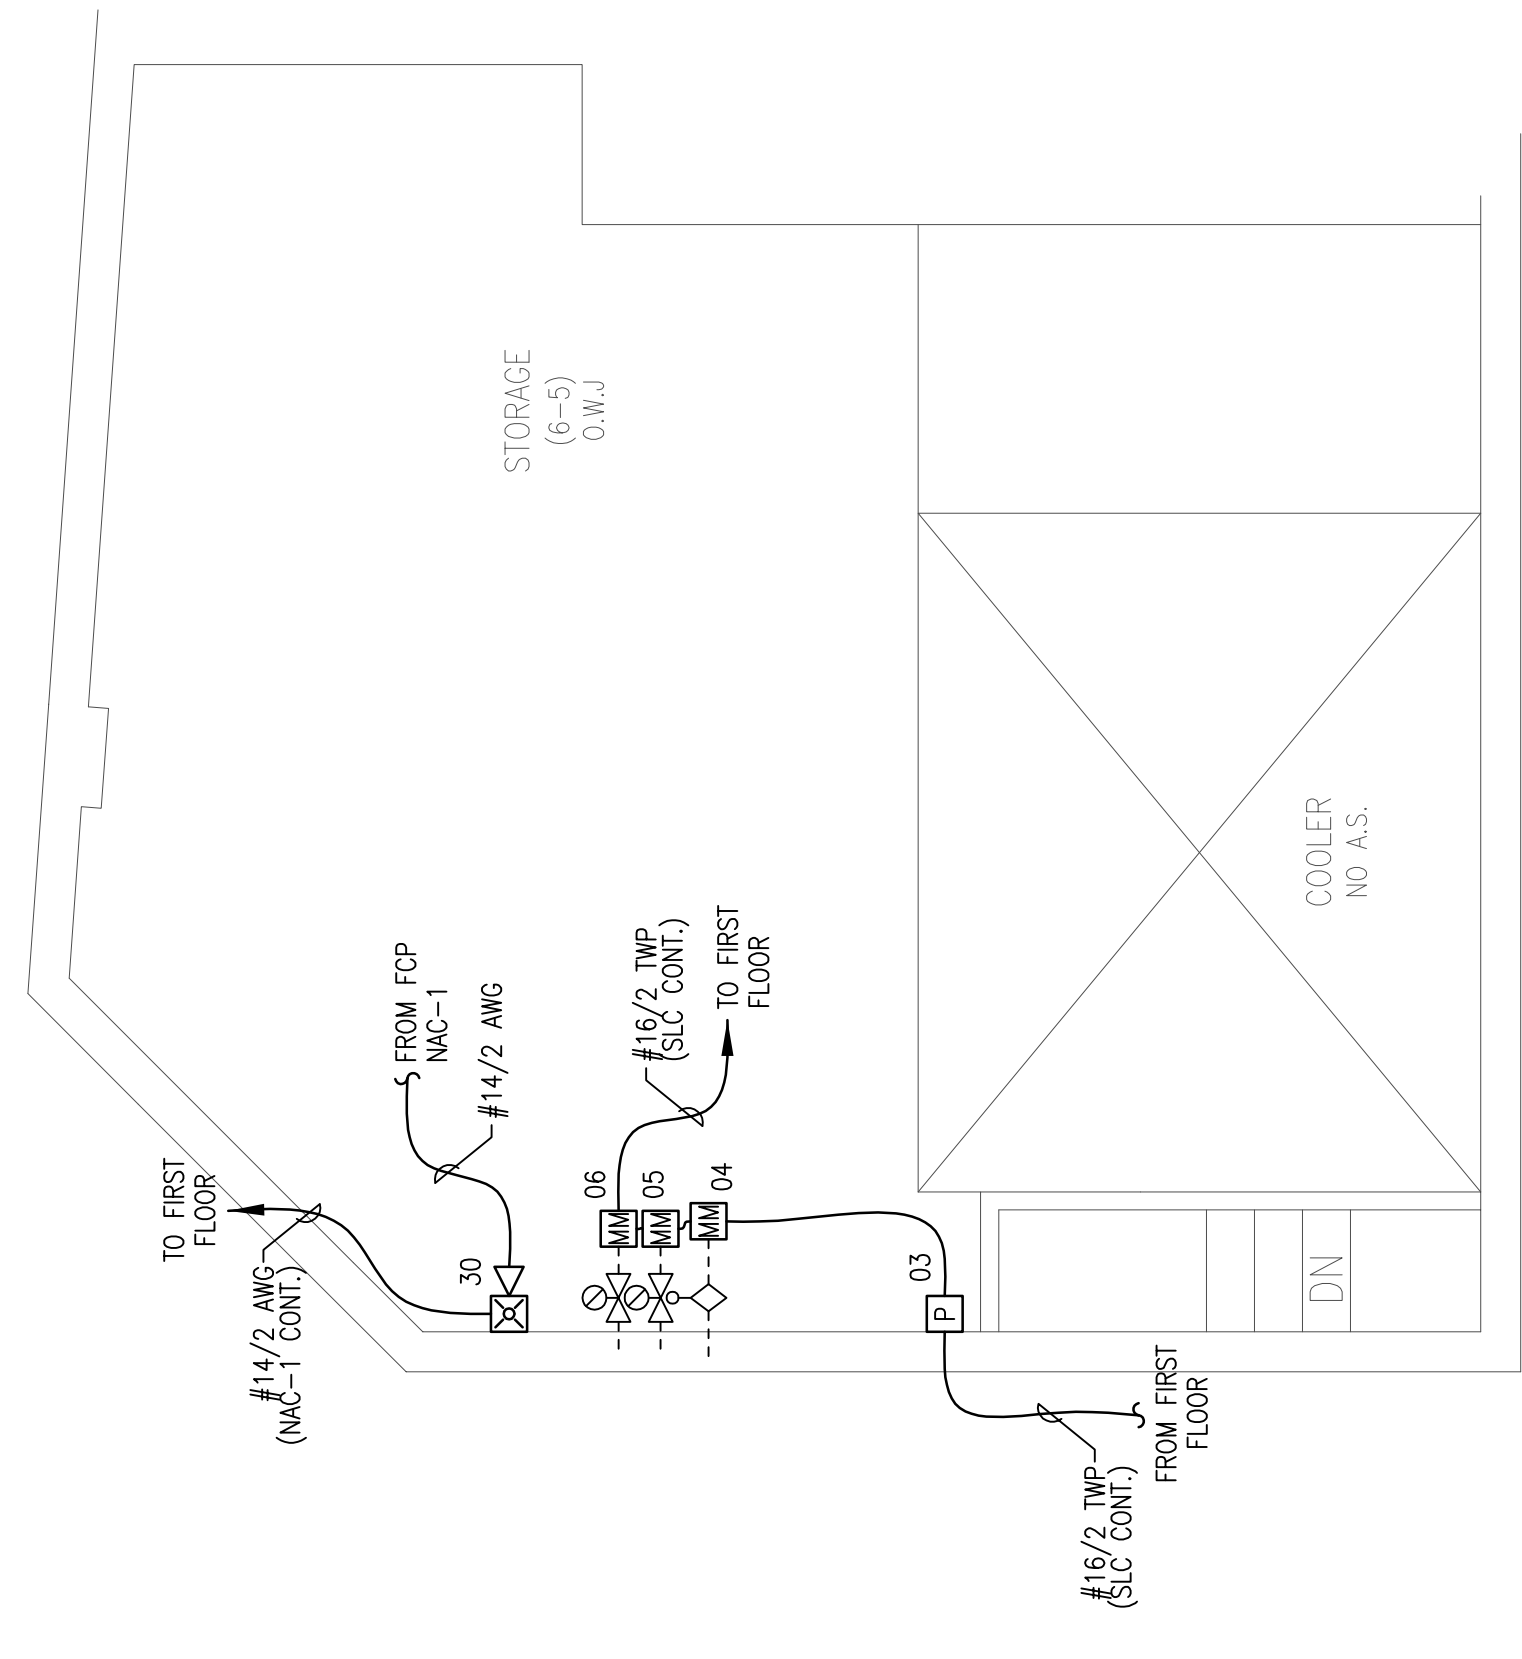

**BASEMENT FIRE ALARM PLAN**  
SCALE: 1/8"=1'-0"



**UNICAD** Inc.  
www.unicad.net  
Fire Alarm Design & Drafting Services