



REVISION	DESCRIPTION	DATE
0	ISSUED FOR REVIEW & APPROVAL	1/20/2014


RESERVED FOR CITY STAMP

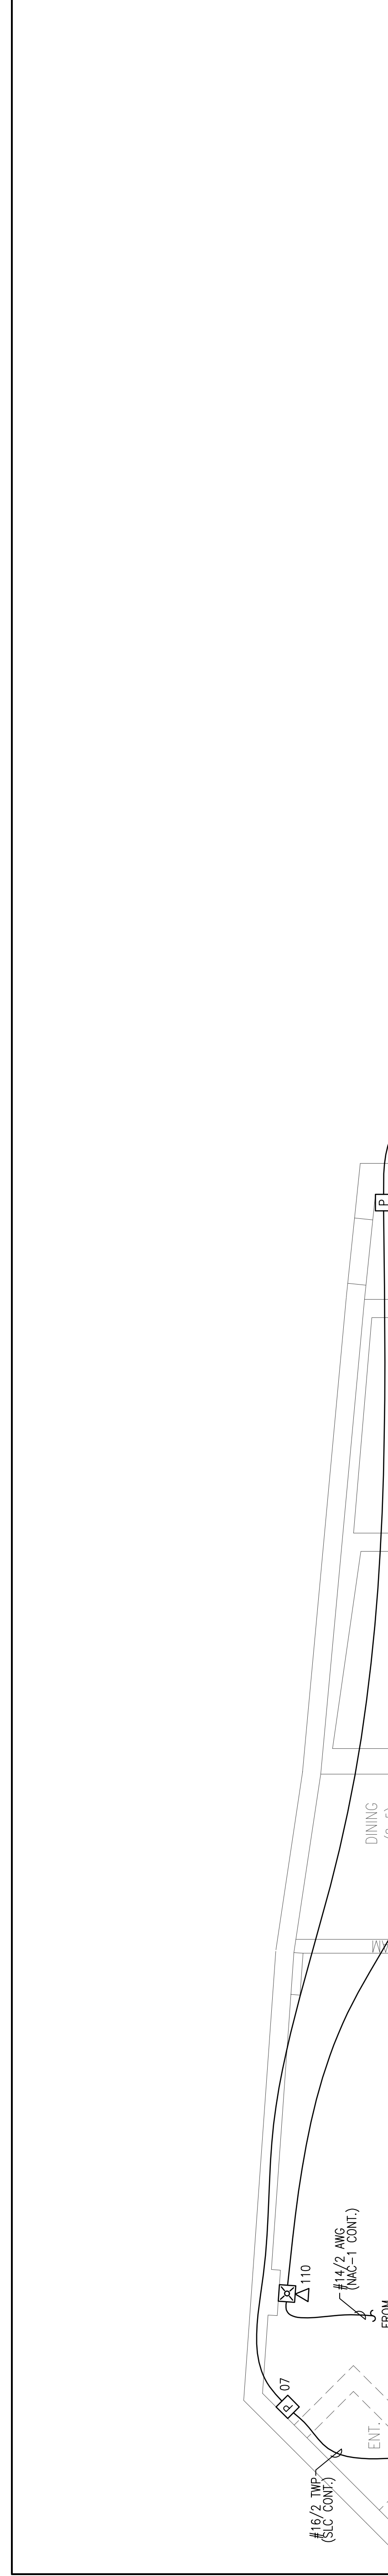

**CUNNINGHAM**  
Security Systems  
10 Princes Point Road, Yarmouth, Maine 04096  
Office: 207.846.3350 • Fax: 207.846.6080

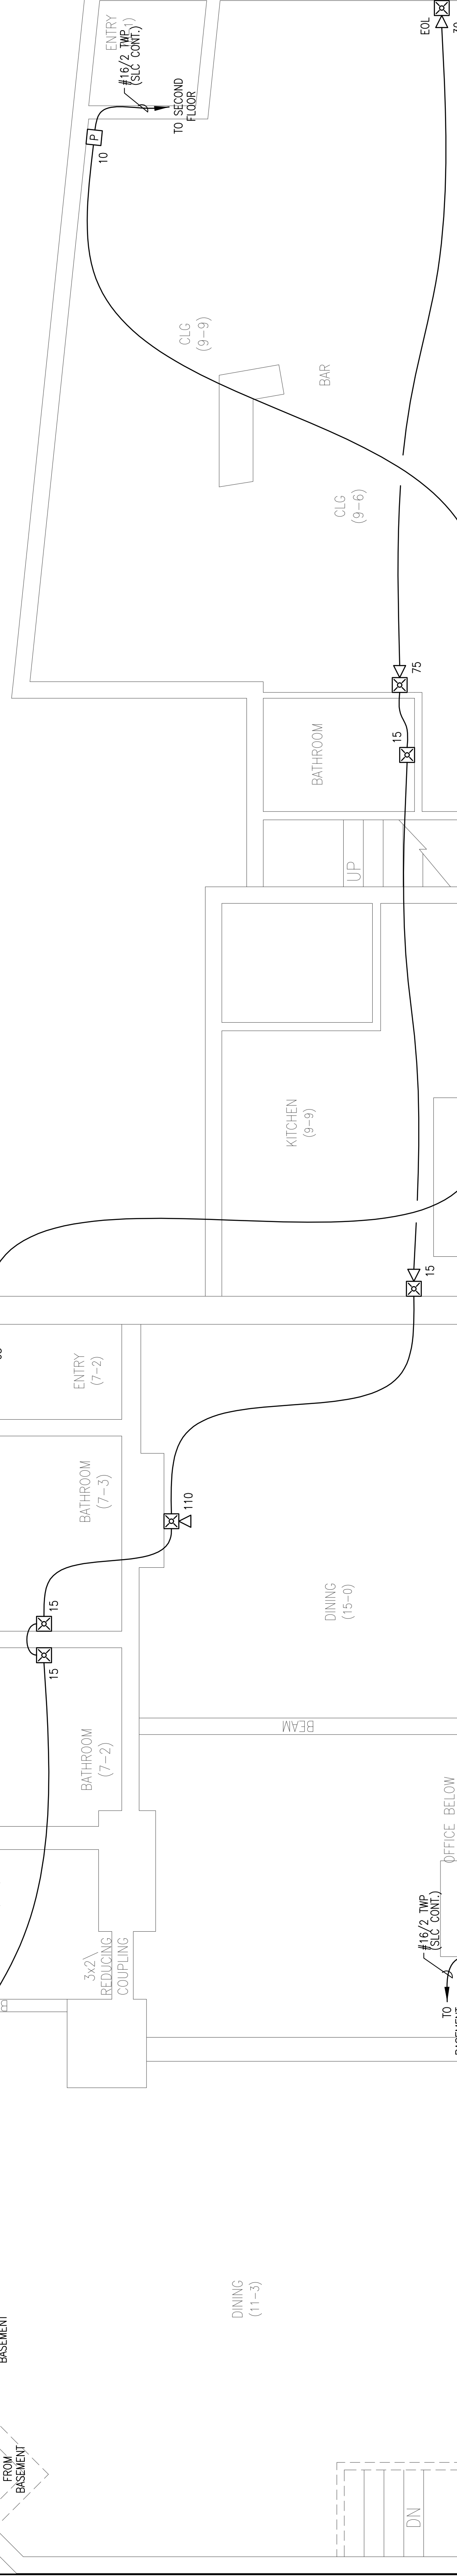

**106 HIGH STREET**  
**PORTLAND, MAINE 04101**  
**FIRST FLOOR FIRE ALARM PLAN**

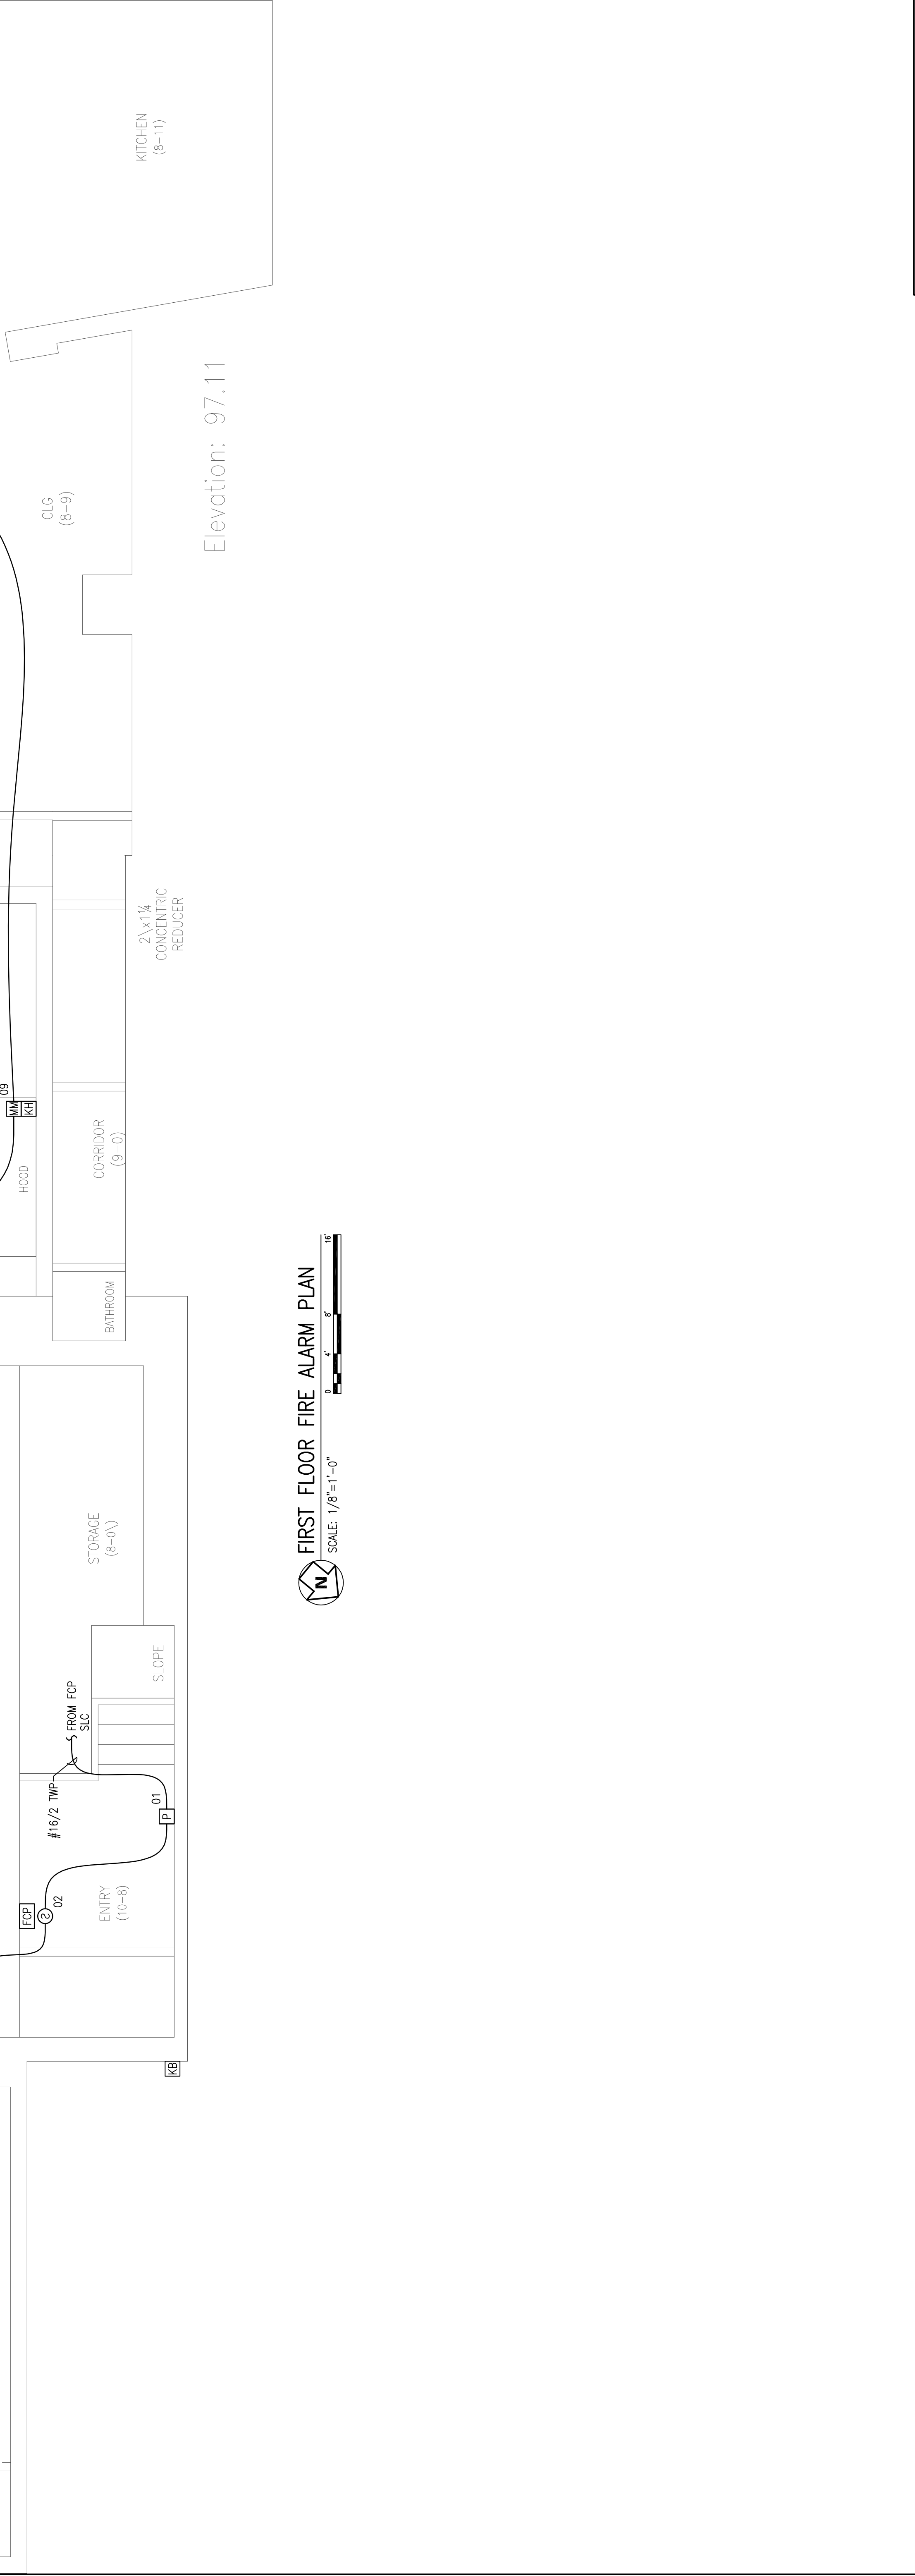

REVISION	SCALE
0	1/4" = 1'-0"

DATE	CHECKED	DRAWN
1/17/2014	WAYNE B. HAWES NCEET # 90496	JPB UNICAD JOB #14027

**UNICAD** Inc.  
Fire Alarm Design & Drafting Services  
www.unicad.net  
5784 W. 40th St.  
Portland, ME 04107  
Office: 501.865.0410