

OWNER:
 53 DANFORTH STREET, LP
 C/O THE SZANTON COMPANY
 ONE CITY CENTER - 4TH FLOOR
 PORTLAND, ME 04101


ARCHETYPE, P.A.
 ARCHITECTS
 48 Union Wharf Portland, Maine 04101
 (207) 772-6022 Fax (207) 772-4056

53 DANFORTH
 53 DANFORTH STREET
 PORTLAND, MAINE


Project:
 Date: 28 MAY 2008
 Scale: AS NOTED
 Revisions:
 28 May 2008 - 90% MSHA Submittal
 1 July 2008 - 90% MSHA Submittal
 15 July 2008 - Pricing Set
 25 July 2008 - 100% MSHA Submittal

PROGRESS SET
 MECHANICAL PLANS
 3rd & 4th FLOORS

M1.02
 M.S.E. PROJECT 0812

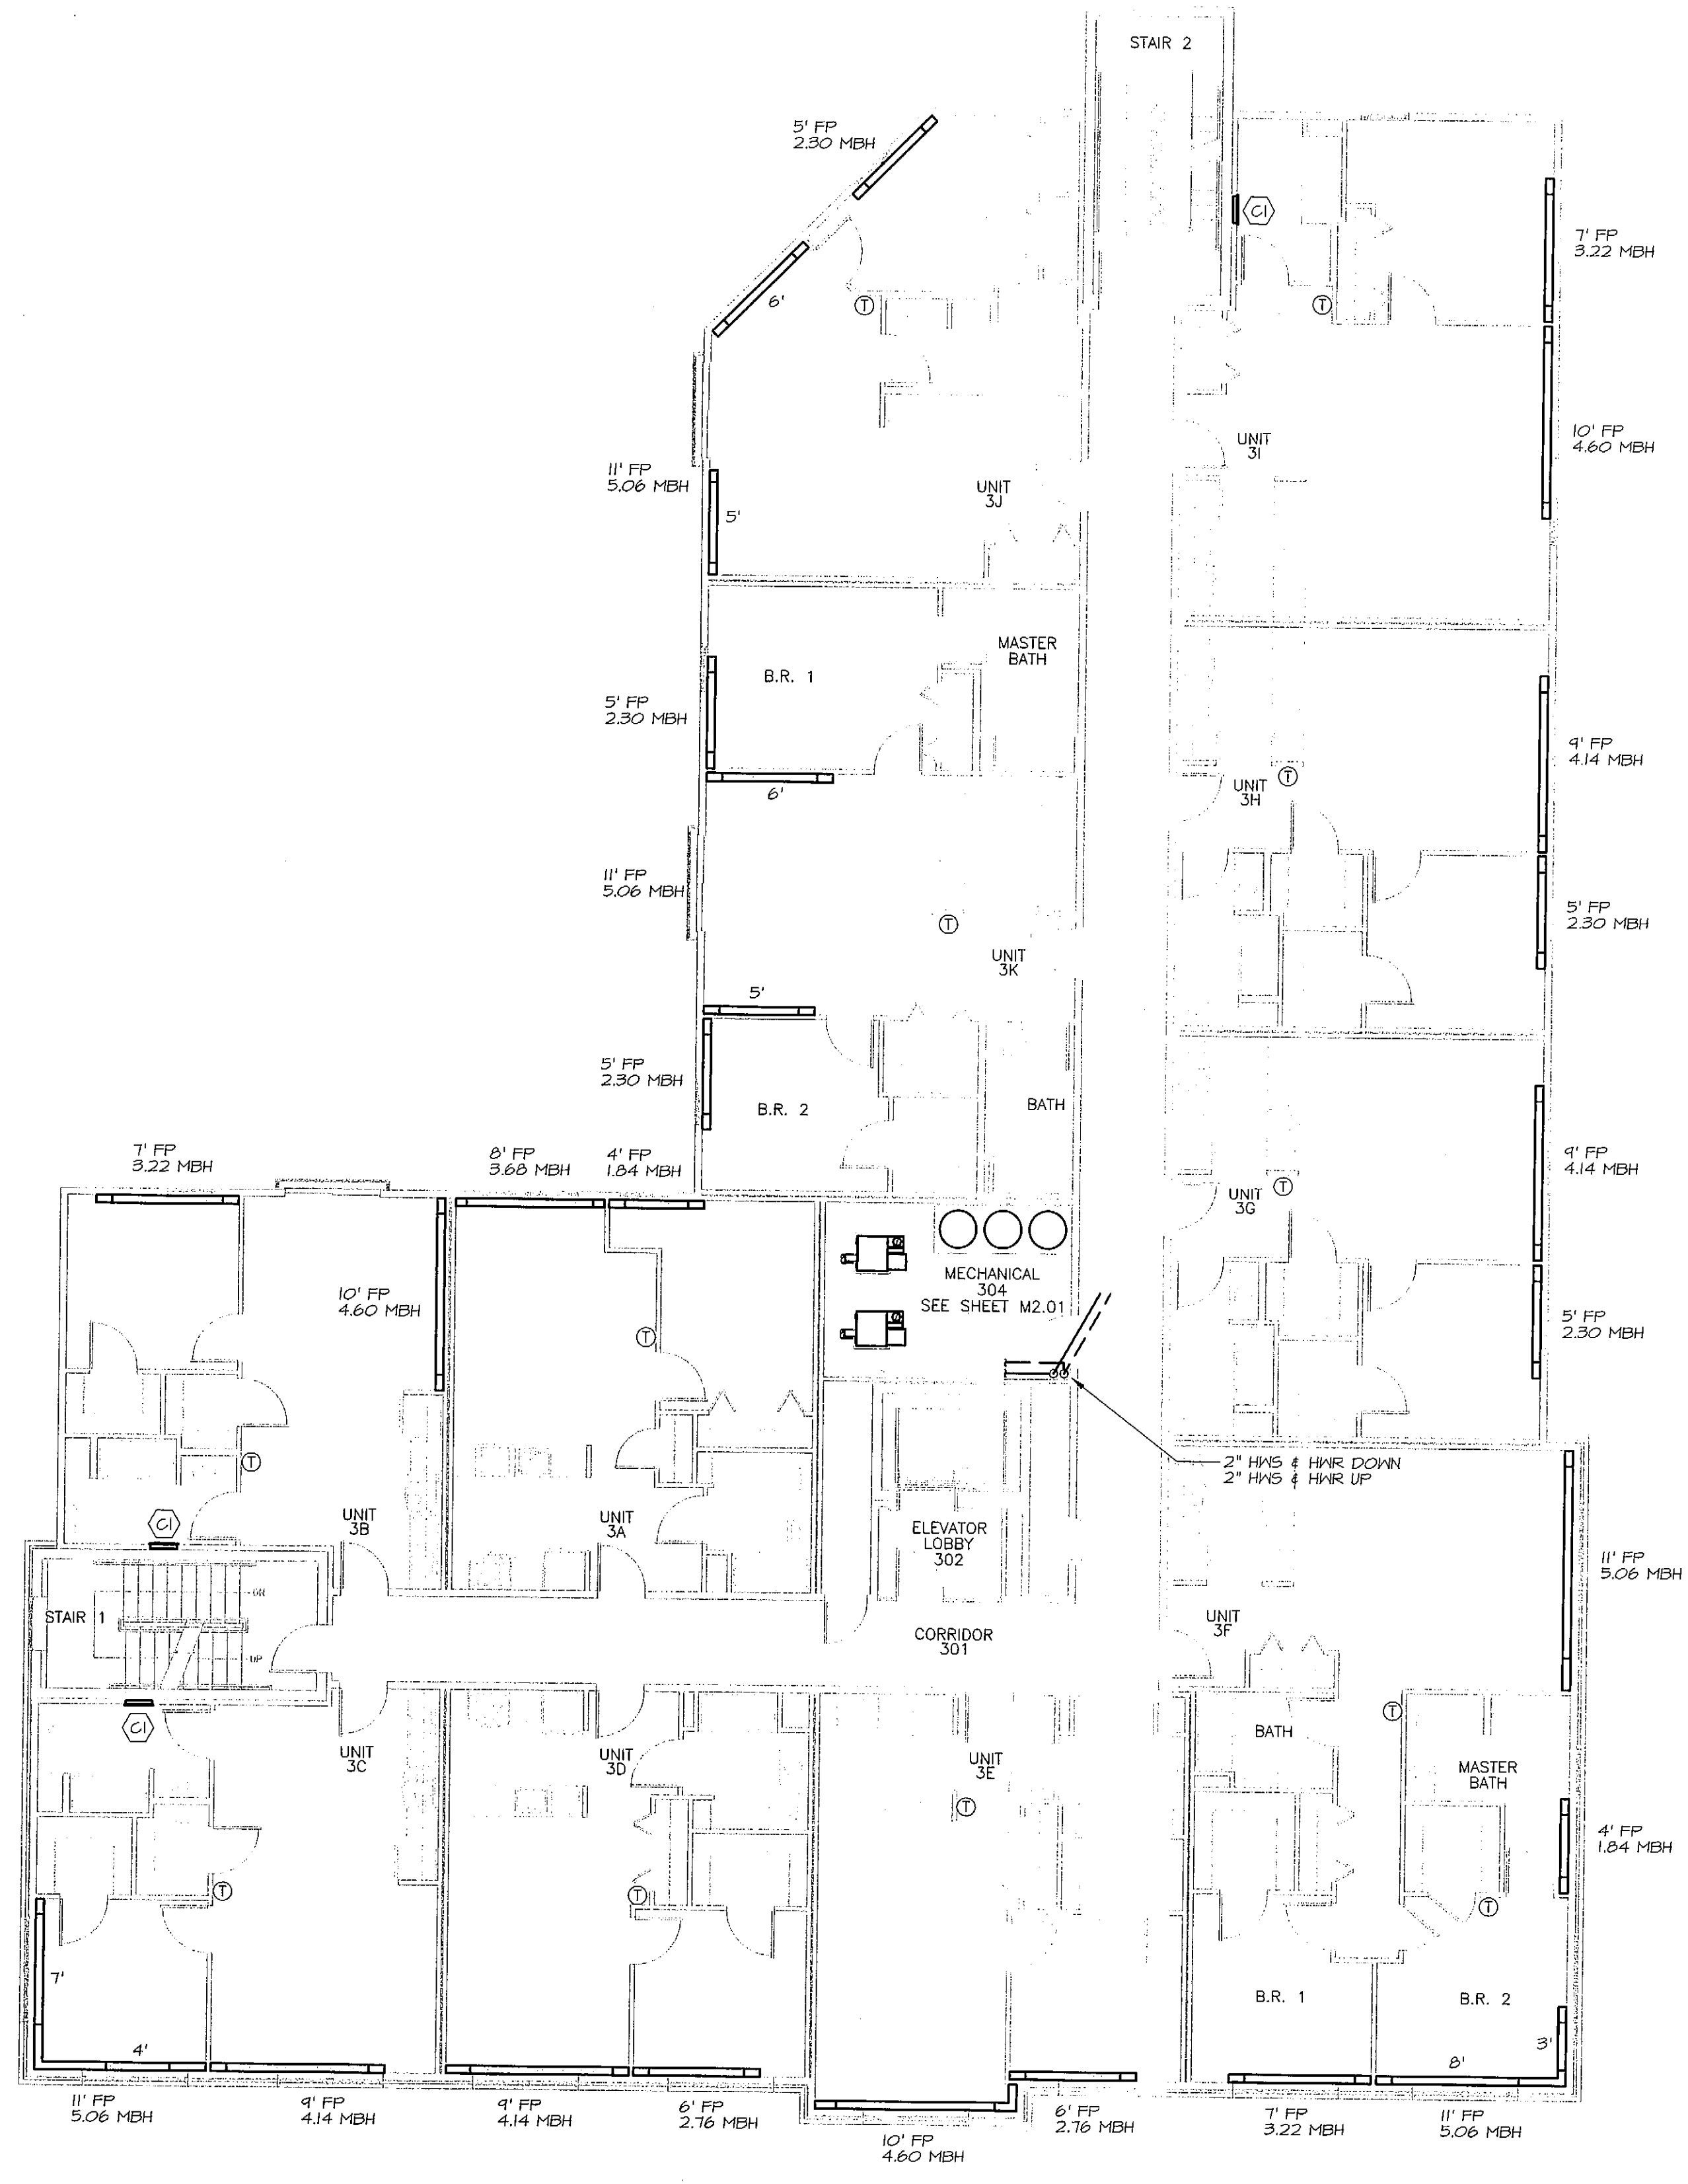


1 MECHANICAL THIRD FLOOR PLAN
 SCALE: 1/8" = 1'-0"

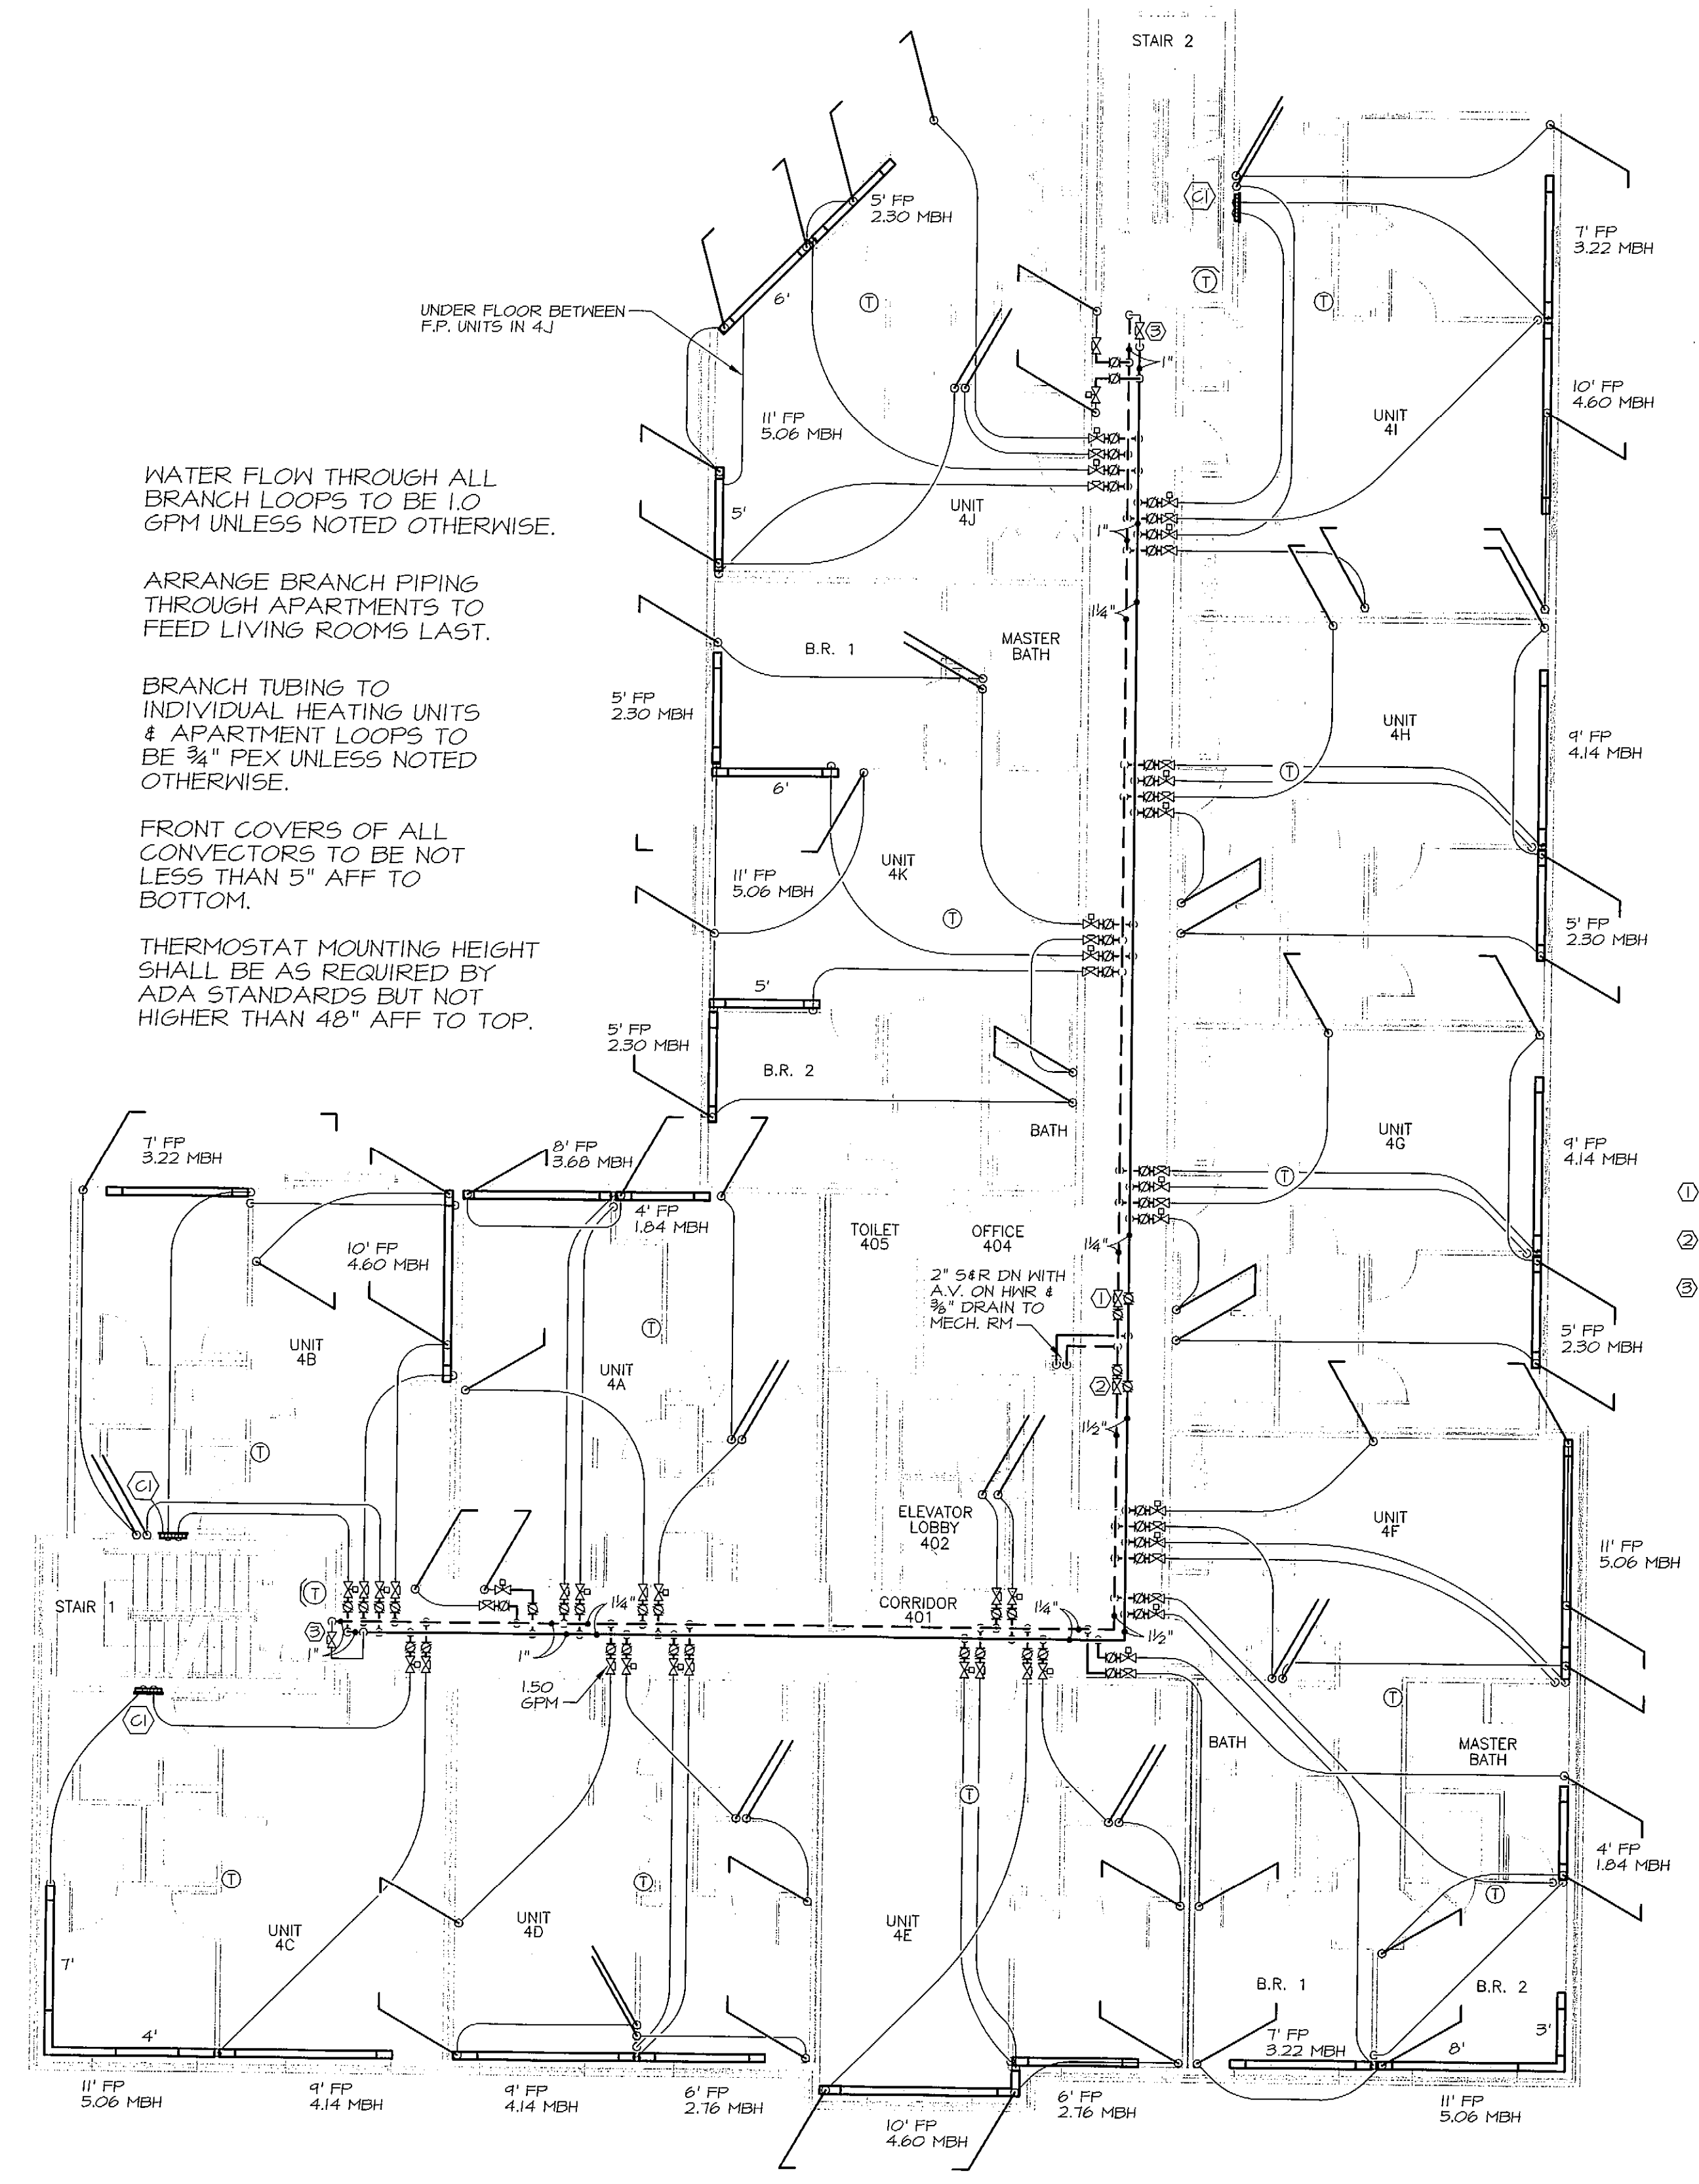


2 MECHANICAL FOURTH FLOOR PLAN
 SCALE: 1/8" = 1'-0"

 - 1 CIRCUIT SETTER SET FOR 12.0 GPM @ 1/2 psi ΔP
- 2 CIRCUIT SETTER SET FOR 15.5 GPM @ 1/2 psi ΔP
- 3 CIRCUIT SETTER SET FOR 1.0 GPM @ 1/2 psi ΔP



MECHANICAL SYSTEMS ENGINEERS
 ROYAL RIVER CENTER, UNIT #10
 10 FOREST FALLS DRIVE
 YARMOUTH, MAINE 04096
 VOICE: (207) 846-1441
 FAX: (207) 846-1443
 mechyst@maine.rr.com
 © copyright 2008

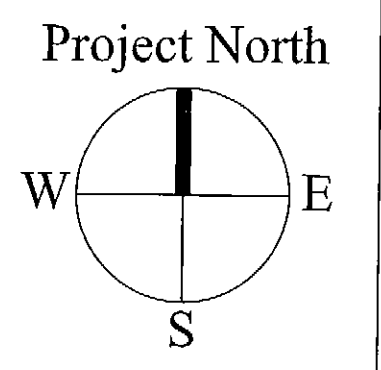

July 25, 2008 - 10:21 am
 \\server1\projects\0812_53_Danforth\Drawings\0812_M101-M103.dwg