

OWNER:
 53 DANFORTH STREET, LP
 C/O THE SZANTON COMPANY
 ONE CITY CENTER - 4TH FLOOR
 PORTLAND, ME 04101

ARCHETYPE, P.A.
 ARCHITECTS
 48 Union Wharf Portland, Maine 04101
 (207) 772-6022 Fax (207) 772-4056


53 DANFORTH
 53 DANFORTH STREET
 PORTLAND, MAINE

Project:
 Date: 28 MAY 2008
 Scale: AS NOTED
 Revisions:
 28 May 2008 - 50% MSHA Submittal
 1 July 2008 - 90% MSHA Submittal
 15 July 2008 - Pricing Set
 25 July 2008 - 100% MSHA Submittal

PROGRESS SET
 MECHANICAL PLANS
 3rd & 4th FLOORS
 DUCTWORK

M1.05

M.S.E. PROJECT 0812

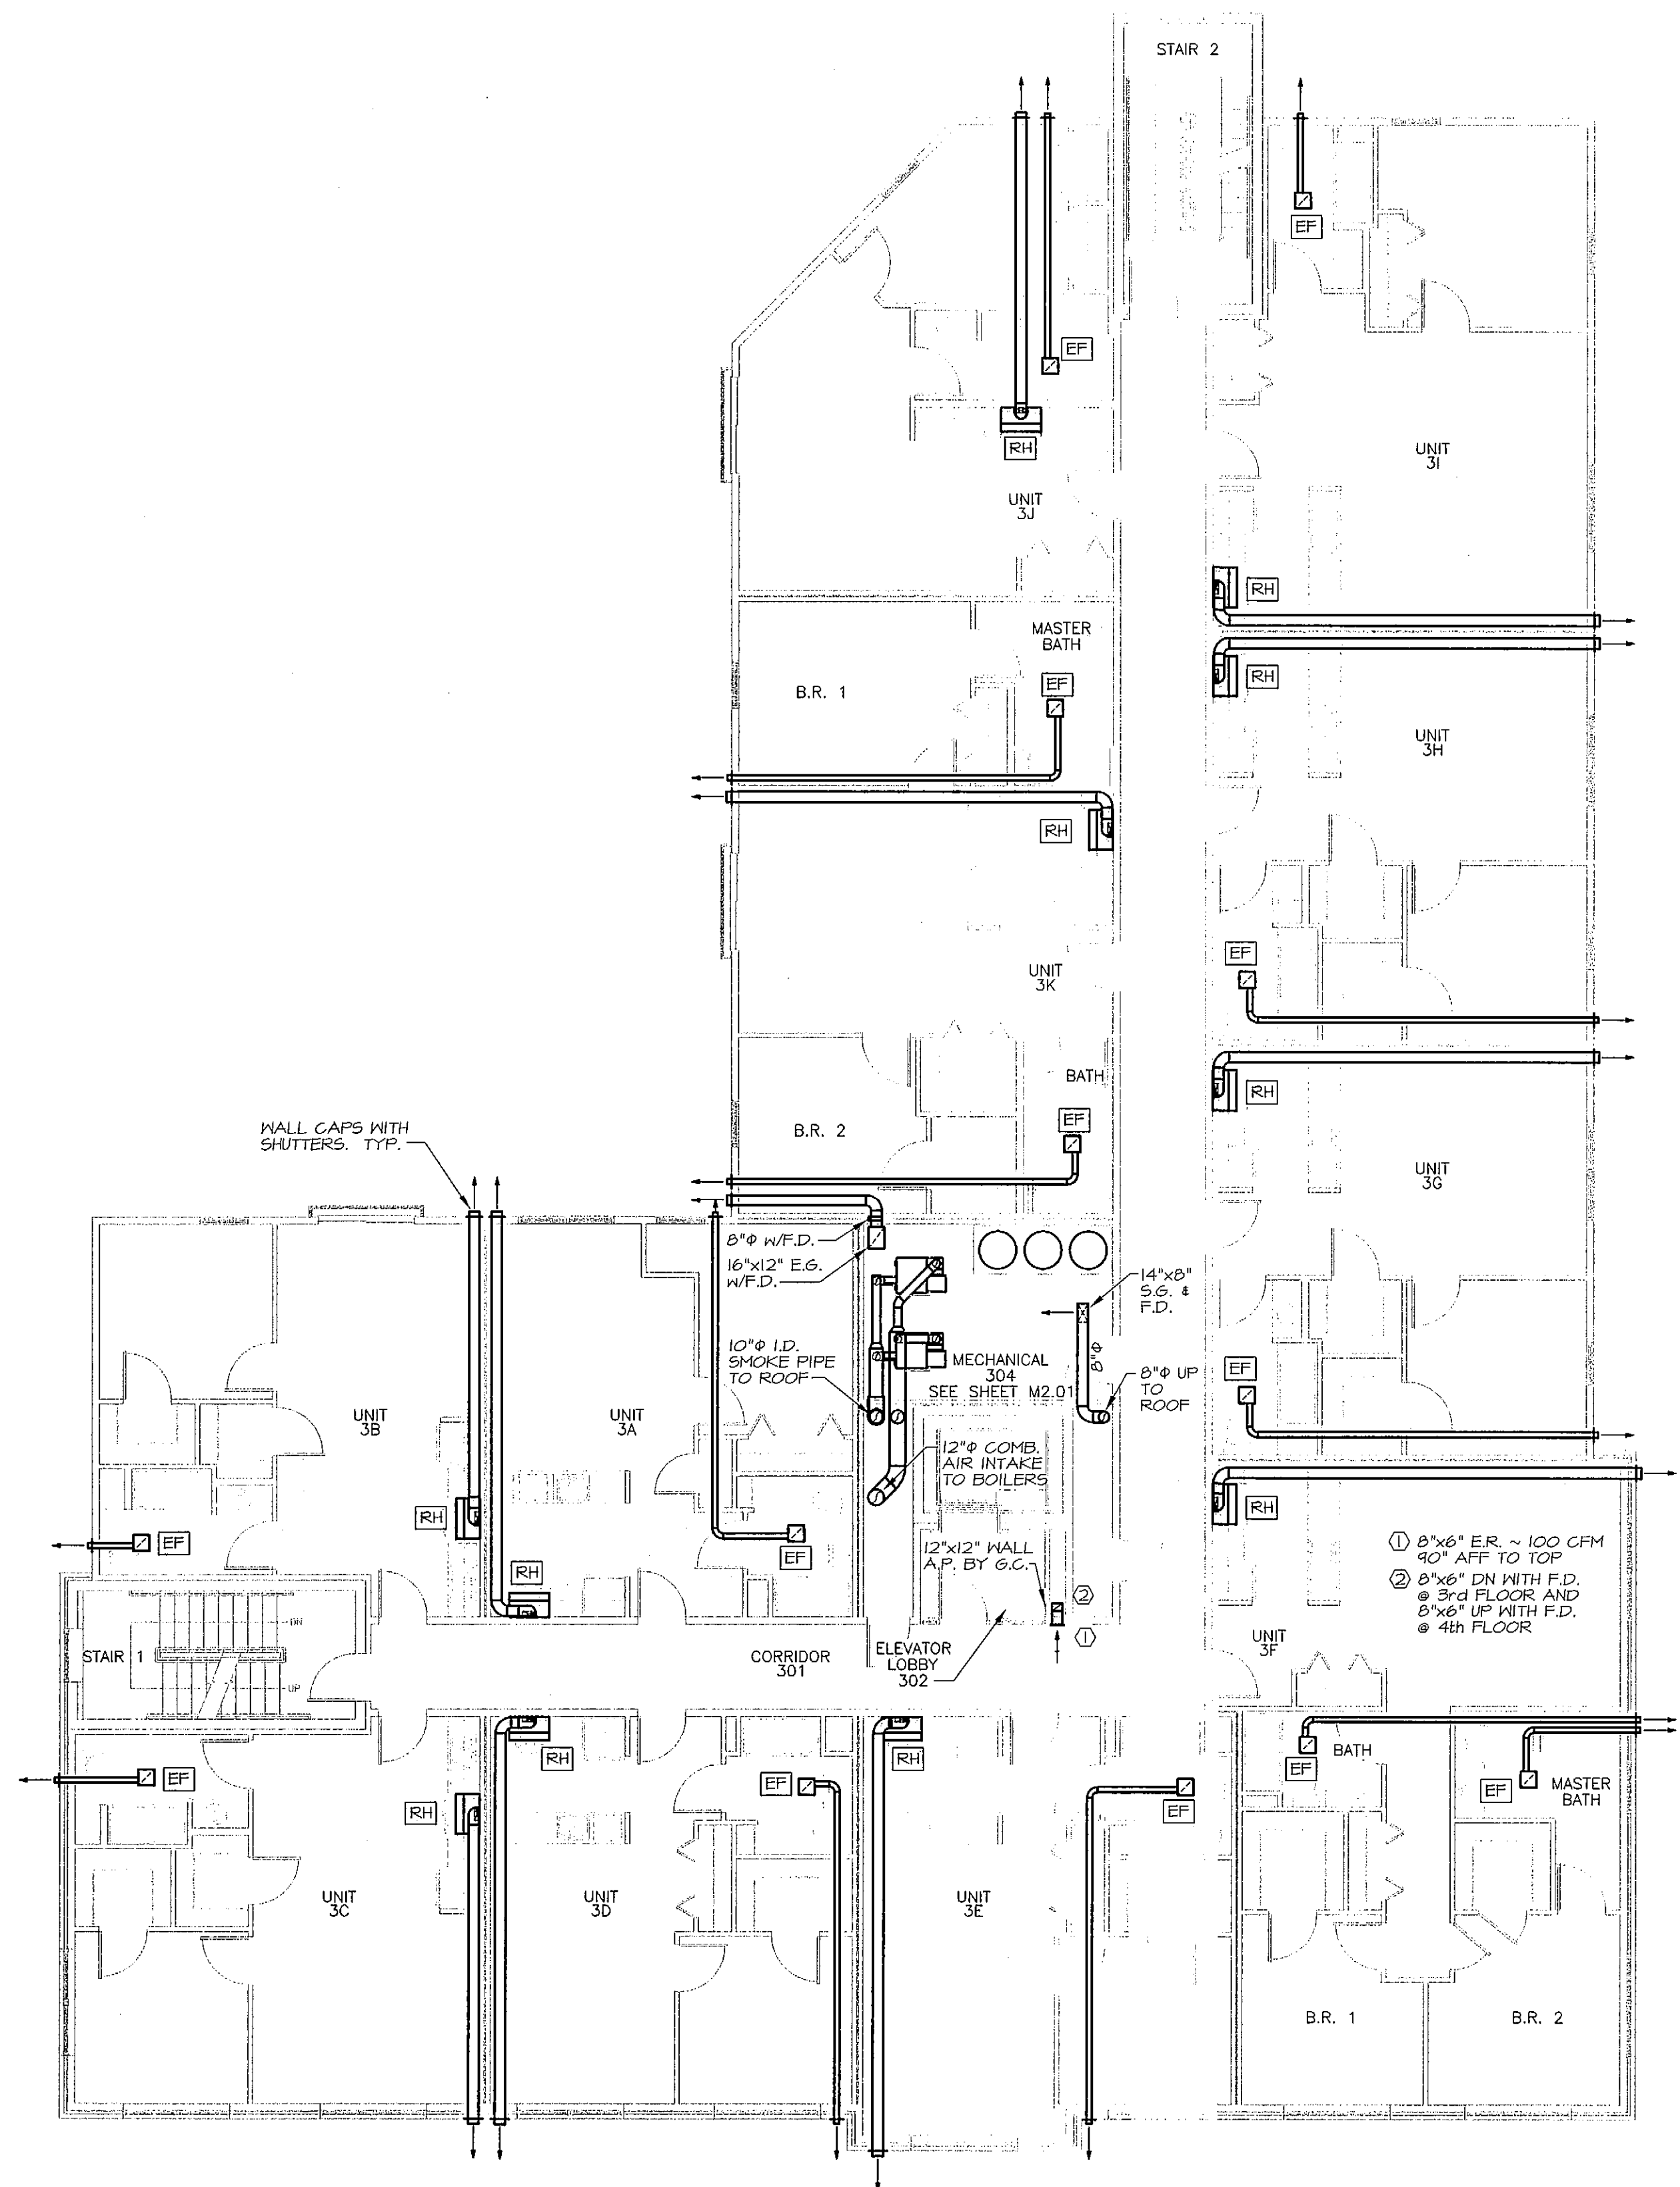


1 MECHANICAL THIRD FLOOR PLAN
 SCALE: 1/8" = 1'-0"

ALL BATHROOM FANS (EF) TO HAVE 4" Ø DUCT CONNECTIONS. TRANSITION TO 6" Ø AND RUN TO OUTSIDE WALLS.

RANGE HOODS (RH) TO HAVE 10"x3 1/4" DUCT CONNECTIONS. TRANSITION TO 8" Ø ABOVE HOOD AND RUN TO OUTSIDE WALLS.


ALL DUCTWORK FOR RANGE HOODS TO HAVE FIRE DAMPERS AT DUCT PENETRATION THRU CEILING. SEE DETAIL ON M6.

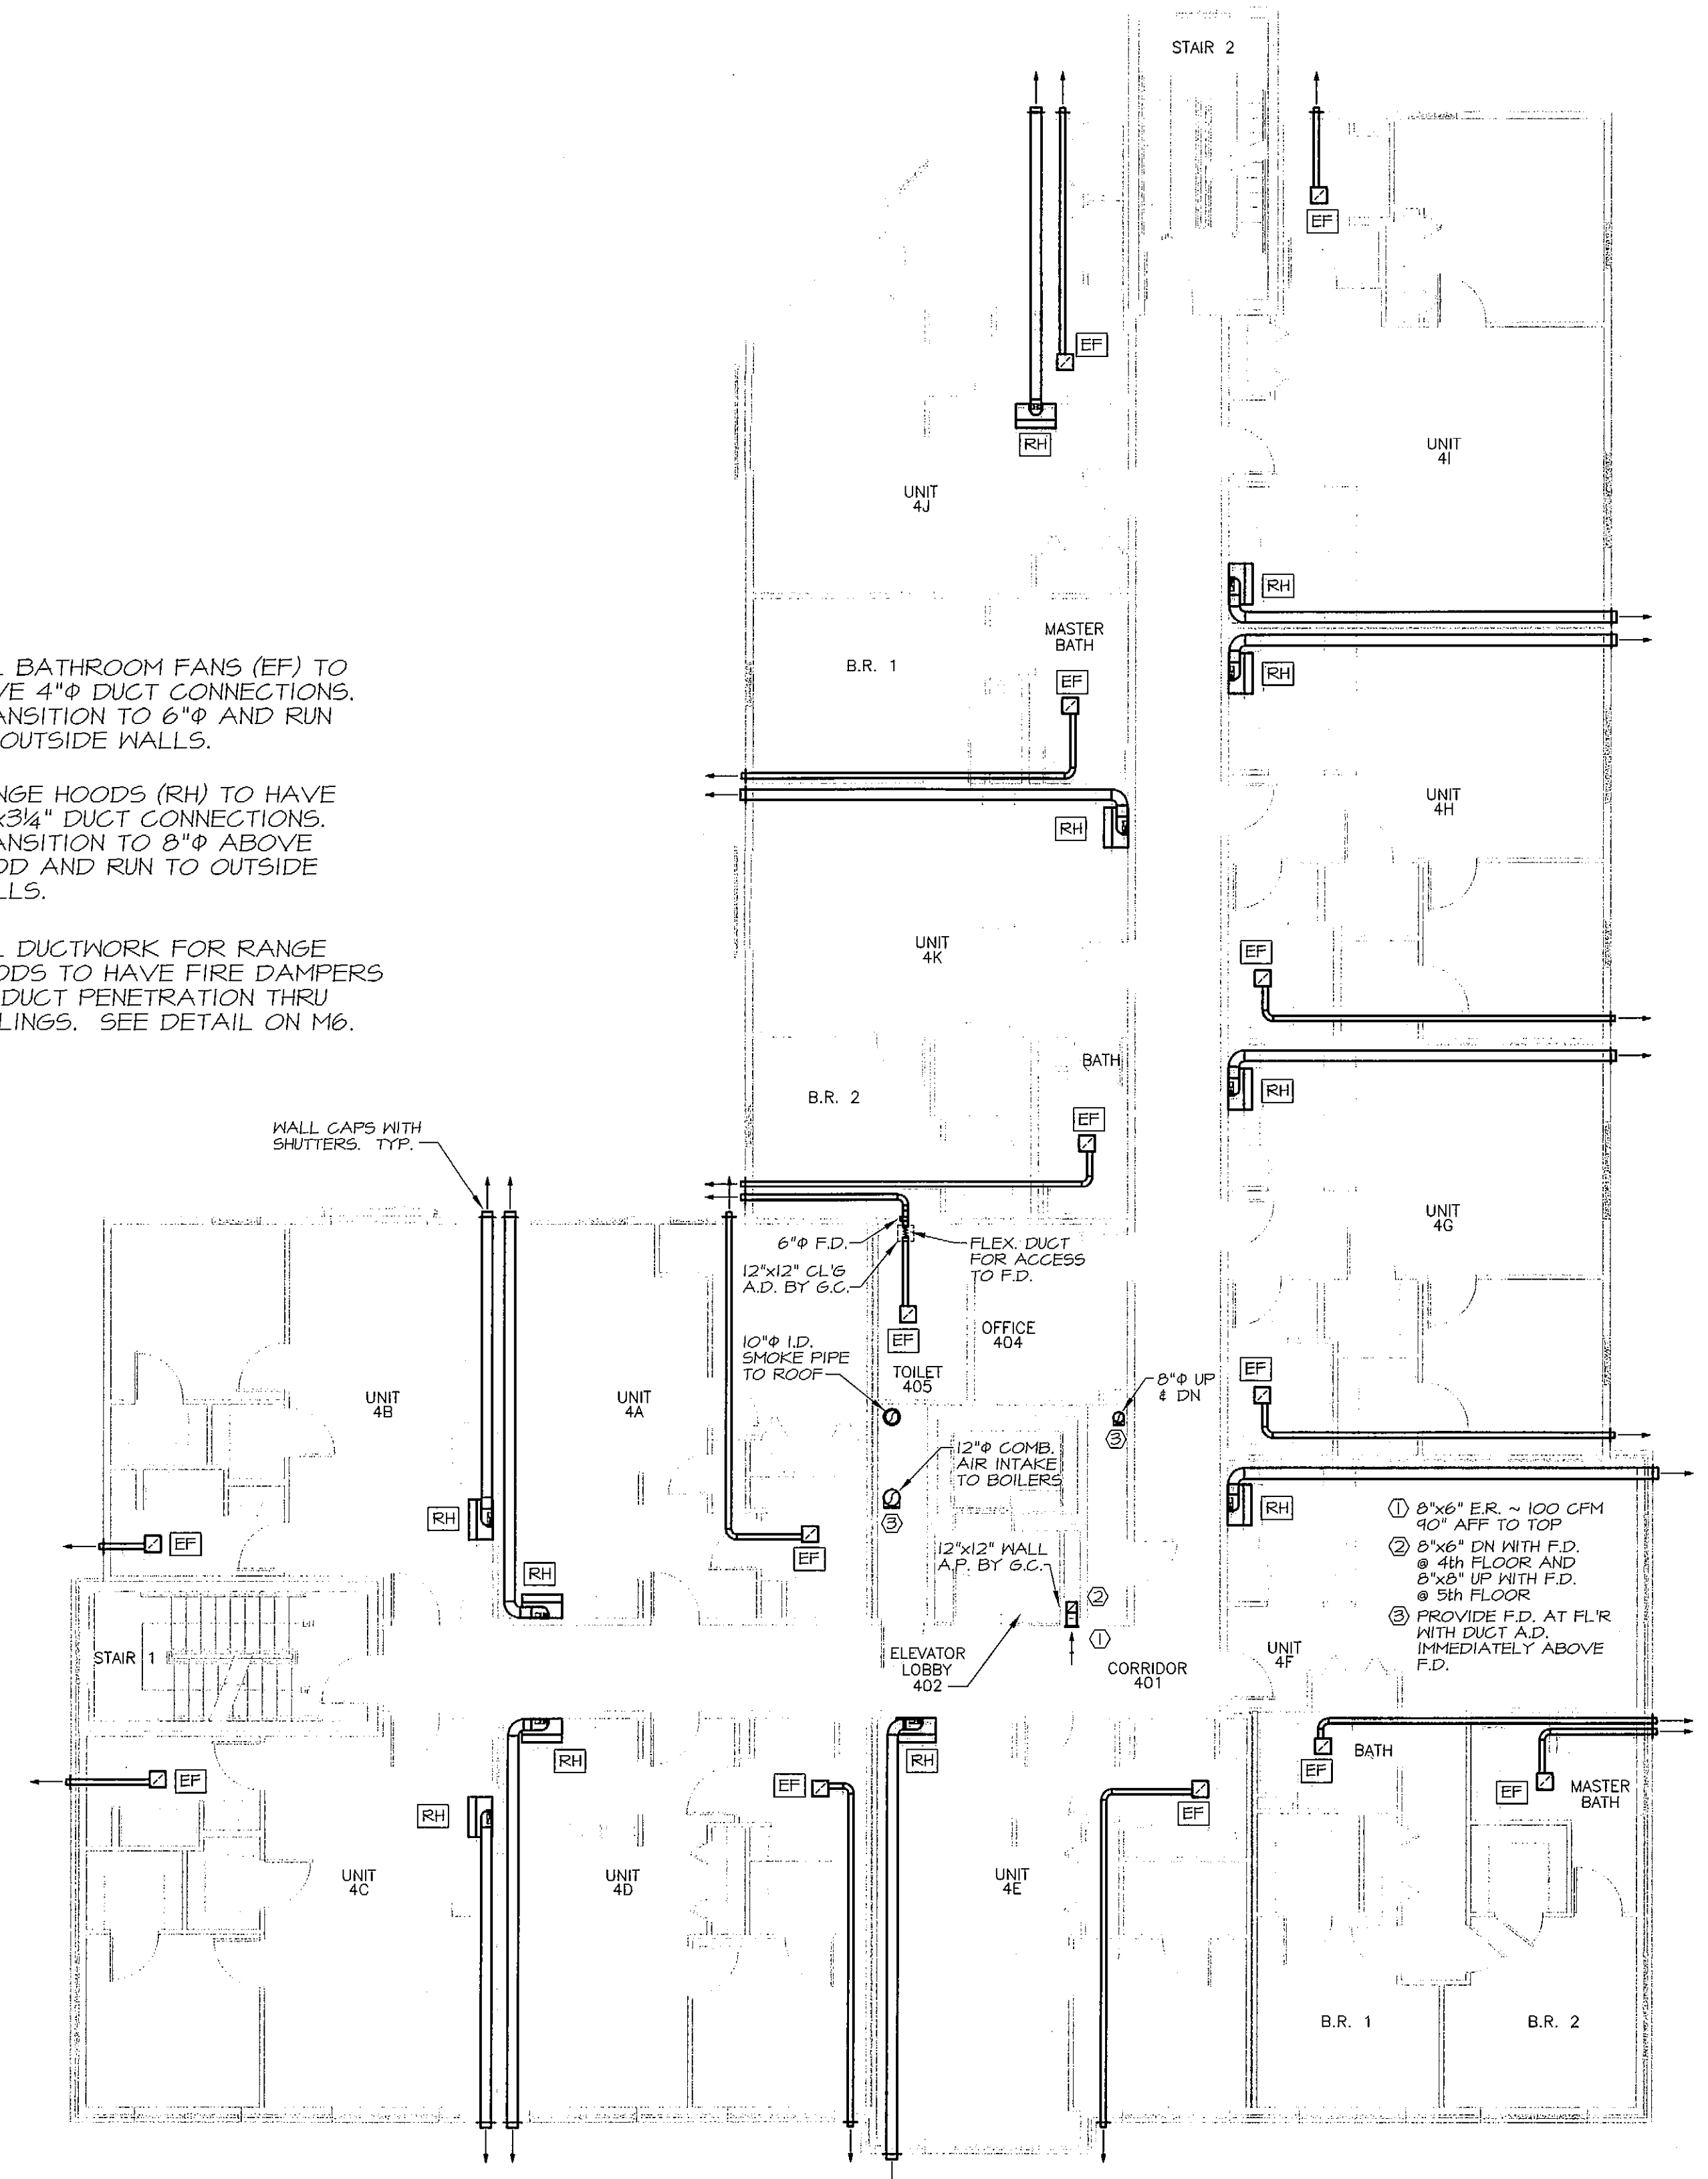

2 MECHANICAL FOURTH FLOOR PLAN
 SCALE: 1/8" = 1'-0"



MECHANICAL SYSTEMS ENGINEERS
 ROYAL RIVER CENTER, UNIT #10
 10 FOREST FALLS DRIVE
 YARMOUTH, MAINE 04096
 VOICE: (207) 846-1441
 FAX: (207) 846-1443
 mechsys@maine.rr.com
 © COPYRIGHT 2008

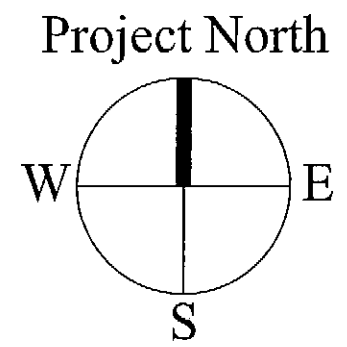

July 25, 2008 - 10:18 am
 \\mechsys1\projects\0812_53_Danforth\Drawings\0812_M104-M106.dwg