


July 28, 2008 - 9:10 am  
 \\Mainfast\Projects\0812\_53 Danforth\Drawings\0812\_53 Danforth\01-P101-P111.dwg

EXISTING BUILDING

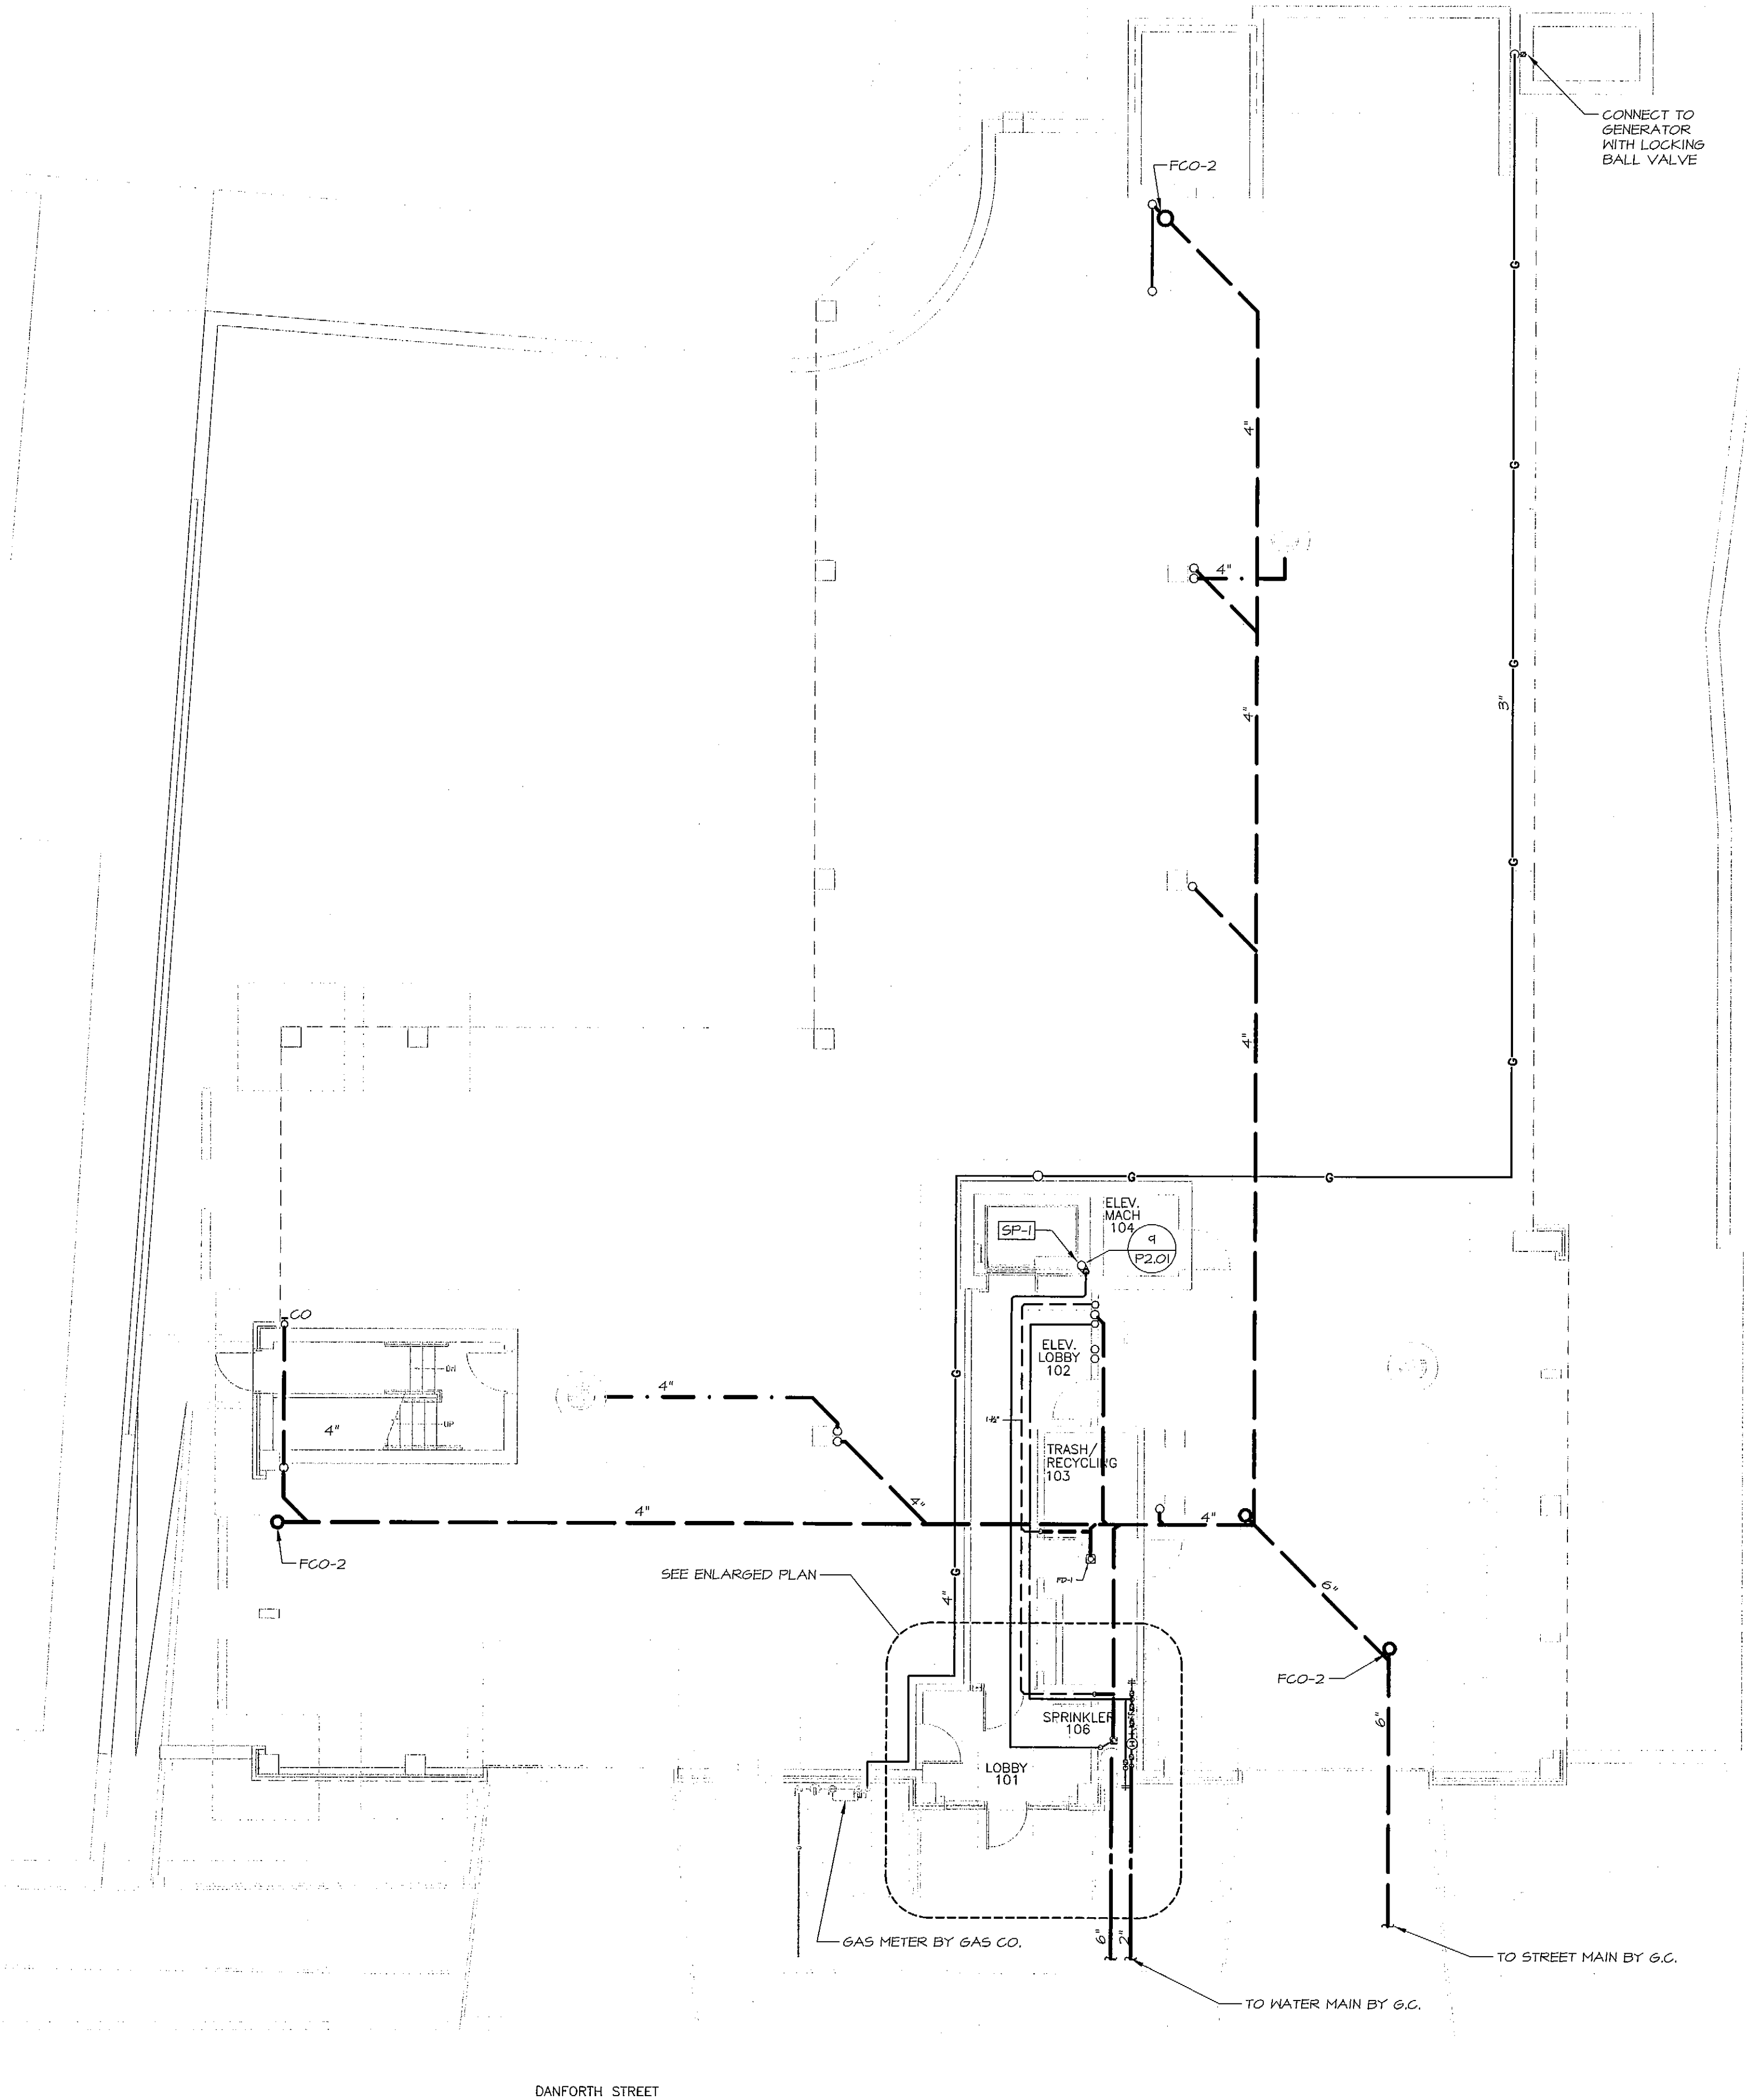


**PLUMBING PLAN - FIRST FLOOR**

SCALE: 1/8" = 1'-0"

EXISTING BUILDING


EXISTING BUILDING

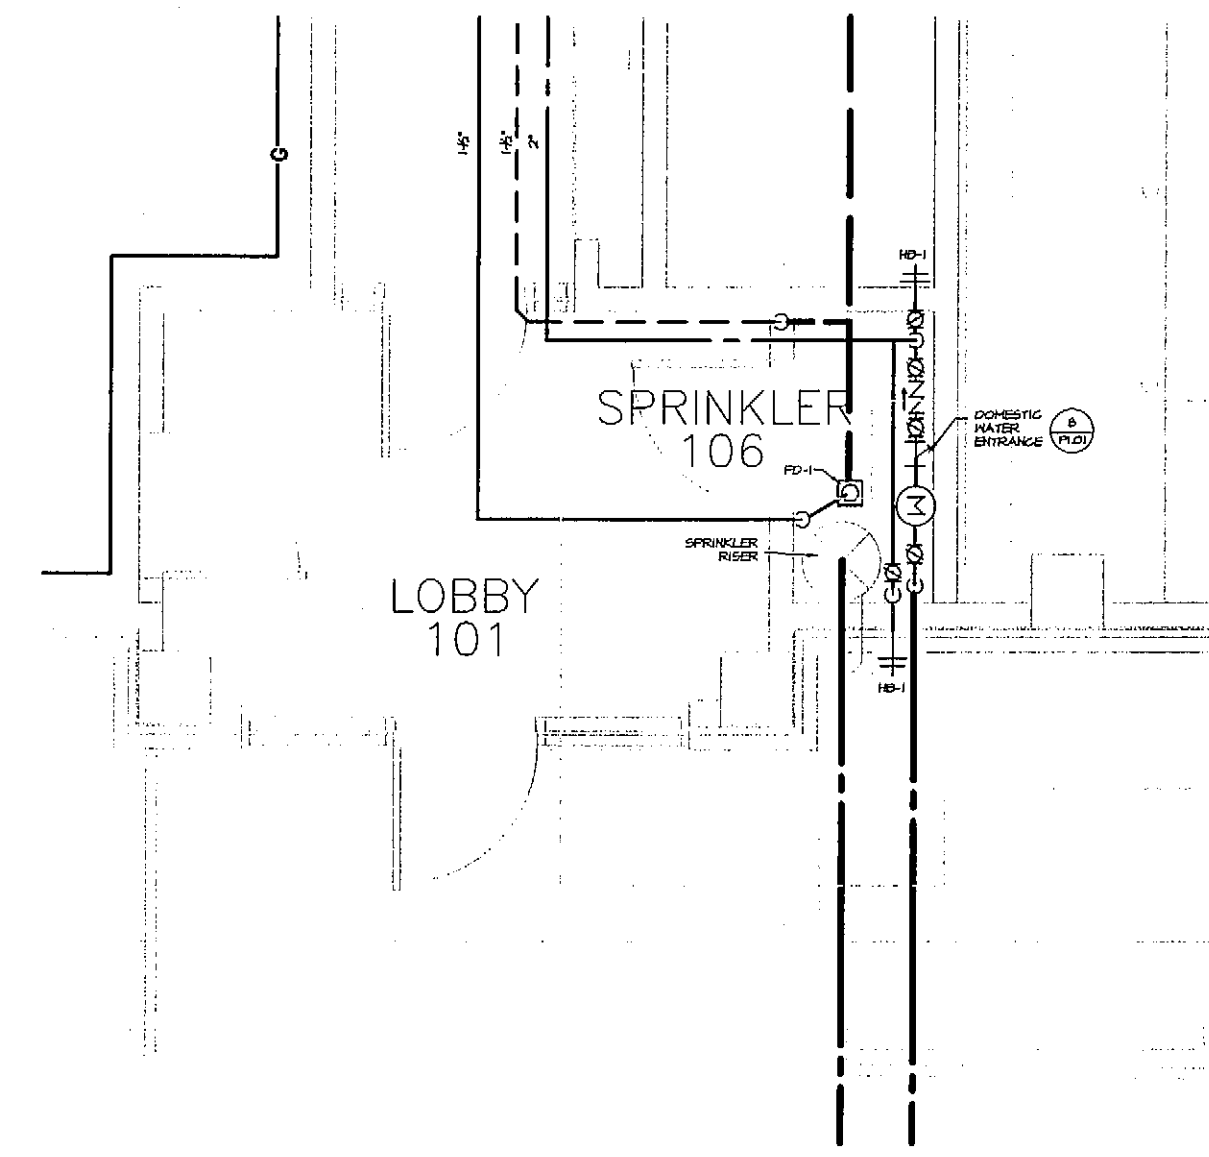



**ENLARGED PLAN**

SCALE: 1/4" = 1'-0"

DANFORTH STREET

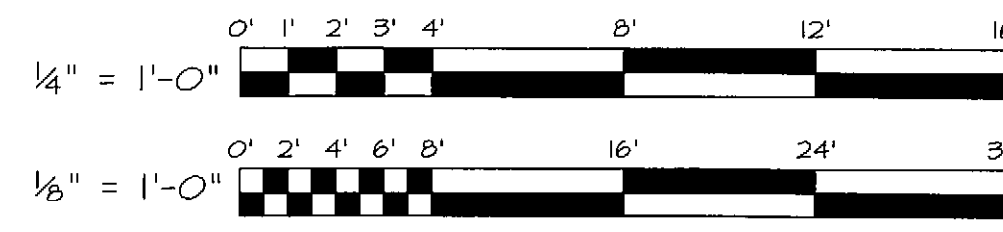

**MECHANICAL SYSTEMS ENGINEERS**  
 ROYAL RIVER CENTER, UNIT #10  
 10 FOREST FALLS DRIVE  
 YARMOUTH, MAINE 04096  
 VOICE: (207) 846-1441  
 FAX: (207) 846-1443  
 mechsys@maine.rr.com  
 © COPYRIGHT 2008

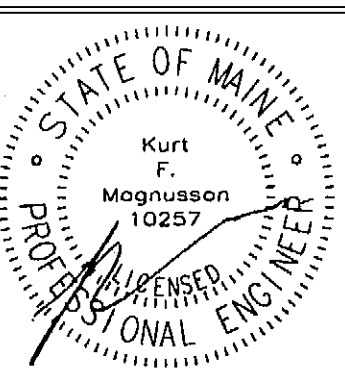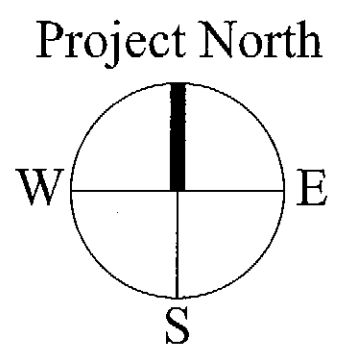

OWNER:  
 53 DANFORTH STREET, LP  
 C/O THE SZANTON COMPANY  
 ONE CITY CENTER - 4TH FLOOR  
 PORTLAND, ME 04101

**ARCHETYPE, P.A. ARCHITECTS**  
 48 Union Wharf Portland, Maine 04101  
 (207) 772-6022 Fax (207) 772-4056

**53 DANFORTH**  
 53 DANFORTH STREET  
 PORTLAND, MAINE

Date:	28 MAY 2008	Scale:	AS NOTED
Revisions:	28 May 2008 - 50% MSHA Submittal		
	1 July 2008 - 90% MSHA Submittal		
	15 July 2008 - Pricing Set		
	25 July 2008 - 100% MSHA Submittal		

PROJECT SET  
**PLUMBING PLAN**  
**FIRST FLOOR**

**P1.01**  
 M.S.E. PROJECT 0812