



July 26, 2008 - 9:09 am
\\server\projects\0812 53 Danforth\Drawings\0812 P101-P111.dwg

MATCH LINE A


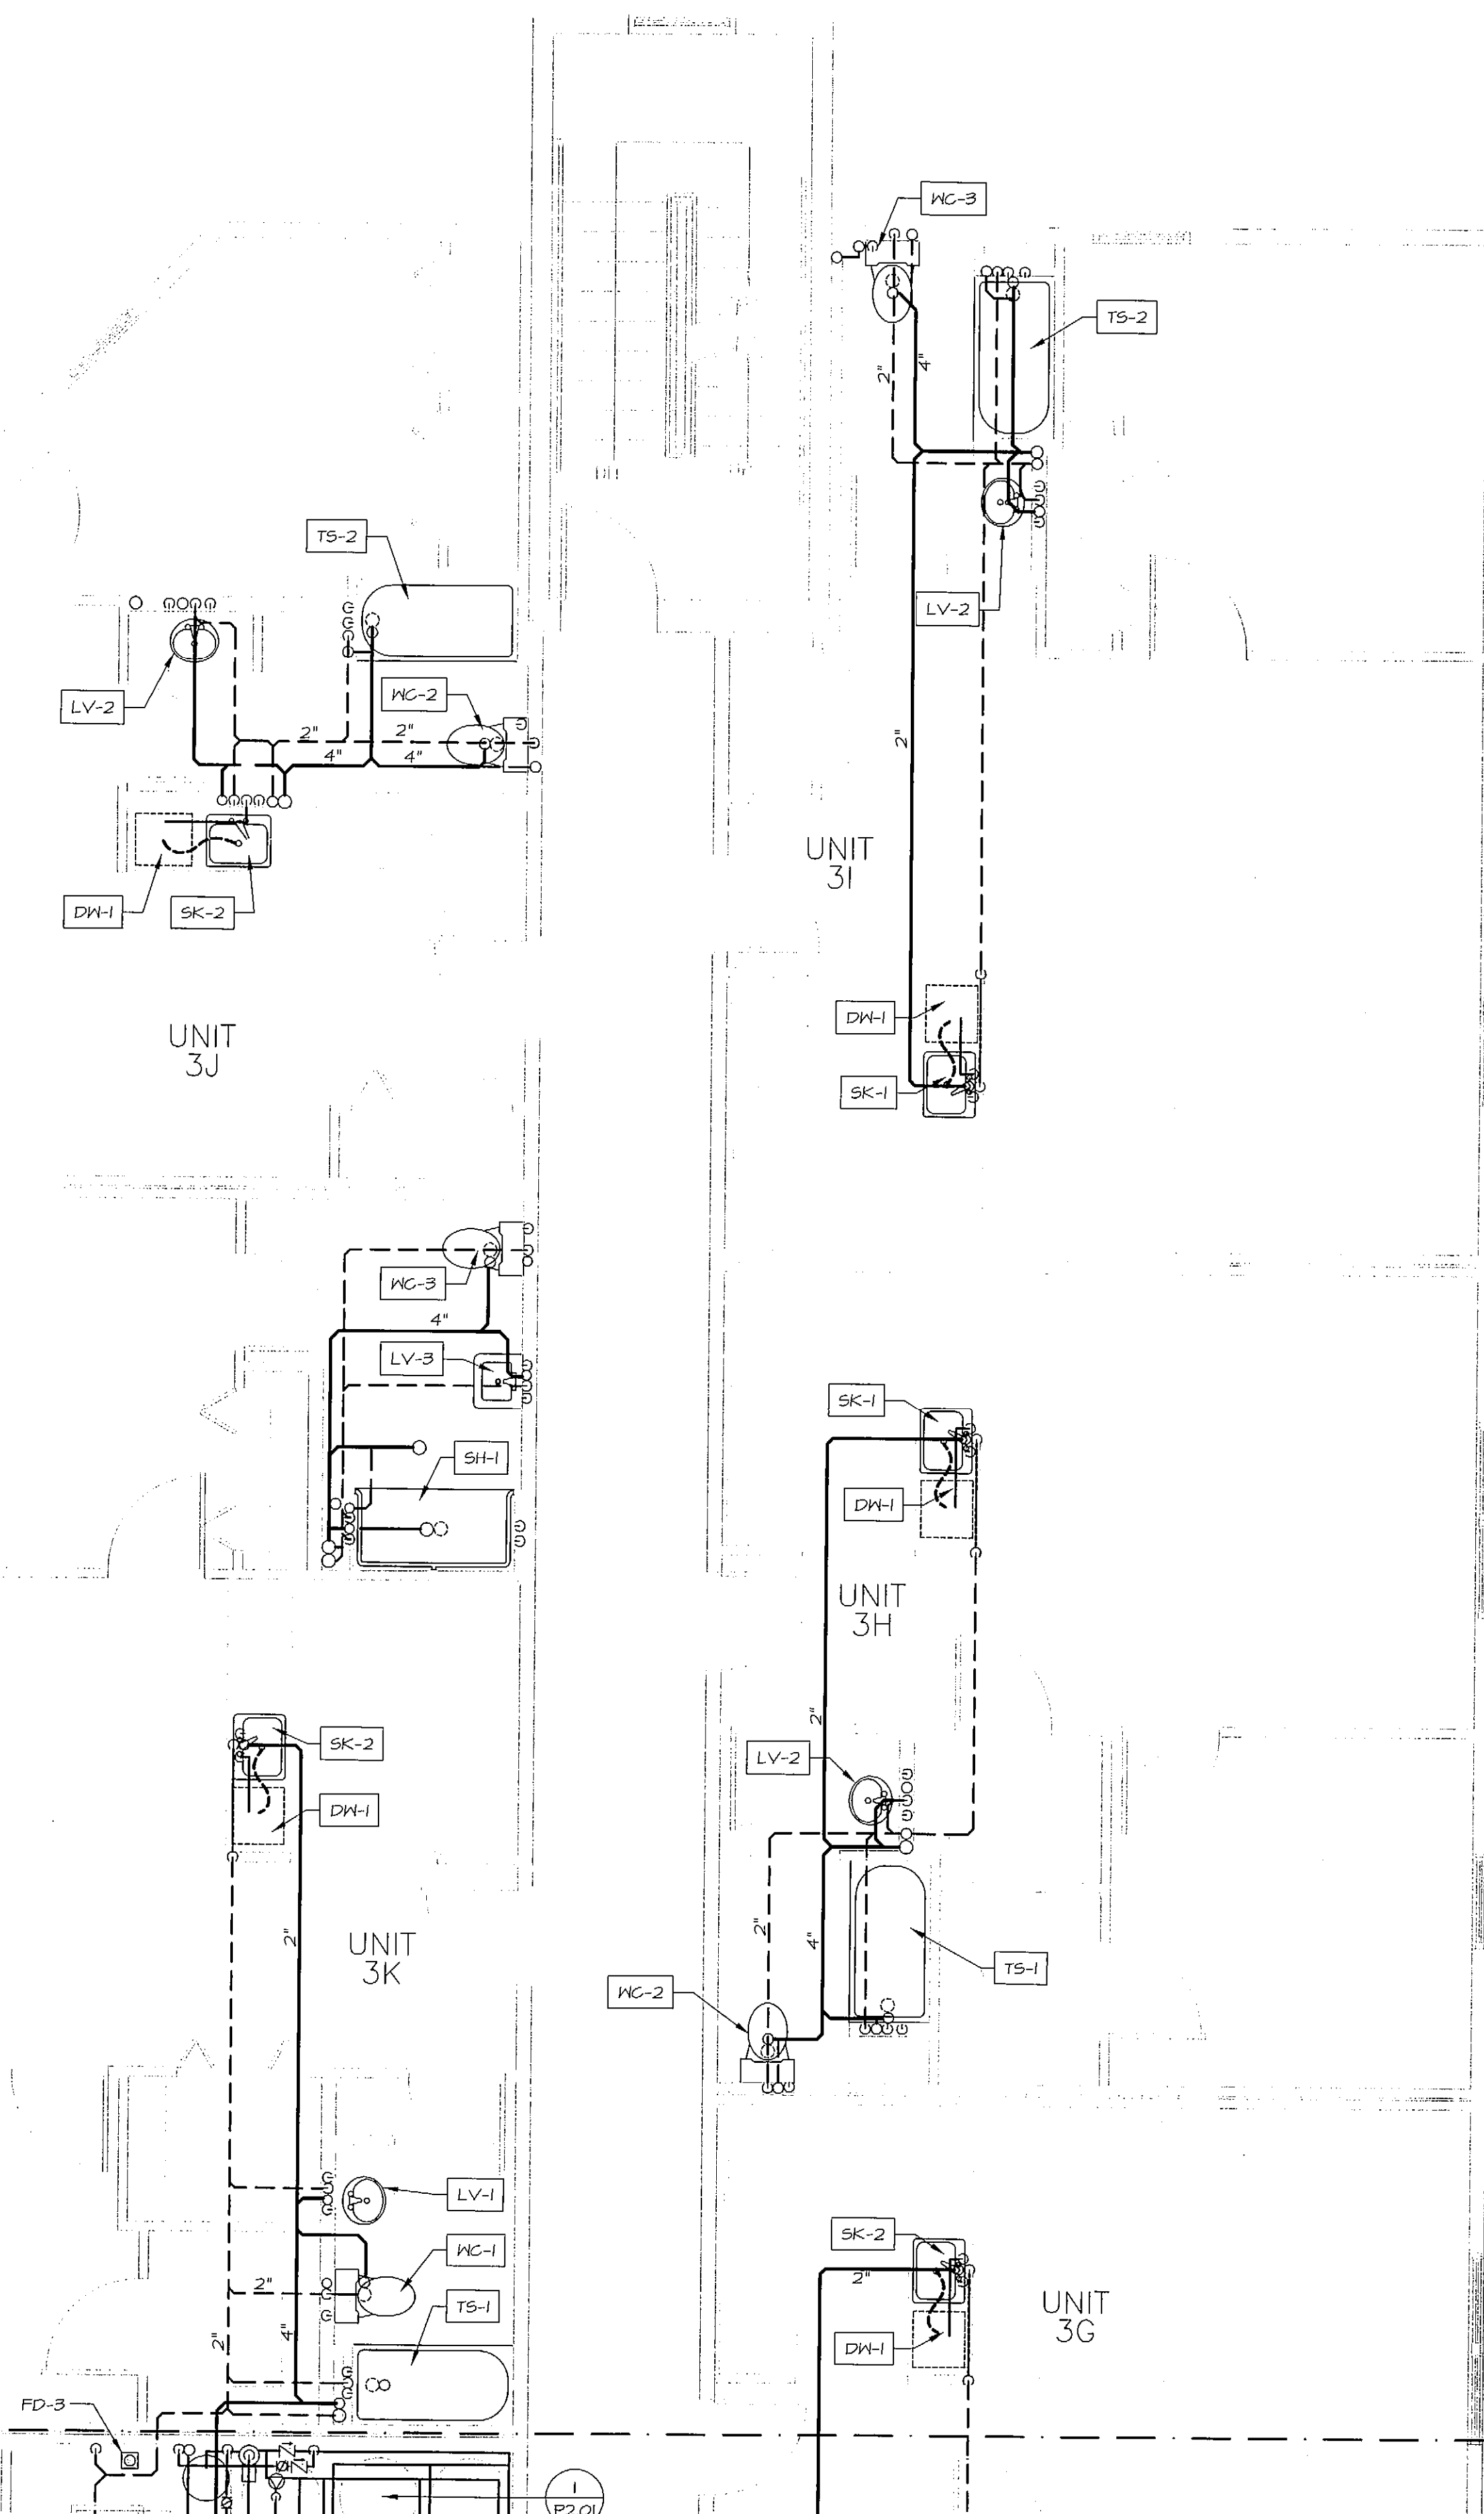


MATCH LINE A

 PLUMBING PLAN - THIRD FLOOR
SCALE: 1/4" = 1'-0"



MECHANICAL SYSTEMS ENGINEERS
 ROYAL RIVER CENTER, UNIT #10
 10 FOREST FALLS DRIVE
 YARMOUTH, MAINE 04096
 VOICE: (207) 846-1441
 FAX: (207) 846-1443
 mechsys@maine.rr.com
 © CSP/RS&E 2008

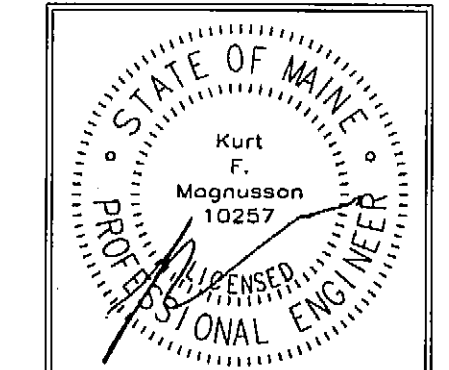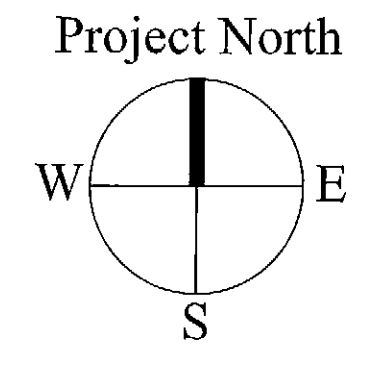

OWNER:
 53 DANFORTH STREET, LP
 C/O THE SZANTON COMPANY
 ONE CITY CENTER - 4TH FLOOR
 PORTLAND, ME 04101

ARCHETYPE, P.A.
 ARCHITECTS
 48 Union Wharf Portland, Maine 04101
 (207) 772-6022 Fax (207) 772-4056

53 DANFORTH
 53 DANFORTH STREET
 PORTLAND, MAINE

Project:

Date:	Scale:
28 MAY 2008	AS NOTED
Revisions:	
28 May 2008 - 50% MSHA Submittal	
1 July 2008 - 90% MSHA Submittal	
15 July 2008 - Pricing Set	
25 July 2008 - 100% MSHA Submittal	

PROGRESS SET
 PLUMBING PLAN
 THIRD FLOOR

P1.05
MS.E. PROJECT 0812