

OWNER:  
 53 DANFORTH STREET, LP  
 C/O THE SZANTON COMPANY  
 ONE CITY CENTER - 4TH FLOOR  
 PORTLAND, ME 04101

ARCHETYPE, P.A.  
 ARCHITECTS  
 48 Union Wharf Portland, Maine 04101  
 (207) 775-6022 Fax (207) 775-4056

53 DANFORTH  
 53 DANFORTH STREET  
 PORTLAND, MAINE

Project:

Date:	28 MAY 2008	Scale:	AS NOTED
Revisions:	28 May 2008 - 50% MSHA Submittal		
	1 July 2008 - 90% MSHA Submittal		
	15 July 2008 - Pricing Set		
	25 July 2008 - 100% MSHA Submittal		


PROGRESS SET  
 PLUMBING PLAN  
 THIRD FLOOR

P1.06

MSE PROJECT 0812


MATCH LINE A

MATCH LINE A

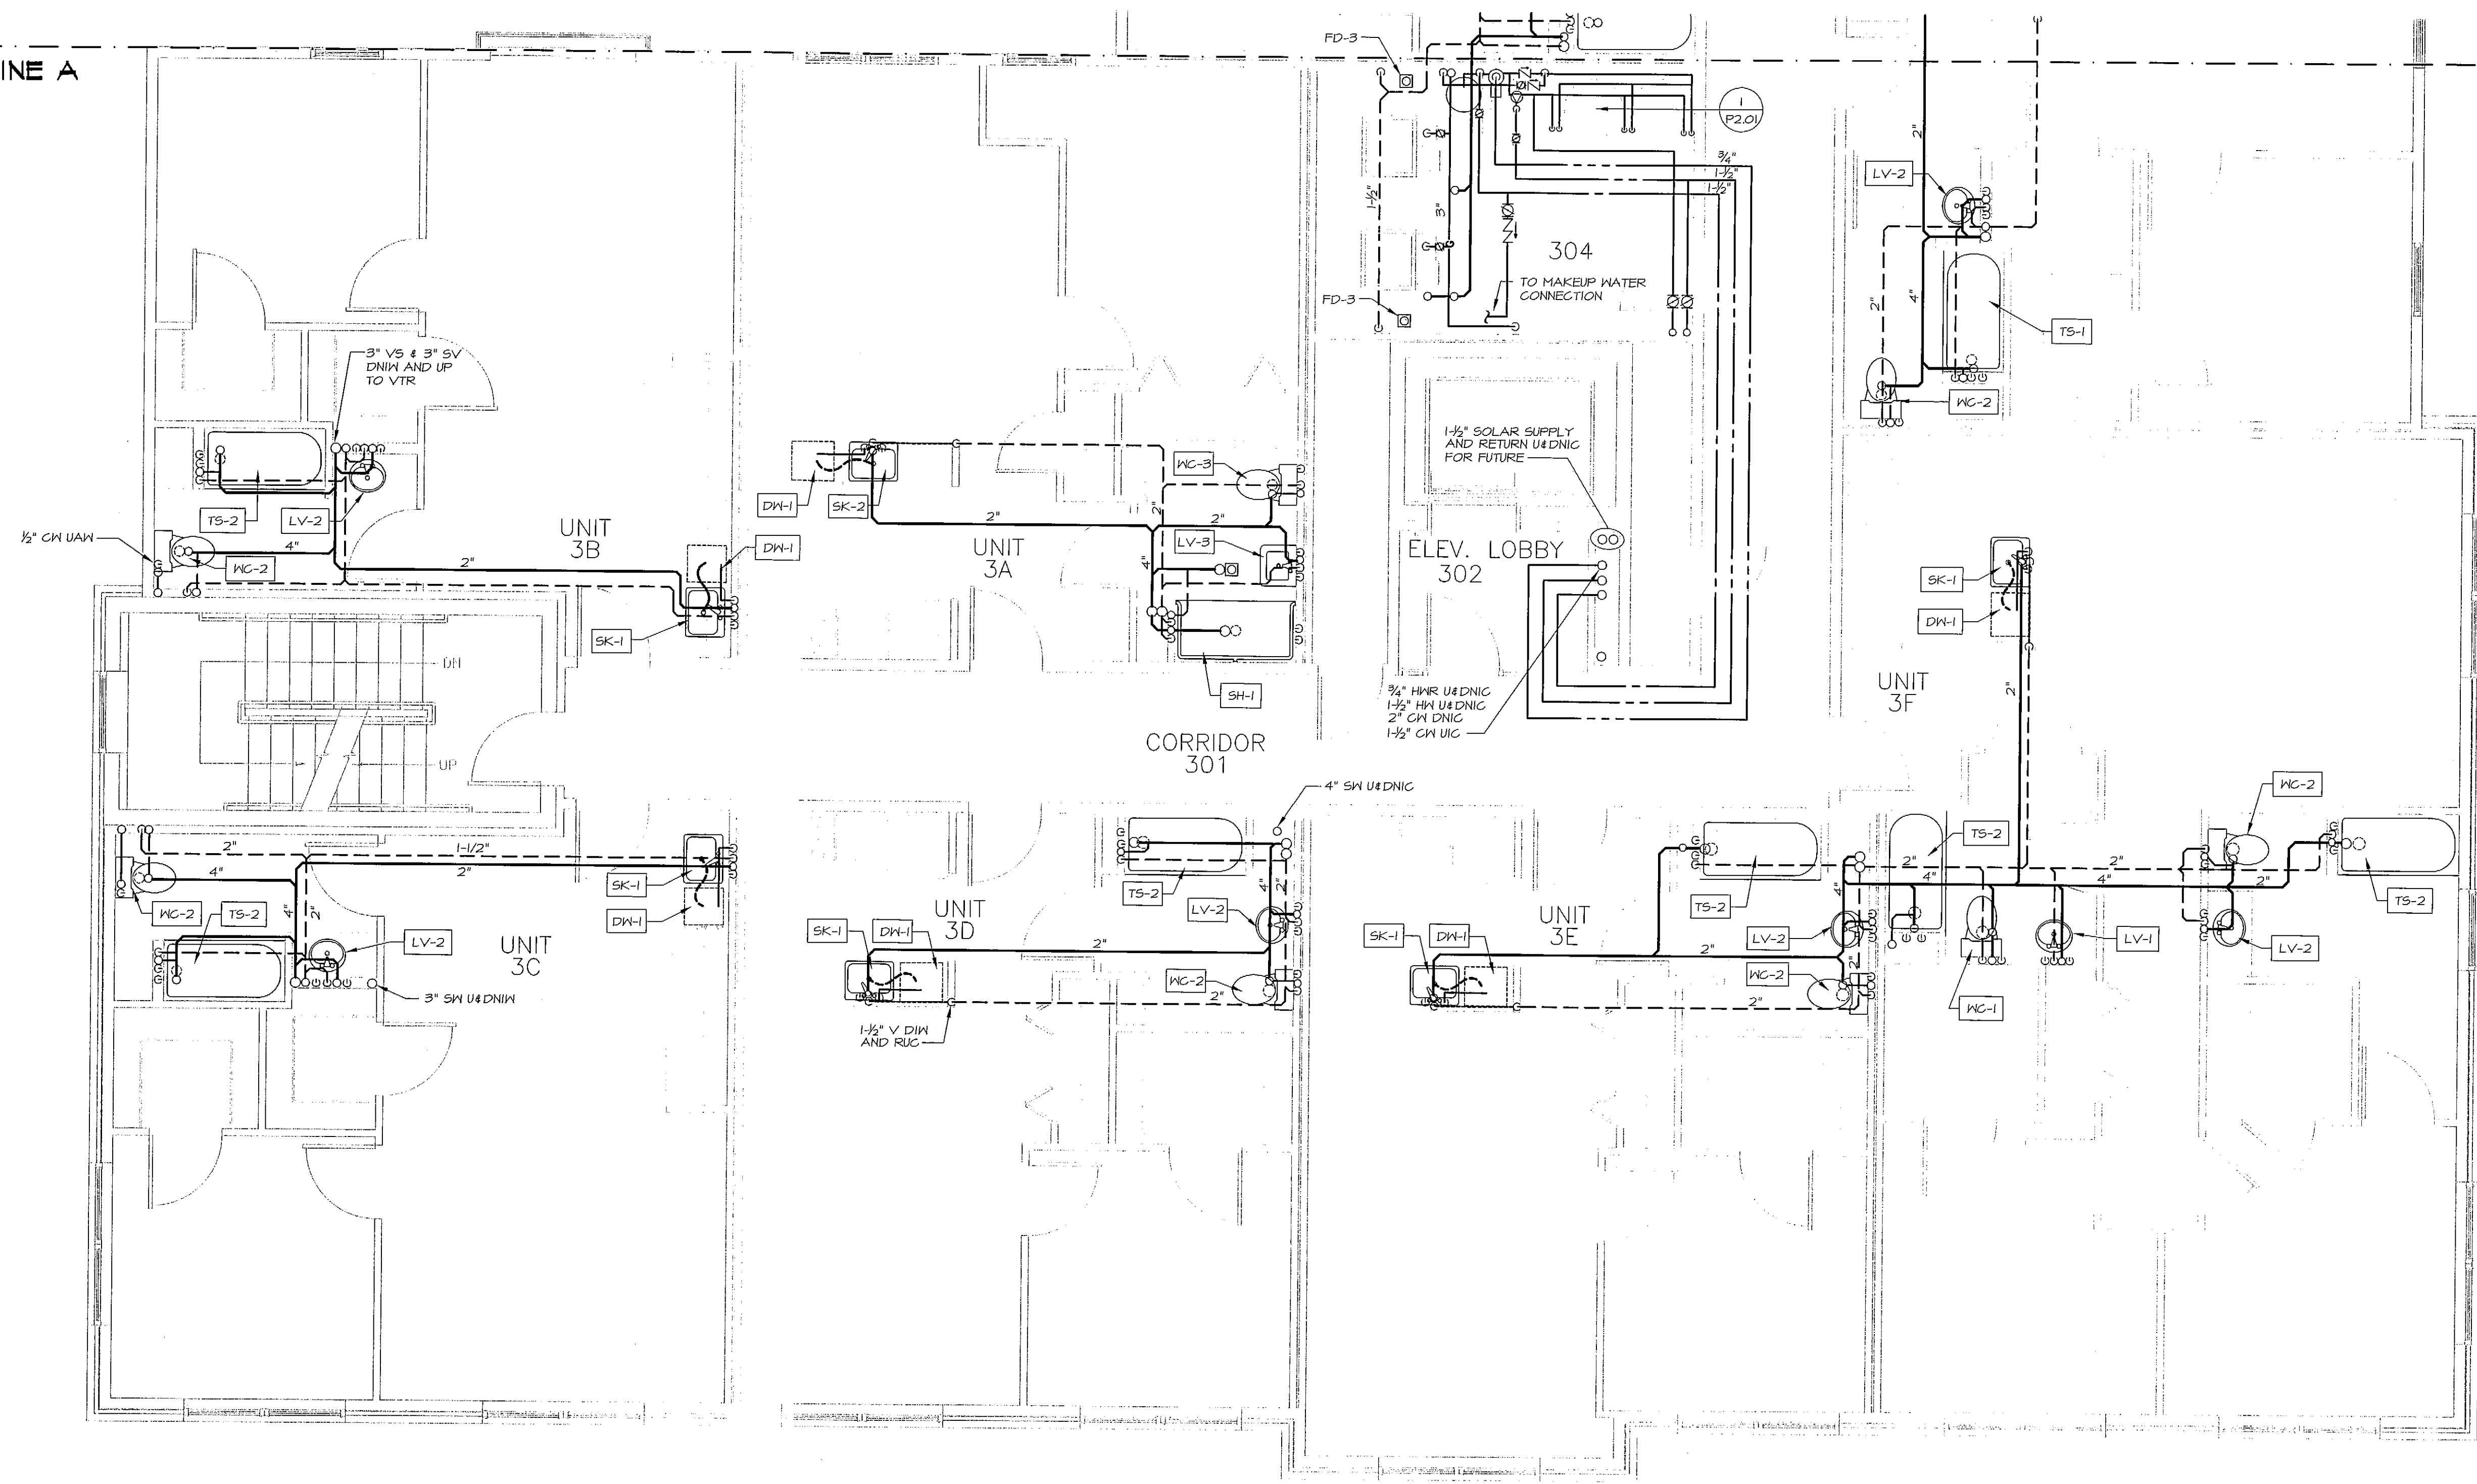

**PLUMBING PLAN - THIRD FLOOR**

 SCALE: 1/4" = 1'-0"



MECHANICAL SYSTEMS ENGINEERS  
 ROYAL RIVER CENTER, UNIT #10  
 10 FOREST FALLS DRIVE  
 YARMOUTH, MAINE 04096  
 VOICE: (207) 846-1441  
 FAX: (207) 846-1443  
 mechsys@maine.rr.com  
 © COPYRIGHT 2008

Project North  
 W E  
 S

July 28, 2008 - 8:09 am  
 \\server\projects\0812 53 Danforth\Drawings\0812 P101-P111.dwg