

OWNER:
 53 DANFORTH STREET, LP
 C/O THE SZANTON COMPANY
 ONE CITY CENTER - 4TH FLOOR
 PORTLAND, ME 04101

ARCHETYPE, P.A.
 ARCHITECTS
 48 Union Wharf Portland, Maine 04101
 (207) 772-6022 Fax (207) 772-4056

Project:
 53 DANFORTH
 53 DANFORTH STREET
 PORTLAND, MAINE

Date: 28 MAY 2008
 Scale: AS NOTED
 Revisions:
 28 May 2008 - 50% MSHA Submittal
 1 July 2008 - 90% MSHA Submittal
 15 July 2008 - Pricing Set
 25 July 2008 - 100% MSHA Submittal


PROGRESS SET
 PLUMBING PLAN
 FOURTH FLOOR

P1.08


M.S.E. PROJECT 0812

MATCH LINE A


MATCH LINE A

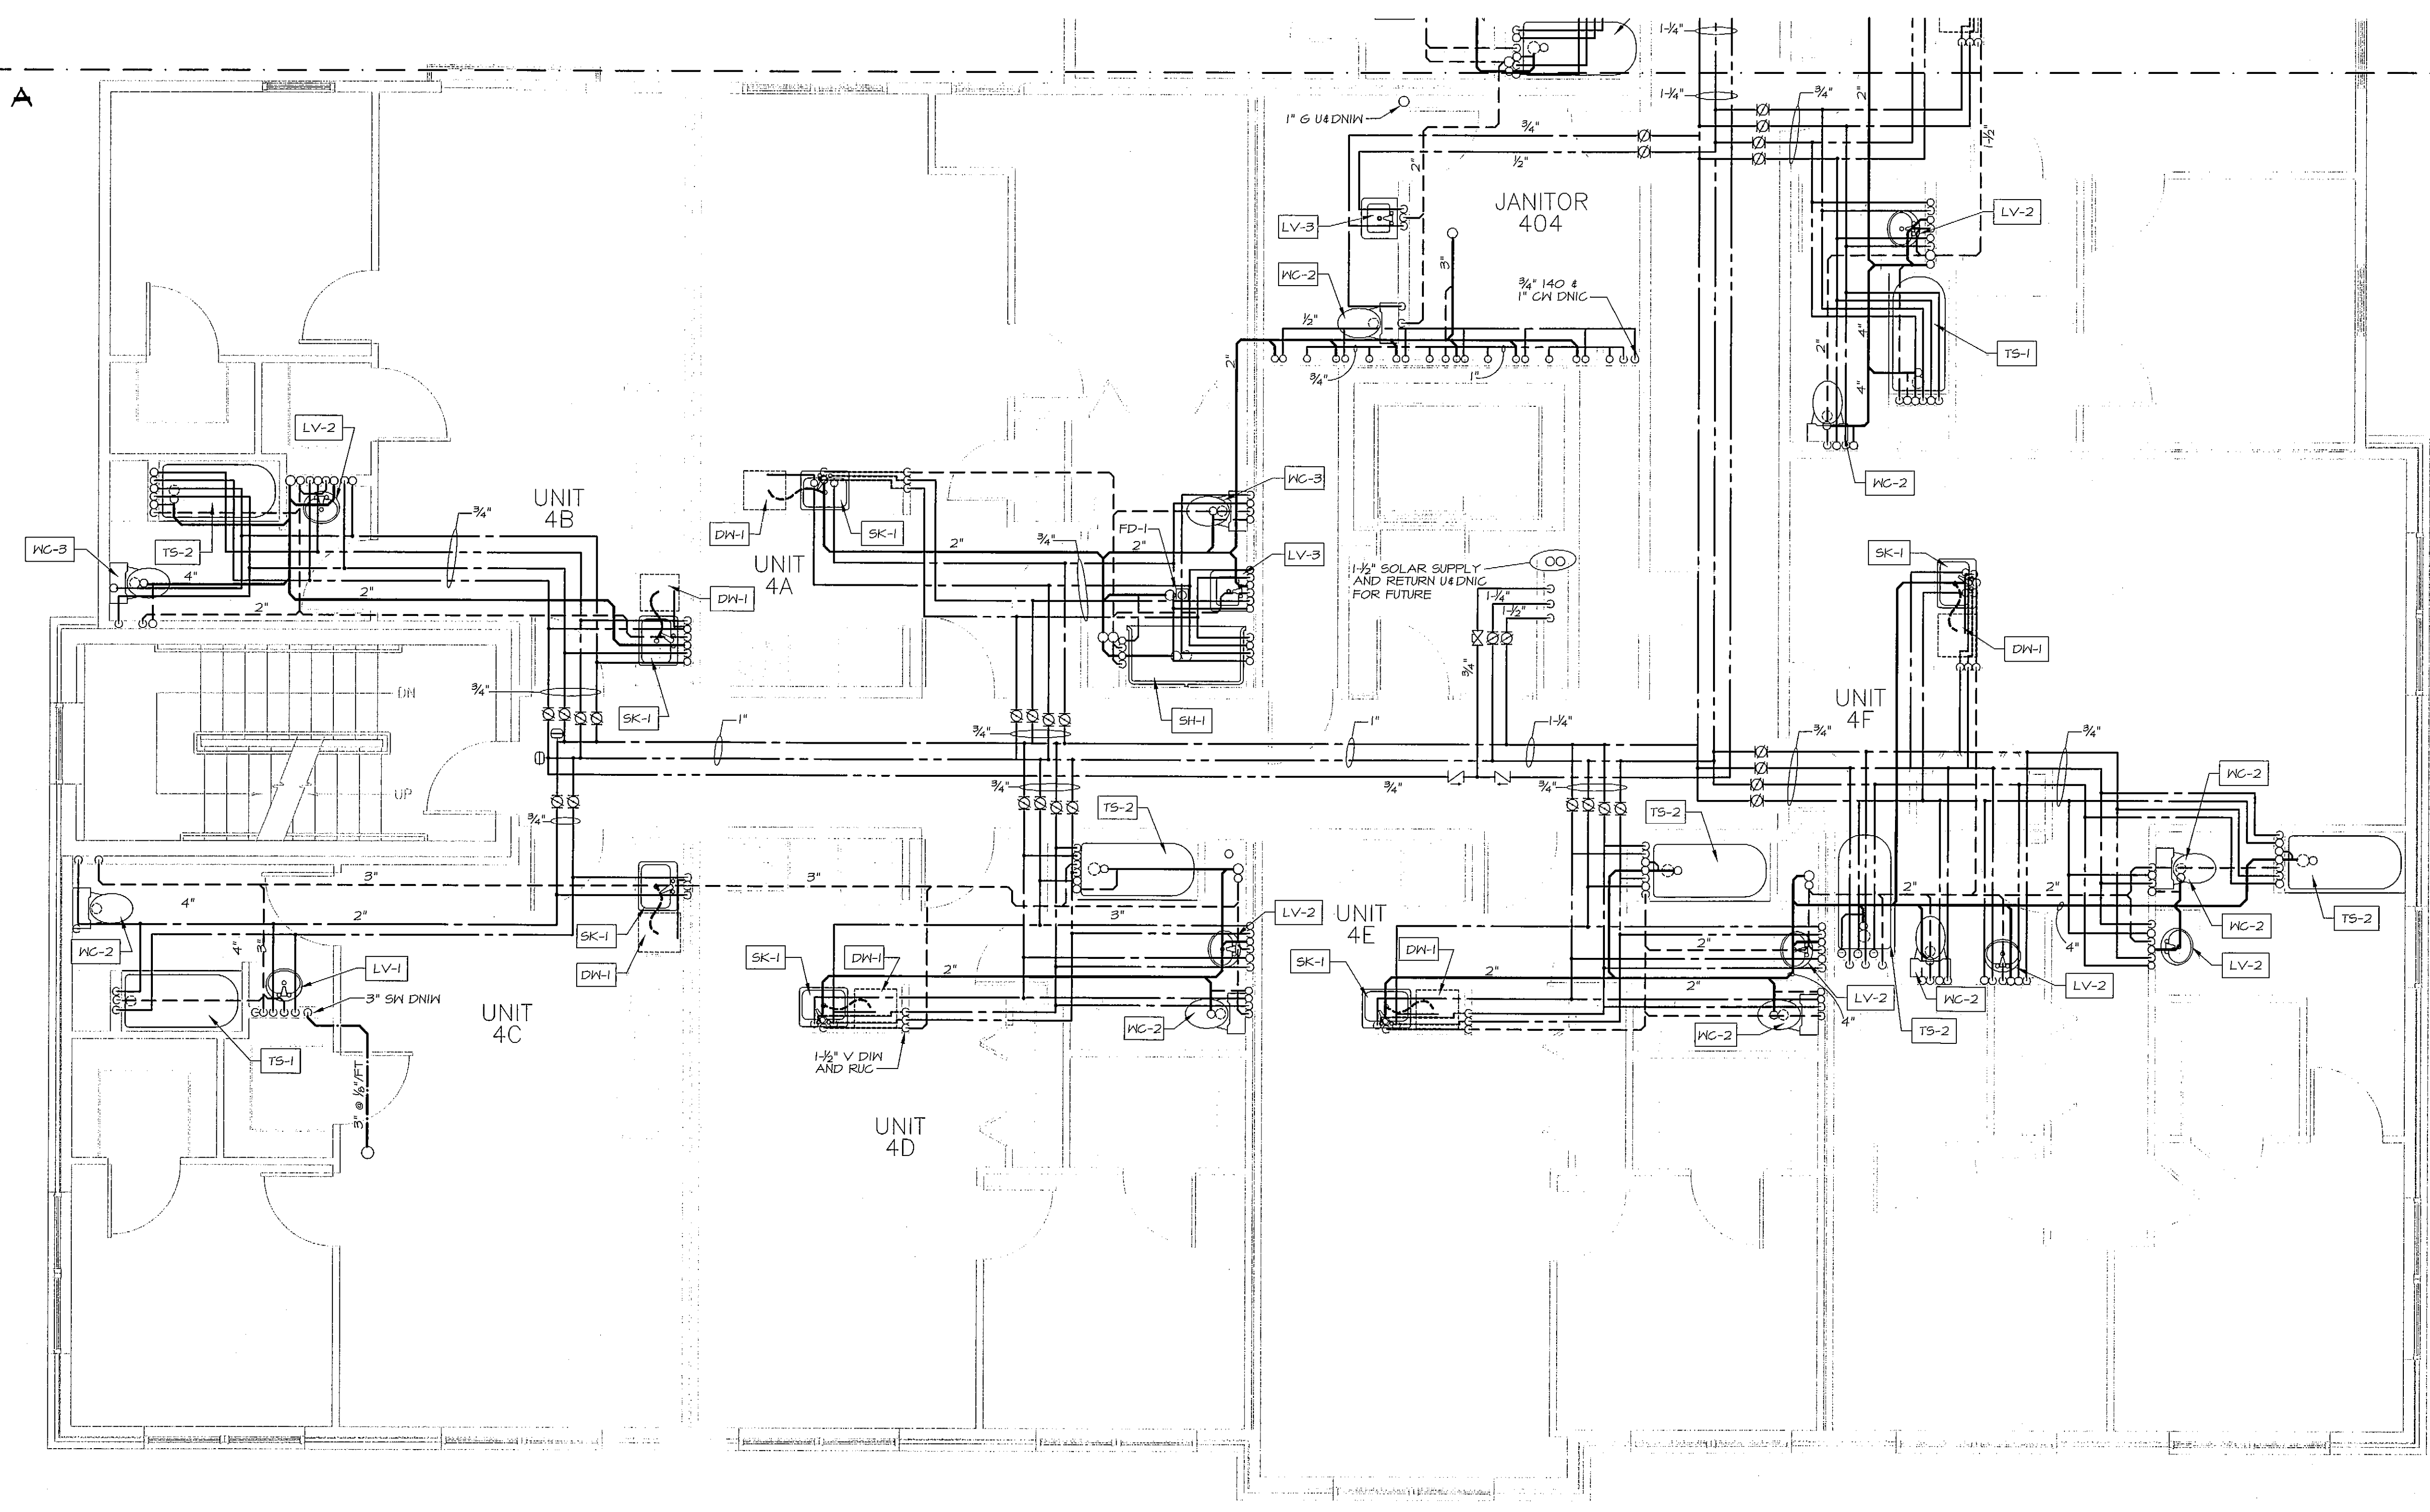

 PLUMBING PLAN - FOURTH FLOOR
 SCALE: 1/4" = 1'-0"



MECHANICAL SYSTEMS ENGINEERS
 ROYAL RIVER CENTER, UNIT #10
 10 FOREST FALLS DRIVE
 YARMOUTH, MAINE 04096
 VOICE: (207) 846-1441
 FAX: (207) 846-1443
 mechsys@maine.rr.com
 © COPYRIGHT 2008

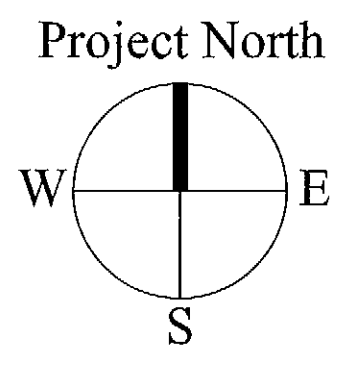

July 28, 2008 - 9:08 am
 \\mechsys\projects\0812_53 Danforth\Drawings\0812_P101-P111.dwg