

OWNER:  
 53 DANFORTH STREET, LP  
 C/O THE SZANTON COMPANY  
 ONE CITY CENTER - 4TH FLOOR  
 PORTLAND, ME 04101

ARCHETYPE, P.A.  
 ARCHITECTS  
 48 Union Wharf Portland, Maine 04101  
 (207) 772-6022 Fax (207) 772-4056

53 DANFORTH  
 53 DANFORTH STREET  
 PORTLAND, MAINE

Project:


|            |                                    |        |          |
|------------|------------------------------------|--------|----------|
| Date:      | 28 MAY 2008                        | Scale: | AS NOTED |
| Revisions: | 28 May 2008 - 50% MSHA Submittal   |        |          |
|            | 1 July 2008 - 90% MSHA Submittal   |        |          |
|            | 15 July 2008 - Pricing Set         |        |          |
|            | 25 July 2008 - 100% MSHA Submittal |        |          |

PROGRESS SET  
 PLUMBING PLAN  
 FIFTH FLOOR

P1.10  
M.S.E. PROJECT 0812

MATCH LINE A

MATCH LINE A

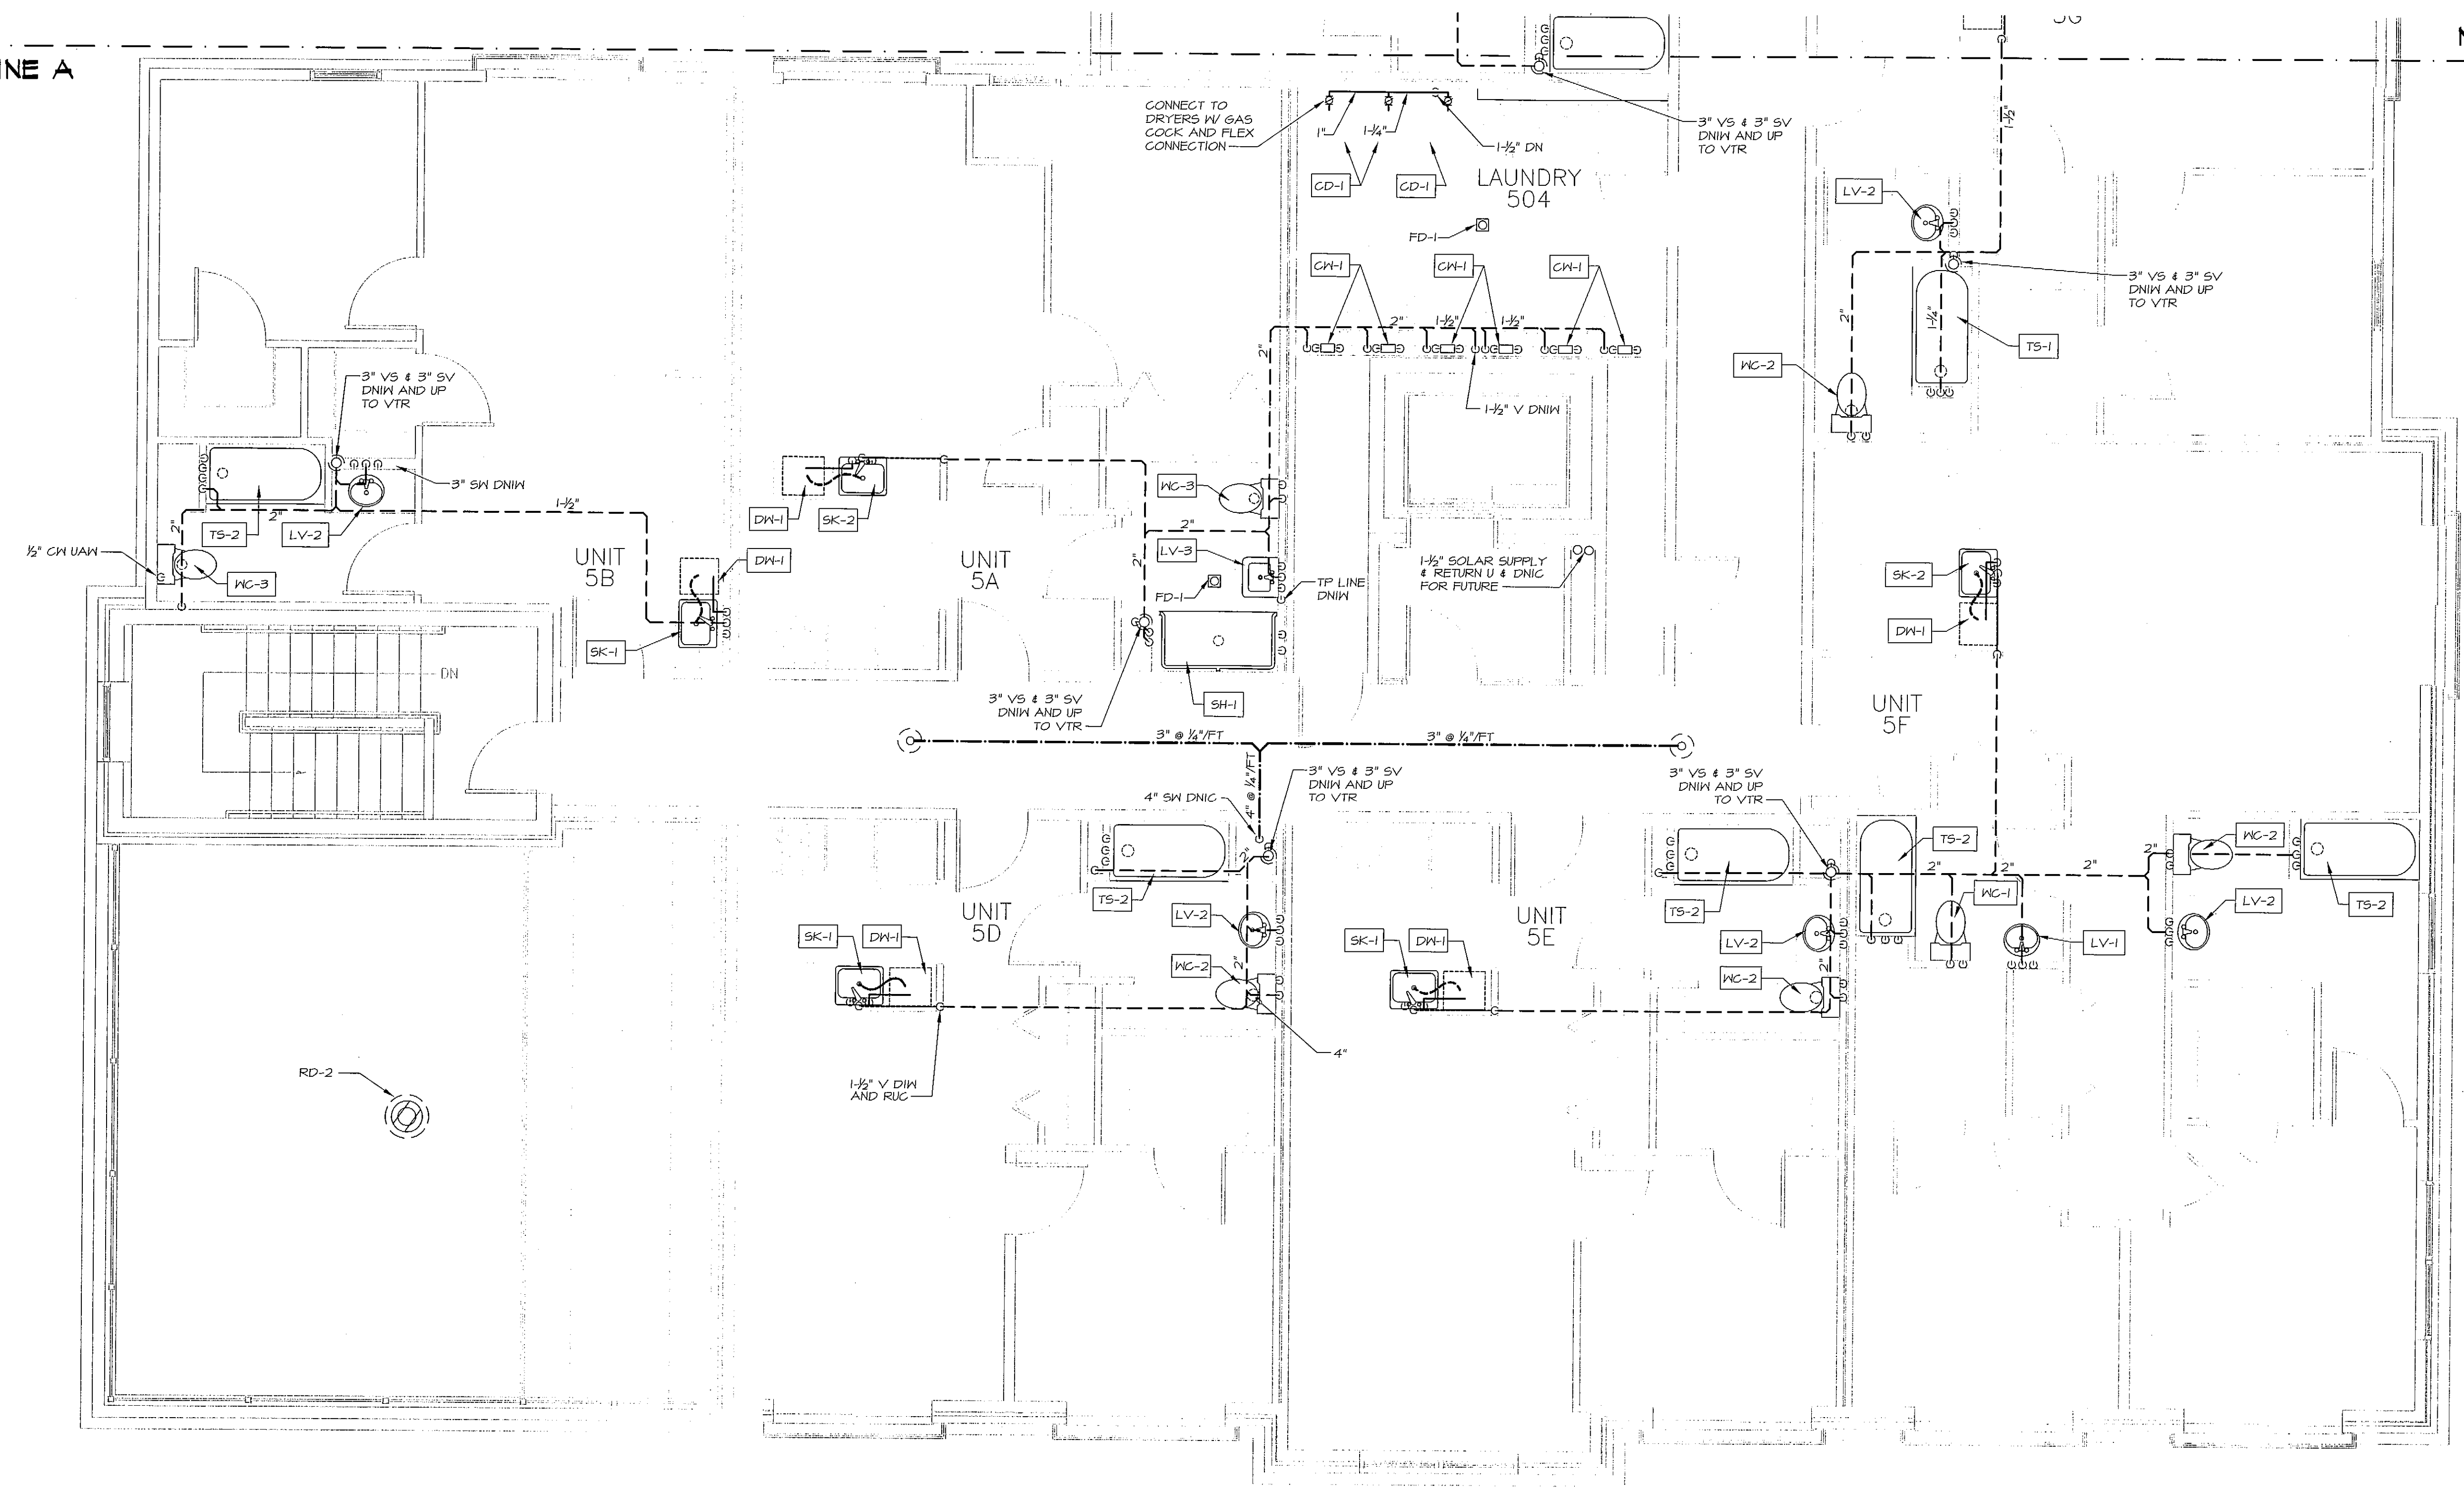

**PLUMBING PLAN - FIFTH FLOOR**  
 SCALE: 1/4" = 1'-0"

July 28, 2008 - 9:07 am  
 \\server1\projects\0812 53 Danforth\Drawings\0812 P101-P111.dwg



**MECHANICAL SYSTEMS ENGINEERS**  
 ROYAL RIVER CENTER, UNIT #10  
 10 FOREST FALLS DRIVE  
 YARMOUTH, MAINE 04098  
 VOICE: (207) 846-1441  
 FAX: (207) 846-1443  
 mecheyst@maine.rr.com  
 © COPYRIGHT 2008

